


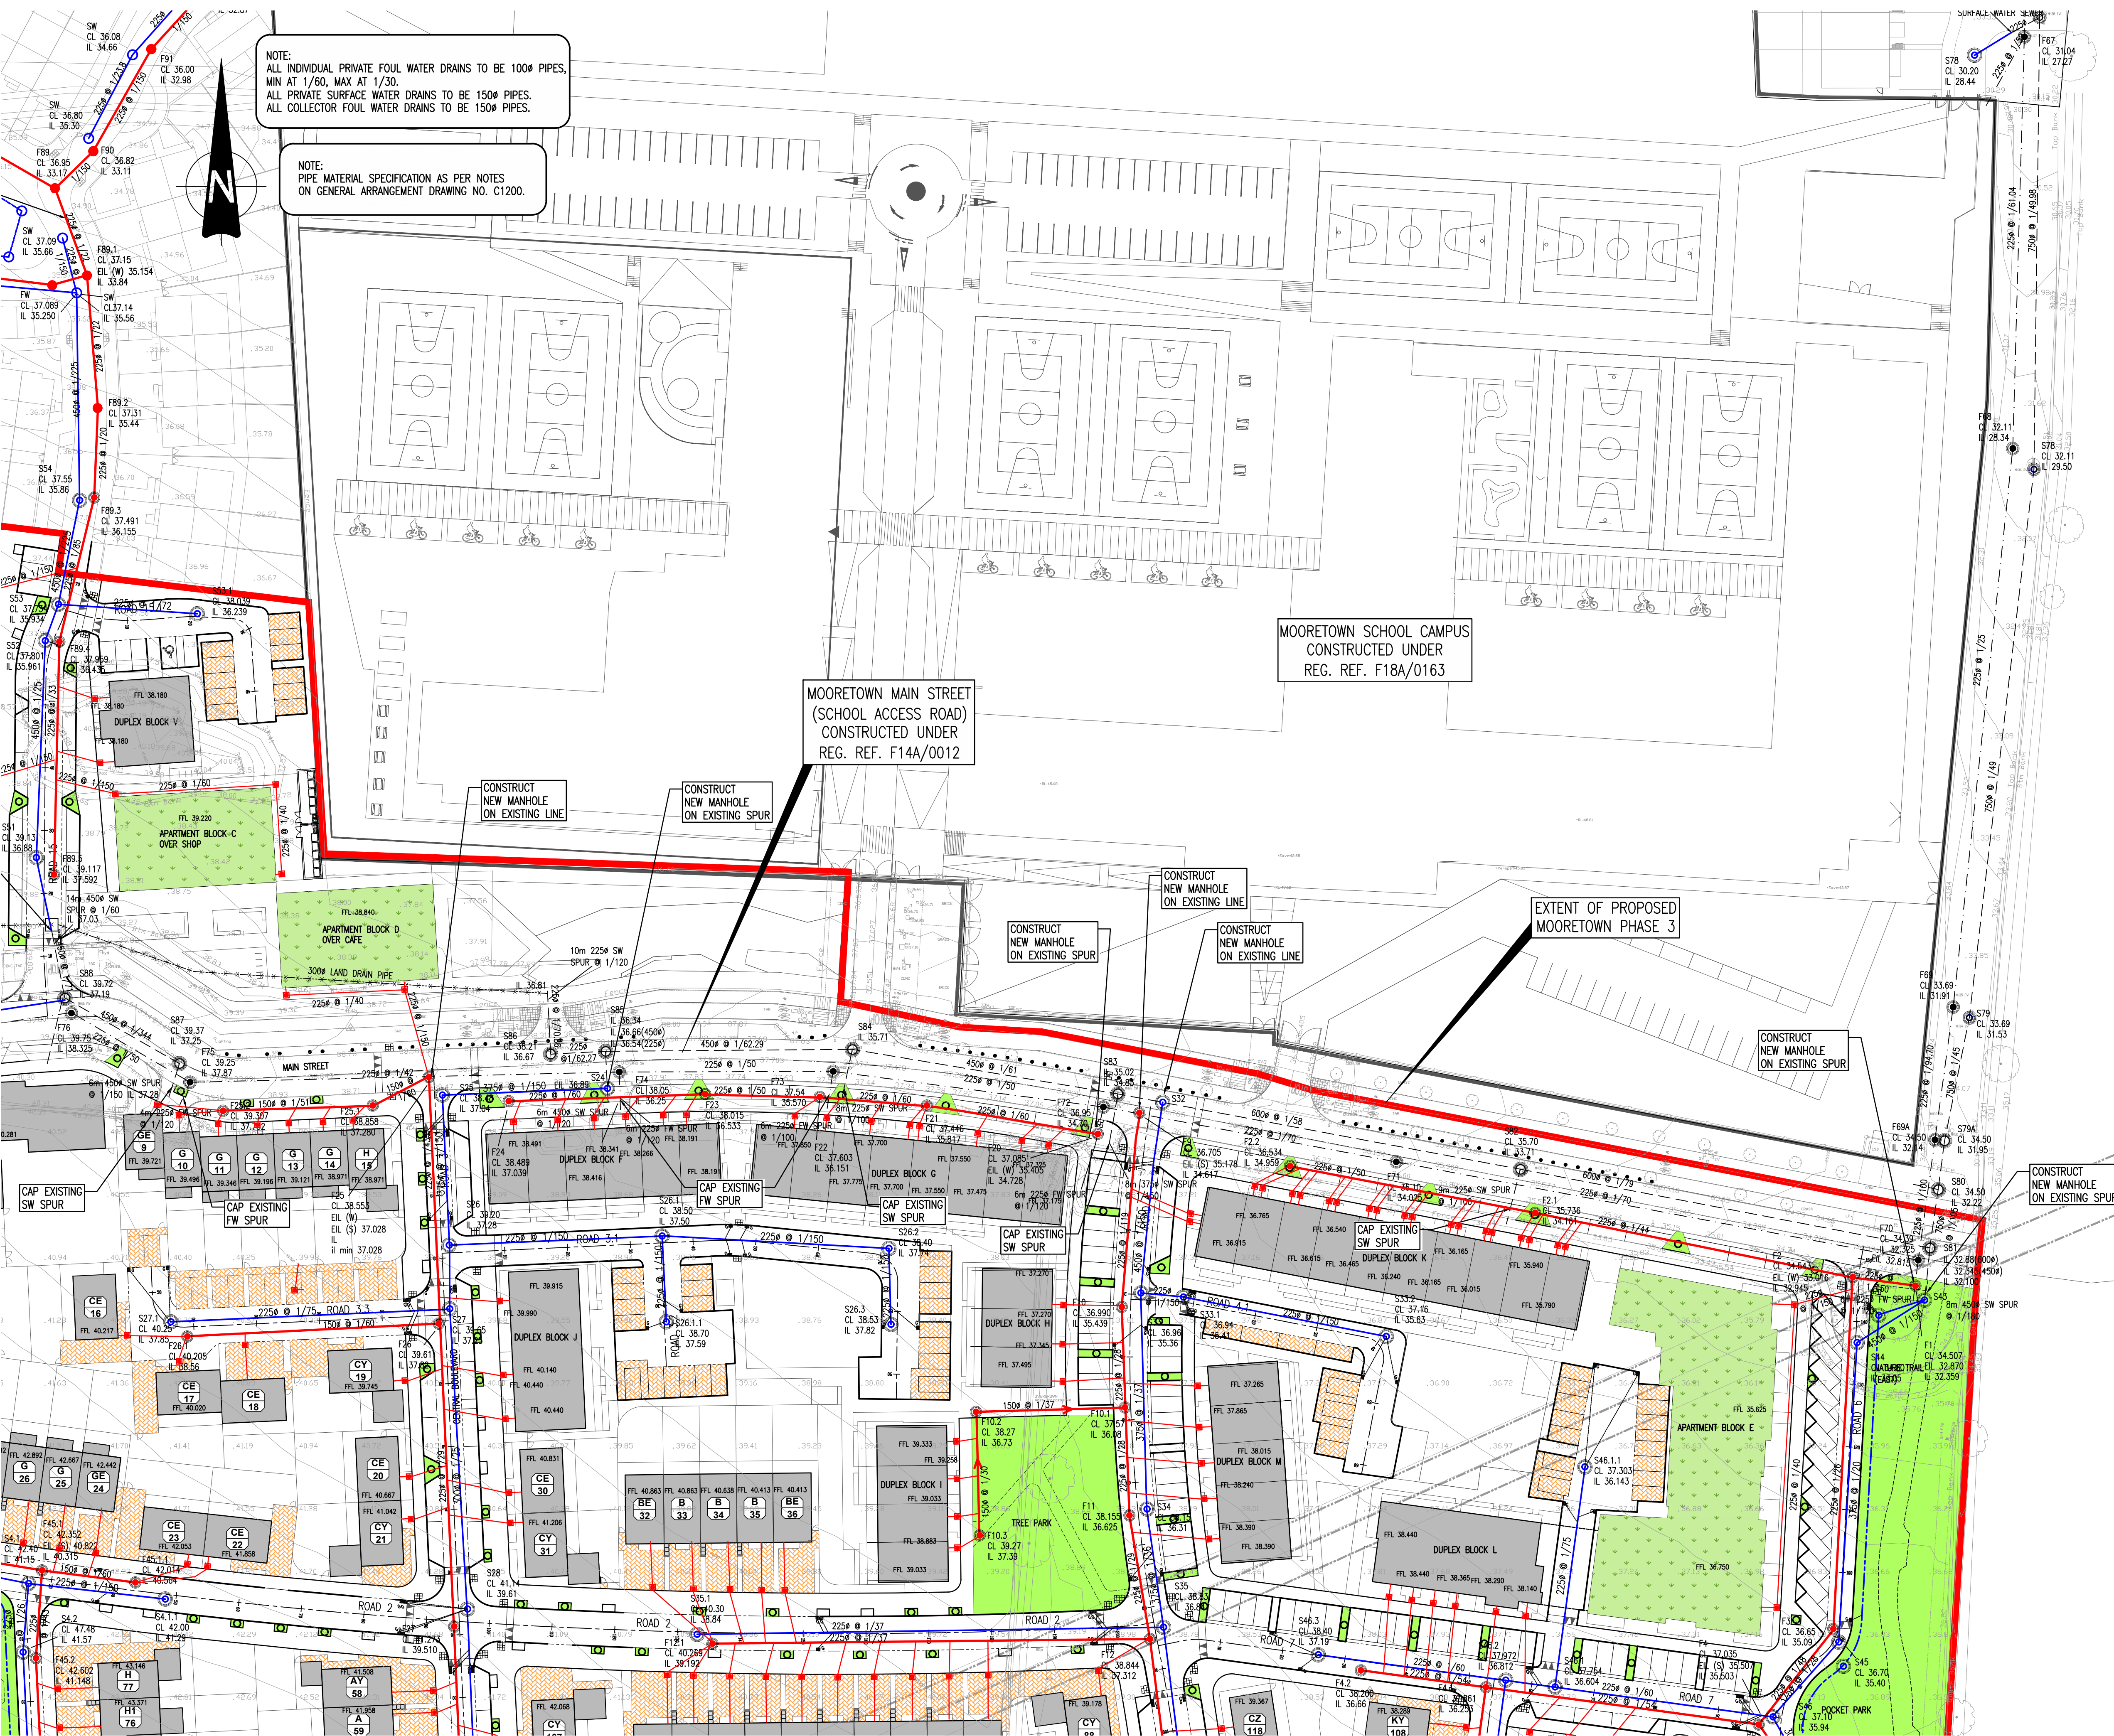

NOTE:
ALL INDIVIDUAL PRIVATE FOUL WATER DRAINS TO BE 100Ø PIPES,
MIN AT 1/60, MAX AT 1/30.
ALL PRIVATE SURFACE WATER DRAINS TO BE 150Ø PIPES.
ALL COLLECTOR FOUL WATER DRAINS TO BE 150Ø PIPES.

NOTE:
PIPE MATERIAL SPECIFICATION AS PER NOTES
ON GENERAL ARRANGEMENT DRAWING NO. C1200.

- NOTES:
- DO NOT SCALE. USE FIGURED DIMENSIONS ONLY.
 - THIS DRAWING IS TO BE READ IN CONJUNCTION WITH ALL OTHER RELEVANT ARCHITECTURAL AND ENGINEERING DRAWINGS.

LEGEND

EX XXXØ @ 1/XXX EXSX
CL X WITH PIPE SIZE, GRADE, MANHOLE
IL X REF. AND INVERT LEVEL

EX XXXØ @ 1/XXX EXFX
CL X EXISTING FOUL WATER SEWER WITH
IL X PIPE SIZE, GRADE, MANHOLE REF.
 AND INVERT LEVEL

XXXØ @ 1/XXX FX
CL X PROPOSED FOUL WATER SEWER
IL X WITH PIPE SIZE, GRADE, MANHOLE
 REF. AND INVERT LEVEL

 PROPOSED INSPECTION CHAMBER

XXXØ @ 1/XXX SX
CL X PROPOSED SURFACE WATER SEWER
IL X WITH PIPE SIZE, GRADE, MANHOLE
 REF. AND INVERT LEVEL



XXXØ @ 1/XXX SX
CL X PROPOSED PERFORATED SURFACE
IL X WATER SEWER WITH PIPE SIZE,
 GRADE, MANHOLE REF. AND INVERT
 LEVEL

G PROPOSED GULLY AND 150Ø GULLY PIPE,
 DOUBLE GULLY AT LOW POINTS

 PERMEABLE PAVING

 PROPOSED BIO-RETENTION
 TREE PIT

 PROPOSED GREEN ROOF
 MIN 60% COVERAGE

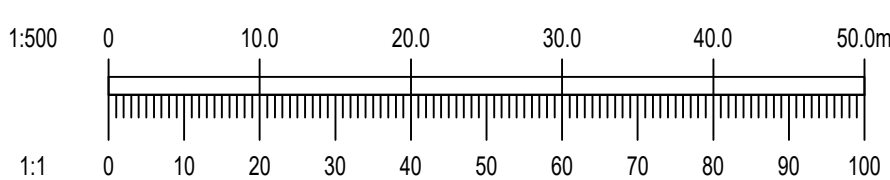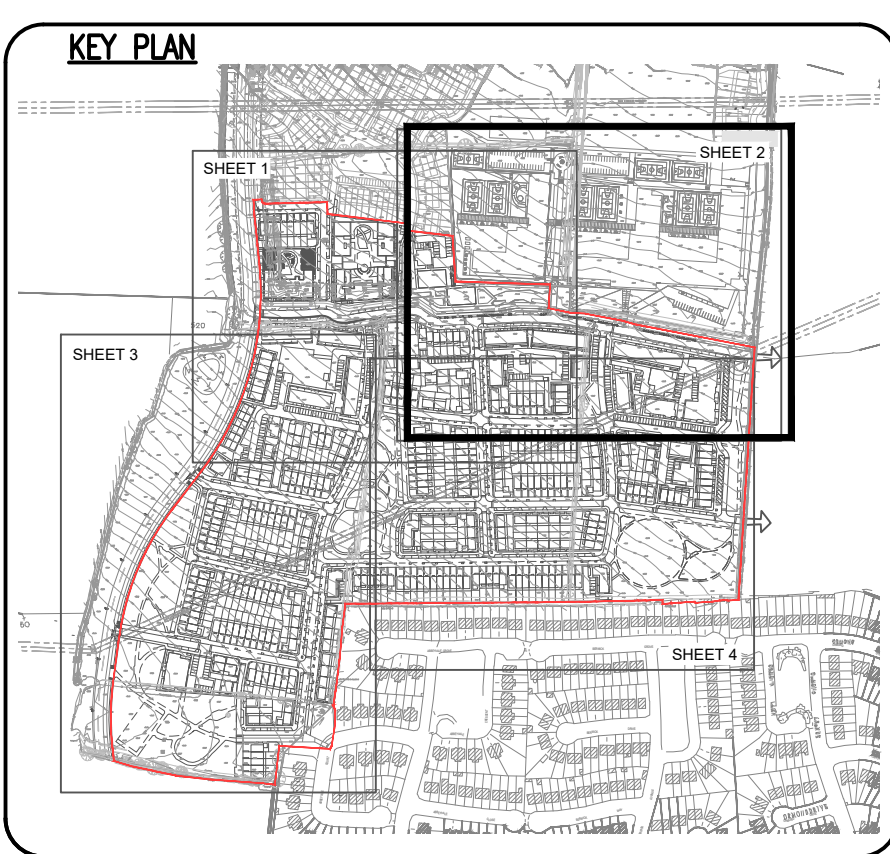

Ordnance Survey Ireland Licence No. EN 0006021
© Ordnance Survey Ireland/Government of Ireland.

A	12/04/22	FINAL SHD SUBMISSION	MS	MD
REV.	DATE	AMENDMENT	DRN	APPD

STATUS **PLANNING**

Waterman Moylan
Engineering Consultants

BLOCK 8, EASTPOINT BUSINESS PARK, ALFIE BYRNE ROAD,
DUBLIN D03 K7W7 IRELAND.
Tel: (01) 664 8900 Fax: (01) 661 3618
Email: info@waterman-moylan.ie www.waterman-moylan.ie

CLIENT **GERARD GANNON PROPERTIES**

ARCHITECT **CONROY CROWE KELLY ARCHITECTS**

PROJECT **PHASE 3, MOORETOWN**

TITLE **DRAINAGE LAYOUT
SHEET 2 OF 4**

DRAWN MS	DESIGNED RM	APPROVED MD	DATE JULY 2021
SCALE 1:500 @ A1	JOB NO. 21-011	DRG. NO. P1202	REVISION A