

A	12/04/22	FINAL SHD SUBMISSION	MS	MD
REV.	DATE	AMENDMENT	DRN	APPD

STATUS **PLANNING**



BLOCK S, EASTPOINT BUSINESS PARK, ALFIE BYRNE ROAD,
DUBLIN D03 K7W7 IRELAND.
Tel: (01) 664 8900 Fax: (01) 661 3618
Email: info@waterman-moylan.ie www.waterman-moylan.ie

CLIENT GERARD GANNON PROPERTIES


ARCHITECT CONROY CROWE KELLY ARCHITECTS

PROJECT PHASE 3,
MOORETOWN

TITLE
DRAINAGE LAYOUT
SHEET 3 OF 4

DRAWN MS	DESIGNED RM	APPROVED MD	DATE JULY 2021
SCALE 1:500 @ A1	JOB NO. 21-011	DRG. NO. P1203	REVISION A

© 2018. This drawing is copyright. No part of this document may be re-produced or transmitted in any form or stored in any retrieval system of any nature without the written permission of the consulting engineer as copyright holder except as agreed for use on the project for which the document was originally issued.

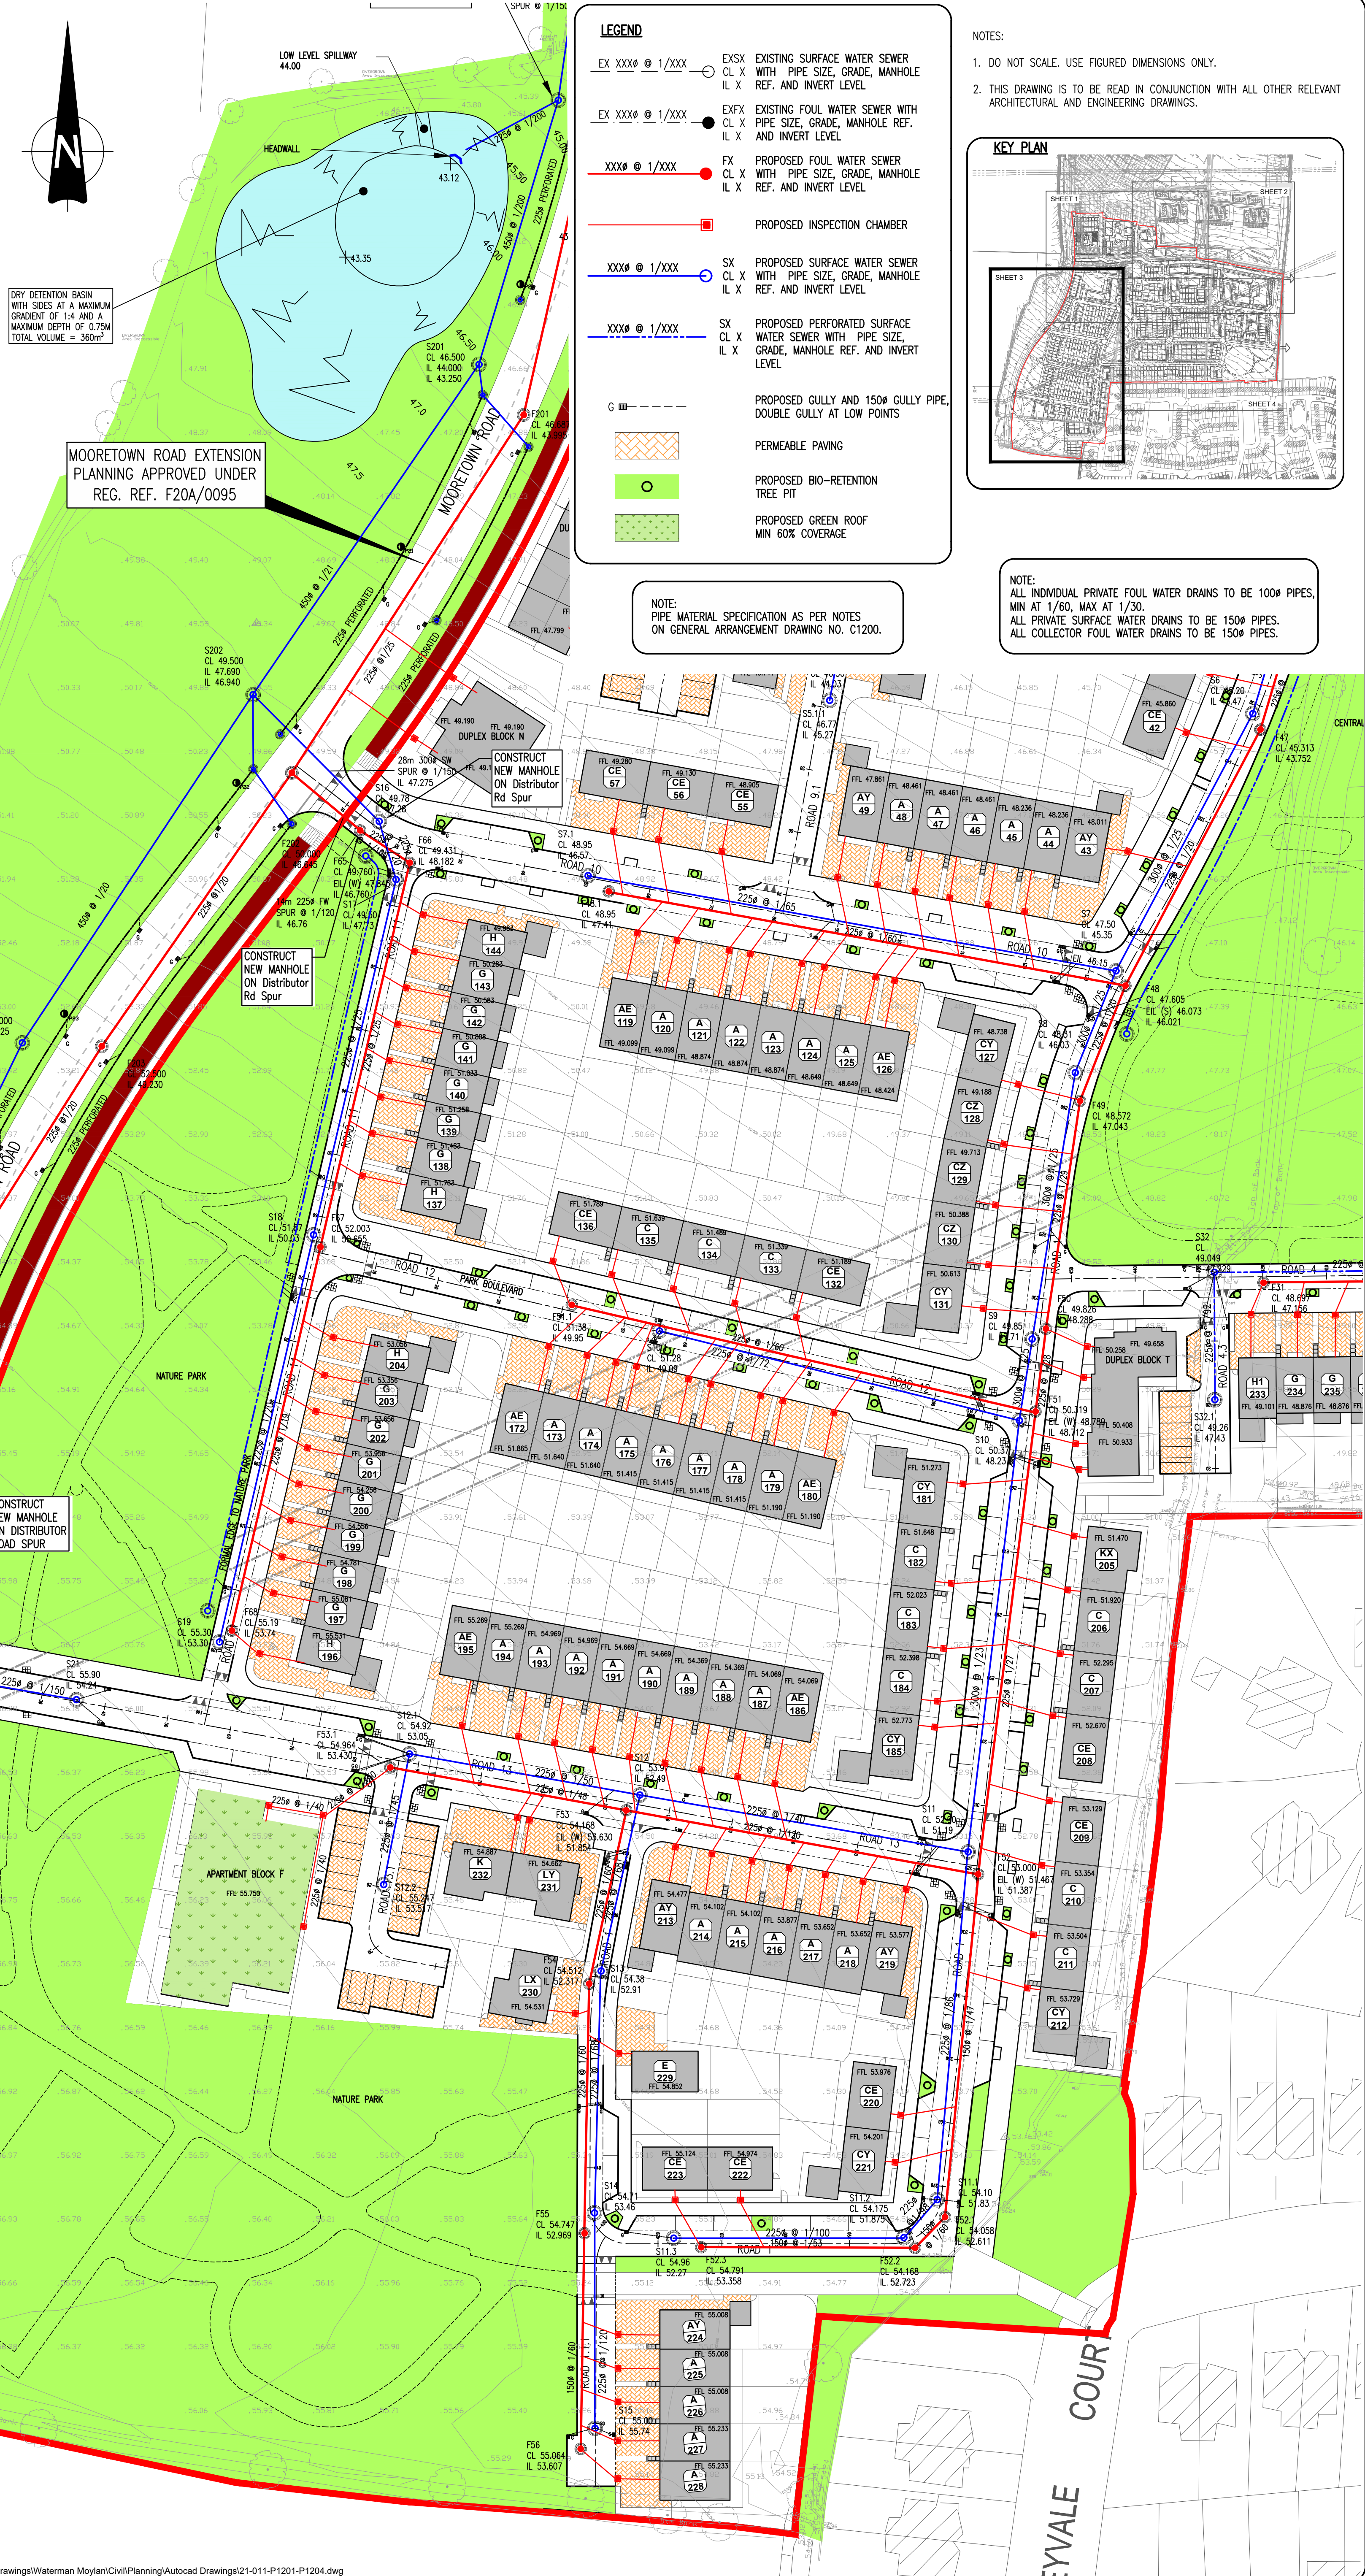

1. DO NOT SCALE. USE FIGURED DIMENSIONS ONLY.
2. THIS DRAWING IS TO BE READ IN CONJUNCTION WITH ALL OTHER RELEVANT ARCHITECTURAL AND ENGINEERING DRAWINGS.

NOTE:
ALL INDIVIDUAL PRIVATE FOUL WATER DRAINS TO BE 100Ø PIPES,
MIN AT 1/60, MAX AT 1/30.
ALL PRIVATE SURFACE WATER DRAINS TO BE 150Ø PIPES.
ALL COLLECTOR FOUL WATER DRAINS TO BE 150Ø PIPES.

