




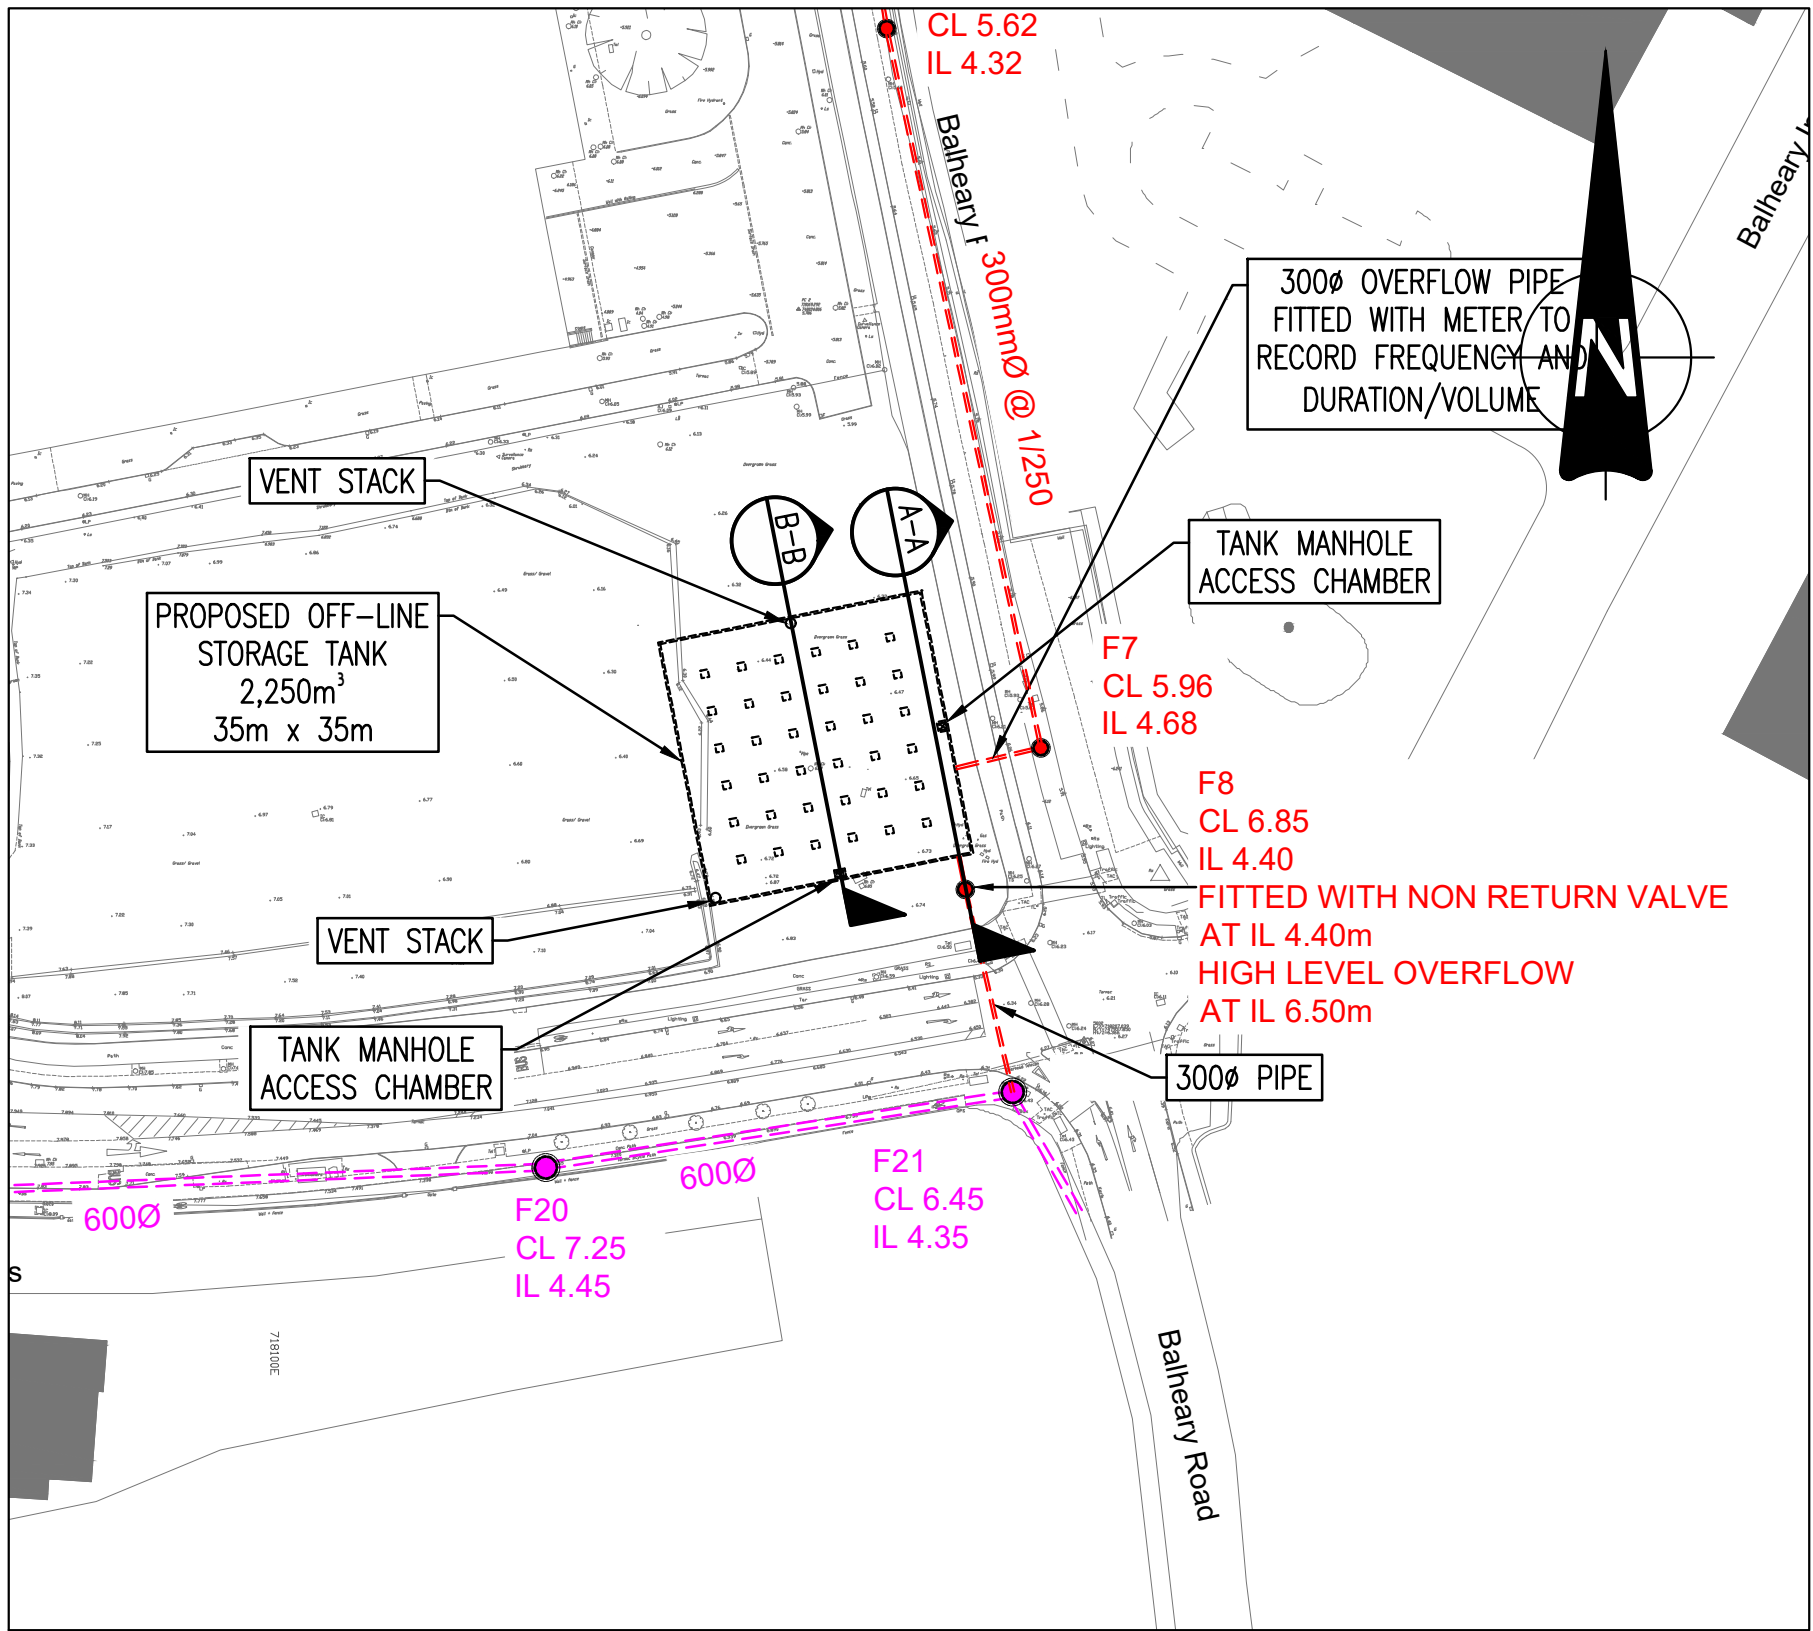


PLAN VIEW – DRAINAGE LAYOUT
SCALE 1:1000 @A1

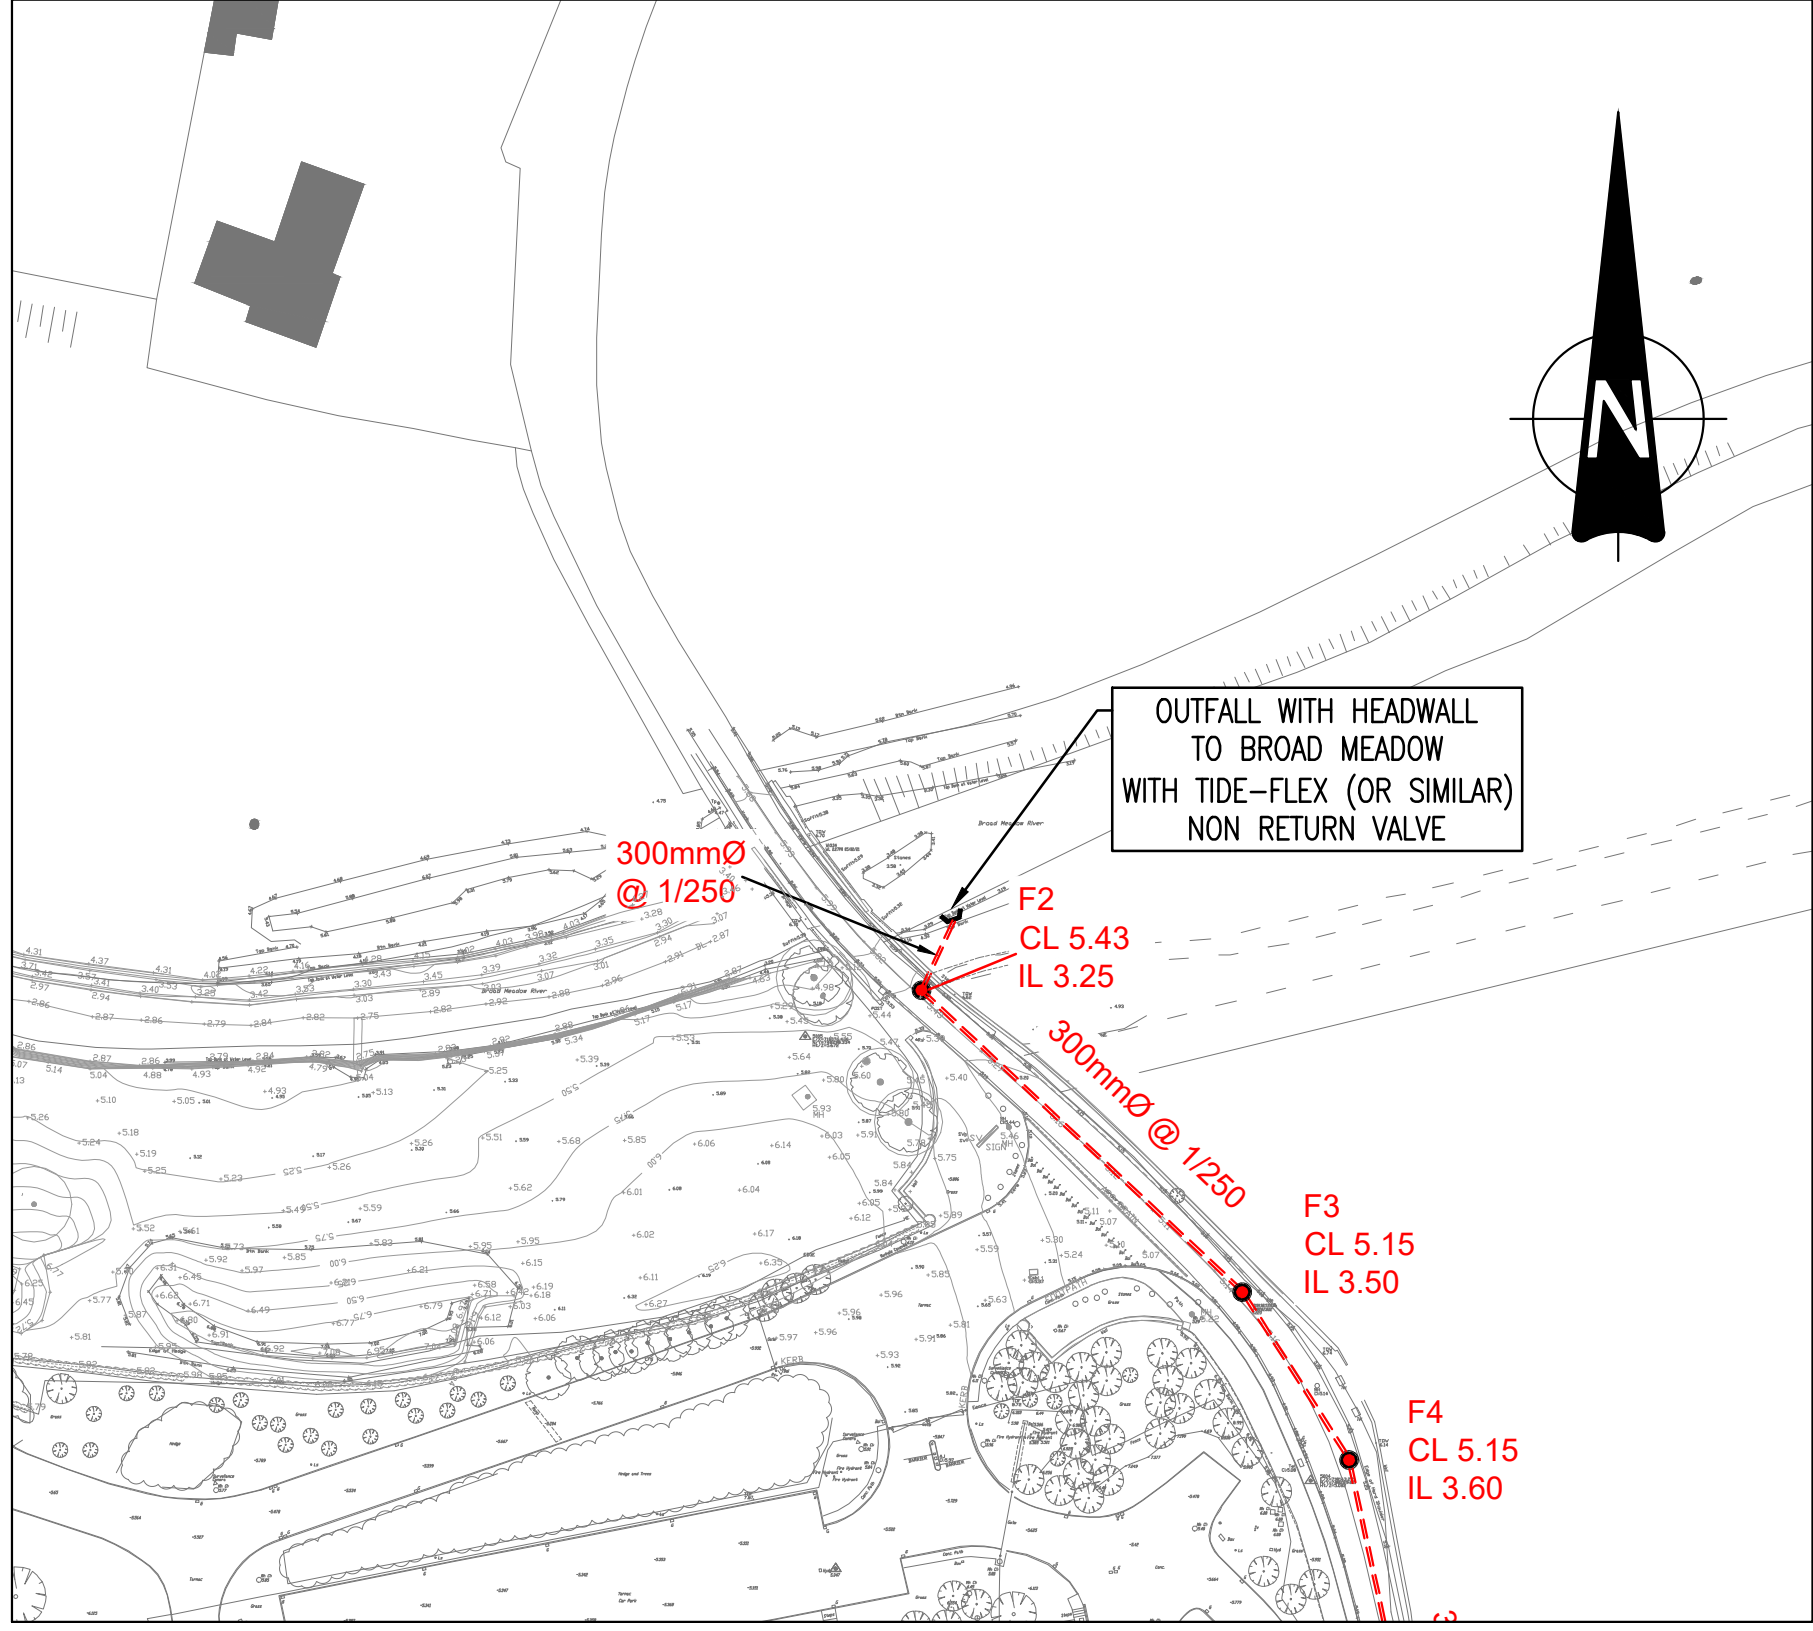

PLAN VIEW – HEADWALL LOCATION
SCALE 1:1000 @A1

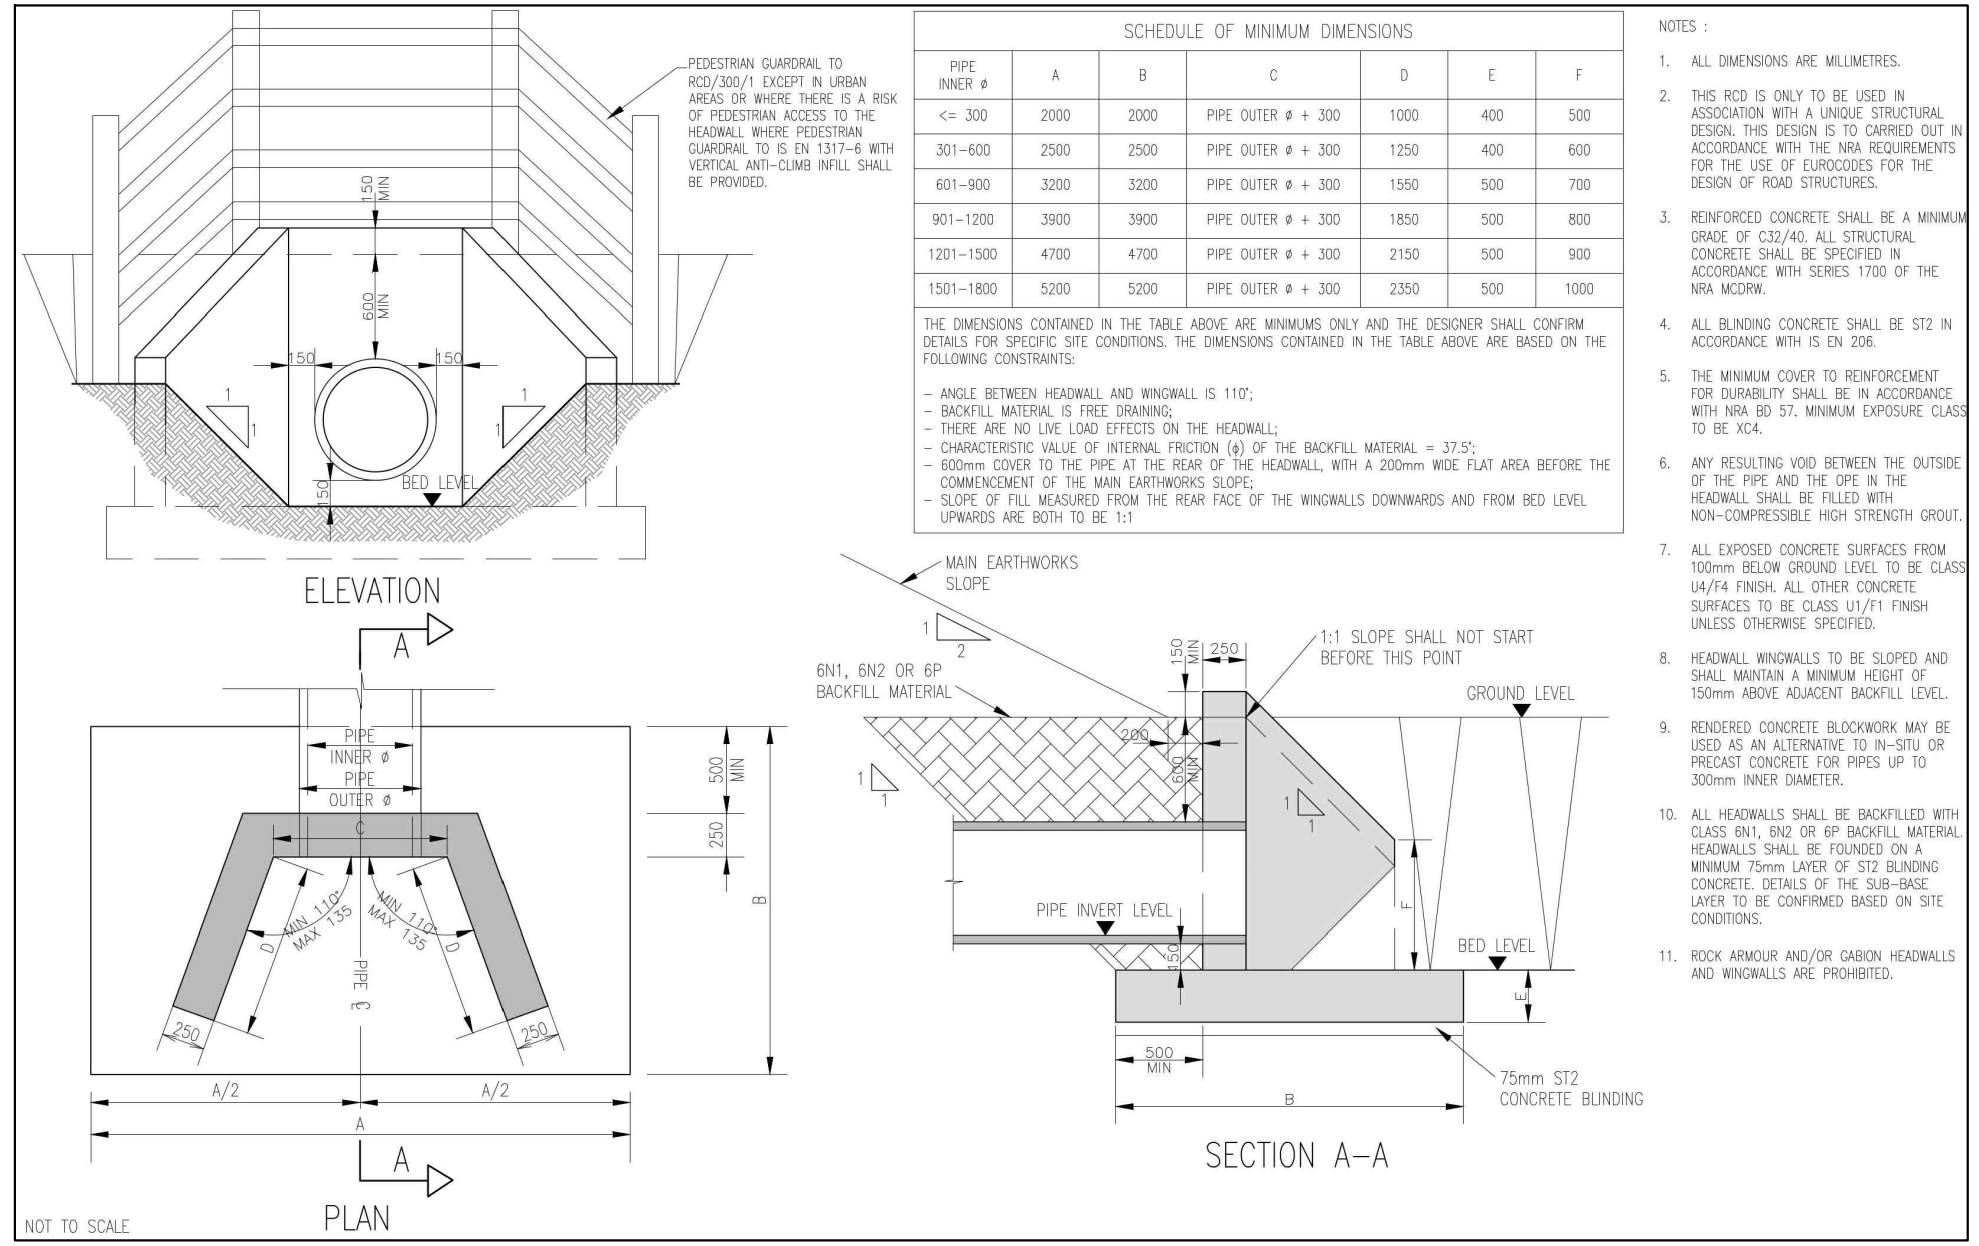


TYPICAL HEADWALL DETAIL
N.T.S.

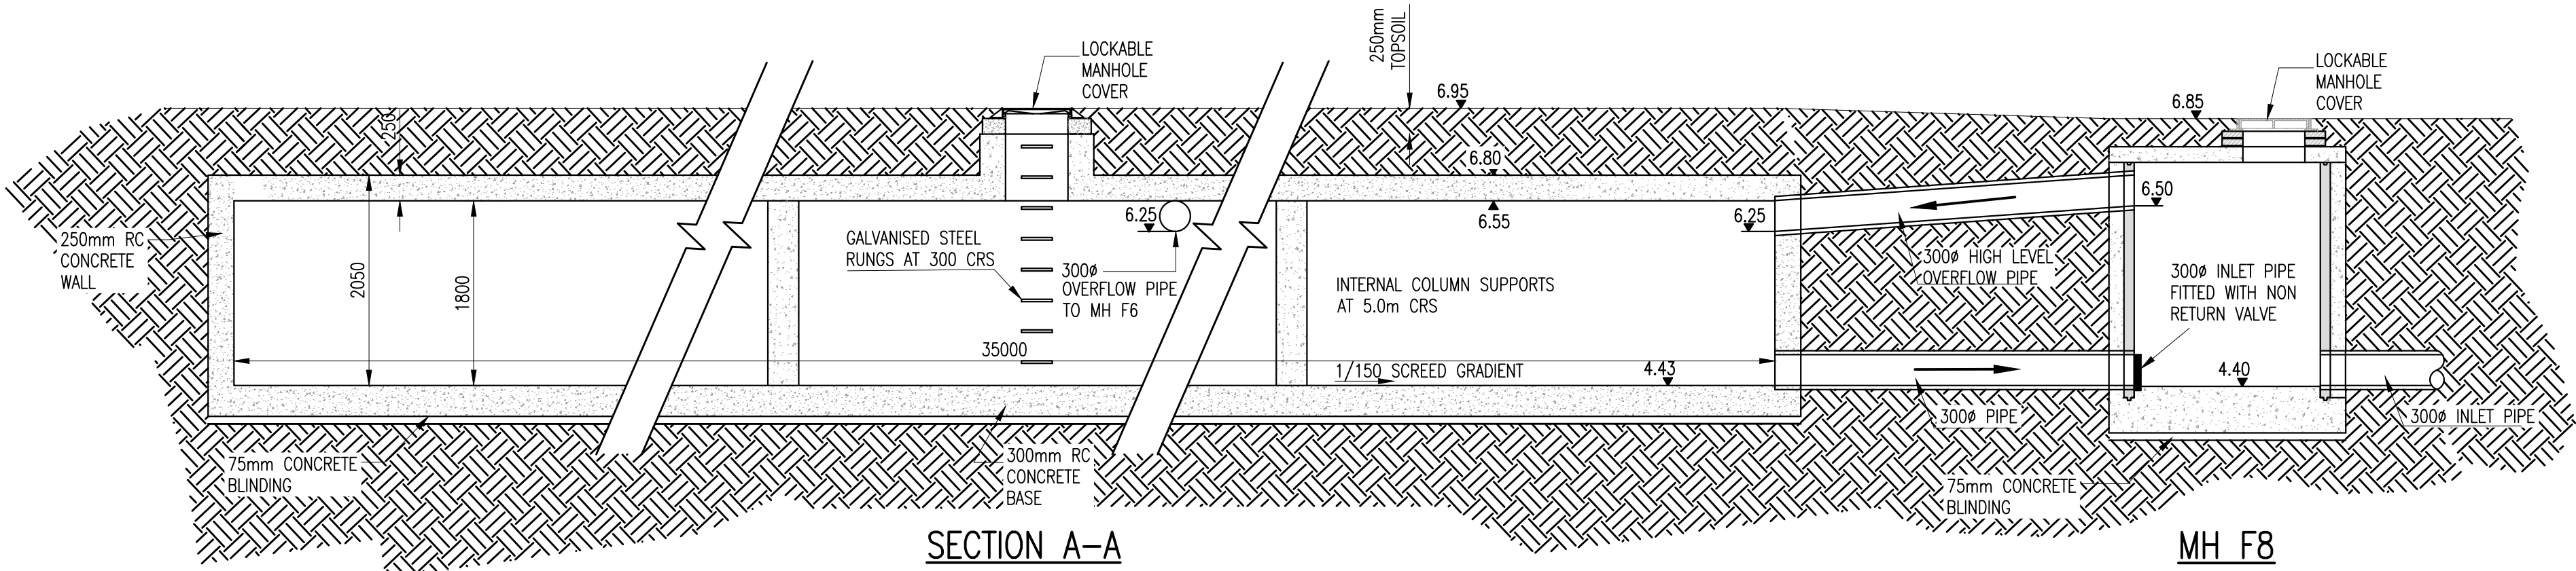


SECTION A-A
SCALE 1:50 @A1

MH F8

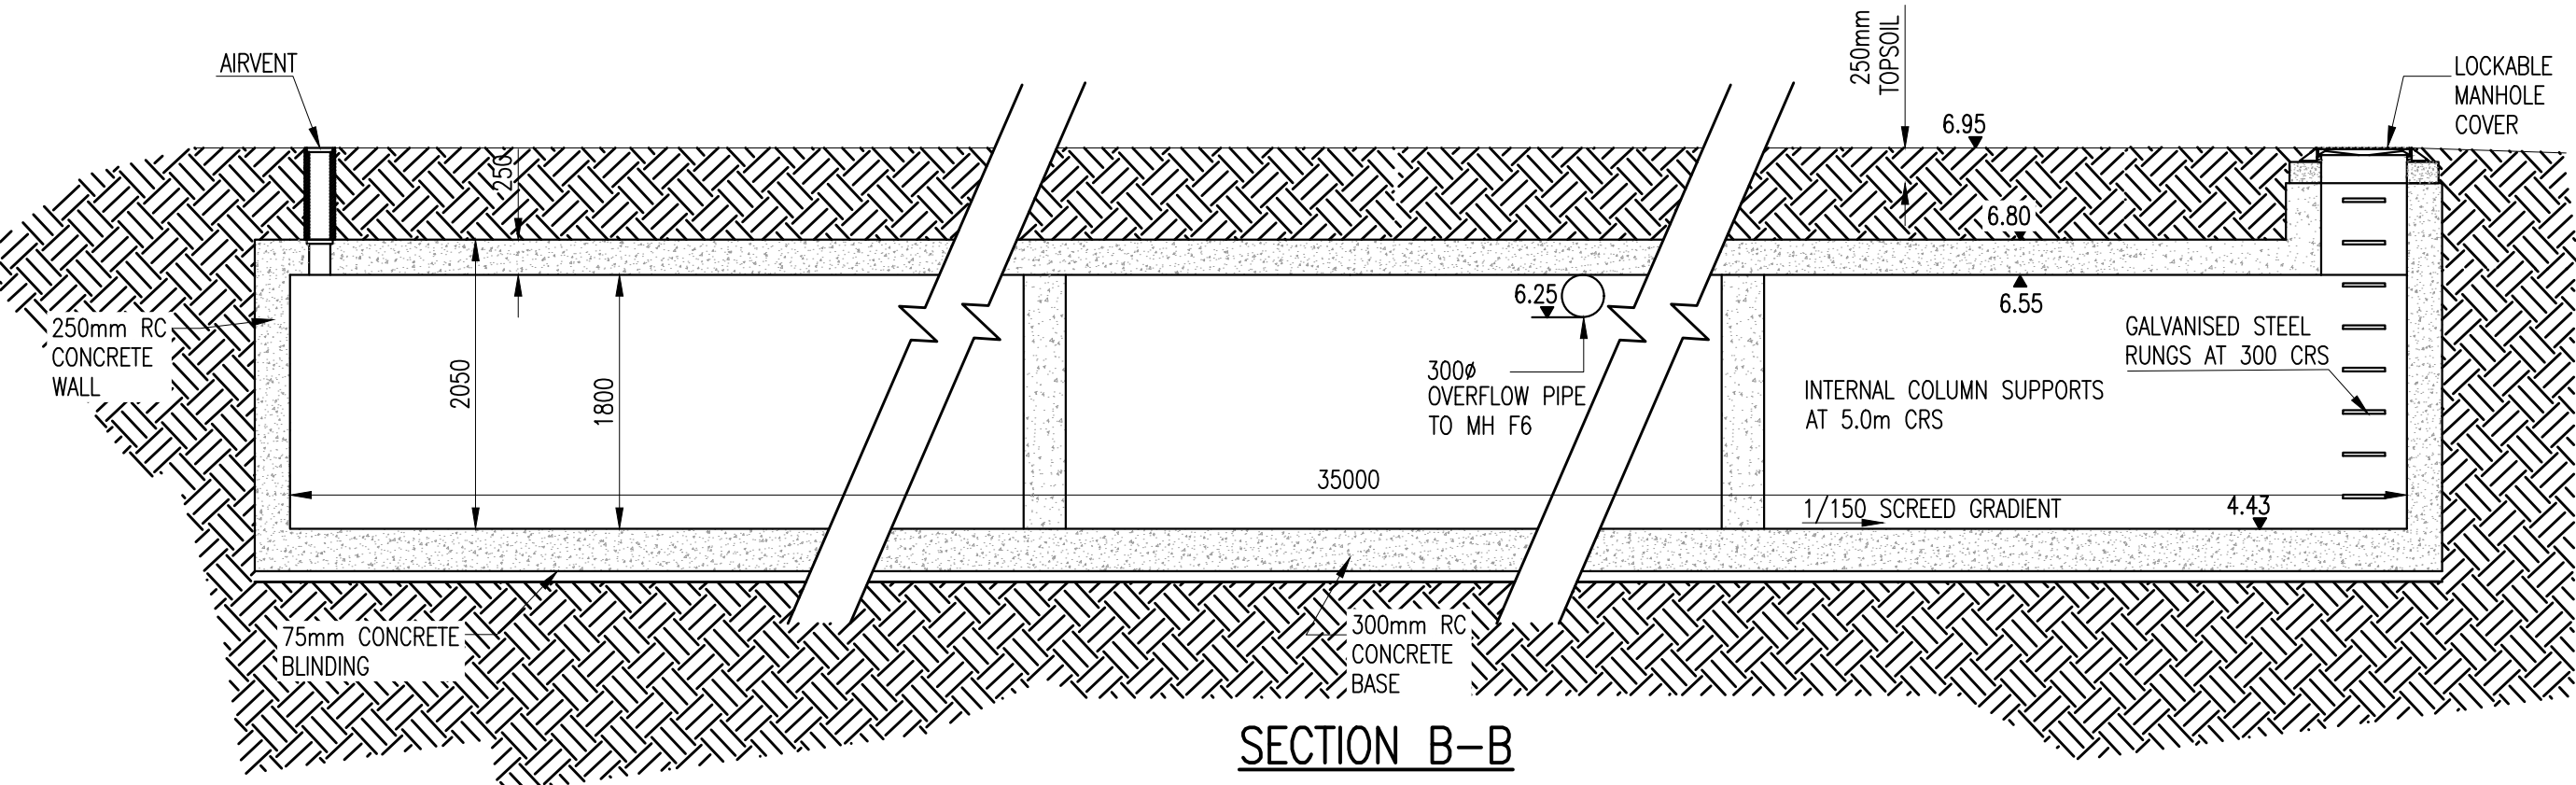

SECTION B-B
SCALE 1:50 @A1

LEGEND:

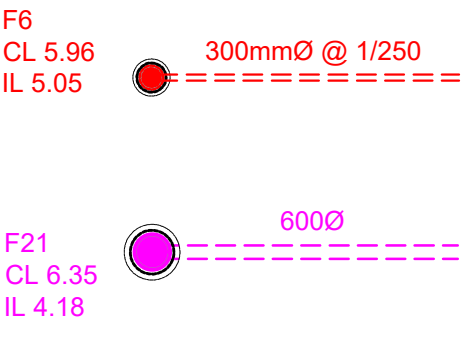

INDICATES PROPOSED FOUL SEWER AND MANHOLE
PIPE SIZE WITH MANHOLE REFERENCE,
COVER AND INVERT LEVELS

INDICATES EXISTING FOUL SEWER AND MANHOLE
PIPE SIZE WITH MANHOLE REFERENCE,
COVER AND INVERT LEVELS

Ordnance Survey Ireland Licence No. EN 0006021
© Ordnance Survey Ireland/Government of Ireland.

REV.	DATE	AMENDMENT	DRN	APPD
------	------	-----------	-----	------

STATUS **PLANNING**

Waterman Moylan
Engineering Consultants
BLOCK 5, EASTPOINT BUSINESS PARK, ALFIE BYRNE ROAD,
DUBLIN D03 K7W7 IRELAND.
Tel: (01) 664 8900 Fax: (01) 661 3618
Email: info@waterman-moylan.ie www.waterman-moylan.ie

CLIENT **GERARD GANNON PROPERTIES**
ARCHITECT **CONROY CROWE KELLY ARCHITECTS**

PROJECT **PHASE 3,
MOORETOWN
STORMWATER STORAGE TANK ON
FOUL WATER DRAINAGE**

TITLE **PROPOSED DRAINAGE DETAILS**

DRAWN MS	DESIGNED MD	APPROVED MD	DATE MARCH 2022
SCALE AS SHOWN	JOB NO. 21-011	DRG. NO. P2004	REVISION

© 2018. This drawing is copyright. No part of this document may be reproduced or transmitted in any form or stored in any retrieval system of any nature without the written permission of the consulting engineer or copyright holder except as agreed in writing for use on the project for which the document was originally issued.