
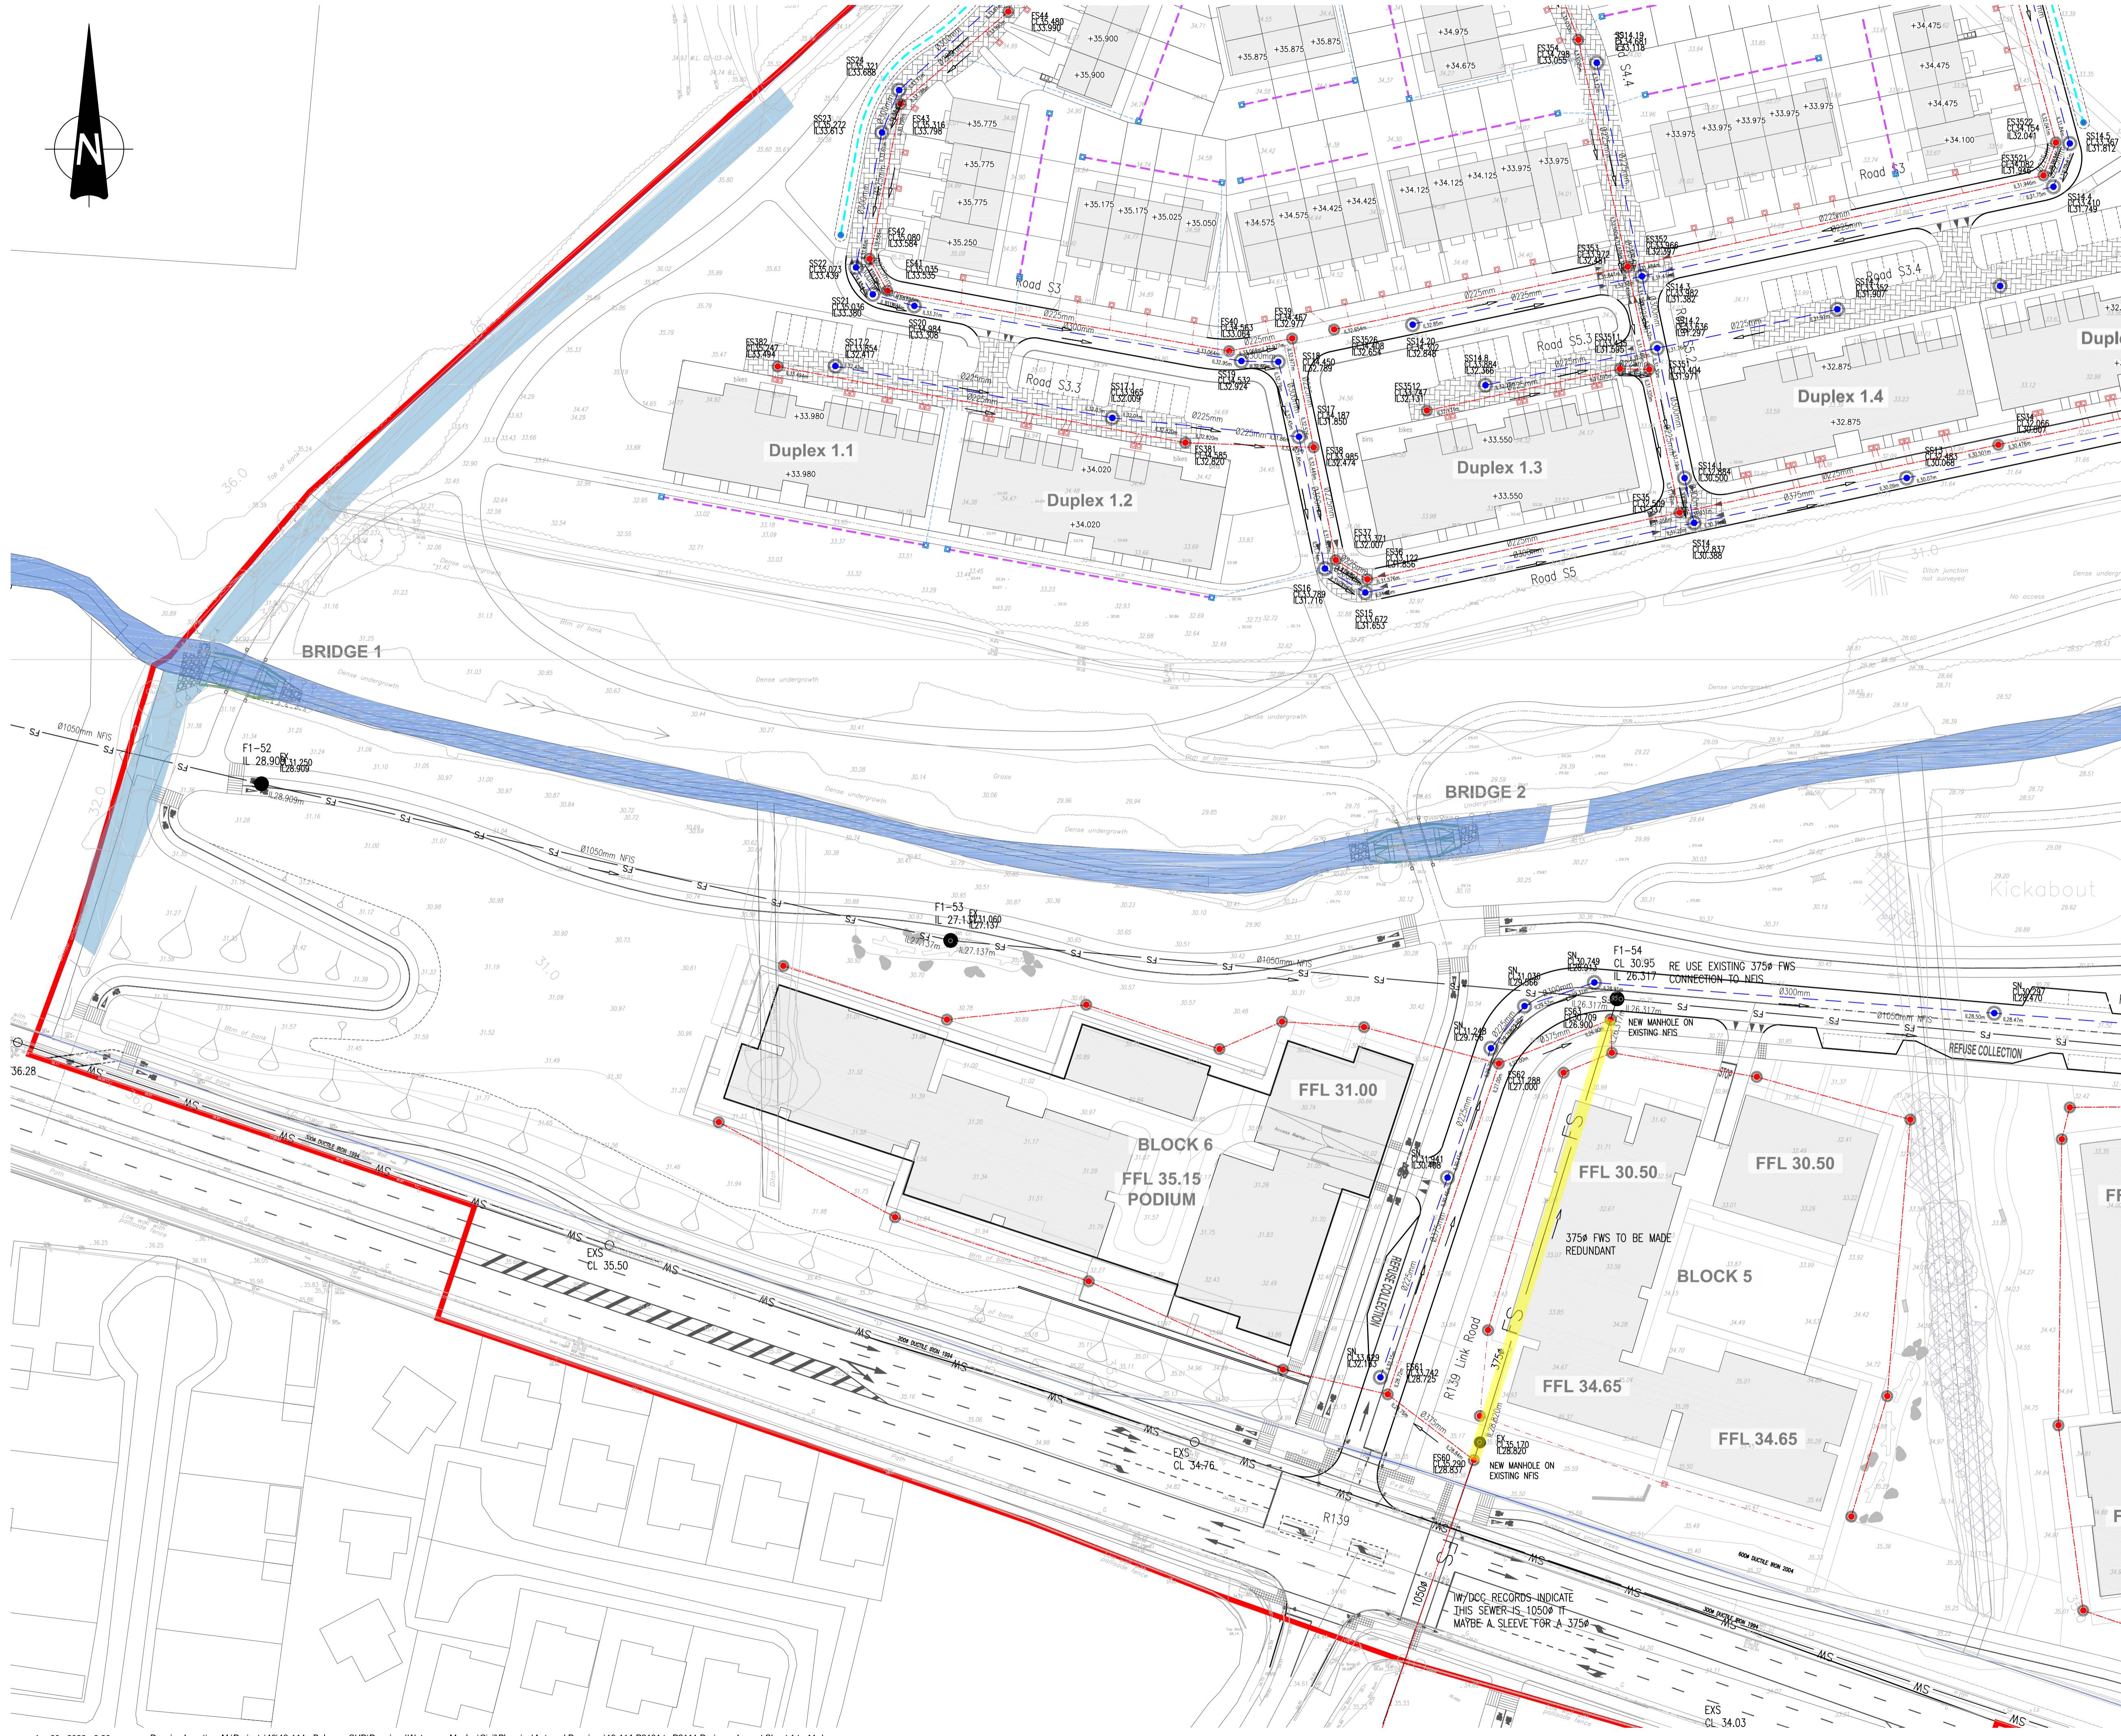


- NOTES:
- DO NOT SCALE. USE FIGURED DIMENSIONS ONLY.
 - THIS DRAWING IS TO BE READ IN CONJUNCTION WITH ALL OTHER RELEVANT ARCHITECTURAL AND ENGINEERING DRAWINGS.

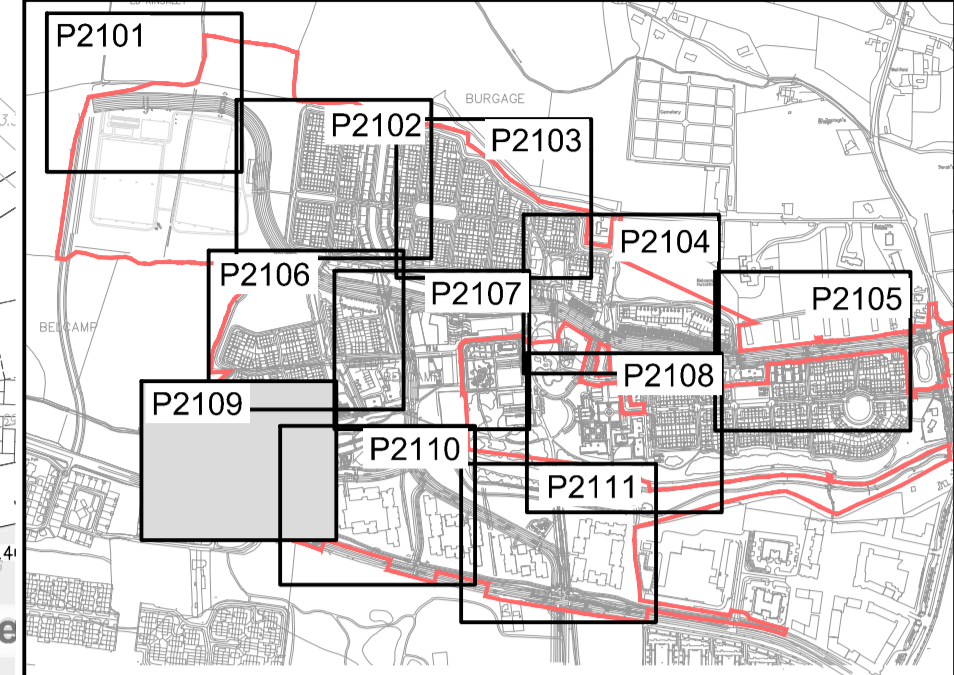

LEGEND:

- FS CL X IL X: EXISTING FOUL WATER SEWER WITH PIPE SIZE, GRADE, MANHOLE REF. AND INVERT LEVEL
- SW CL X IL X: EXISTING SURFACE WATER SEWER WITH PIPE SIZE, GRADE, MANHOLE REF. AND INVERT LEVEL
- XXXmm @ 1/XXX uPVC SN8: PROPOSED FOUL WATER SEWER WITH PIPE SIZE, GRADE, MANHOLE REF. AND INVERT LEVEL
- XXXmm @ 1/XXX SX CL X IL X: PROPOSED SURFACE WATER SEWER WITH PIPE SIZE, GRADE, MANHOLE REF. AND INVERT LEVEL
- P2101: PROPOSED FOUL INSPECTION CHAMBER AND CONNECTION
- SWALE: PROPOSED SWALE WITH PERFORATED PIPE AND GRATED MANHOLE
- PROPOSED 0.5m WIDE KERB OPENING FOR SURFACE WATER RUN-OFF TO SWALE, MAX CENTER'S 25m
- PROPOSED 225# FILTER DRAIN
- G: PROPOSED GULLY AND CONNECTION
- PROPOSED PERMEABLE PAVING
- EXISTING STREAM/POND FOR SURFACE WATER OUTFALL
- PROPOSED DRY DETENTION BASIN

1:500 0 10.0 20.0 30.0 40.0 50.0m
1:1 0 10 20 30 40 50 60 70 80 90 100

Ordnance Survey Ireland
Ordnance Survey Ireland Licence No. EN 0006022 © Ordnance Survey Ireland/Government of Ireland.

REV.	DATE	AMENDMENT	DRN APPD

STATUS FOR PLANNING NOT FOR CONSTRUCTION

Waterman Moylan
Engineering Consultants
BLOCK 5, EASTPOINT BUSINESS PARK, ALFIE BYRNE ROAD, DUBLIN D03 H3F4 IRELAND. Tel: (01) 664 8900
Email: info@waterman-moylan.ie www.waterman-moylan.ie

CLIENT: GERARD GANNON PROPERTIES
ARCHITECT: CONROY CROWE KELLY / WILSON ARCHITECTURE

PROJECT: PROPOSED STRATEGIC HOUSING DEVELOPMENT AT BELCAMP, DUBLIN 17

TITLE: DRAINAGE LAYOUT SHEET 9 OF 11

DRAWN PJD	DESIGNED SDN	APPROVED MDG	DATE APRIL 2022
SCALE 1:500 @ A1	JOB NO. 19-114	DRG. NO. P2109	REVISION