


01 Site Location
001 1:2500

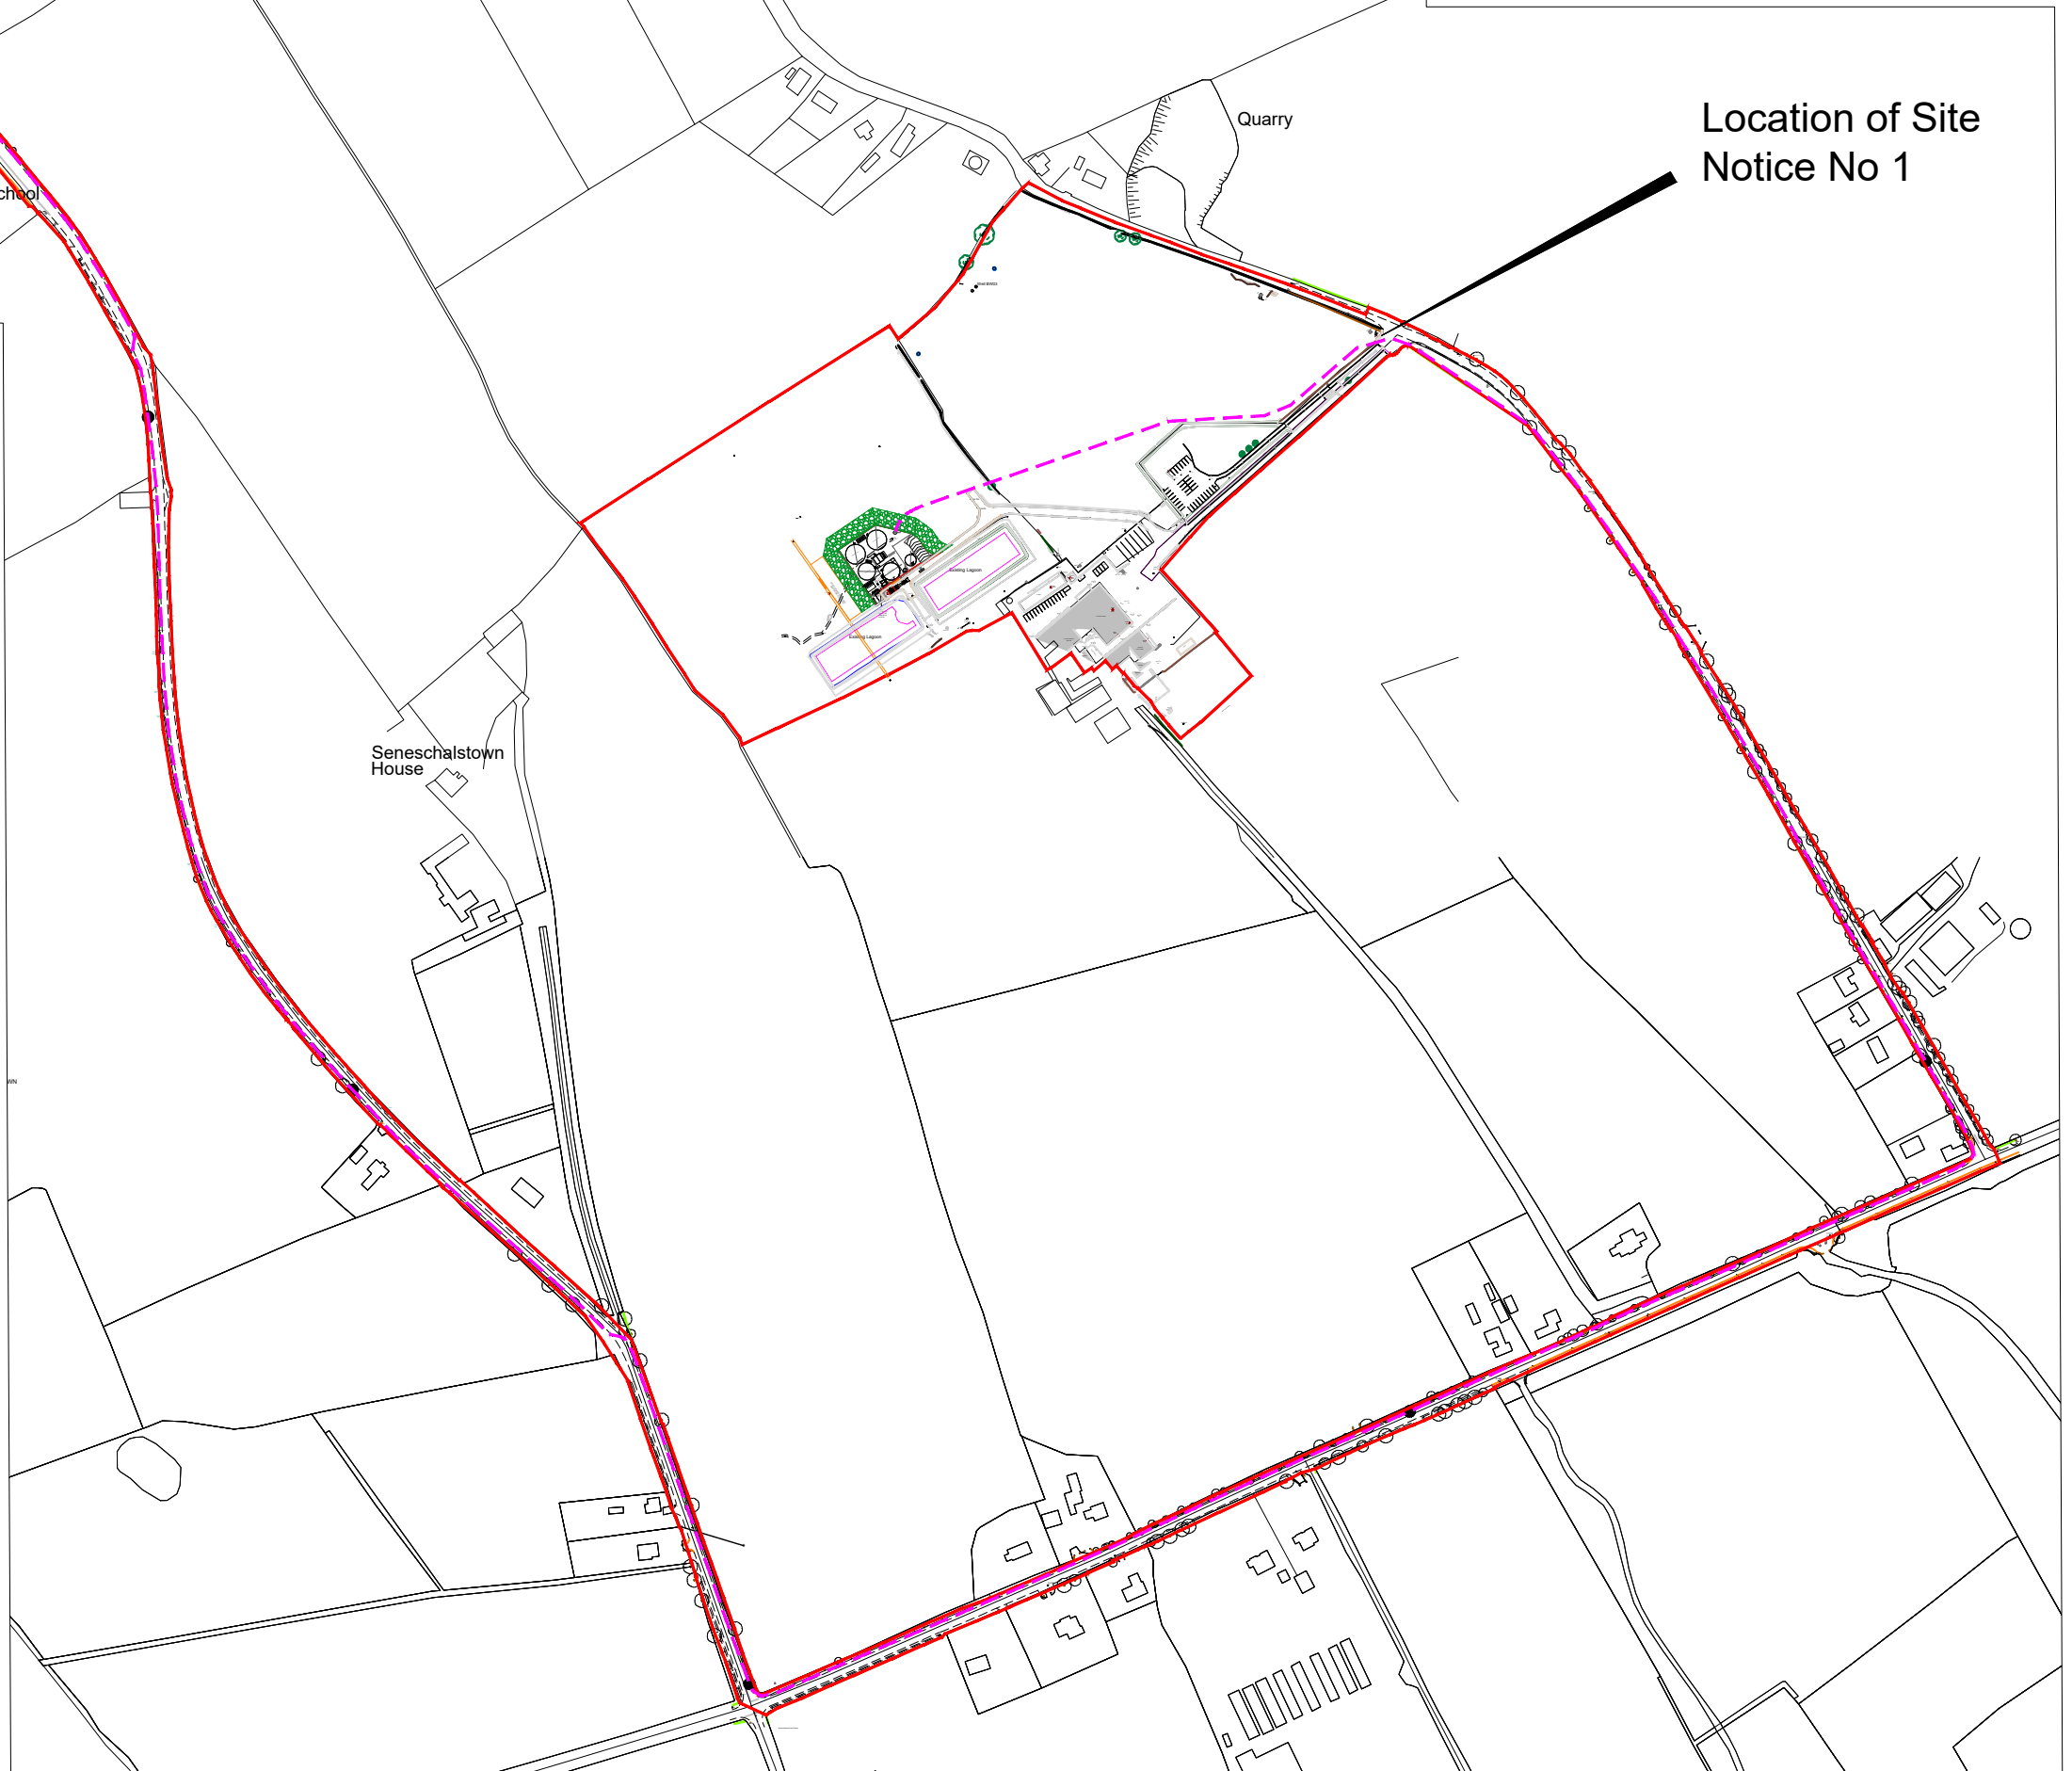

02 Site Location
001 1:5000

A	Submitted in response to F1 request on planning ref 21424	January 2022	T. Finn
REV. NO.	DESCRIPTION	DATE	INITIALS

finn
DESIGN
PARTNERSHIP
Blakestown, Ardee, Co. Louth, Ireland
t 041 6857200 f 041 6857201 e info@finn.ie w www.finn.ie

CREATIVE • INNOVATIVE

DRAWING NO:
001

REV. NO:
A

G
Z
E

TITLE:	Site Location Map		
PROJECT:	Extension to WWTP & Rising Main Pipeline to River Boyne		
CLIENT:	Dawn Meats Ireland Painestown, Beauparc, Co Meath		
SCALE:	1:5000	DRAWN:	T. Finn
DATE:	February 2020	CHECKED:	-
STATUS:	Planning Application		
JOB NO:	1604		

NOTES

- Copyright Reserved 2003 ©
- Work to figured dimensions only. Do not scale drawing.
- The contractor is responsible for checking all levels and dimensions on site and shall refer all discrepancies to the Architect.
- Where appropriate, for details of r.c. structure, or mechanical and electrical details, see Engineers drawings.
- Proprietary items shall be fixed in strict accordance with manufacturers instructions.
- Size of proprietary items shall be checked with manufacturer.
- The contractor shall be responsible for the coordination of structure, finishes and services.

CIVIL • STRUCTURAL ENGINEERING • PROJECT MANAGEMENT

O.S. SHEET No. 2378/2440

COPIED UNDER ORDNANCE
SURVEY LICENSE No. AR0049711

LEGEND:
Boundary of Proposed
Development outlined in red