


Legend

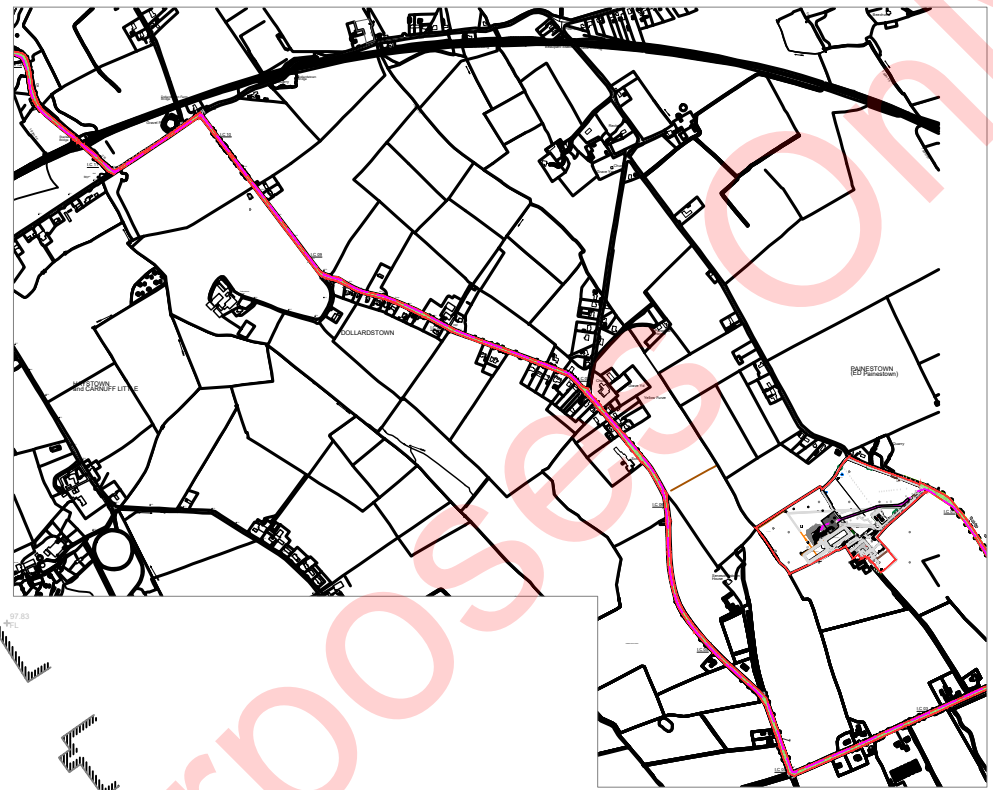

A	WWTP Site Layout Revised in Response to FI Response	January 2022	T.Finn
REV. NO.	DESCRIPTION	DATE	INITIALS

finn
DESIGN PARTNERSHIP
CREATIVE • INNOVATIVE

Blakestown, Ardee, Co. Louth, Ireland
t 041 6857200 f 041 6857201 e info@finn.ie w www.finn.ie

DRAWING NO: **306** REV. NO: **A**

ENG

TITLE: Proposed Rising Main
Sheet 7 of 7

PROJECT: Extension to WWTP &
Rising Main Pipeline to River Boyne

CLIENT: Dawn Meats Ireland
Painestown, Beauparc,
Co Meath

SCALE: 1:1000 DRAWN: T.Finn

DATE: February 2020 CHECKED: -

STATUS: **Planning Application**

JOB NO: **1604**

NOTES

1. Copyright Reserved 2020 ©
2. Work to figure dimensions only. Do not scale drawing.
3. The contractor is responsible for checking all levels and dimensions on site and shall refer all discrepancies to the Architect.
4. Where appropriate, for details of c, structure, or mechanical and electrical details, see Engineers drawings.
5. Proprietary items shall be listed in detail accordance with manufacturers instructions.
6. Sizes of proprietary items shall be checked with manufacturer.
7. The contractor shall be responsible for the coordination of structure, services and services.

• CIVIL STRUCTURAL ENGINEERING • PROJECT MANAGEMENT

O.S. SHEET No. 2378/2440

COPIED UNDER ORDNANCE
SURVEY LICENSE No. AR0049711

PROPOSED NEW 150MM Ø
TREATED EFFLUNET RISING MAIN

01 Part Site Layout
301 1:1000