

Layout 1

Layout 2

Layout 3

Layout 4

Layout 5

Layout 6

Layout 7

Layout 8


R:\MCW1088 - BAM Castlelake Residential D\p18.0 Drawings\PL\MCW1088-RPS-00-XX-DR-C-PL0101.dwg



Client	General Notes
	<p>(i) Hard copies, dwf and pdf will form a controlled issue of the drawing. All other formats (dwg etc.) are deemed to be an uncontrolled issue and any work carried out based on these files is at the recipient's own risk. RPS will not accept any responsibility for any errors from the use of these files, either by human error by the recipient, listing of the un-dimensioned measurements, compatibility with the recipient's software, and any errors arising when these files are used to aid the recipient's drawing production, or setting out on site.</p> <p>(ii) DO NOT SCALE, use figured dimensions only.</p>

	<p>(iii) This drawing is the property of RPS, it is a project confidential classified document. It must not be copied used or its contents divulged without prior written consent. The needs and expectations of client and RPS must be considered when working with this drawing.</p> <p>(iv) Information including topographical survey, geotechnical investigation and utility detail used in the design have been provided by others.</p> <p>(v) All Levels refer to Ordnance Survey Datum, Main Head.</p>
--	--

Rev	Date	Drawn By	Amendment / Issue	App
S4 P01	08/06/22	PER/DK	Issue for Planning	
S3 P01	27/05/22	PER/DK	Issue for Review and Comment	



Model File Identifier
MCW1088-RPS-00-XX-DR-C-PL0101


Scale	1:2000 @ A1 1:4000 @ A3
Created on	25/05/2022
Sheets	01 of 09

Project	Castlelake SHD
Title	Proposed Public Lighting Infrastructure Key Plan
Status	S4
Rev	P01

REF. No.	SYMBOL	DESCRIPTION
1.		9.5km LED LANTERN POST TOP MOUNTED ON 08m COLUMN.



R:\MCW1088 - BAM Castlelake Residential Dwp18.0 Drawings\PL\MCW1088-RPS-00-XX-DR-C-PL0101.dwg

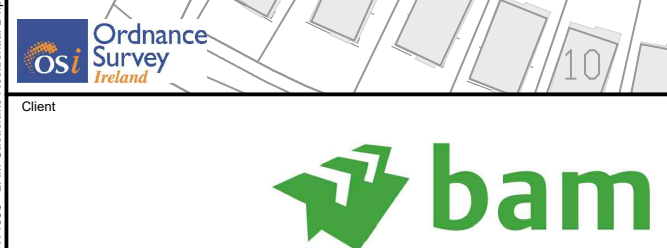

General Notes

(i) Hard copies, dxf and pdf will form a controlled issue of the drawing. All other formats (dwg etc.) are deemed to be an uncontrolled issue and any work carried out based on these files is at the recipient's own risk. RPS will not accept any responsibility for any errors from the use of these files, either by human error or the recipient, listing of the un-dimensioned measurements, compatibility with the recipient's software, and any errors arising when these files are used to aid the recipient's drawing production, or setting out on site.

(ii) DO NOT SCALE, use figured dimensions only.

(iii) This drawing is the property of RPS, it is a project confidential classified document. It must not be copied used or its contents divulged without prior written consent. The needs and expectations of client and RPS must be considered when working with this drawing.

(iv) Information including topographical survey, geotechnical investigation and utility detail used in the design have been provided by others.

(v) All Levels refer to Ordnance Survey Datum, Main Head.

Rev	Date	Dim Ck	Amendment / Issue	App
S4 P01	08/06/22		Issue for Planning	
S3 P01	27/05/22		Issue for Review and Comment	

Model File Identifier
MCW1088-RPS-00-XX-DR-C-PL0101

Scale 1:500 @ A1 1:1000 @ A3	Project Castlelake SHD
Created on 25/05/2022	Title Proposed Public Lighting Infrastructure Lighting Layout (1 of 8)
Sheets 02 of 09	Status S4
File Identifier MCW1088-RPS-00-XX-DR-C-PL0101-02	Rev P01



KEY TO PUBLIC LIGHTING SYMBOLS		
REF. No.	SYMBOL	DESCRIPTION
1.		9.5km LED LANTERN POST TOP MOUNTED ON 08m COLUMN.

R:\MCW1088 - BAM Castlelake Residential Dwp18.0 Drawings\PL\MCW1088-RPS-00-XX-DR-C-PL0101.dwg



Client

General Notes

(i) Hard copies, dwf and pdf will form a controlled issue of the drawing. All other formats (dwg etc.) are deemed to be an uncontrolled issue and any work carried out based on these files is at the recipient's own risk. RPS will not accept any responsibility for any errors from the use of these files, either by human error by the recipient, listing of the un-dimensioned measurements, compatibility with the recipient's software, and any errors arising when these files are used to aid the recipient's drawing production, or setting out on site.

(ii) DO NOT SCALE, use figured dimensions only.

(iii) This drawing is the property of RPS, it is a project confidential classified document. It must not be copied used or its contents divulged without prior written consent. The needs and expectations of client and RPS must be considered when working with this drawing.

(iv) Information including topographical survey, geotechnical investigation and utility detail used in the design have been provided by others.


(v) All Levels refer to Ordnance Survey Datum, Main Head.

Rev	Date	Dim Ck	Amendment / Issue	App
S4 P01	08/06/22		Issue for Planning	
S3 P01	27/05/22		Issue for Review and Comment	

Model File Identifier
MCW1088-RPS-00-XX-DR-C-PL0101

Scale	1:500 @ A1 1:1000 @ A3	Project	Castlelake SHD
Created on	25/05/2022	Title	Proposed Public Lighting Infrastructure Lighting Layout (2 of 8)
Sheets	03 of 09	Status	S4
File Identifier	MCW1088-RPS-00-XX-DR-C-PL0101-03	Rev	P01

KEY TO PUBLIC LIGHTING SYMBOLS		
REF. No.	SYMBOL	DESCRIPTION
1.		9.5km LED LANTERN POST TOP MOUNTED ON 08m COLUMN.

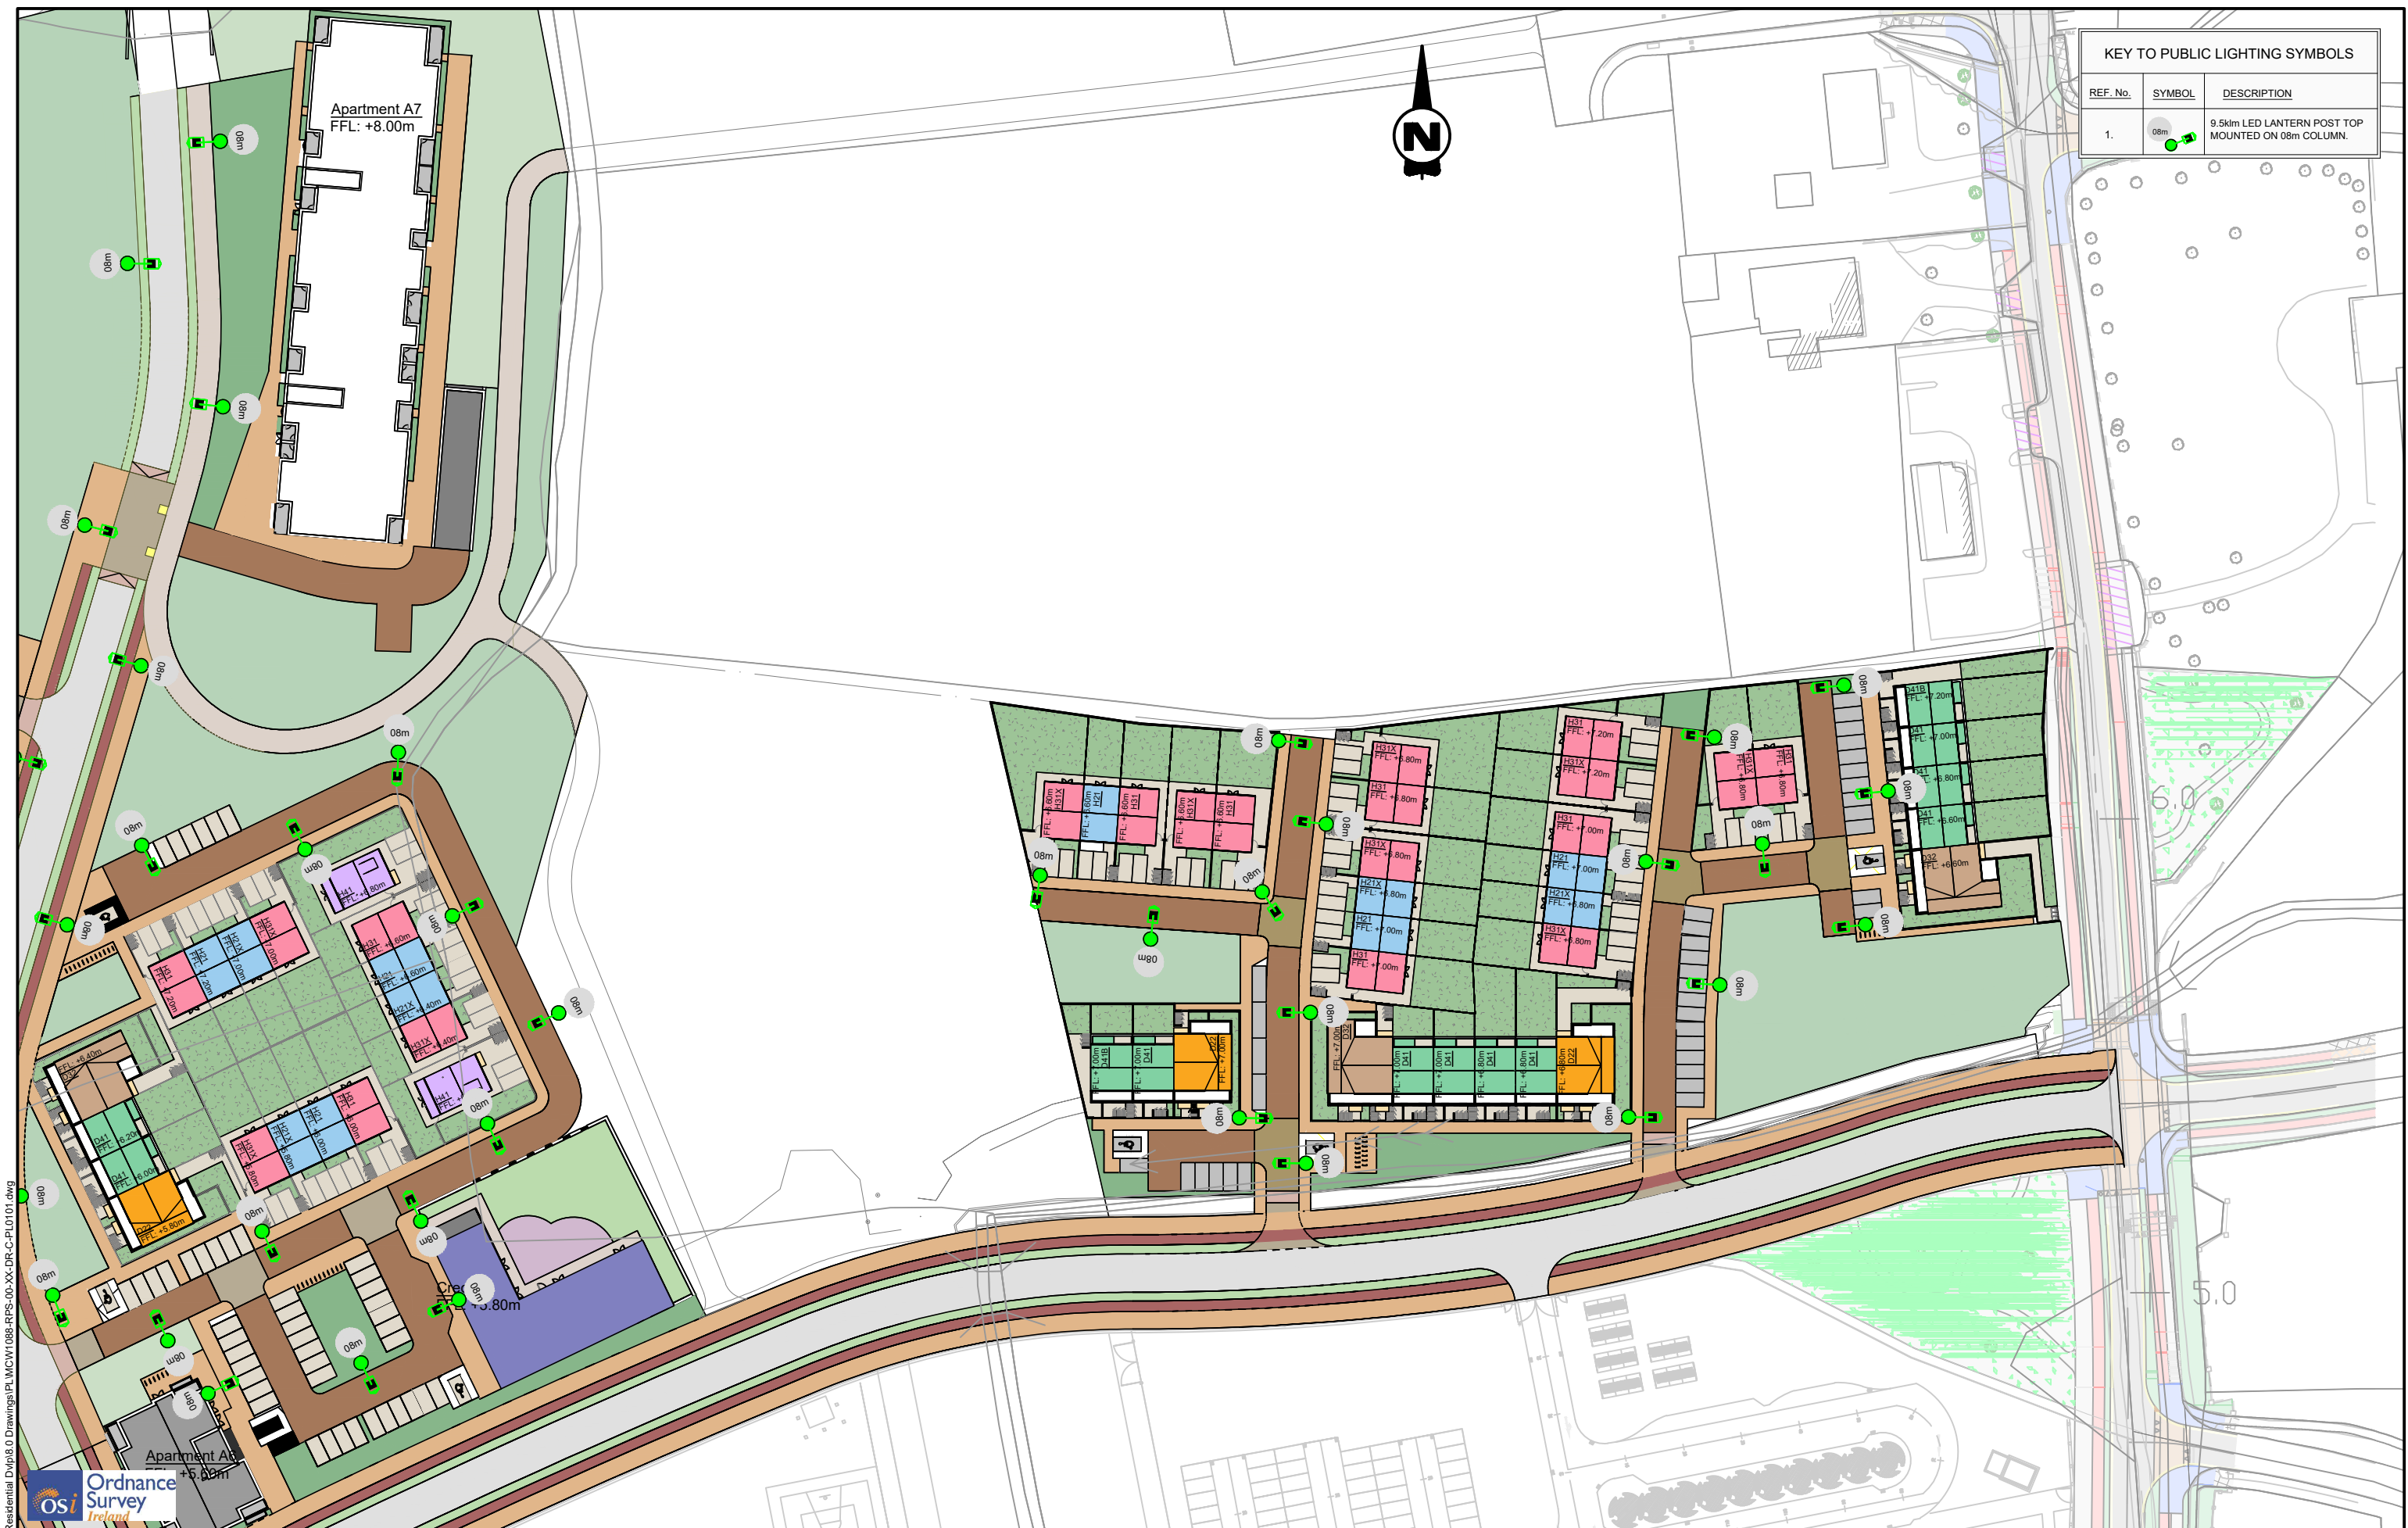

R:\MCW1088 - BAM Castlelake Residential Dwp18.0 Drawings\PL\MCW1088-RPS-00-XX-DR-C-PL0101.dwg



Client	Castlelake Residential SHD
Scale	1:500 @ A1 1:1000 @ A3
Created on	25/05/2022
Sheets	04 of 09
Model File Identifier	MCW1088-RPS-00-XX-DR-C-PL0101
File Identifier	MCW1088-RPS-00-XX-DR-C-PL0101-04
Status	S4
Rev	P01

Rev	Date	Dim Chk	Amendment / Issue	App
S4	08/06/22	DRG	Issue for Planning	DRG
S3	27/05/22	DRG	Issue for Review and Comment	DRG

General Notes

(i) Hard copies, dwf and pdf will form a controlled issue of the drawing. All other formats (dwg etc.) are deemed to be an uncontrolled issue and any work carried out based on these files is at the recipient's own risk. RPS will not accept any responsibility for any errors from the use of these files, either by human error by the recipient, listing of the un-dimensioned measurements, compatibility with the recipient's software, and any errors arising when these files are used to aid the recipient's drawing production, or setting out on site.

(ii) DO NOT SCALE, use figured dimensions only.


(iii) This drawing is the property of RPS, it is a project confidential classified document. It must not be copied used or its contents divulged without prior written consent. The needs and expectations of client and RPS must be considered when working with this drawing.

(iv) Information including topographical survey, geotechnical investigation and utility detail used in the design have been provided by others.

(v) All Levels refer to Ordnance Survey Datum, Malin Head.



KEY TO PUBLIC LIGHTING SYMBOLS		
REF. No.	SYMBOL	DESCRIPTION
1.		9.5m LED LANTERN POST TOP MOUNTED ON 0.8m COLUMN.

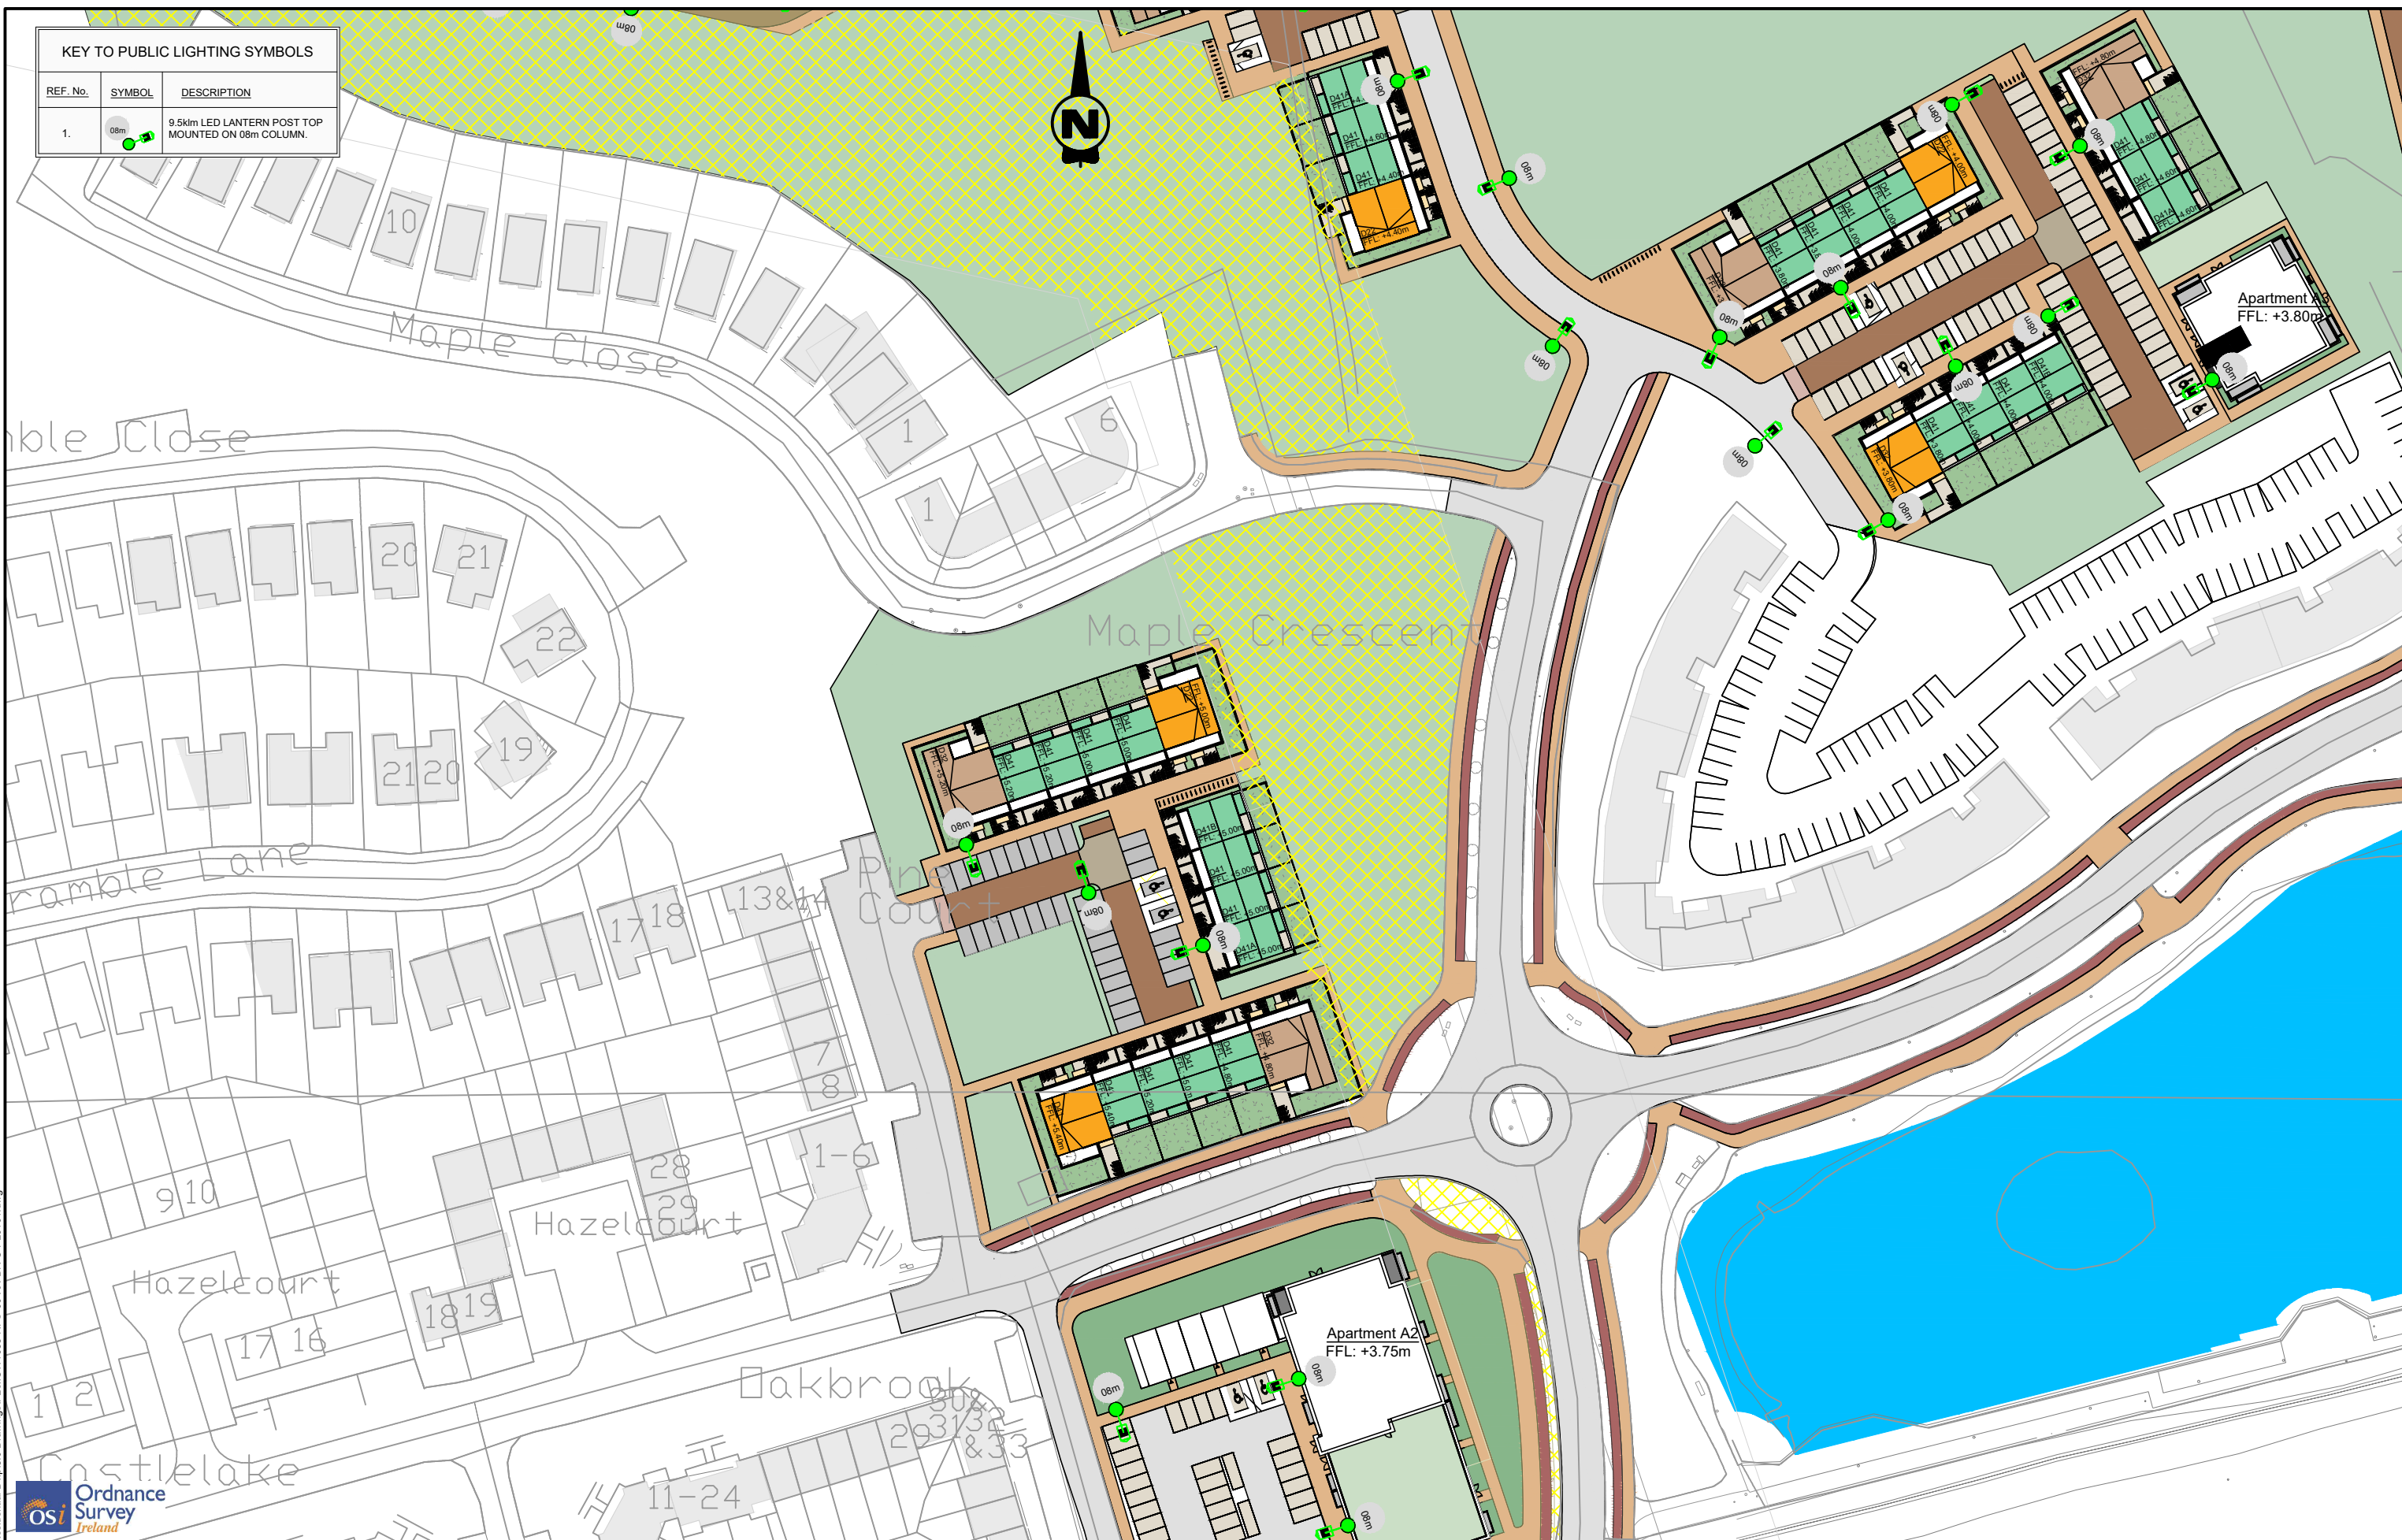

R:\MCW1088 - BAM Castlelake Residential Dwp18.0 Drawings\PL\MCW1088-RPS-00-XX-DR-C-PL0101.dwg



General Notes

(i) Hard copies, dxf and pdf will form a controlled issue of the drawing. All other formats (dwg etc.) are deemed to be an uncontrolled issue and any work carried out based on these files is at the recipient's own risk. RPS will not accept any responsibility for any errors from the use of these files, either by human error or by the recipient, listing of the un-dimensioned measurements, compatibility with the recipient's software, and any errors arising when these files are used to aid the recipient's drawing production, or setting out on site.


(ii) DO NOT SCALE, use figured dimensions only.

(iii) This drawing is the property of RPS, it is a project confidential classified document. It must not be copied used or its contents divulged without prior written consent. The needs and expectations of client and RPS must be considered when working with this drawing.

(iv) Information including topographical survey, geotechnical investigation and utility detail used in the design have been provided by others.


(v) All Levels refer to Ordnance Survey Datum, Main Head.


Rev	Date	Dim Ck	Amendment / Issue	App
S4 P01	08/06/22		Issue for Planning	
S3 P01	27/05/22		Issue for Review and Comment	



Model File Identifier
MCW1088-RPS-00-XX-DR-C-PL0101

Scale	1:500 @ A1 1:1000 @ A3	Project	Castlelake SHD
Created on	25/05/2022	Title	Proposed Public Lighting Infrastructure Lighting Layout (4 of 8)
Sheets	05 of 09	Status	S4
File Identifier	MCW1088-RPS-00-XX-DR-C-PL0101-05	Rev	P01

KEY TO PUBLIC LIGHTING SYMBOLS		
REF. No.	SYMBOL	DESCRIPTION
1.		9.5km LED LANTERN POST TOP MOUNTED ON 08m COLUMN.

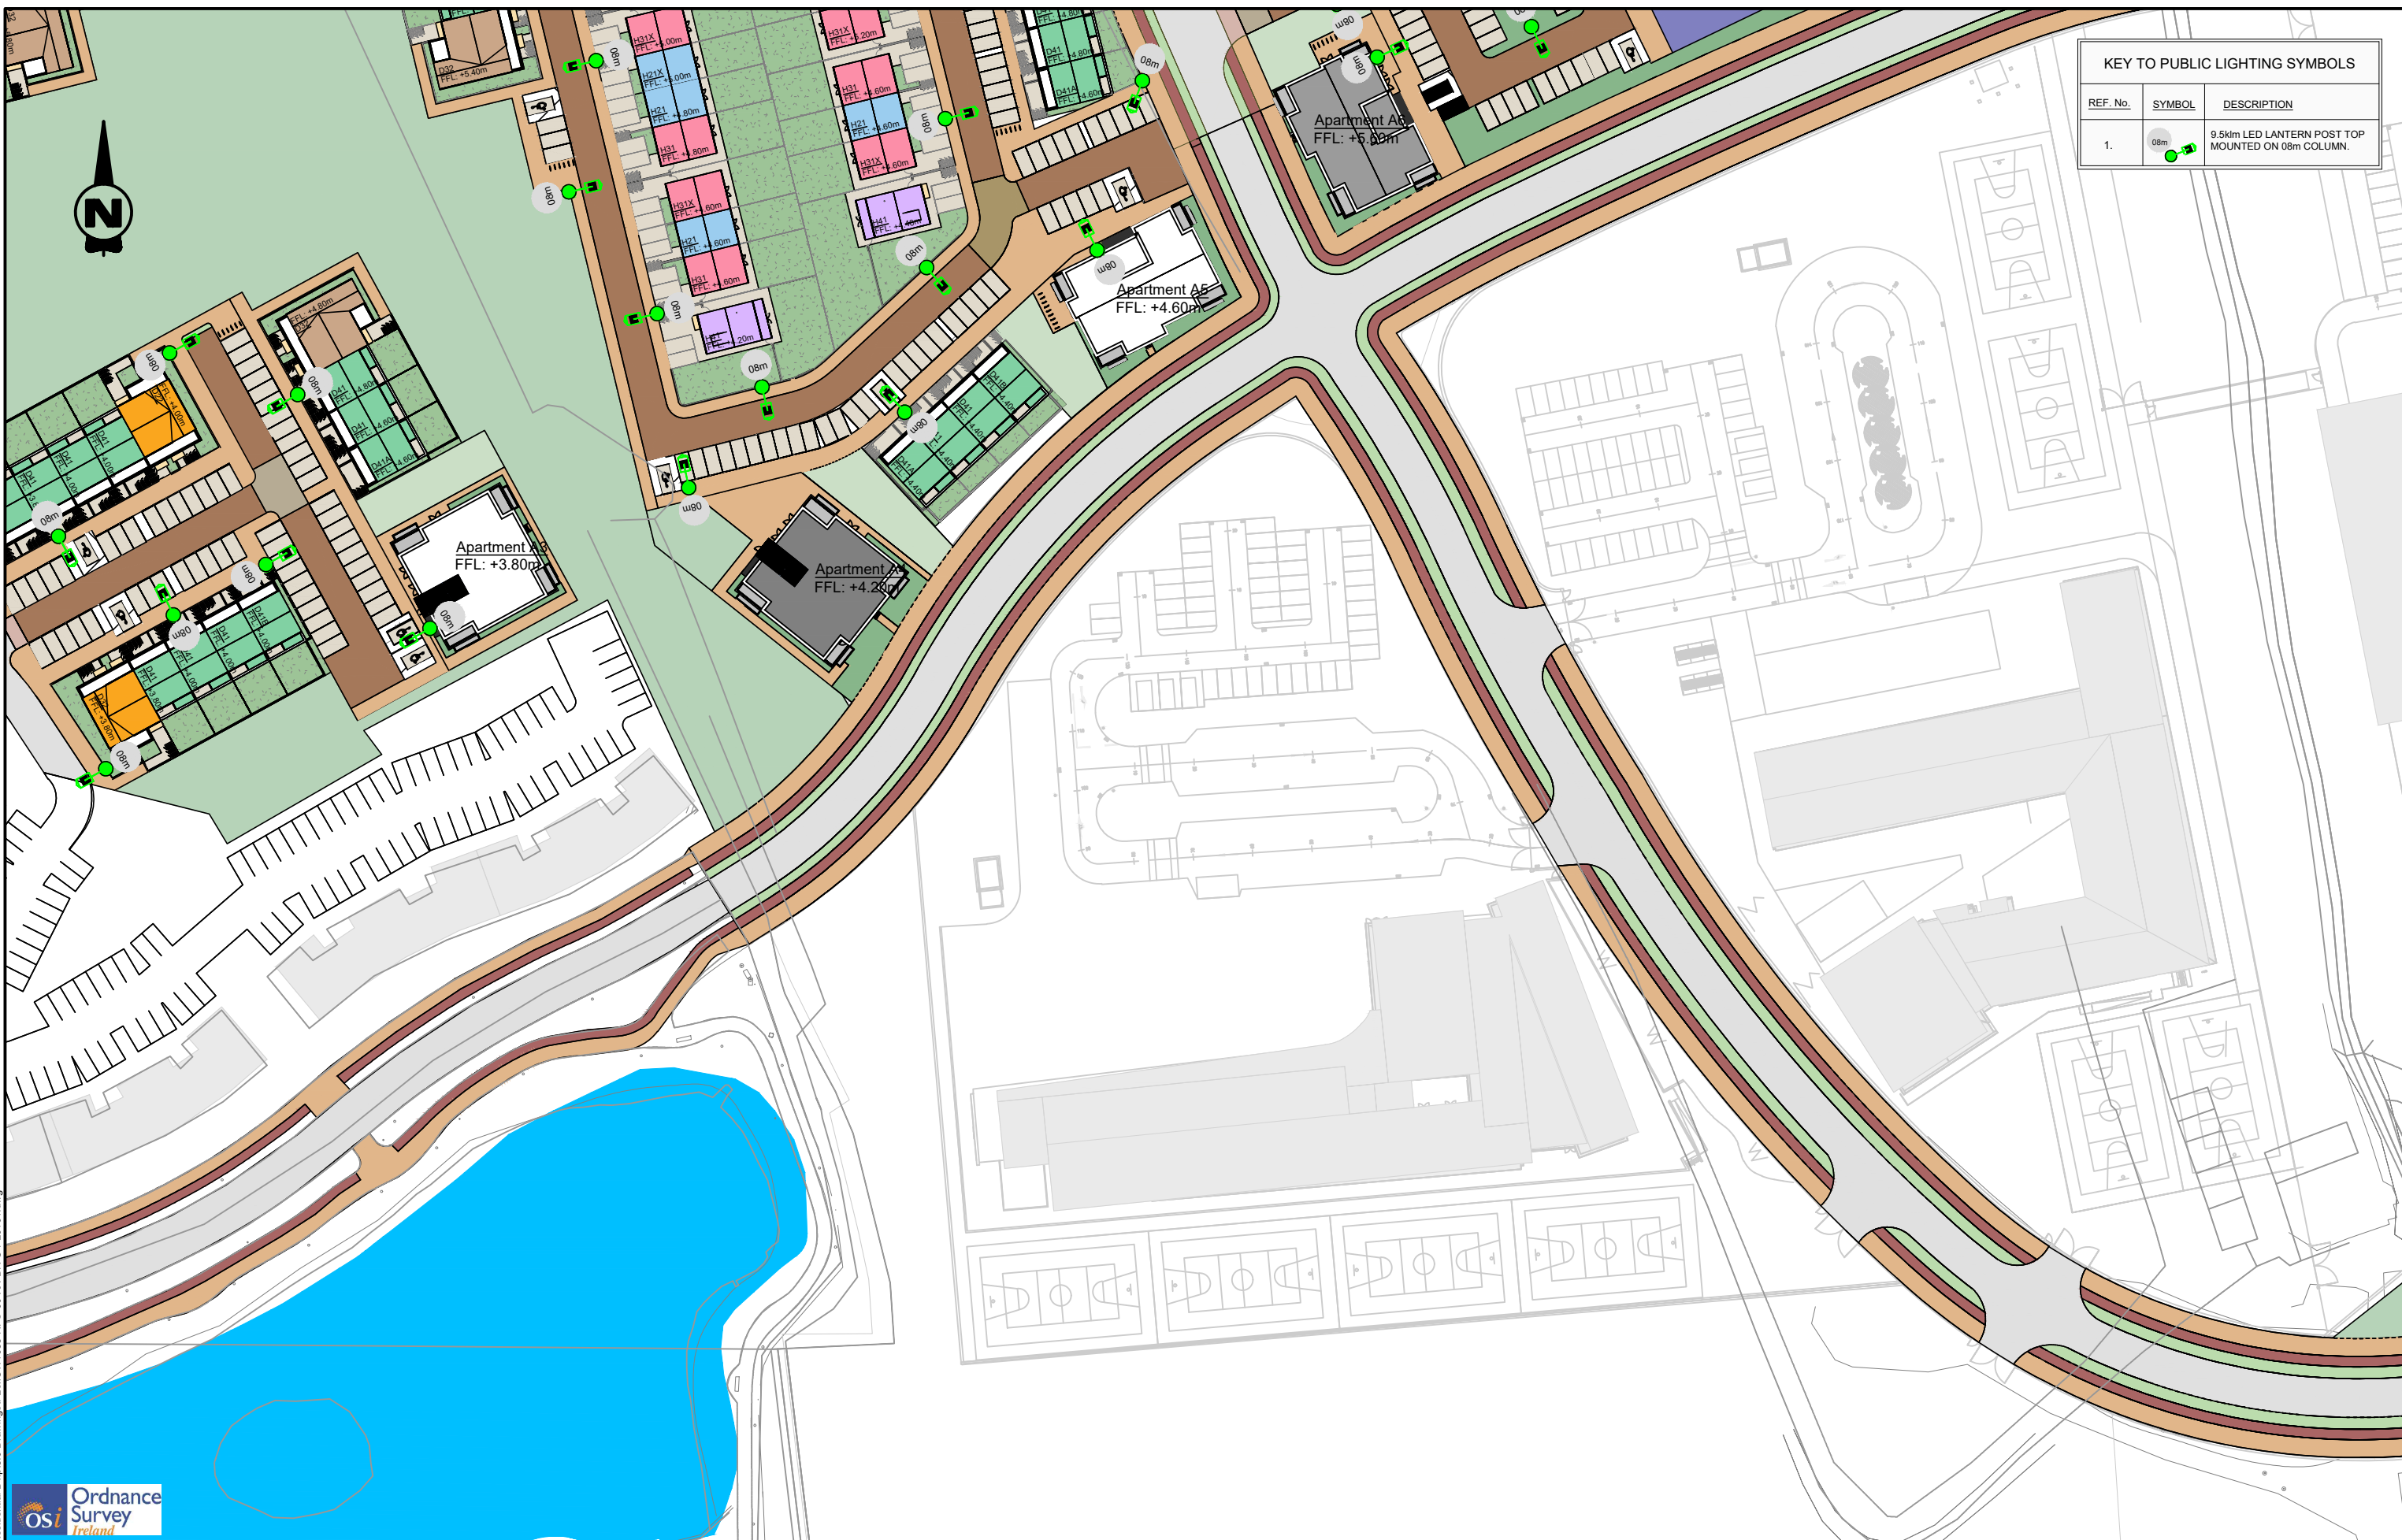

Client




General Notes



 
 
(i) Hard copies, dwf and pdf will form a controlled issue of the drawing. All other formats (dwg etc.) are deemed to be an uncontrolled issue and any work carried out based on these files is at the recipient's own risk. RPS will not accept any responsibility for any errors from the use of these files, either by human error or by the recipient, listing of the un-dimensioned measurements, compatibility with the recipient's software, and any errors arising when these files are used to aid the recipient's drawing production, or setting out on site.


(ii) DO NOT SCALE, use figured dimensions only.

(iii) This drawing is the property of RPS, it is a project confidential classified document. It must not be copied used or its contents divulged without prior written consent. The needs and expectations of client and RPS must be considered when working with this drawing.

(iv) Information including topographical survey, geotechnical investigation and utility detail used in the design have been provided by others.

(v) All Levels refer to Ordnance Survey Datum, Malin Head.


Rev	Date	Dim Ck	Amendment / Issue	App
S4 P01	08/06/22		Issue for Planning	
S3 P01	27/05/22		Issue for Review and Comment	



Model File Identifier
MCW1088-RPS-00-XX-DR-C-PL0101

Scale 1:500 @ A1 1:1000 @ A3	Project Castlelake SHD
Created on 25/05/2022	Title Proposed Public Lighting Infrastructure Lighting Layout (5 of 8)
Sheets 06 of 09	Status S4
File Identifier MCW1088-RPS-00-XX-DR-C-PL0101-06	Rev P01

R:\MCW1088 - BAM Castlelake Residential D\p18.0 Drawings\PL\MCW1088-RPS-00-XX-DR-C-PL0101.dwg

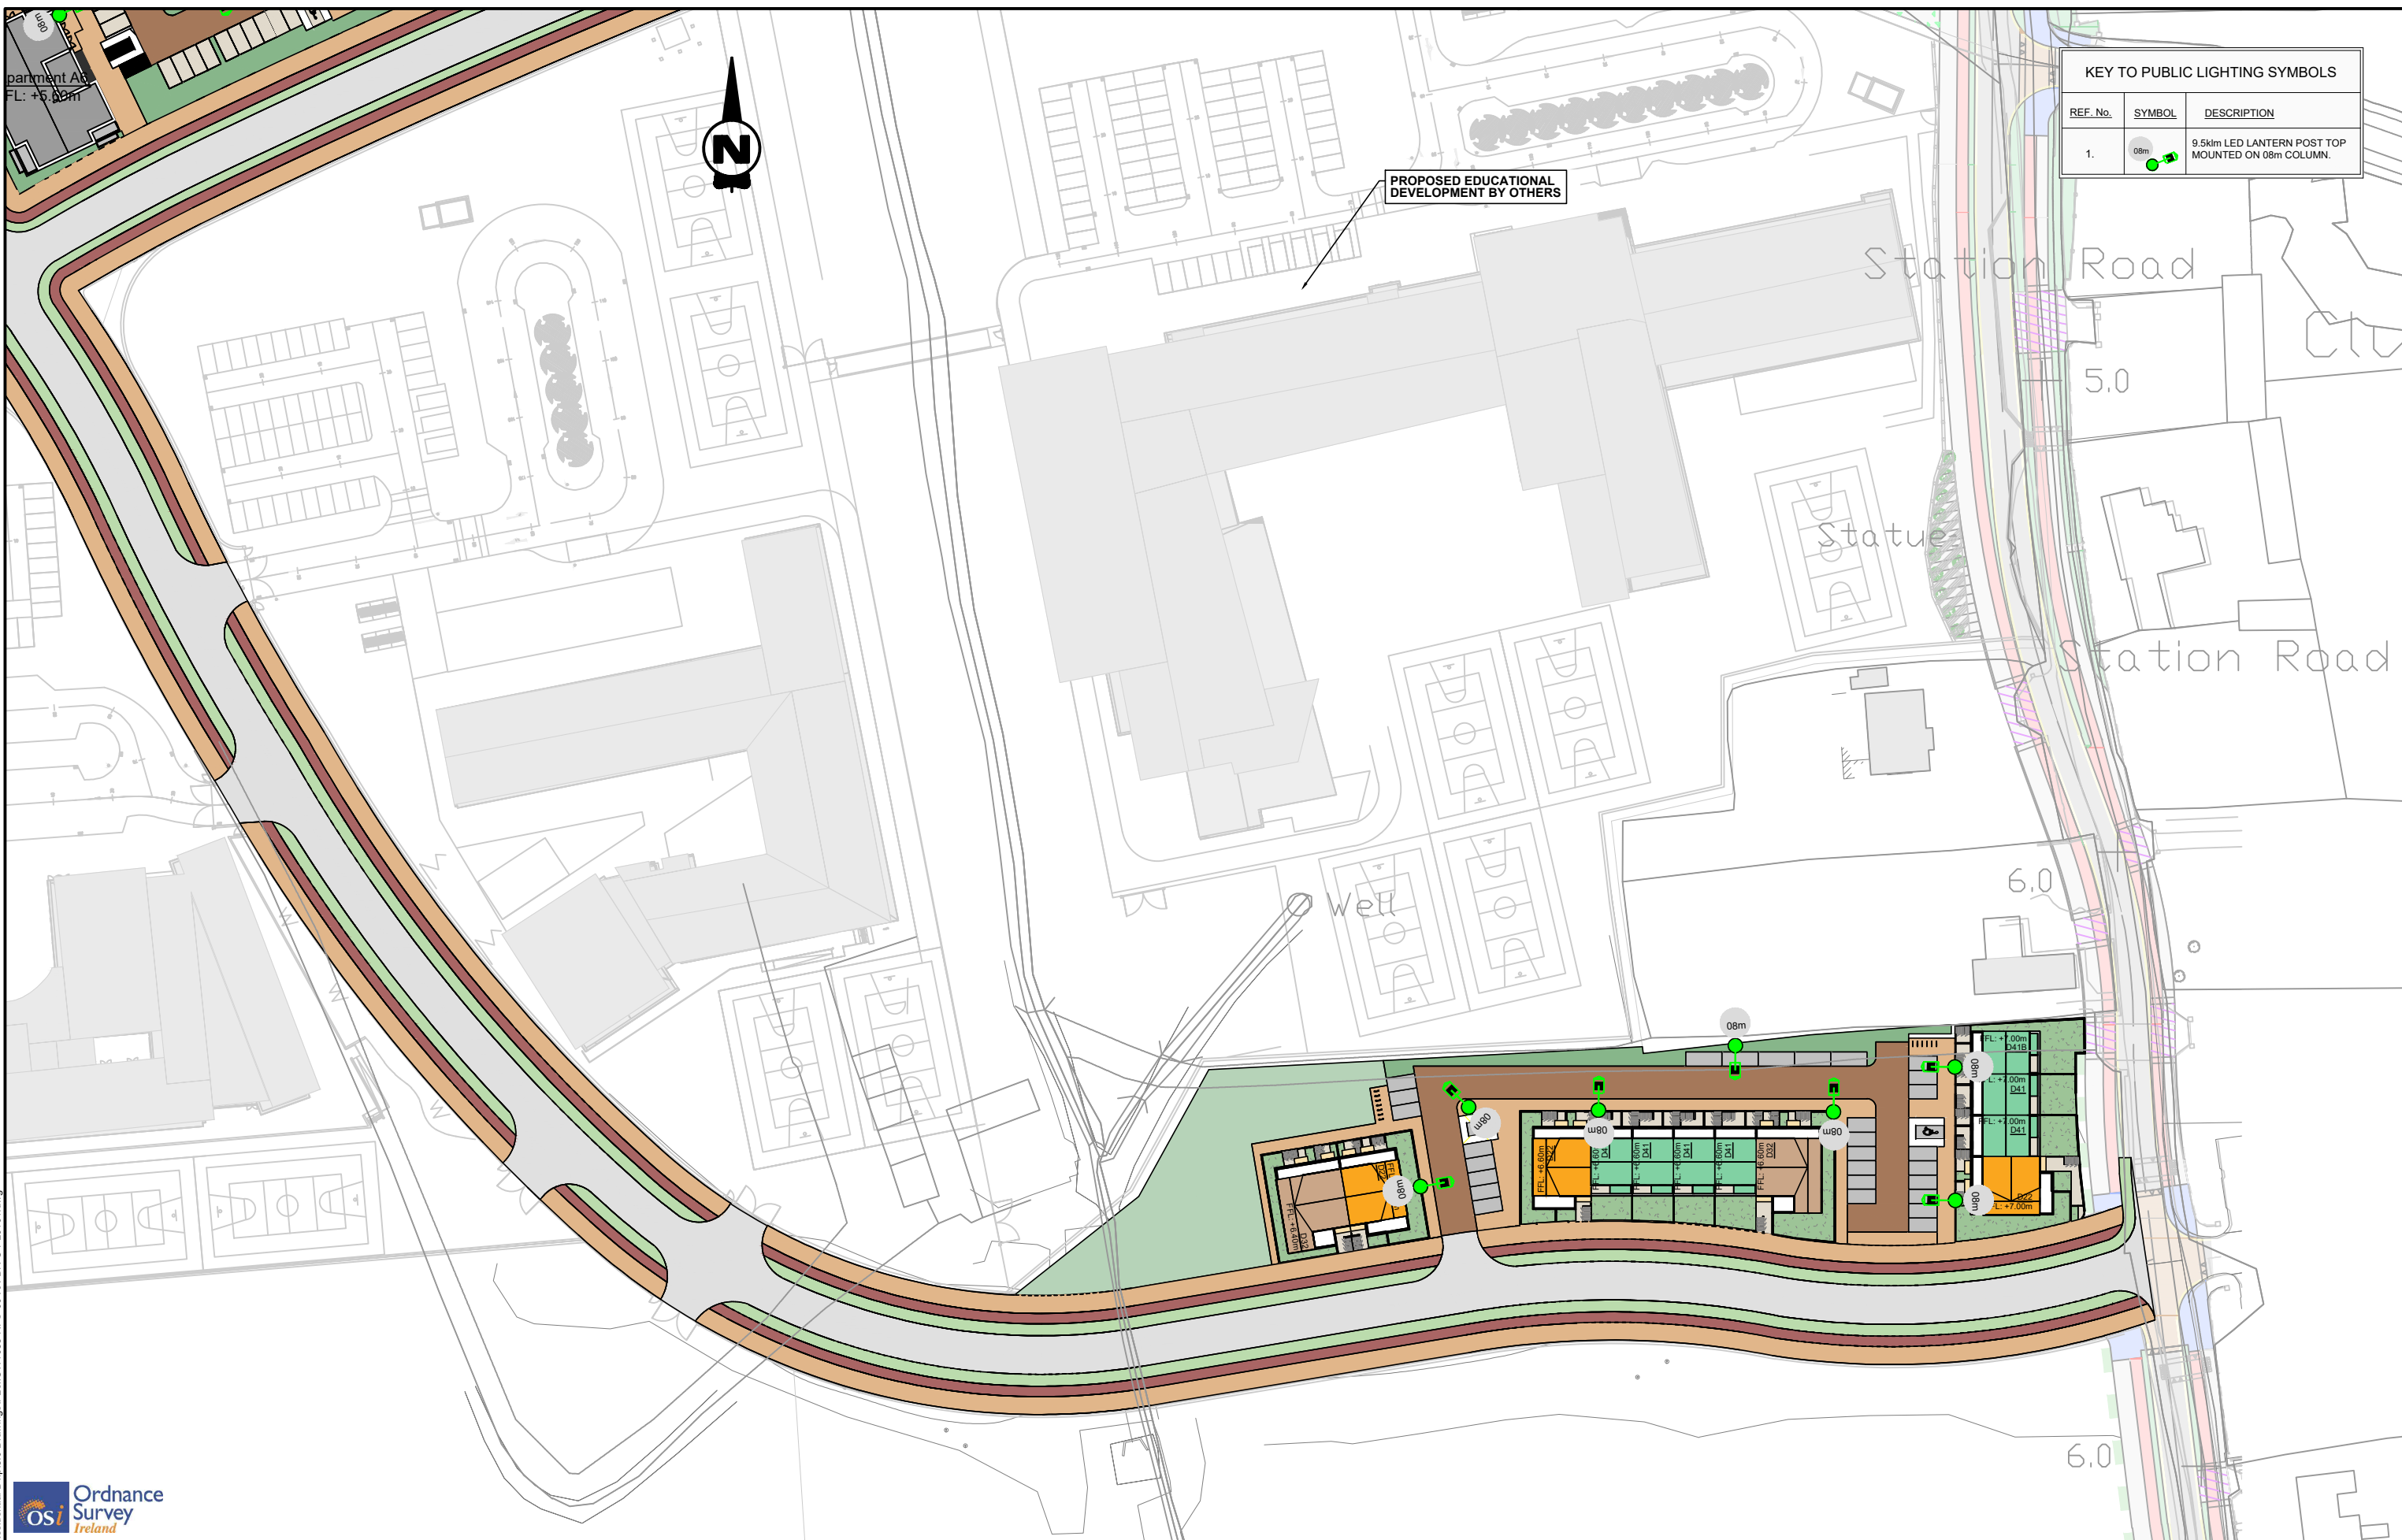

KEY TO PUBLIC LIGHTING SYMBOLS		
REF. No.	SYMBOL	DESCRIPTION
1.		9.5km LED LANTERN POST TOP MOUNTED ON 08m COLUMN.



General Notes

(i) Hard copies, dwf and pdf will form a controlled issue of the drawing. All other formats (dwg etc.) are deemed to be an uncontrolled issue and any work carried out based on these files is at the recipients own risk. RPS will not accept any responsibility for any errors from the use of these files, either by human error by the recipient, listing of the un-dimensioned measurements, compatibility with the recipients software, and any errors arising when these files are used to aid the recipients drawing production, or setting out on site.

(ii) DO NOT SCALE, use figured dimensions only.

(iii) This drawing is the property of RPS, it is a project confidential classified document. It must not be copied used or its contents divulged without prior written consent. The needs and expectations of client and RPS must be considered when working with this drawing.

(iv) Information including topographical survey, geotechnical investigation and utility detail used in the design have been provided by others.

(v) All Levels refer to Ordnance Survey Datum, Malin Head.

Rev	Date	Dim Ck	Amendment / Issue	App
S4 P01	08/06/22		Issue for Planning	
S3 P01	27/05/22		Issue for Review and Comment	

Model File Identifier
MCW1088-RPS-00-XX-DR-C-PL0101


Scale
1:500 @ A1
1:1000 @ A3

Created on
25/05/2022

Sheets
07 of 09

Client	Castlelake SHD
Project	Proposed Public Lighting Infrastructure Lighting Layout (6 of 8)
File Identifier	MCW1088-RPS-00-XX-DR-C-PL0101-07
Status	S4
Rev	P01

R:\MCW1088 - BAM Castlelake Residential D\p18.0 Drawings\PL\MCW1088-RPS-00-XX-DR-C-PL0101.dwg

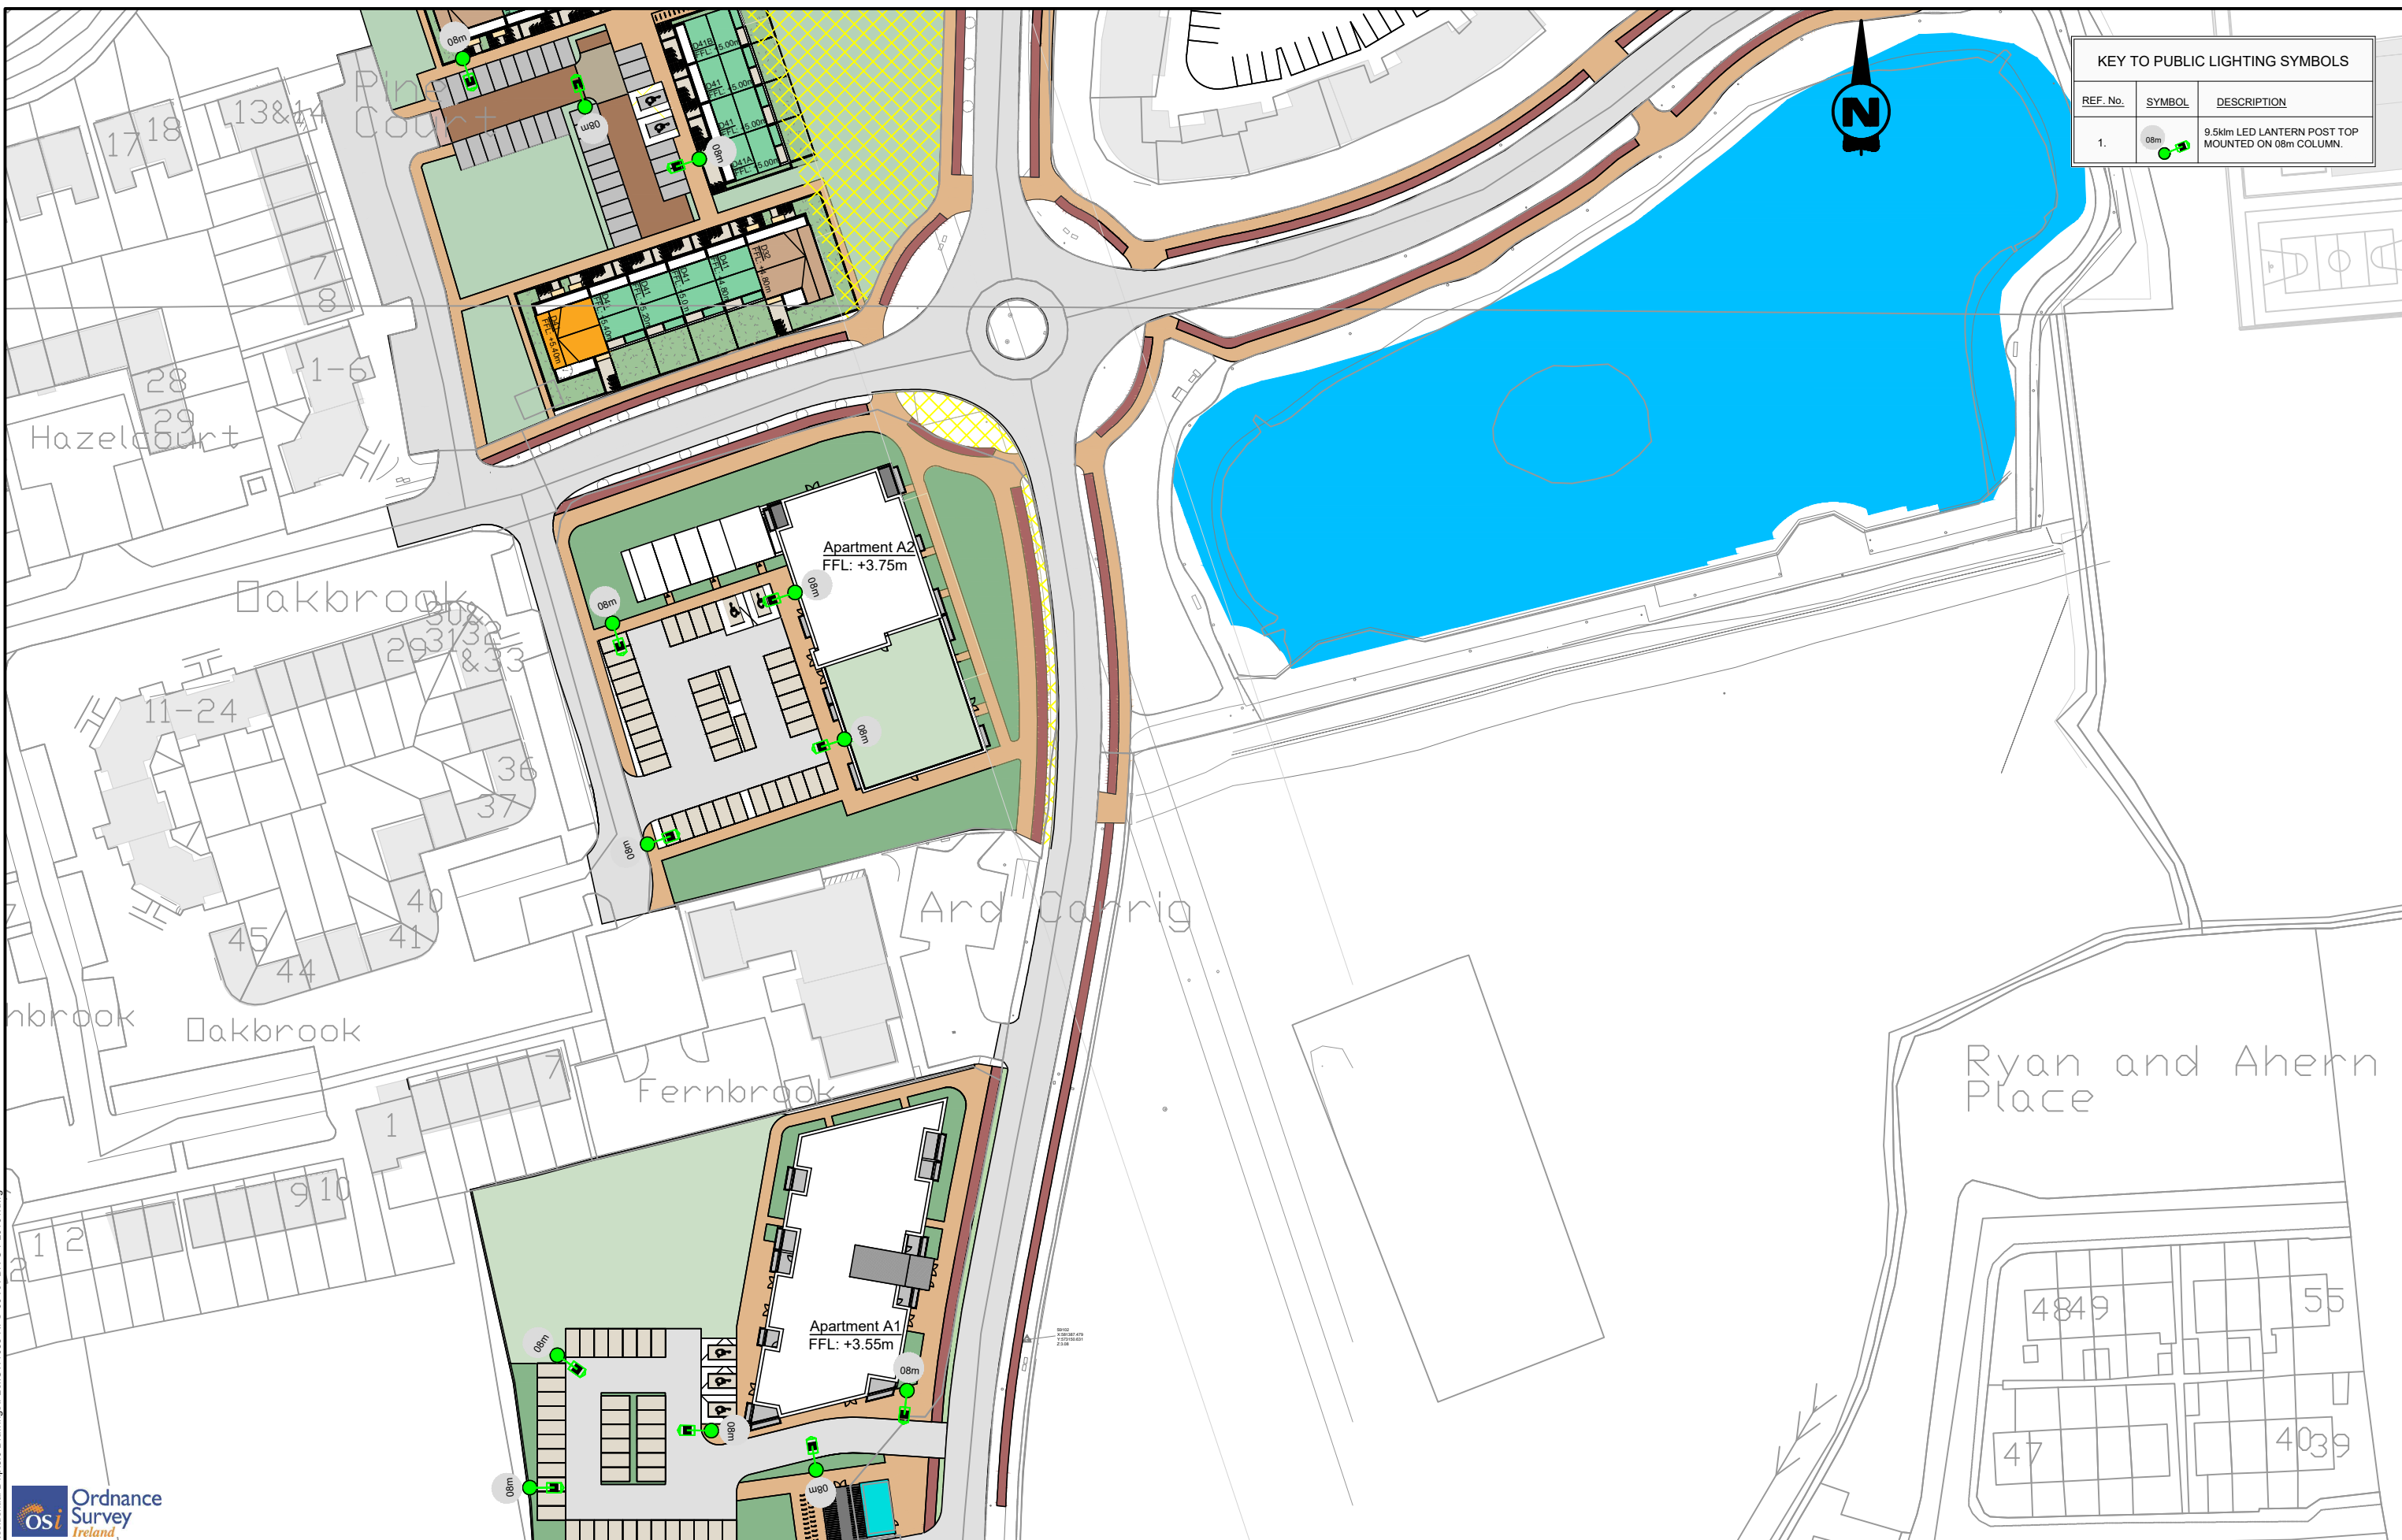

KEY TO PUBLIC LIGHTING SYMBOLS		
REF. No.	SYMBOL	DESCRIPTION
1.		9.5km LED LANTERN POST TOP MOUNTED ON 08m COLUMN.

R:\MCW1088 - BAM Castlelake Residential Dwp18.0 Drawings\PL\MCW1088-RPS-00-XX-DR-C-PL0101.dwg




Client	General Notes
	(i) Hard copies, dwf and pdf will form a controlled issue of the drawing. All other formats (dwg etc.) are deemed to be an uncontrolled issue and any work carried out based on these files is at the recipient's own risk. RPS will not accept any responsibility for any errors from the use of these files, either by human error by the recipient, listing of the un-dimensioned measurements, compatibility with the recipient's software, and any errors arising when these files are used to aid the recipient's drawing production, or setting out on site.
	(ii) DO NOT SCALE, use figured dimensions only.
	(iii) This drawing is the property of RPS, it is a project confidential classified document. It must not be copied used or its contents divulged without prior written consent. The needs and expectations of client and RPS must be considered when working with this drawing.
	(iv) Information including topographical survey, geotechnical investigation and utility detail used in the design have been provided by others.
	(v) All Levels refer to Ordnance Survey Datum, Malin Head.

S4 P01	08/06/22	DR	Issue for Planning	
S3 P01	27/05/22	DR	Issue for Review and Comment	
Rev	Date	Dim Chk	Amendment / Issue	App



Model File Identifier	MCW1088-RPS-00-XX-DR-C-PL0101	Scale	1:500 @ A1 1:1000 @ A3	Project	Castelake SHD
File Identifier	MCW1088-RPS-00-XX-DR-C-PL0101-08	Created on	25/05/2022	Title	Proposed Public Lighting Infrastructure Lighting Layout (7 of 8)
Status	S4	Sheets	08 of 09	Rev	P01

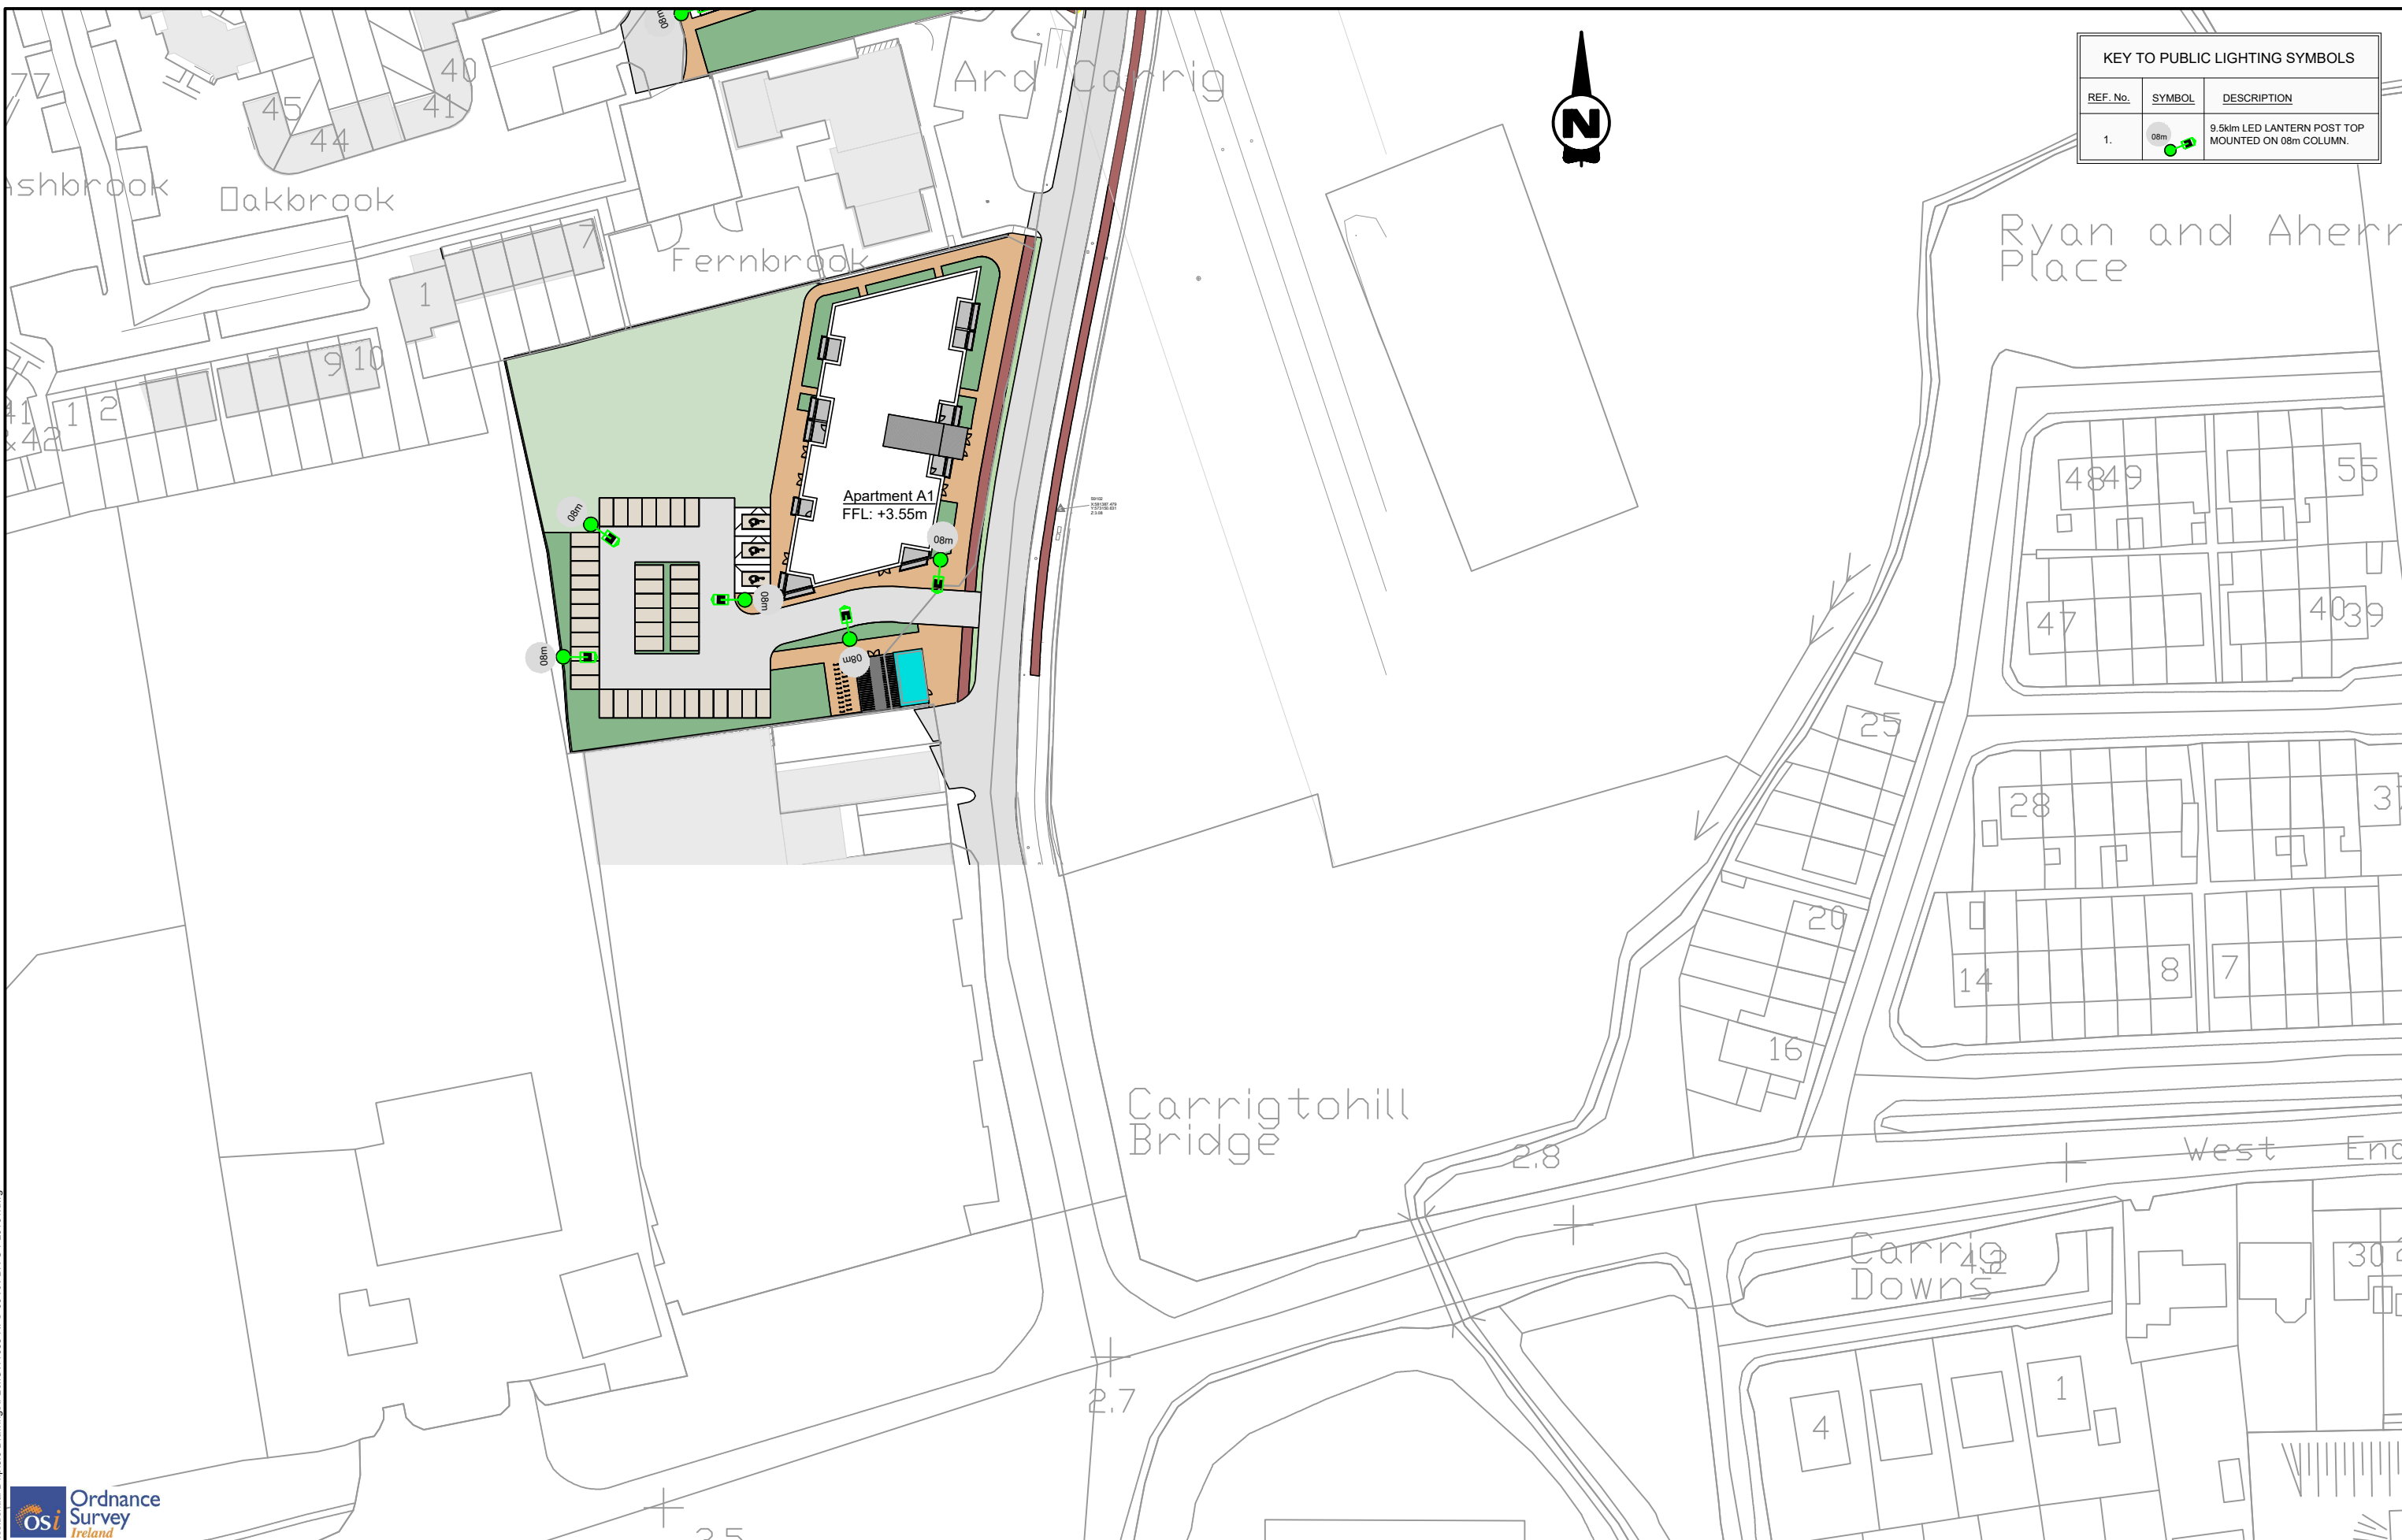

KEY TO PUBLIC LIGHTING SYMBOLS		
REF. No.	SYMBOL	DESCRIPTION
1.		9.5km LED LANTERN POST TOP MOUNTED ON 08m COLUMN.



General Notes

(i) Hard copies, dwf and pdf will form a controlled issue of the drawing. All other formats (dwg etc.) are deemed to be an uncontrolled issue and any work carried out based on these files is at the recipient's own risk. RPS will not accept any responsibility for any errors from the use of these files, either by human error by the recipient, listing of the un-dimensioned measurements, compatibility with the recipient's software, and any errors arising when these files are used to aid the recipient's drawing production, or setting out on site.

(ii) DO NOT SCALE, use figured dimensions only.

(iii) This drawing is the property of RPS, it is a project confidential classified document. It must not be copied used or its contents divulged without prior written consent. The needs and expectations of client and RPS must be considered when working with this drawing.

(iv) Information including topographical survey, geotechnical investigation and utility detail used in the design have been provided by others.

(v) All Levels refer to Ordnance Survey Datum, Main Head.

Rev	Date	Dim Ck	Amendment / Issue	App
S4 P01	08/06/22		Issue for Planning	
S3 P01	27/05/22		Issue for Review and Comment	

Model File Identifier
MCW1088-RPS-00-XX-DR-C-PL0101

Scale 1:500 @ A1 1:1000 @ A3	Project Castlelake SHD
Created on 25/05/2022	Title Proposed Public Lighting Infrastructure Lighting Layout (8 of 8)
Sheets 09 of 09	Status S4
File Identifier MCW1088-RPS-00-XX-DR-C-PL0101-09	Rev P01

R:\MCW1088 - BAM Castlelake Residential Dwp\8.0 Drawings\PL\MCW1088-RPS-00-XX-DR-C-PL0101.dwg