




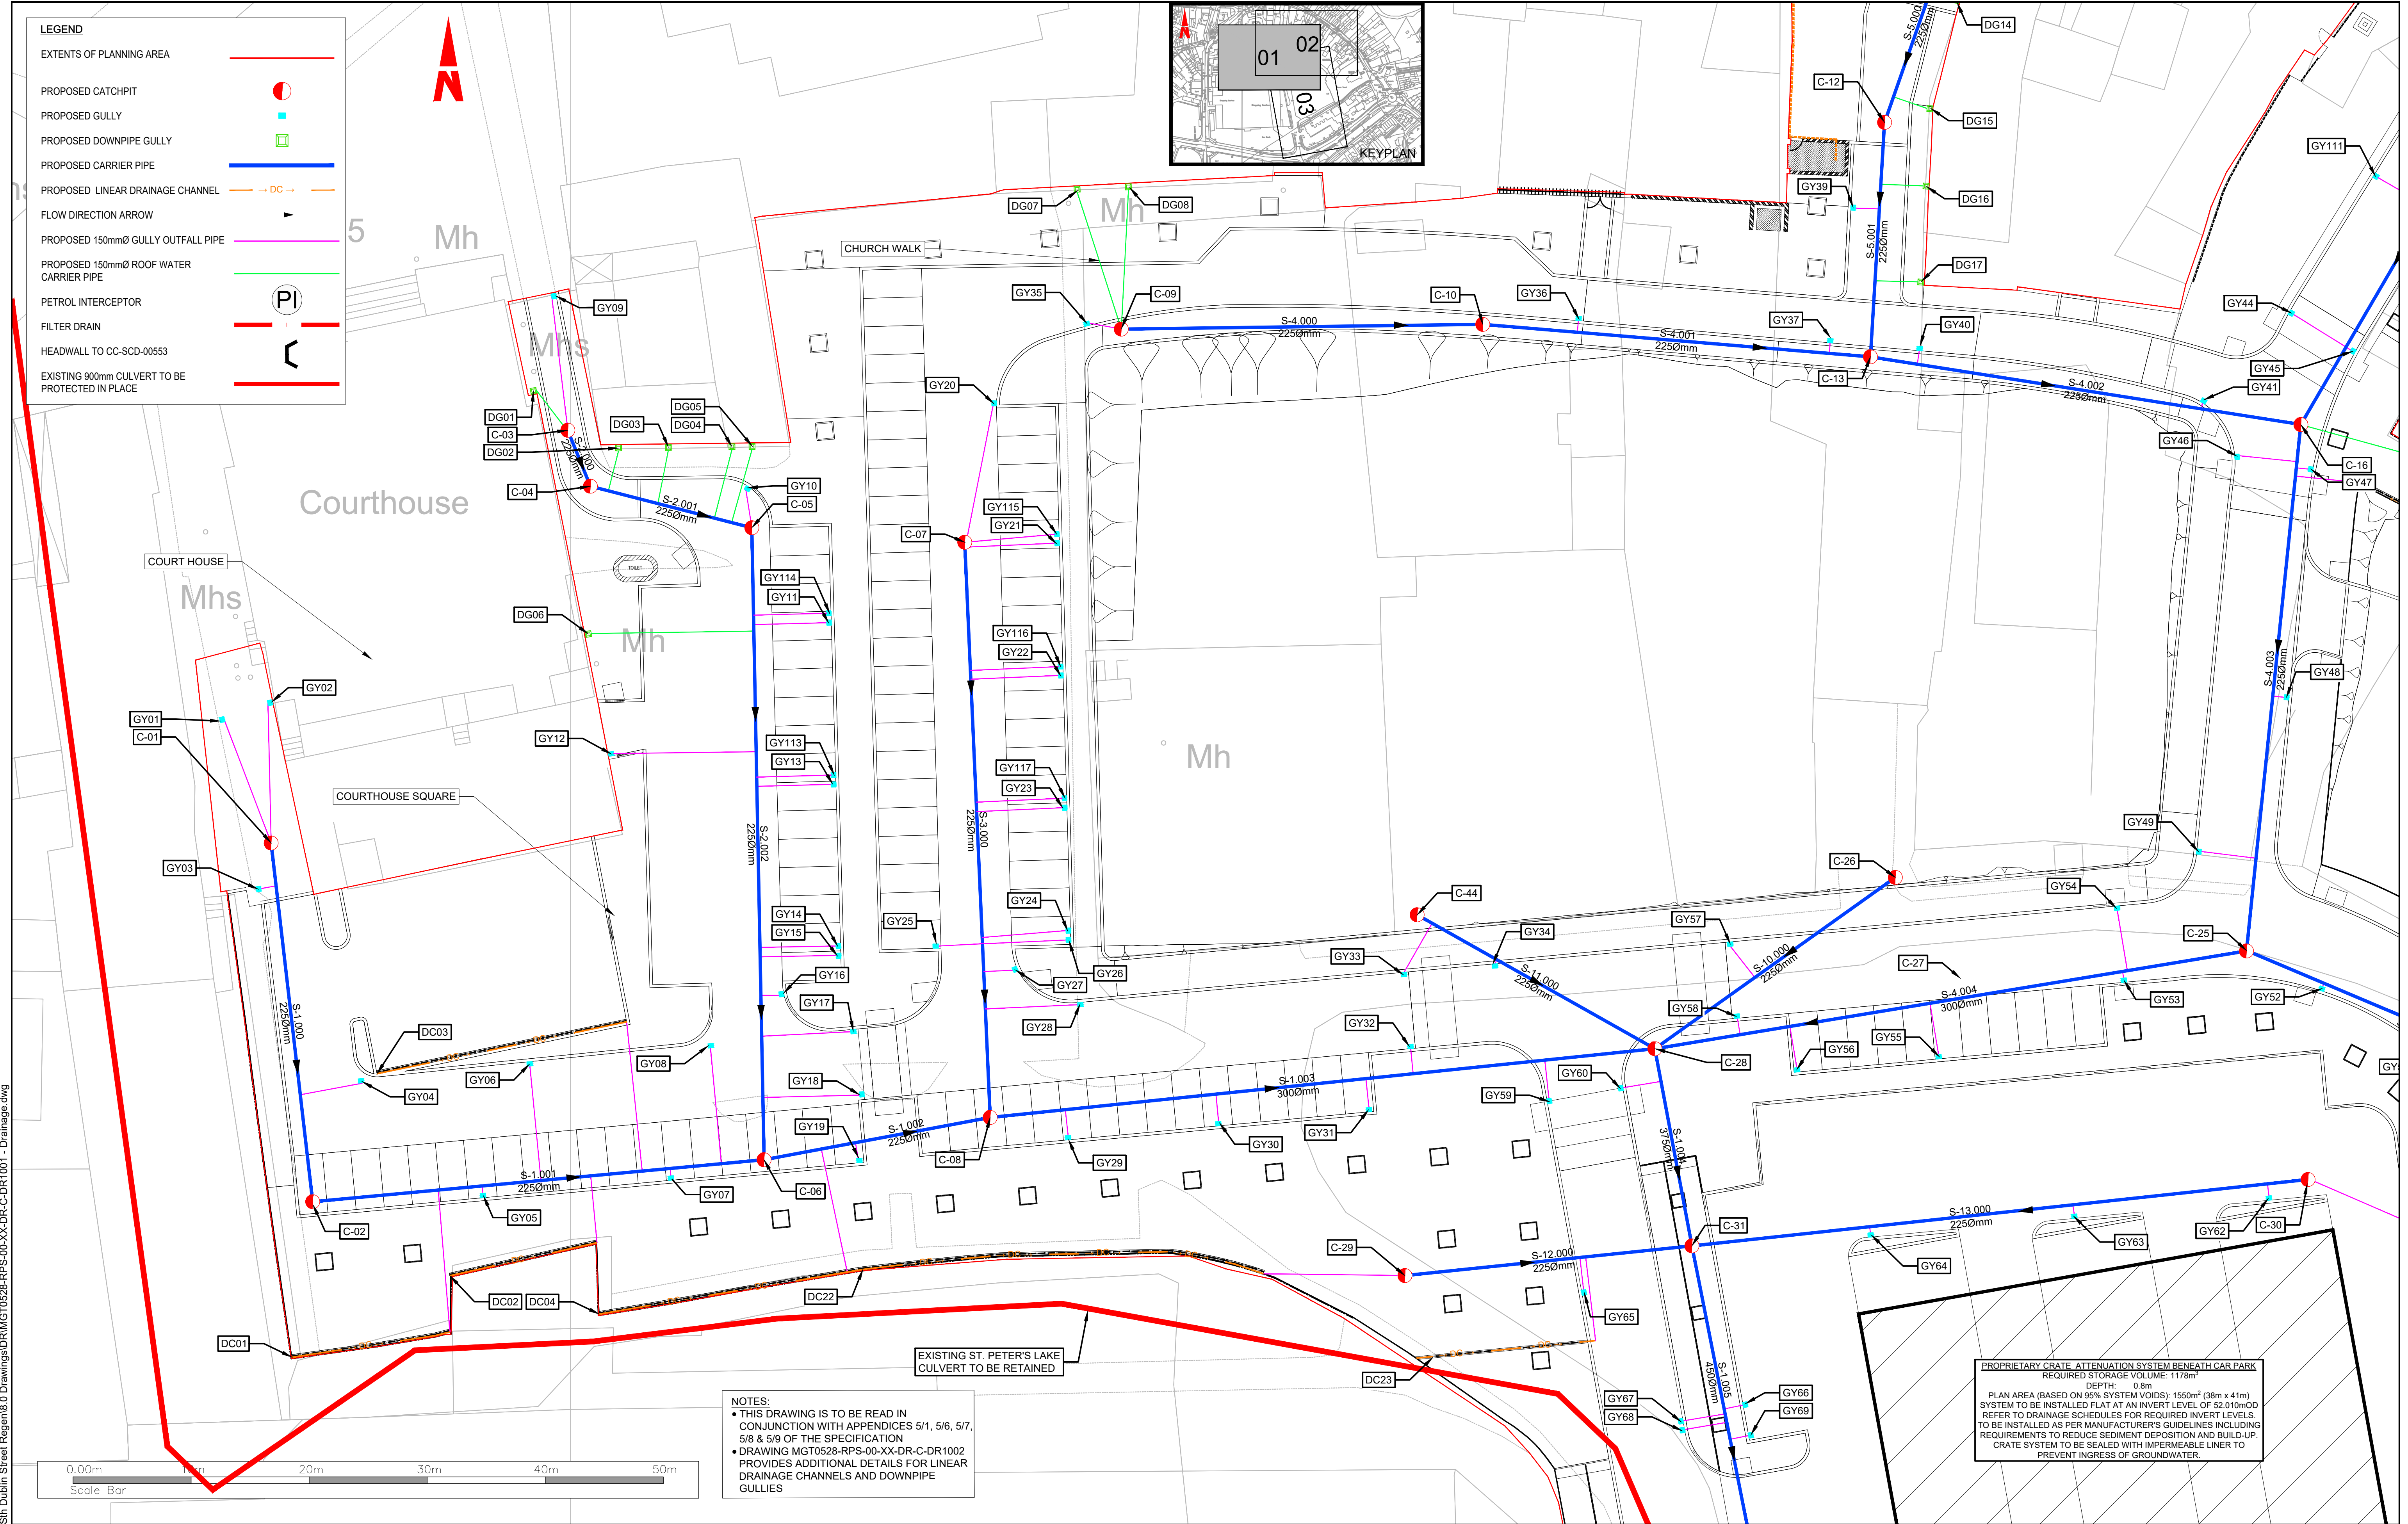

Client		General Notes		(iii) This drawing is the property of RPS, it is a project confidential classified document. It must not be copied used or its contents divulged without prior written consent. The needs and expectations of client and RPS must be considered when working with this drawing.		(iv) Information including topographical survey, geotechnical investigation and utility detail used in the design have been provided by others.		(v) All Levels refer to Ordnance Survey Datum, Malin Head.		P05 25.07.22 Enk MF PLANNING MF		P04 26.05.22 MF MF DETAIL DESIGN MF		P03 23.05.22 MG Enk MF DETAIL DESIGN MF		P02 08.03.22 MG Enk RS DETAIL DESIGN RS		Rev Date Dm App		Model File Identifier N/A		Scale 1:250 @ A1 1:500 @ A3		Project MONAGHAN TOWN - DUBLIN STREET REGENERATION PROJECT		Title DRAINAGE LAYOUT		File Identifier MGT0528-RPS-00-XX-DR-C-DR1001		Drawing No. DR1001		Status S4		Rev P05	
Comhairle Contae Mhuineacháin Monaghan County Council		(i) Hard copies, dwf and pdf will form a controlled issue of the drawing. All other formats (dwg etc.) are deemed to be an uncontrolled issue and any work carried out based on these files is at the recipients own risk. RPS will not accept any responsibility for any errors from the use of these files, either by human error by the recipient, listing of the un-dimensioned measurements, compatibility with the recipients software, and any errors arising when these files are used to aid the recipients drawing production, or setting out on site.		(ii) DO NOT SCALE, use figured dimensions only.																		Created on APRIL 2021		Sheets 01 of 03											

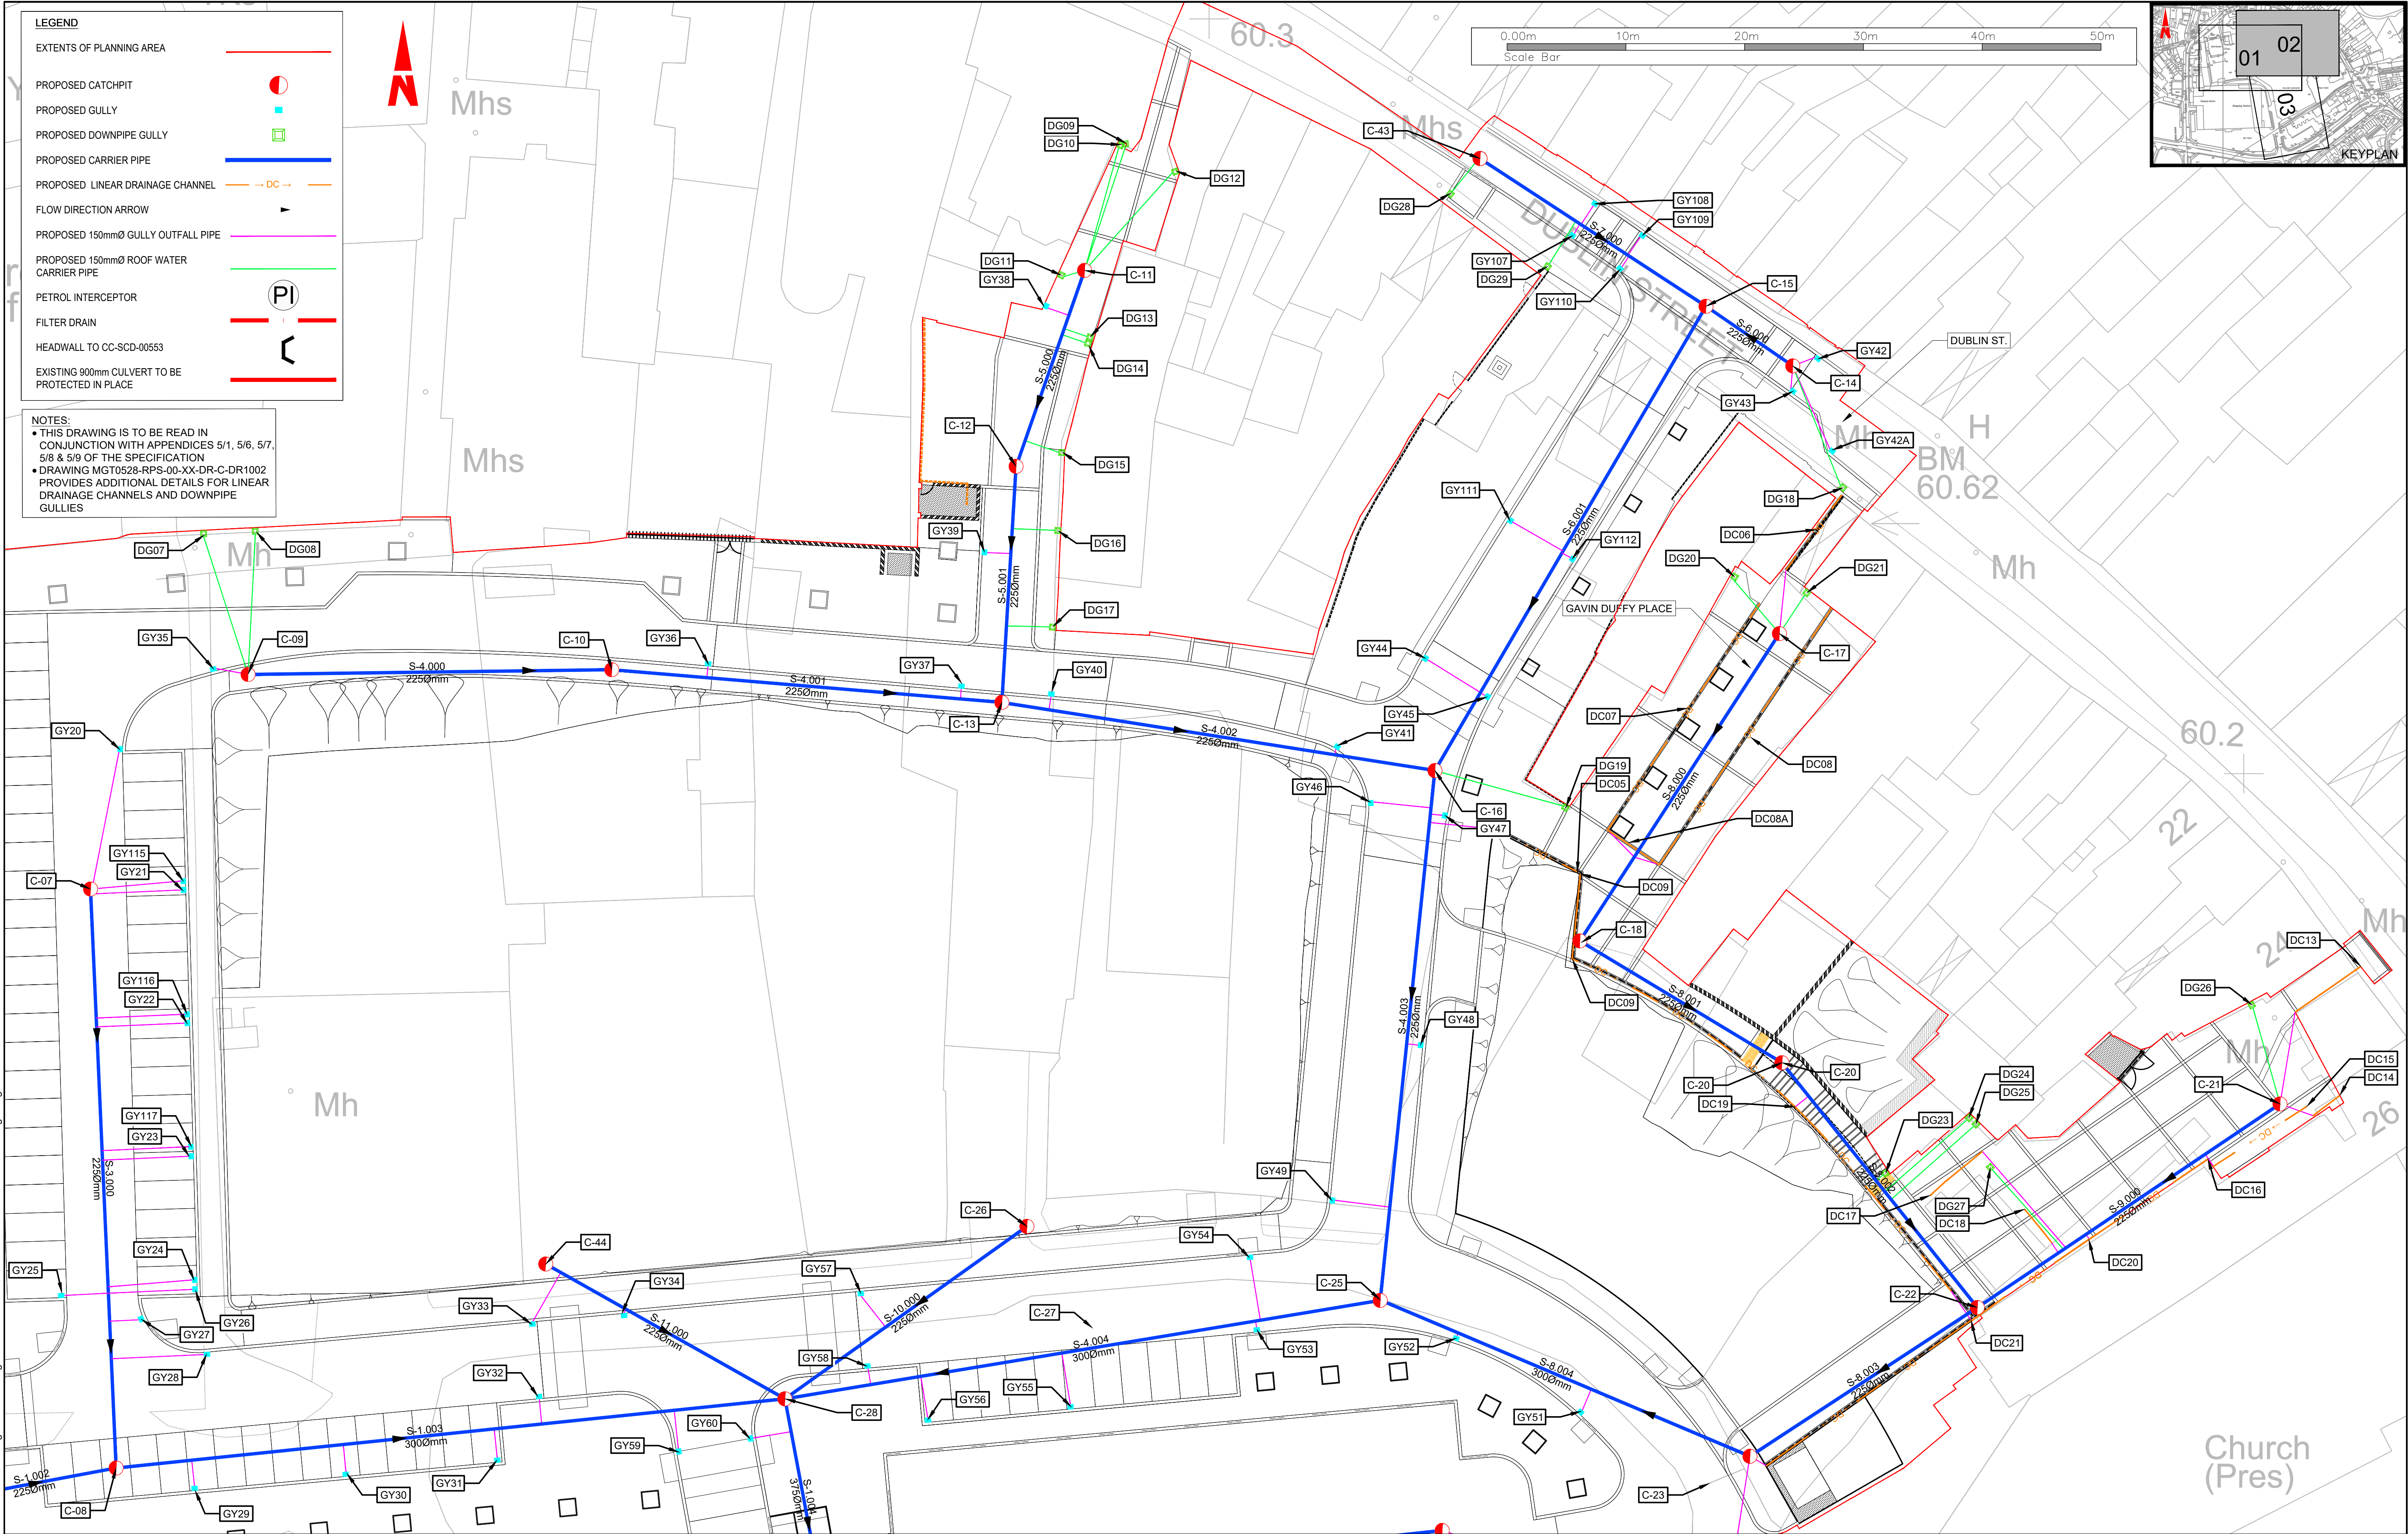

Client	 Comhairle Contae Mhuineacháin Monaghan County Council	General Notes (i) Hard copies, dwf and pdf will form a controlled issue of the drawing. All other formats (dwg etc.) are deemed to be an uncontrolled issue and any work carried out based on these files is at the recipients own risk. RPS will not accept any responsibility for any errors from the use of these files, either by human error by the recipient, listing of the un-dimensioned measurements, compatibility with the recipients software, and any errors arising when these files are used to aid the recipients drawing production, or setting out on site. (ii) DO NOT SCALE, use figured dimensions only.	(iii) This drawing is the property of RPS, it is a project confidential classified document. It must not be copied used or its contents divulged without prior written consent. The needs and expectations of client and RPS must be considered when working with this drawing. (iv) Information including topographical survey, geotechnical investigation and utility detail used in the design have been provided by others. (v) All Levels refer to Ordnance Survey Datum, Malin Head.	P05	25.07.22	ENK MF	PLANNING	MF		Scale	1:250 @ A1 1:500 @ A3	Project	MONAGHAN TOWN - DUBLIN STREET REGENERATION PROJECT					
				P04	26.05.22	MF	DETAIL DESIGN	MF		Created on	APRIL 2021		Title	DRAINAGE LAYOUT				
				P03	23.05.22	MG ENK	DETAIL DESIGN	MF		Sheets	02 of 03							
				P02	08.03.22	MG ENK	DETAIL DESIGN	RS						Model File Identifier				
				Rev	Date	Dm Ck	Amendment / Issue	App		N/A					File Identifier	MGT0528-RPS-00-XX-DR-C-DR1001	Drawing No.	DR1001

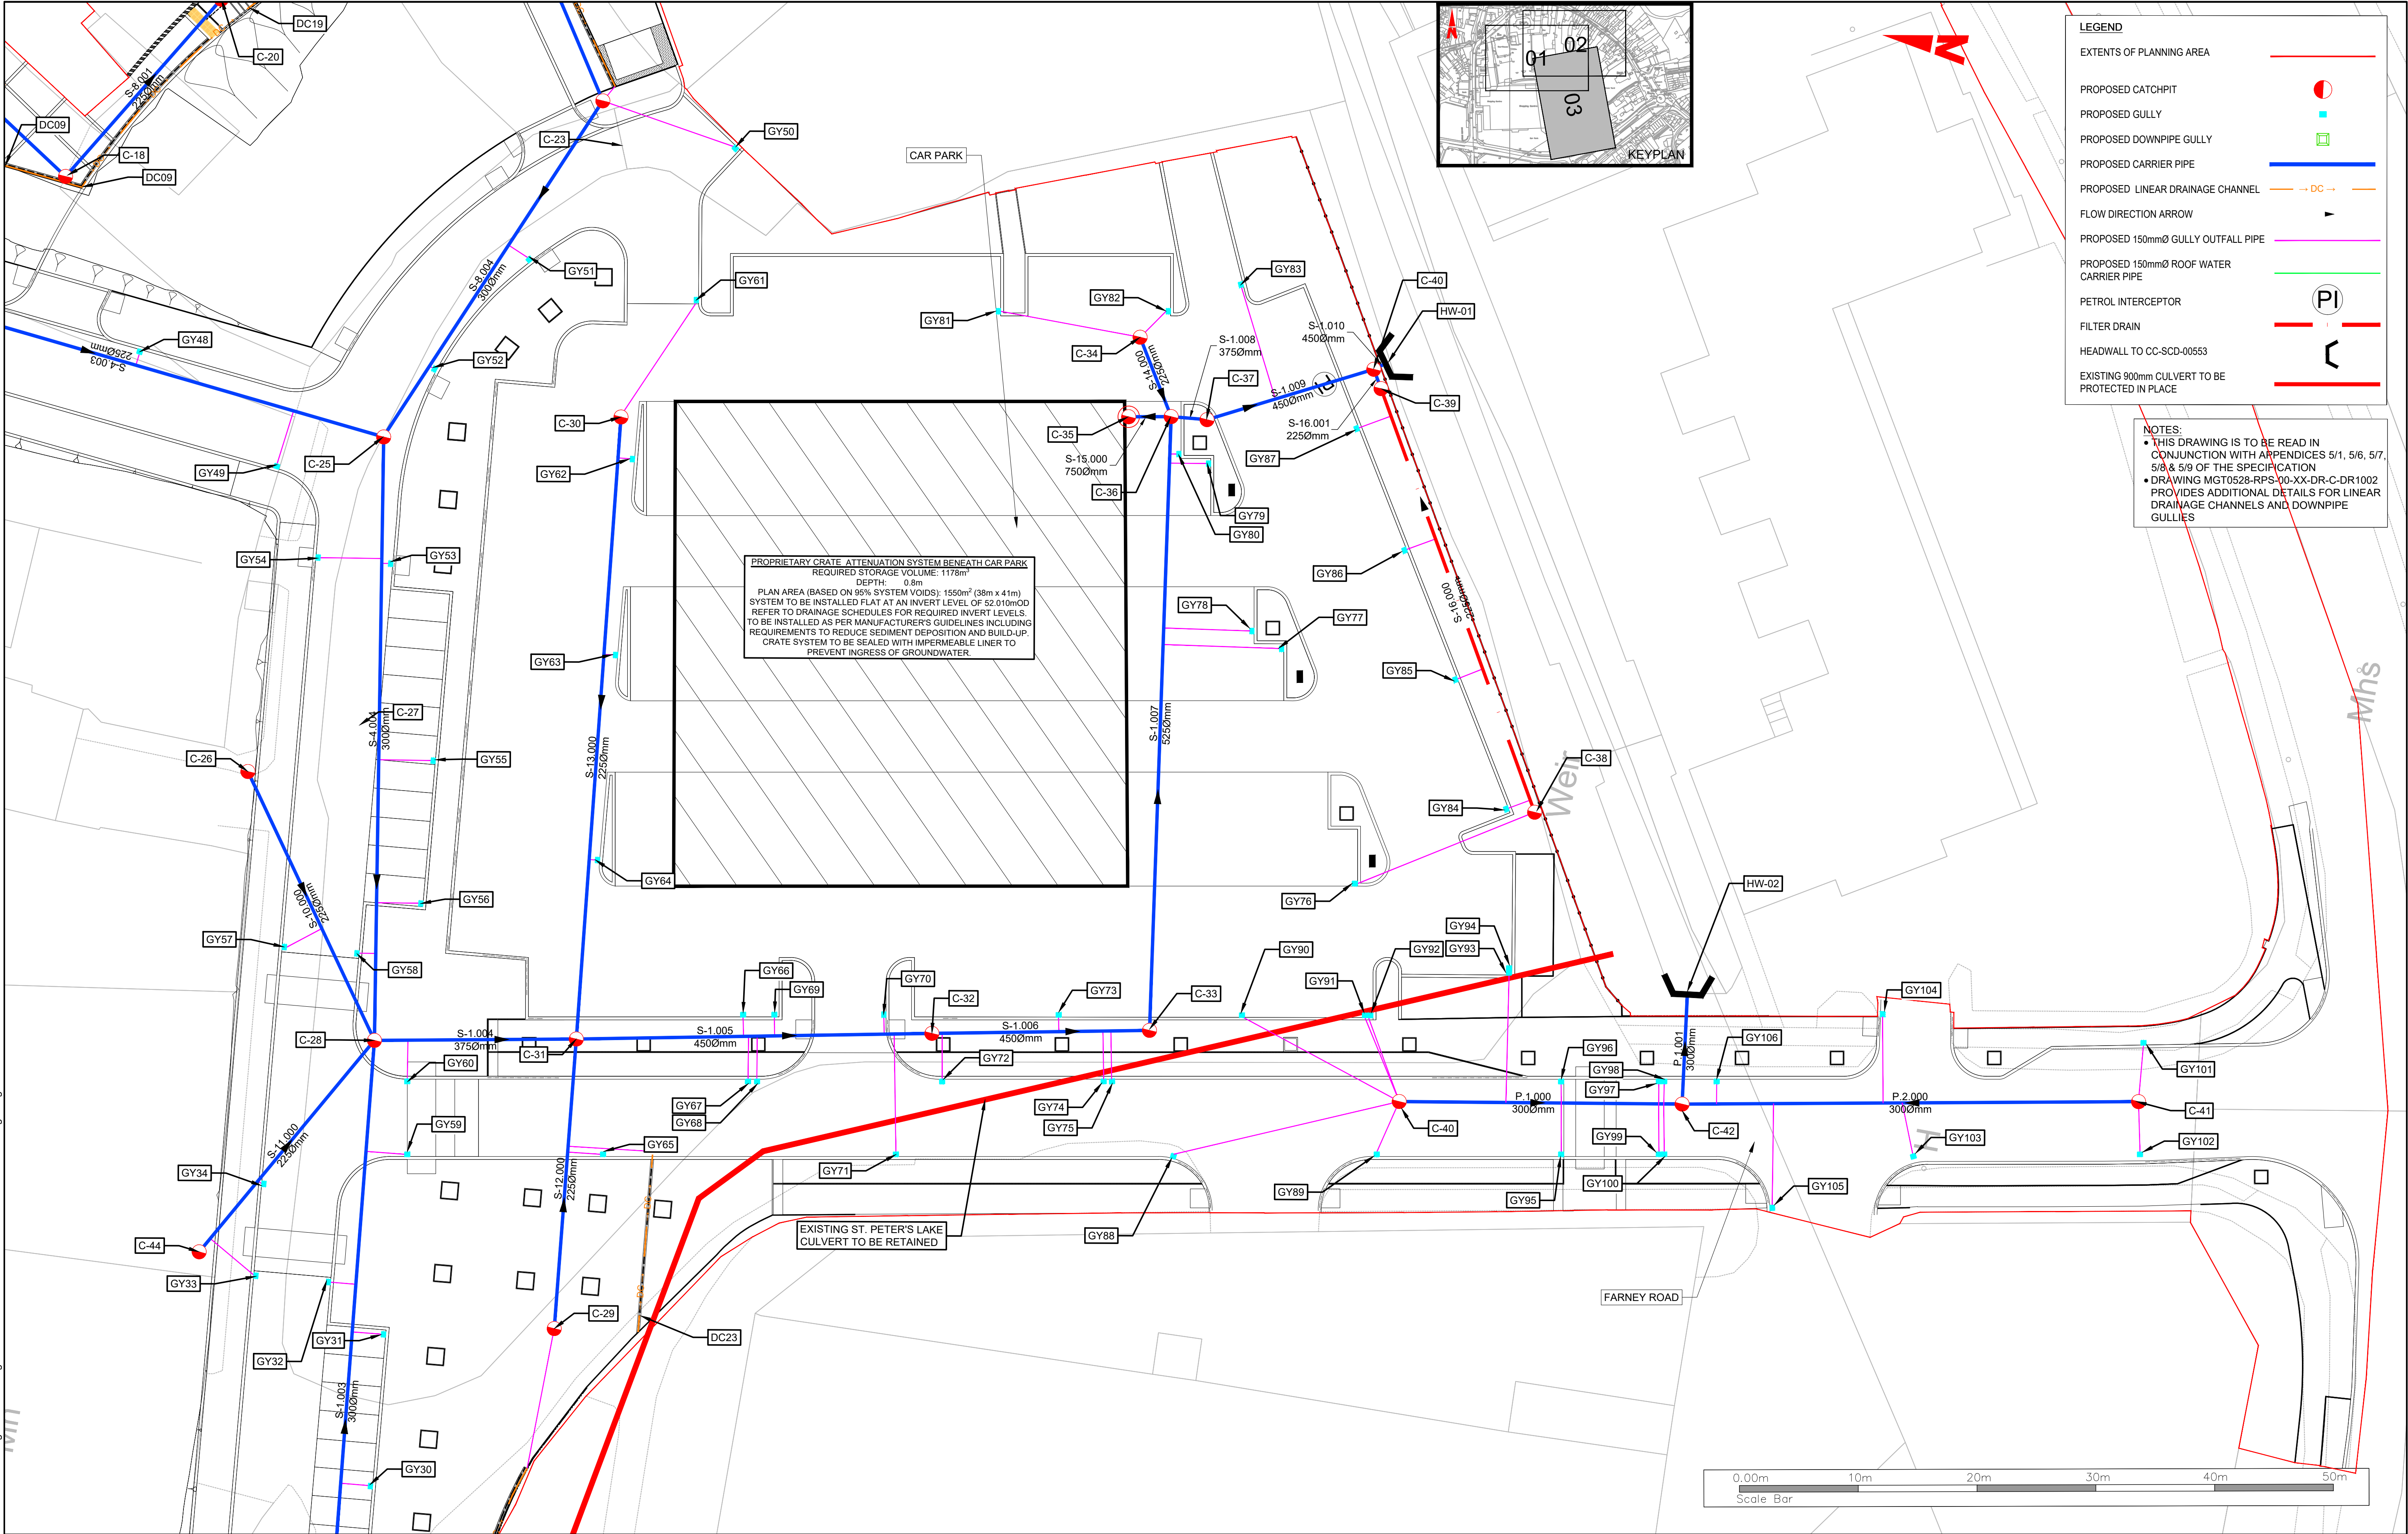

Client	 Comhairle Contae Mhuineacháin Monaghan County Council	General Notes (i) Hard copies, dwf and pdf will form a controlled issue of the drawing. All other formats (dwg etc.) are deemed to be an uncontrolled issue and any work carried out based on these files is at the recipients own risk. RPS will not accept any responsibility for any errors from the use of these files, either by human error by the recipient, listing of the un-dimensioned measurements, compatibility with the recipients software, and any errors arising when these files are used to aid the recipients drawing production, or setting out on site. (ii) DO NOT SCALE, use figured dimensions only.	(iii) This drawing is the property of RPS, it is a project confidential classified document. It must not be copied used or its contents divulged without prior written consent. The needs and expectations of client and RPS must be considered when working with this drawing. (iv) Information including topographical survey, geotechnical investigation and utility detail used in the design have been provided by others. (v) All Levels refer to Ordnance Survey Datum, Malin Head.	P05 25.07.22 ENK MF PLANNING MF	rps	Scale 1:250 @ A1 1:500 @ A3	Project MONAGHAN TOWN - DUBLIN STREET REGENERATION PROJECT			
				P04 26.05.22 MF MF DETAIL DESIGN MF		Created on APRIL 2021	Title DRAINAGE LAYOUT			
				P03 23.05.22 MF ENK DETAIL DESIGN MF		Sheets 03 of 03				
				P02 08.03.22 MF ENK DETAIL DESIGN RS						
				Rev Date Drn Chk Amendment / Issue App		Model File Identifier N/A	File Identifier MGT0528-RPS-00-XX-DR-C-DR1001	Drawing No. DR1001	Status S4	Rev P05