


100  
10  
0  
A1

DO NOT SCALE

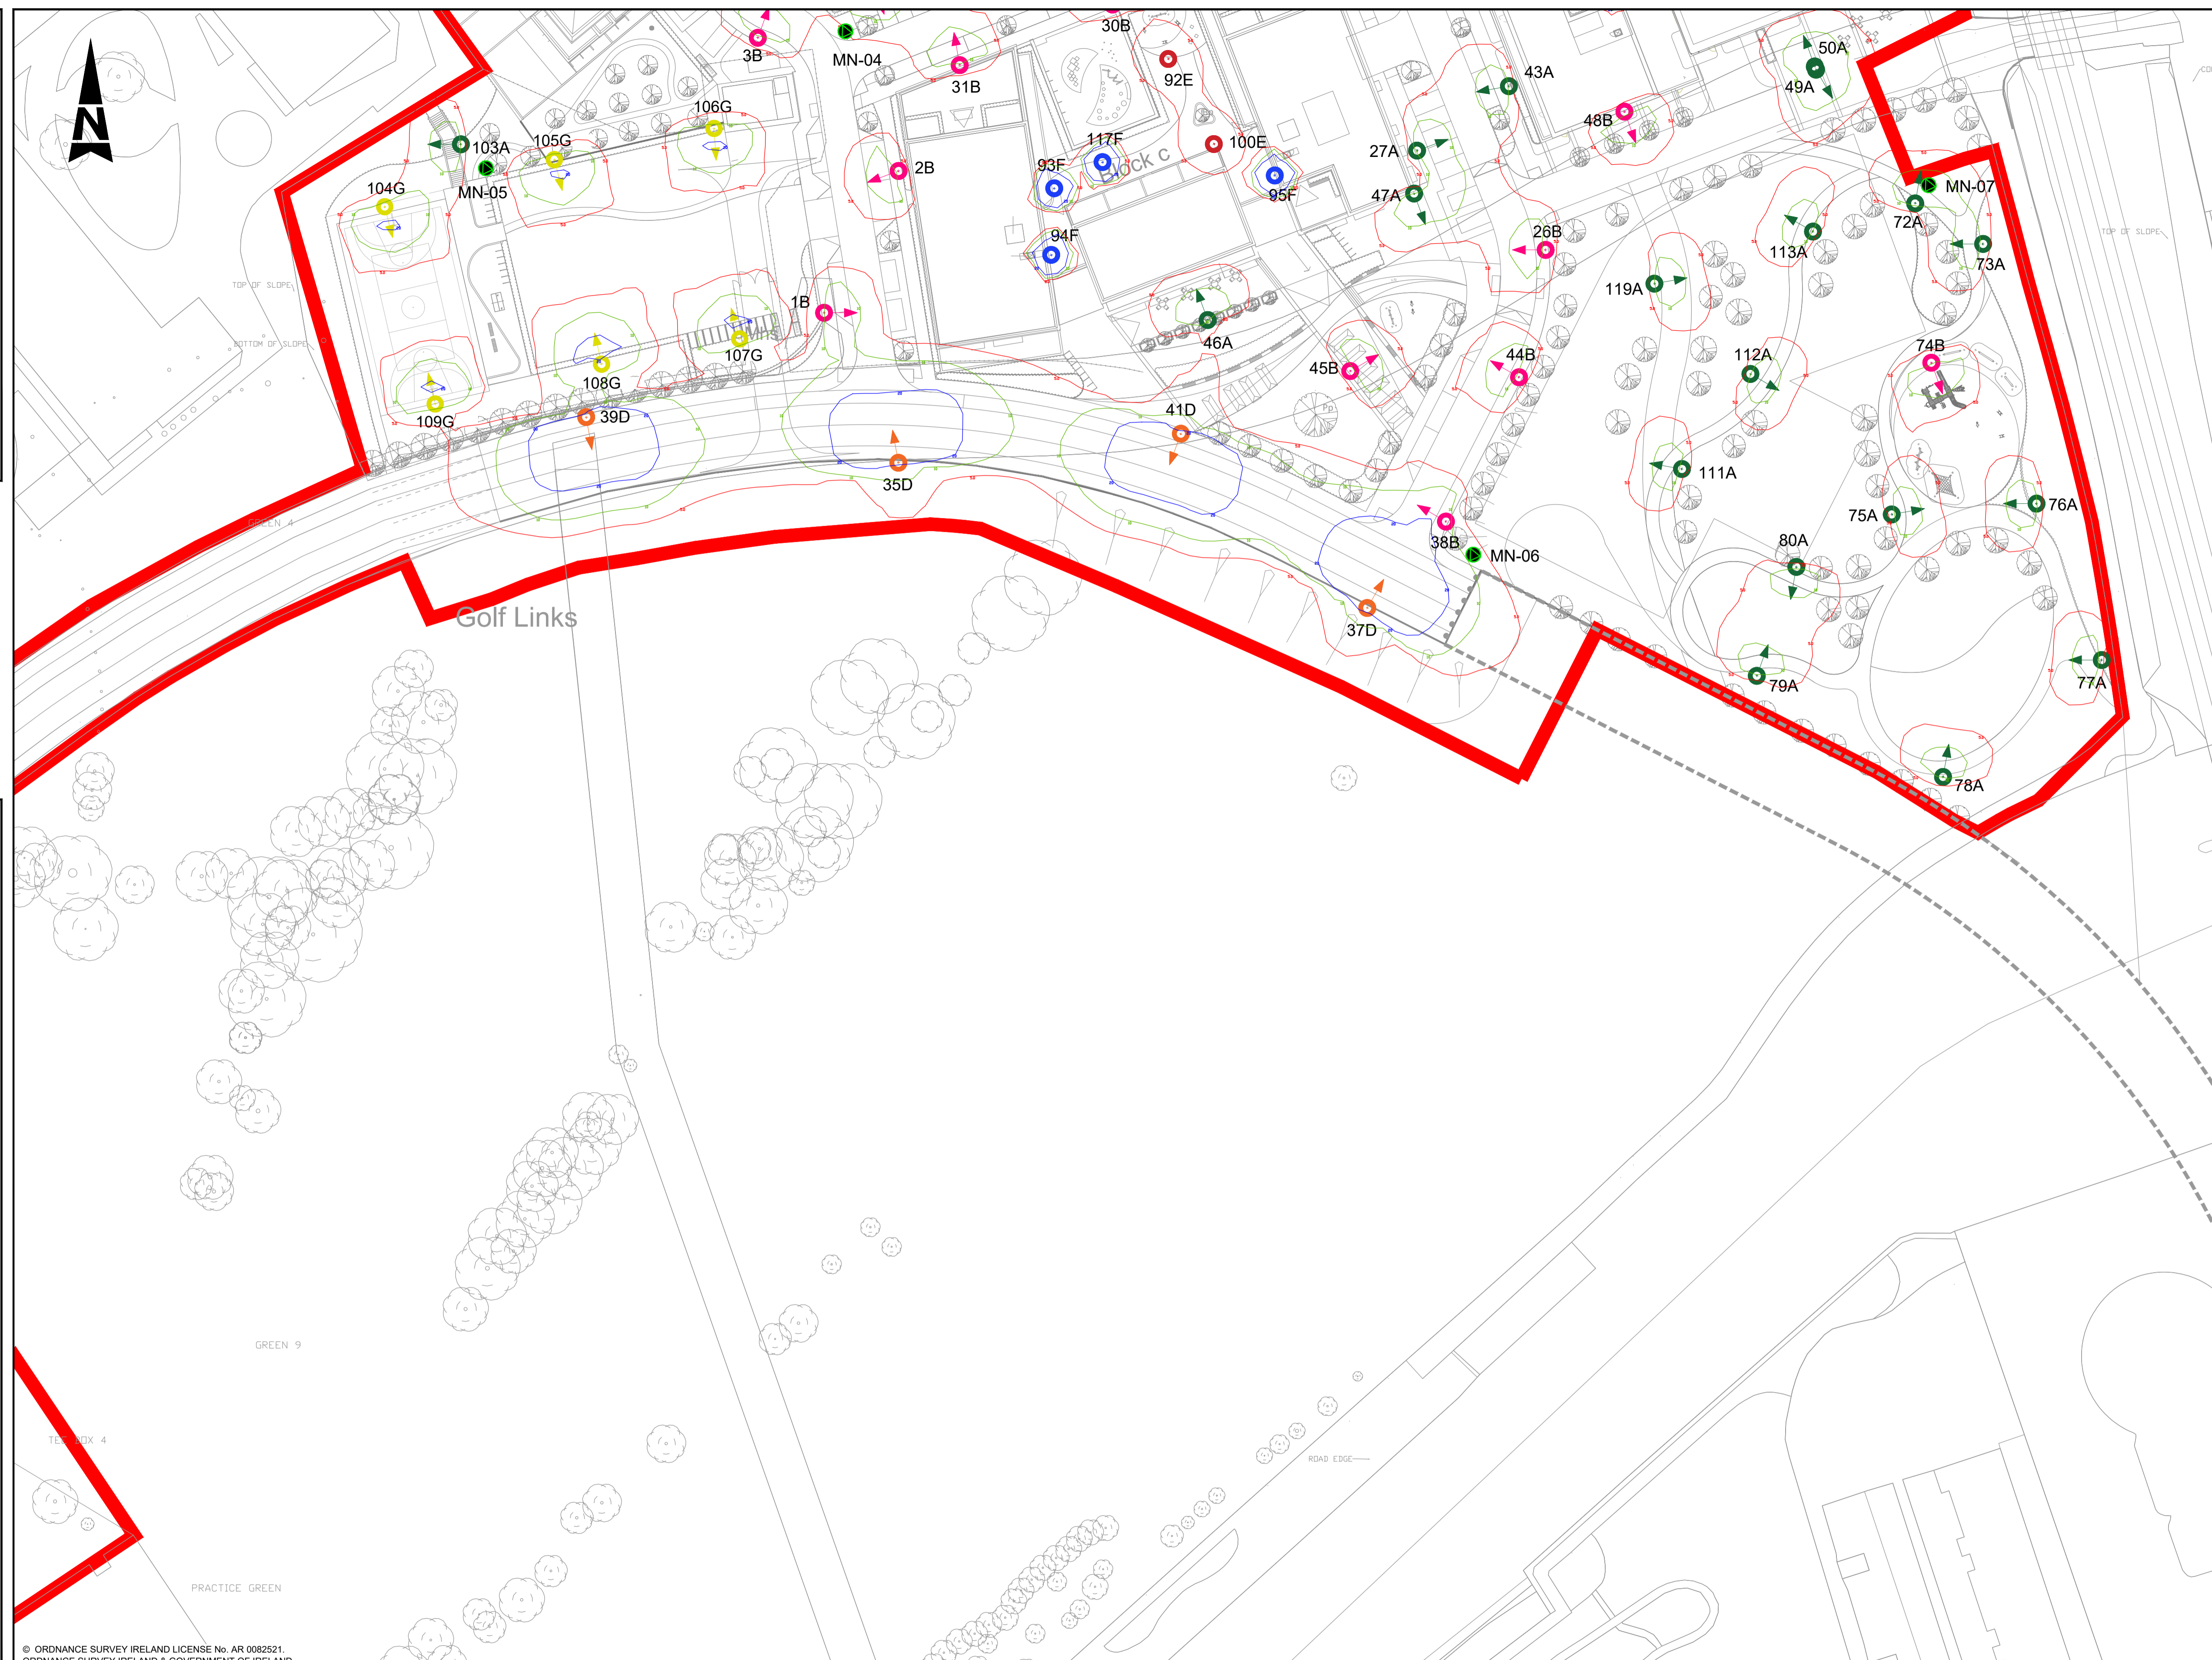


- GENERAL NOTES**
1. ALL DIMENSIONS ARE IN MILLIMETRES UNLESS NOTED OTHERWISE
  2. ONLY WRITTEN DIMENSIONS SHALL BE USED. NO DIMENSIONS SHALL BE SCALED FROM THE DRAWINGS
  3. ALL LEVELS ARE IN METRES AND ARE TO MALIN HEAD DATUM
  4. ALL COORDINATES ARE IN METRES AND ARE TO IRISH TRANSVERSE MERCATOR

**LEGEND**

SYMBOL	IMAGE	DESCRIPTION
TYPE A		Luminaire A Veelite Metro Streetlight 19w LED Street Optic R03 Lamp 8LED 2700K G4 MF 0.83 COLUMN HEIGHT: 6.0M
TYPE B		Luminaire B Veelite Metro Streetlight 19w LED Forward Throw A Optic Lamp 8LED 2700K G4 MF 0.83 COLUMN HEIGHT: 6.0M
TYPE C		Luminaire C Veelite Metro Streetlight 19w LED Street Optic R03 Lamp 8LED 2700K G4 MF 0.83 COLUMN HEIGHT: 5.0M
TYPE D		Luminaire D Veelite Metro Streetlight 134w LED Forward Throw Optic Lamp 64LED 3000K G4 MF 0.83 COLUMN HEIGHT: 10 M
TYPE E		Luminaire E Veelite Quad Series 14w LED Symmetric Lamp 8LED 2700K G4 MF 0.83 COLUMN HEIGHT: 4.0M
TYPE F		Luminaire F Veelite LED Bollard 18w LED Symmetric Lamp 4 x 4LED 3000K MF 0.83 COLUMN HEIGHT: 1.0M
TYPE G		Luminaire G Veelite Metro Streetlight 27w LED Forward Throw A Optic Lamp 12LED 2700K G4 MF 0.83 COLUMN HEIGHT: 6.0M
	20 Lux Levels	
	10 Lux Levels	
	5 Lux Levels	
	SITE BOUNDARY	
	SITE OWNER BOUNDARY	
	PUBLIC LIGHTING MINI PILLAR (PROPOSED)	

File: 5214419-ATK-01-ZZ-DR-EE-1301\_1302.dwg  
Date: Sep 12, 2022 - 3:18pm  
Printed by: rthomas

© ORDNANCE SURVEY IRELAND LICENSE No. AR 0082521.  
ORDNANCE SURVEY IRELAND & GOVERNMENT OF IRELAND

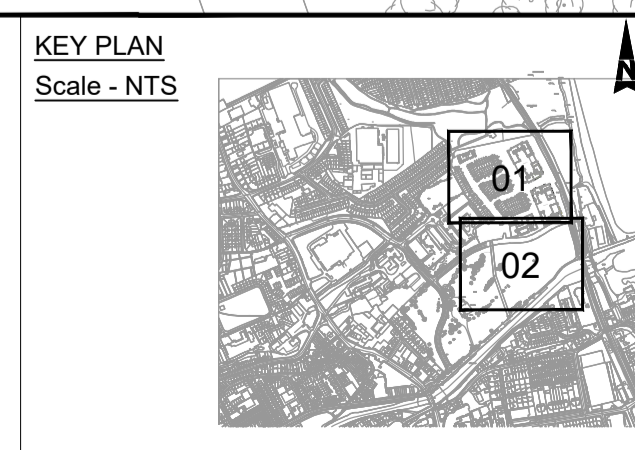

Rev	Description	By	Date	Chk'd	Auth
P01	ISSUED FOR PLANNING	RRT	02.09.22	AK	NS

**ATKINS**  
Member of the SNC-Lavalin Group

Atkins House, 150-155 Ainslie Road, Business Park, Swords, Co. Dublin  
Tel (+353) 01 810 8000 Fax (+353) 01 810 8001

Unit 2B, 2200 Cork Airport Business Park, Cork  
Tel (+353) 021 429 0300 Fax (+353) 021 429 0360

1st Floor Technology House Parkmore Technology Park, Galway  
Tel (+353) 091 786 050 Fax (+353) 091 779 830

Client	SHANKILL PROPERTY INVESTMENTS LTD
Project	COASTAL QUARTER SHD 2

Purpose	PLANNING
Title	PROPOSED PUBLIC LIGHTING LAYOUT - SHEET 2 OF 2
Original Scale	1:500 at A1 1:1000 at A3
Design/Drawn	RRT
Checked	AK
Authorised	NS
Date	02.09.22
Date	02.09.22
Date	02.09.22
Status	P
Drawing Number	5214419-ATK-01-ZZ-DR-EE-1302
Rev	P01