



KEY PLAN
N.T.S

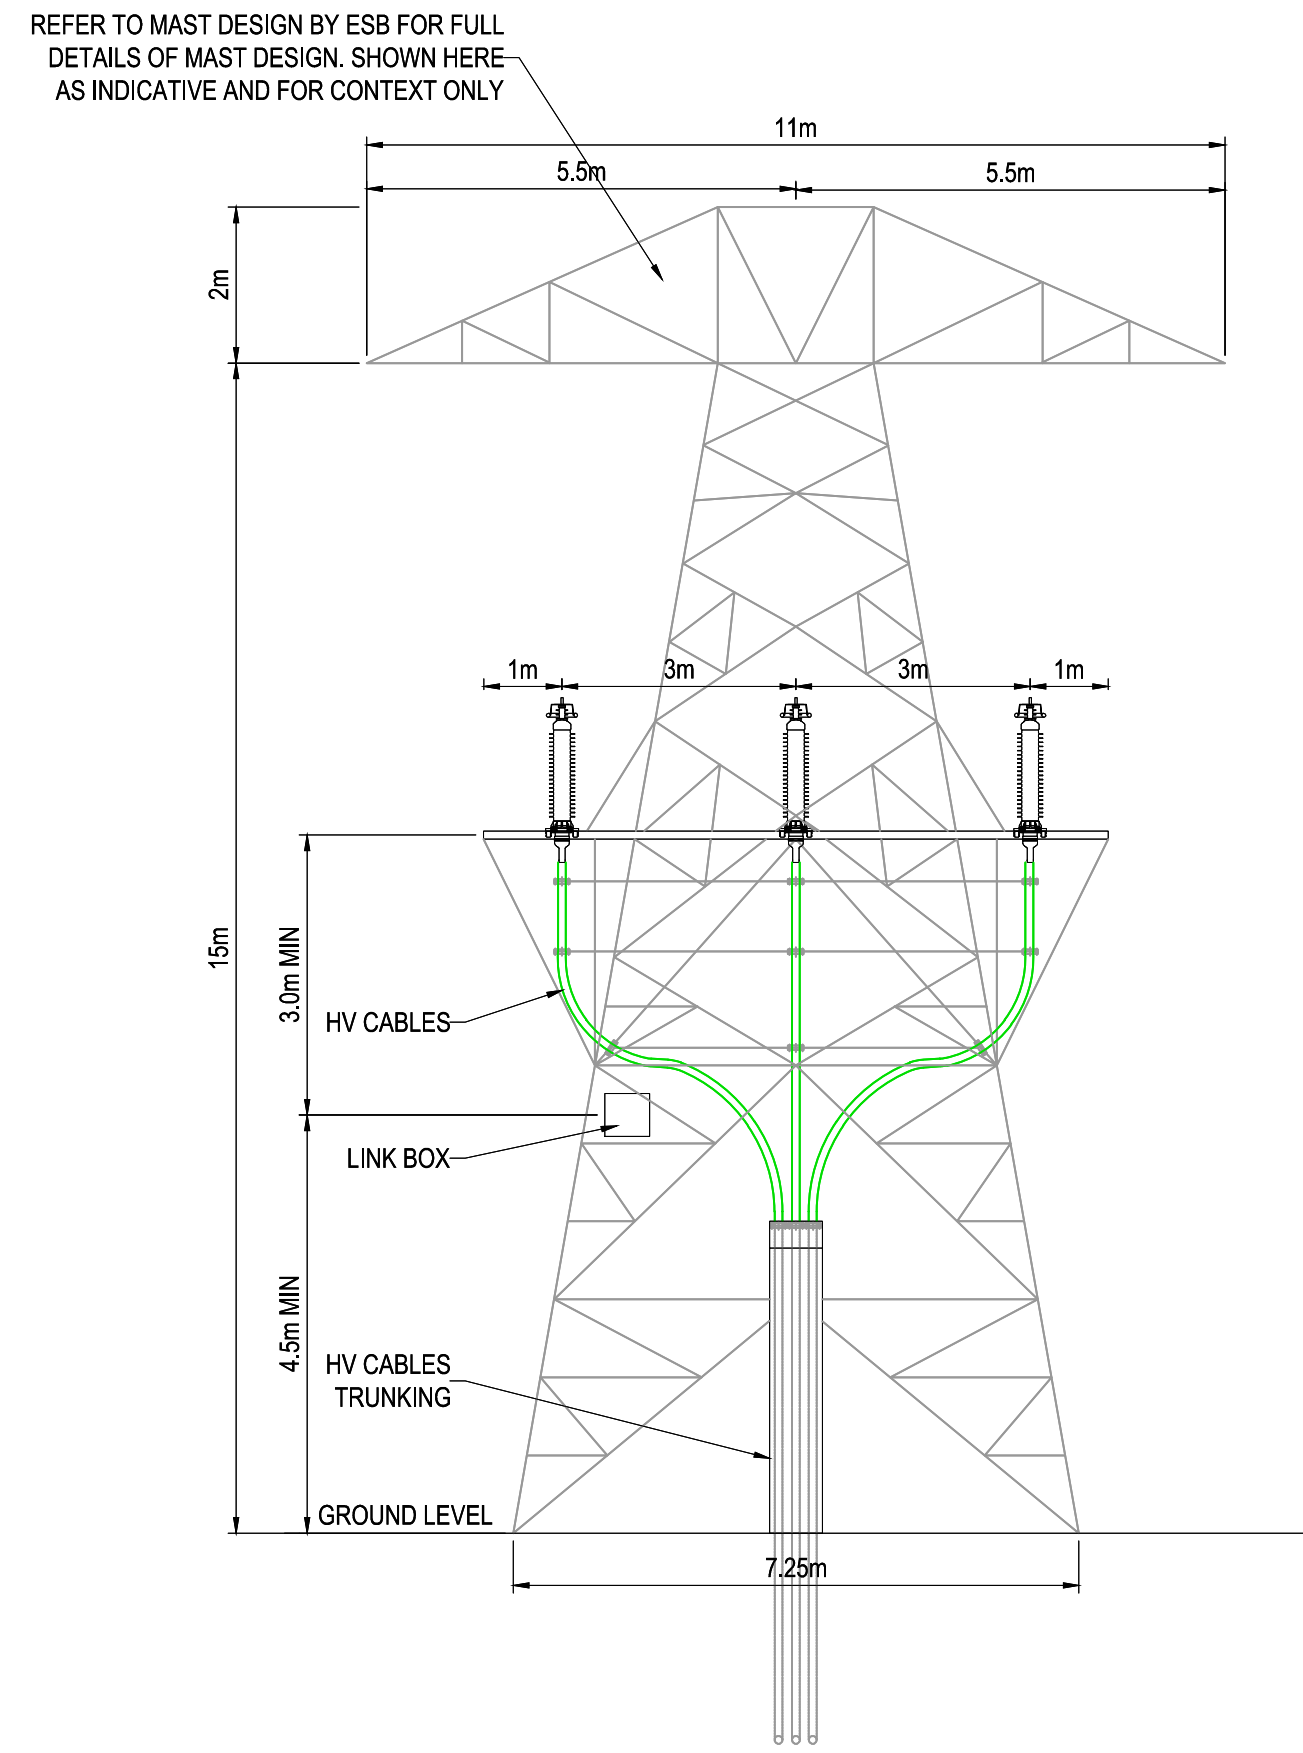

FRONT ELEVATION
SCALE 1:100

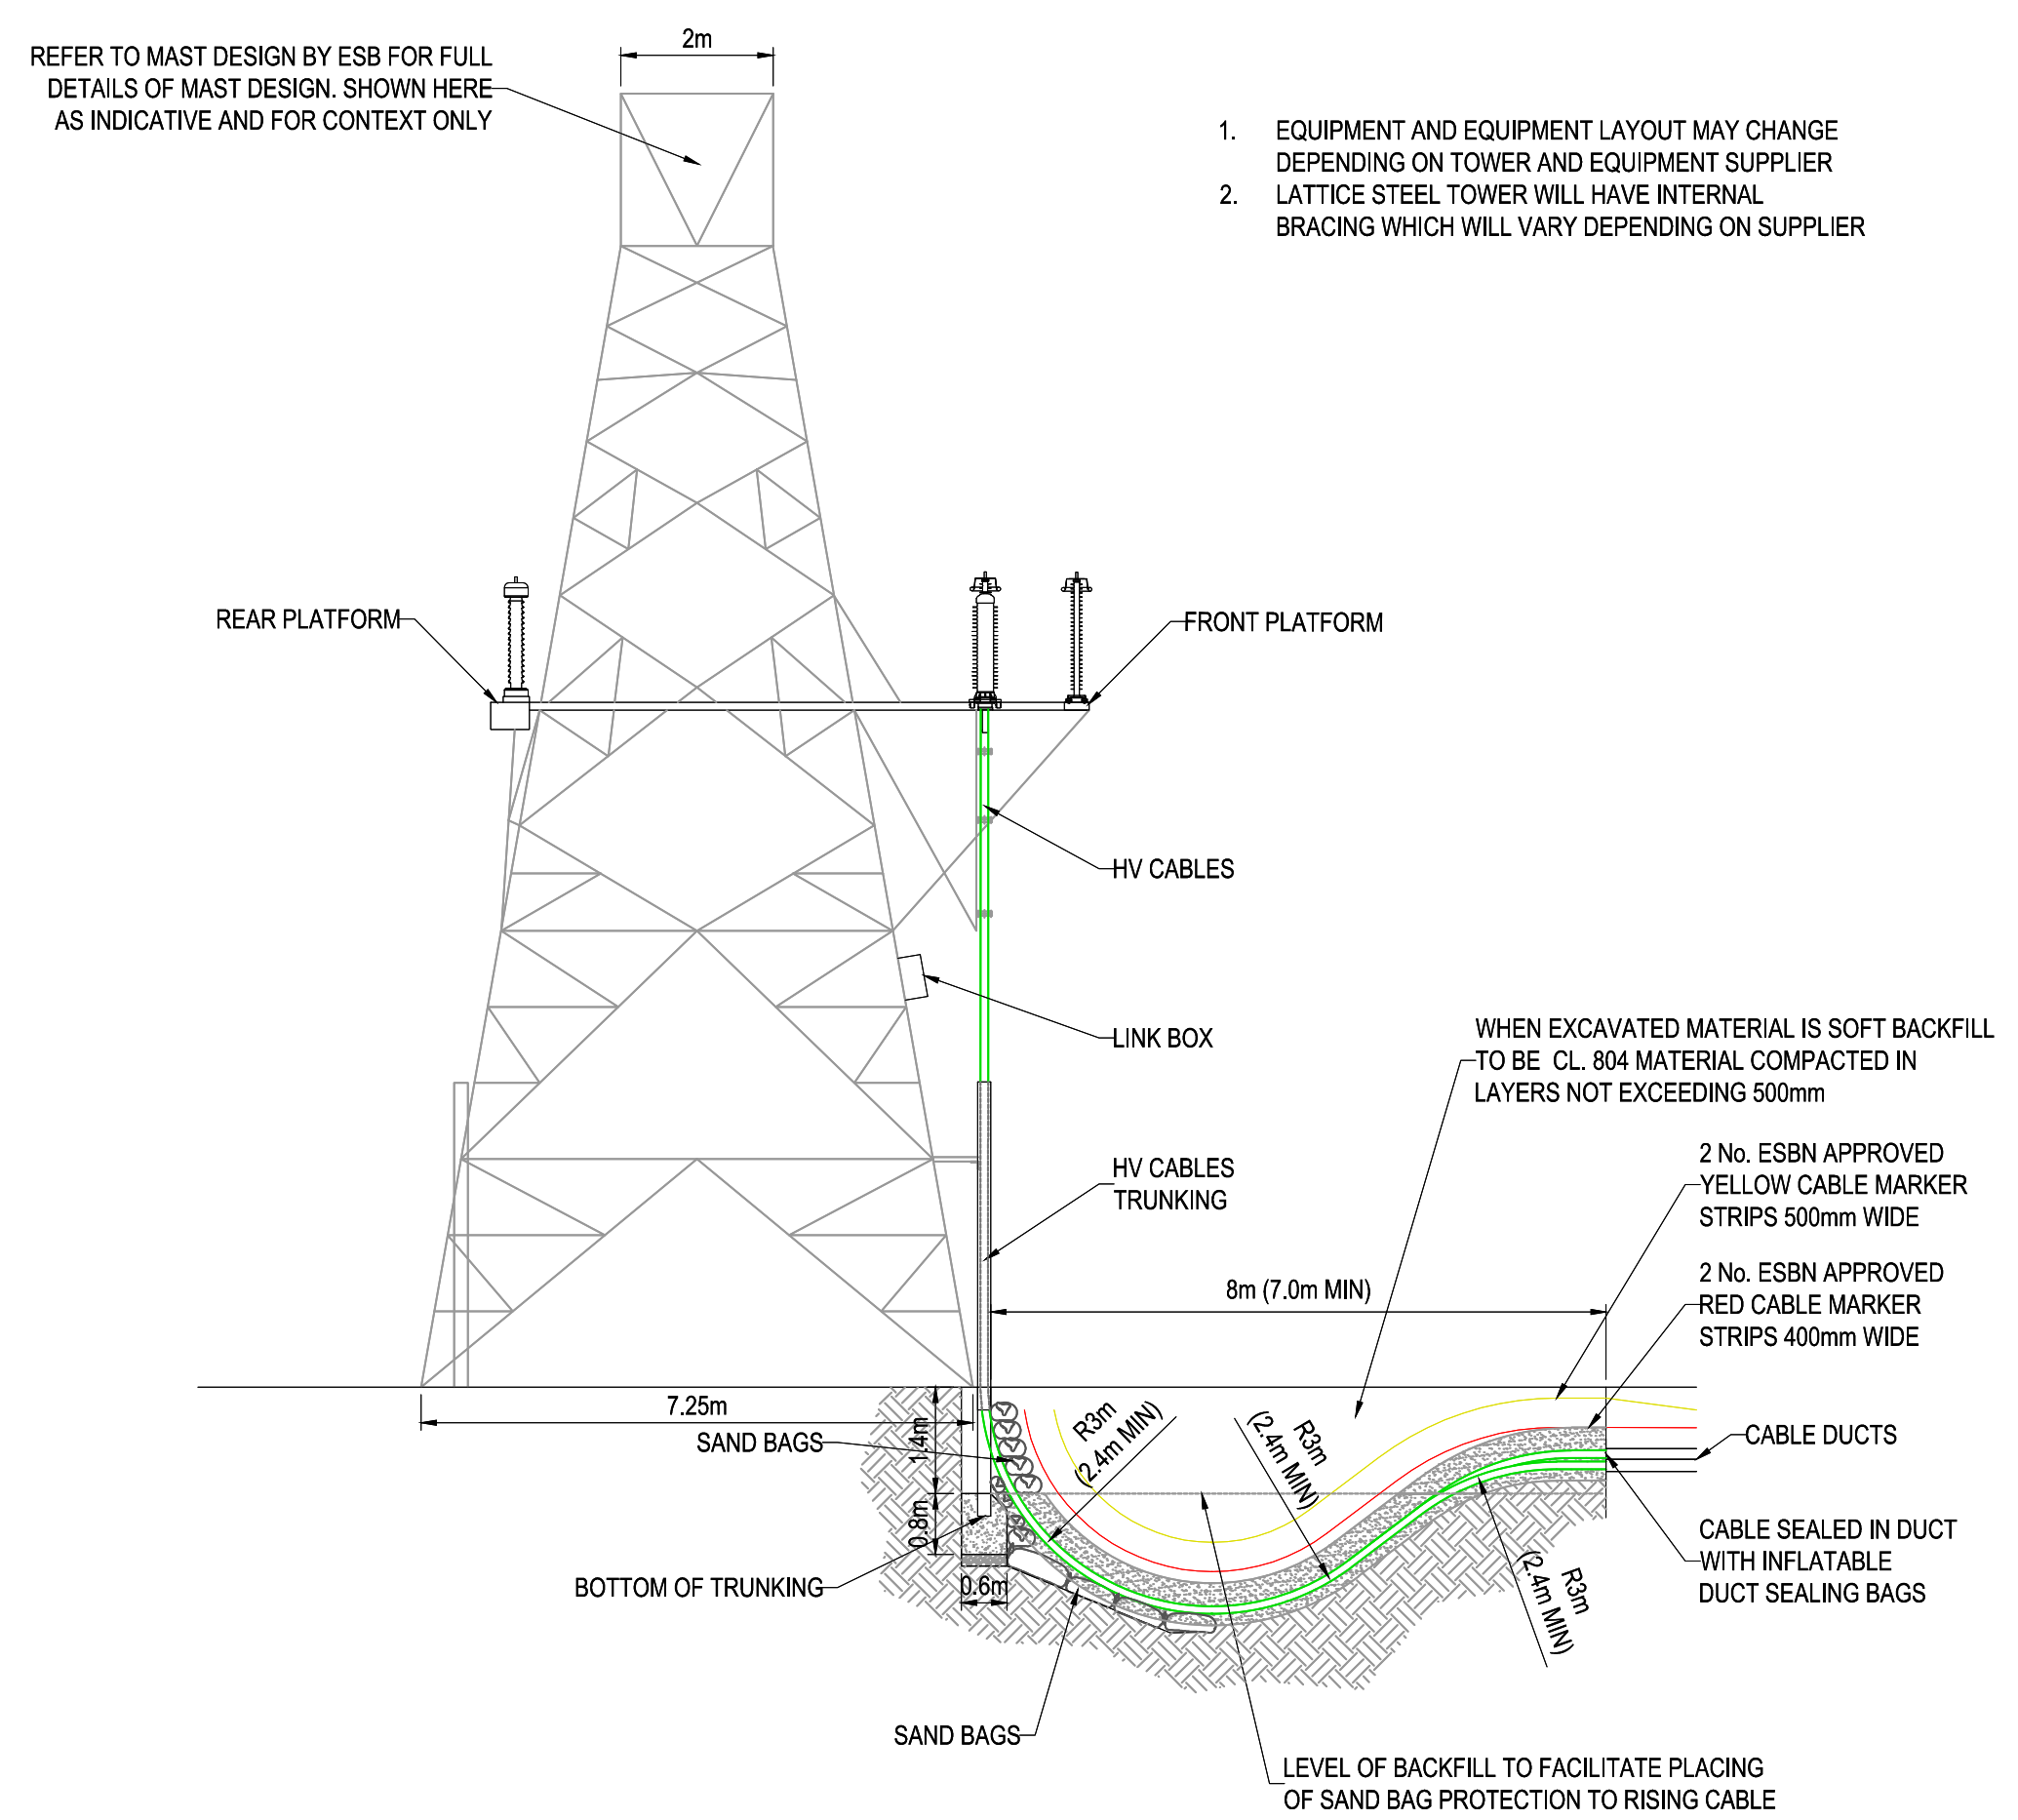

SIDE ELEVATION
SCALE 1:100

1. EQUIPMENT AND EQUIPMENT LAYOUT MAY CHANGE DEPENDING ON TOWER AND EQUIPMENT SUPPLIER
2. LATTICE STEEL TOWER WILL HAVE INTERNAL BRACING WHICH WILL VARY DEPENDING ON SUPPLIER

Rev	Description	Drawn	Checked	Date
P02	GENERAL AMENDMENTS	KT	DRL	25/10/22
P01	ISSUE FOR PLANNING	KT	DRL	21/10/22

Clifton Scannell Emerson Associates Limited
Consulting Engineers,
3rd Floor The Highline,
Bakers Point, Pottery Road,
Dun Laoghaire, Co. Dublin,
Ireland, A96 KW29

T. +353 1 288 5006
F. +353 1 283 3466
E. info@csea.ie
W. www.csea.ie

Client: CRAG WICKLOW LIMITED

Project: DUB 30 GRID CONNECTION

Dwg. Title: CABLES DROP DETAILS

Drawn By: KT Date: SEP. 2022

Checked By: DRL Scale: AS SHOWN @ A1

Project Code: 22_131 - CSE - GEN - XX - DR - C - 1530

Status Code: S2 SUITABLE FOR INFORMATION

Revision: P02 Project Status: PLANNING