



00-ZZ-ML-A-ElevationMaterialKey	
*Ventilation grille positioning strategy as indicated on Facade strategy in Design Statement	
M1	Buff brick, stretcher bond, light mortar
M2	Red brick, stretcher bond, light mortar
M3	Red brick, stretcher bond, dark wet mortar to match
M4	Red brick banding with soldier course to top and bottom
M5	Red brick banding with protruding soldier course to top and bottom and PPC sill
M6	Precast concrete parapet capping
M7	PPC metal balcony & railing, for colour strategy ref. to Design Statement
M8	Recessed PPC aluminium RWP to Tower, for colour strategy ref. to Design Statement
M10	PPC aluminium window, for colour strategy ref. to Design Statement
M11	PPC aluminium door, for colour strategy ref. to Design Statement
M13	PPC metal entrance gate / railing, for colour strategy ref. to Design Statement
M15	Red brick, hit and miss detail
M16	Alternating redbuff sawtooth brick coursing panel with precast concrete head and base course
M17	Recessed entrance w/ alternating redbuff sawtooth brick, precast concrete surround & downward
M18	Concrete screen to mechanical plant
M19	Alternating redbuff stretcher bond coursing flush
M20	Buff brick soldier course
M21	Recessed panel of alternating redbuff stretcher bond coursing, alternating course recessed



Site Section 3
1 : 200

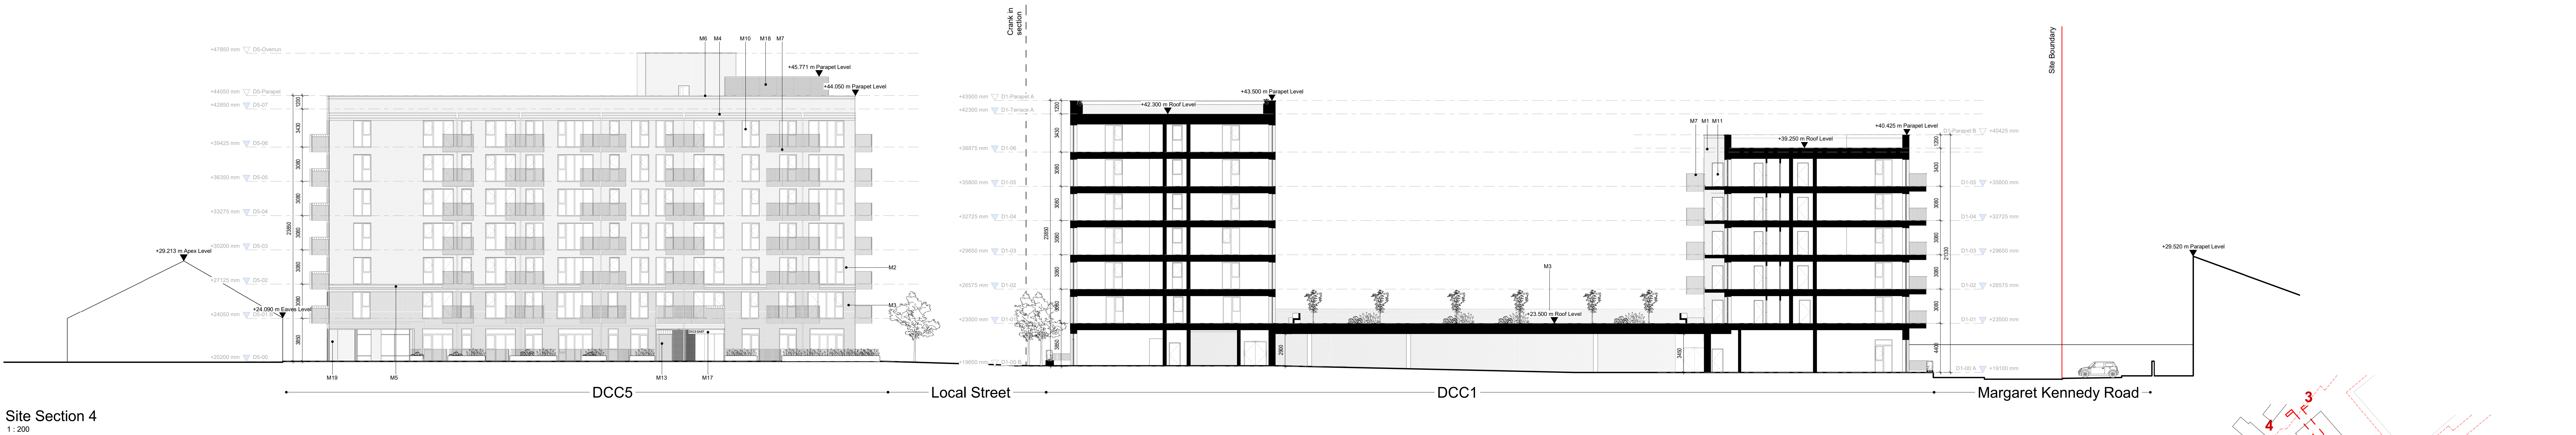

Site Section 4
1 : 200

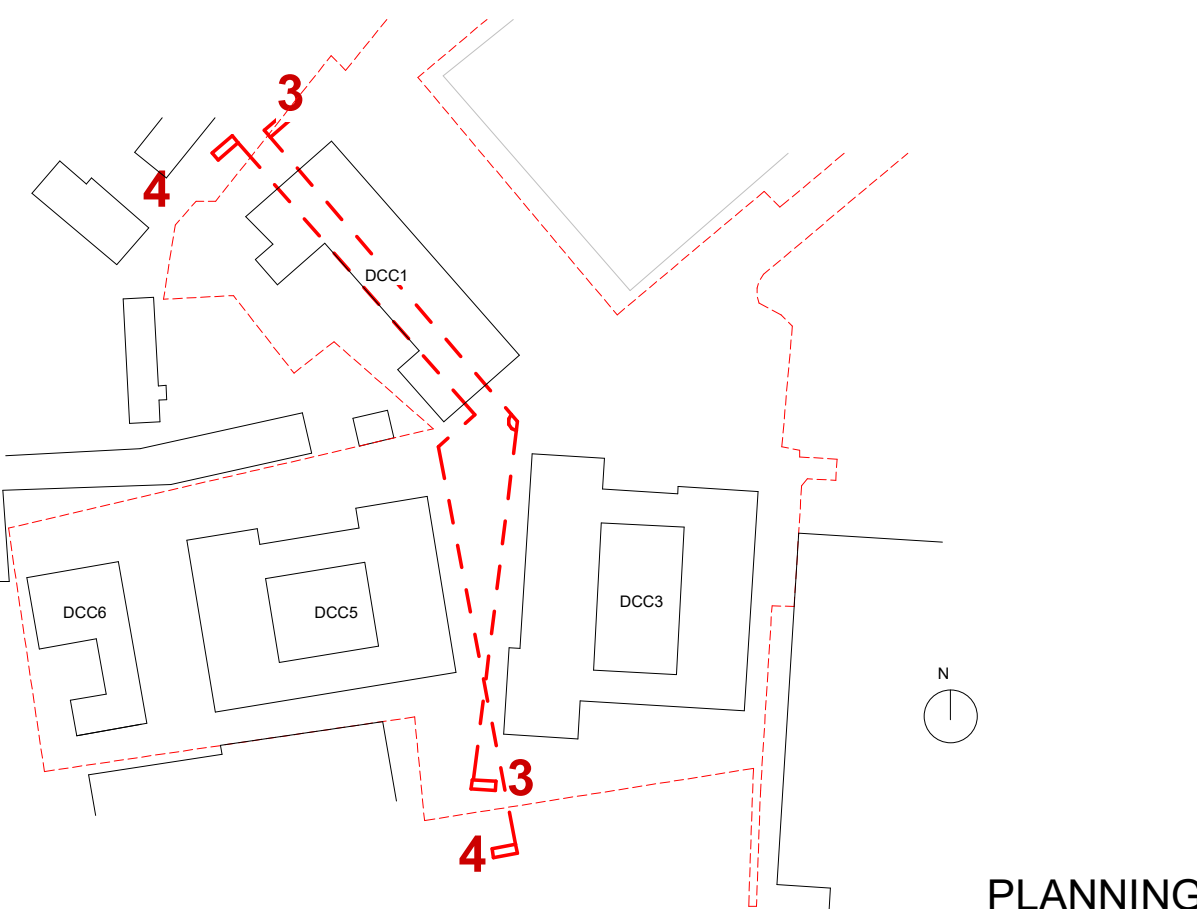

PLANNING

Revision	Date	Description	Issued	Checked
P1	Dec 22	Issued for Planning	CC	JH



Notes:
For planning purposes only. Do not scale drawings. Errors to be reported to the Architect. To be read in conjunction with all relevant consultants information. All levels shown are above Ordnance datum.
Copyright:
Copyright Metropolitan Workshop LLP.
No implied license exists. This drawing should not be used to calculate areas for the purpose of valuation.
The drawing was prepared in part, based on survey information provided by others. Whilst this information is believed to be reliable, Metropolitan Workshop assumes no responsibility for the accuracy of the information or any errors or omissions that may have been incorporated into it as a result of incorrect information provided by others.

Key

Metropolitan
Workshop

Metropolitan Workshop
Furnally Court
Dun Laoghaire
D08 N2N8

00 353 (0)1 531 4889
www.metroworkshop.ie

Project: Donore Project, Donore Avenue
Client: The Land Development Agency
Location: Dublin 8
Site Sections 03 & 04
Date: Dec 22
Scale: 1 : 200 @ A0

Drawing Number: STG MET 00 XX DR A 1130001 S4 P1