

PROJECT

DONORE PROJECT,
DONORE AVENUE,
DUBLIN 8.

CLIENT

THE LAND DEVELOPMENT AGENCY

CONSULTANT

AECOM
10th Floor, The Clarence West Building,
2 Clarence Street West,
Belfast.
Tel: +44 (0)28 9060 7200
www.aecom.com

NOTES


LEGEND - ROOF TERRACE

- NET DEVELOPABLE AREA BOUNDARY
- PCC PAVING: ROOF TERRACE GREY PAVING
- SHRUB MIX: ROOF TERRACE MIX 1
- SHRUB MIX: ROOF TERRACE MIX 2
- SHRUB MIX: ROOF TERRACE MIX 3
- ARTIFICIAL LAWN
- 1.1m HIGH PLANTER LOW SHRUB MIX
- EXTENSIVE ROOF SEDIUM MIX 1/2
- SEAT: TIMBER TOP SEAT
- PICNIC TABLE
- BENCH: TIMBER TOP PCC WALL
- SHELTER: TIMBER PERGOLA SHELTER WITH SEATING
- CRECHE PLAY SURFACE SAFETY SURFACING IN 3 COLOURS
- CRECHE CANOPY
- PROPOSED BUILDING CORE LOCATION

ISSUE/REVISION

I/R	DATE	DESCRIPTION
P1	DEC 2022	ISSUED FOR PLANNING

KEY PLAN

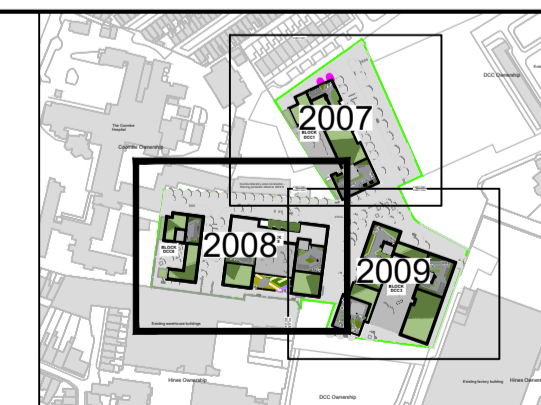

PROJECT NUMBER

60648061

SHEET TITLE


GENERAL ARRANGEMENT
(DCC6 & DCC5 - ROOF TERRACES)
SHEET 2 OF 3

SHEET NUMBER

STG-AEC-S1b-00-00-DR-L-0002008

ISO A1 594mm x 841mm

Last saved by: KAREN.CRAWFORD(2022-12-02) Last Plotted: 2022-12-02
 Filename: \\NA.AECOM\NET\COM\FILES\EMEA\DUBLIN\EDBL2\LEGACY\IEDBL2\FP001\DATA\DCS\PROJECTS\BP\60648061_LDA_STG_TERESAS900_CAD_GIS\906_LAO2_SHEETS\STG-AEC-S1b-00-00-DR-L-0002007_2008_2009_GENERAL_ARRANGEMENT (ROOF TERRACES).DWG
 Project Management Initials: Designer: KSC Checked: RM Approved: PG
 Project Management Initials: Designer: KSC Checked: RM Approved: PG

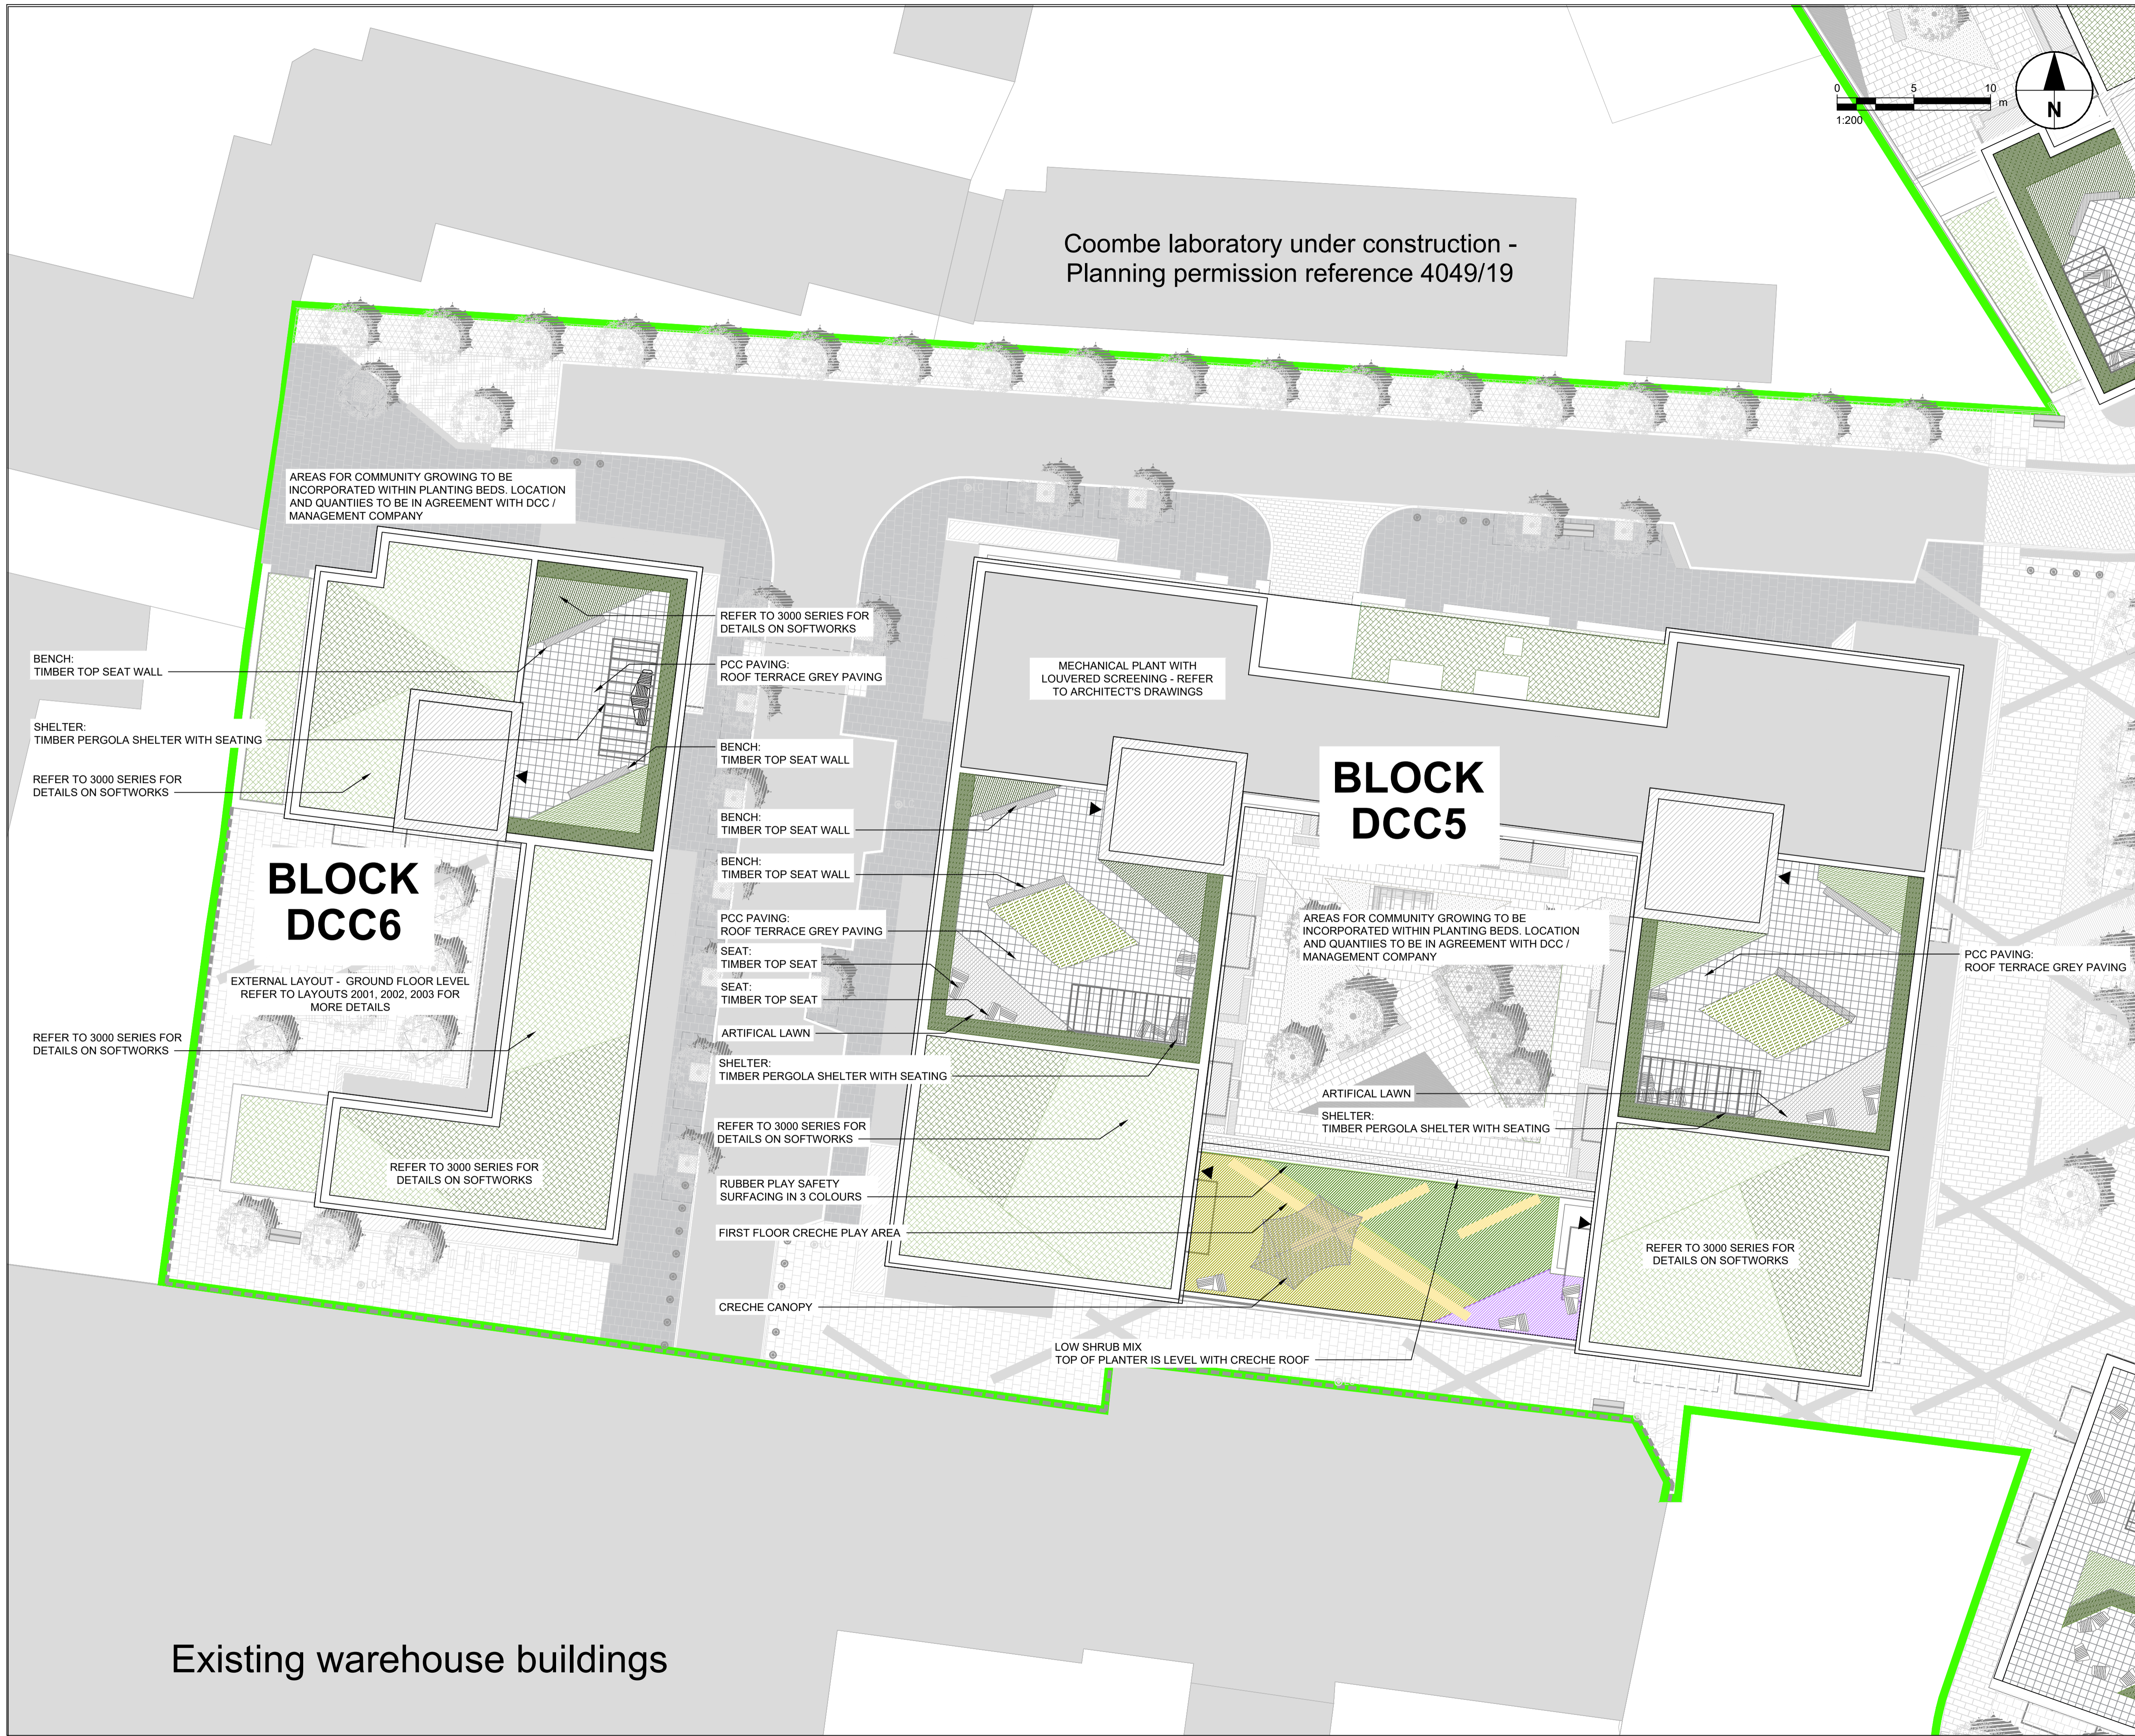

This drawing has been prepared for the use of AECOM's client. It may not be used, modified, reproduced or relied upon by third parties, except as required by law. AECOM accepts no responsibility, and denies any liability whatsoever, to any party that uses or relies on this drawing without AECOM's express written consent. Do not scale this document. All measurements must be obtained from the stated dimensions.

Existing warehouse buildings

Coombe laboratory under construction -
Planning permission reference 4049/19

AREAS FOR COMMUNITY GROWING TO BE
INCORPORATED WITHIN PLANTING BEDS. LOCATION
AND QUANTITIES TO BE IN AGREEMENT WITH DCC /
MANAGEMENT COMPANY

MECHANICAL PLANT WITH
LOUVERED SCREENING - REFER
TO ARCHITECT'S DRAWINGS

**BLOCK
DCC5**

**BLOCK
DCC6**

AREAS FOR COMMUNITY GROWING TO BE
INCORPORATED WITHIN PLANTING BEDS. LOCATION
AND QUANTITIES TO BE IN AGREEMENT WITH DCC /
MANAGEMENT COMPANY

EXTERNAL LAYOUT - GROUND FLOOR LEVEL
REFER TO LAYOUTS 2001, 2002, 2003 FOR
MORE DETAILS

ARTIFICIAL LAWN

SHELTER:
TIMBER PERGOLA SHELTER WITH SEATING

REFER TO 3000 SERIES FOR
DETAILS ON SOFTWORKS

LOW SHRUB MIX
TOP OF PLANTER IS LEVEL WITH CRECHE ROOF

BENCH:
TIMBER TOP SEAT WALL

SHELTER:
TIMBER PERGOLA SHELTER WITH SEATING

REFER TO 3000 SERIES FOR
DETAILS ON SOFTWORKS

REFER TO 3000 SERIES FOR
DETAILS ON SOFTWORKS

PCC PAVING:
ROOF TERRACE GREY PAVING

BENCH:
TIMBER TOP SEAT WALL

BENCH:
TIMBER TOP SEAT WALL

BENCH:
TIMBER TOP SEAT WALL

PCC PAVING:
ROOF TERRACE GREY PAVING

SEAT:
TIMBER TOP SEAT

SEAT:
TIMBER TOP SEAT

ARTIFICIAL LAWN

SHELTER:
TIMBER PERGOLA SHELTER WITH SEATING

REFER TO 3000 SERIES FOR
DETAILS ON SOFTWORKS

RUBBER PLAY SAFETY
SURFACING IN 3 COLOURS

FIRST FLOOR CRECHE PLAY AREA

CRECHE CANOPY

PCC PAVING:
ROOF TERRACE GREY PAVING