


Last saved by: KAREN.CRAWFORD/2022.11.15 | Last Plotted: 2023.11.15
 Filename: I:\A\AECOM\NET\COM\FILES\MEAD\BUN\HEDBLZ\LEGACY\HEDBLZ\PROJECTS\BP\60648061_LDA_STG_TERRASAS\900_CAD_GIS\906_LAV02_SHEETS\STG-AEC-S1B-00-00-DR-L-0004001_LANDSCAPE DETAILS SHEET.DWG
 Project Management Initials: Drawn by: KC Checked: RM Approved: PG
 ISO A1 594mm x 841mm

PROJECT
 DONORE PROJECT,
 DONORE AVENUE,
 DUBLIN 8.

CLIENT
 THE LAND DEVELOPMENT AGENCY

CONSULTANT
 AECOM
 4th Floor Adelphi Plaza,
 George's Street Upper,
 Dun Laoghaire,
 Co Dublin
 Tel: +353 (0)1 696-6220
 www.aecom.com

- NOTES**
- THIS DRAWING IS TO BE READ IN CONJUNCTION WITH ALL OTHER RELEVANT ARCHITECTURAL AND ENGINEERING DRAWINGS. ANY DISCREPANCIES, ERRORS OR OMISSIONS TO BE BROUGHT TO THE ATTENTION OF THE DESIGNER.
 - ALL DIMENSIONS TO BE CHECKED BY THE CONTRACTOR ON SITE PRIOR TO COMMENCEMENT OF WORKS.
 - AECOM LIMITED TO BE INFORMED BY THE CONTRACTOR OF ANY DISCREPANCIES PRIOR TO THE COMMENCEMENT OF WORKS ON SITE.
 - DIMENSIONS OF ALL BOUNDARIES AND ADJOINING ROADS TO BE CHECKED ON SITE PRIOR TO COMMENCEMENT OF WORKS.
 - FOR WATERMAIN LAYOUT REFER TO DRAWING STG-AEC-S1b-00-00-DR-C-0002700.
 - FOR DRAINAGE LAYOUT REFER TO DRAWING STG-AEC-S1b-00-00-DR-C-0000501.

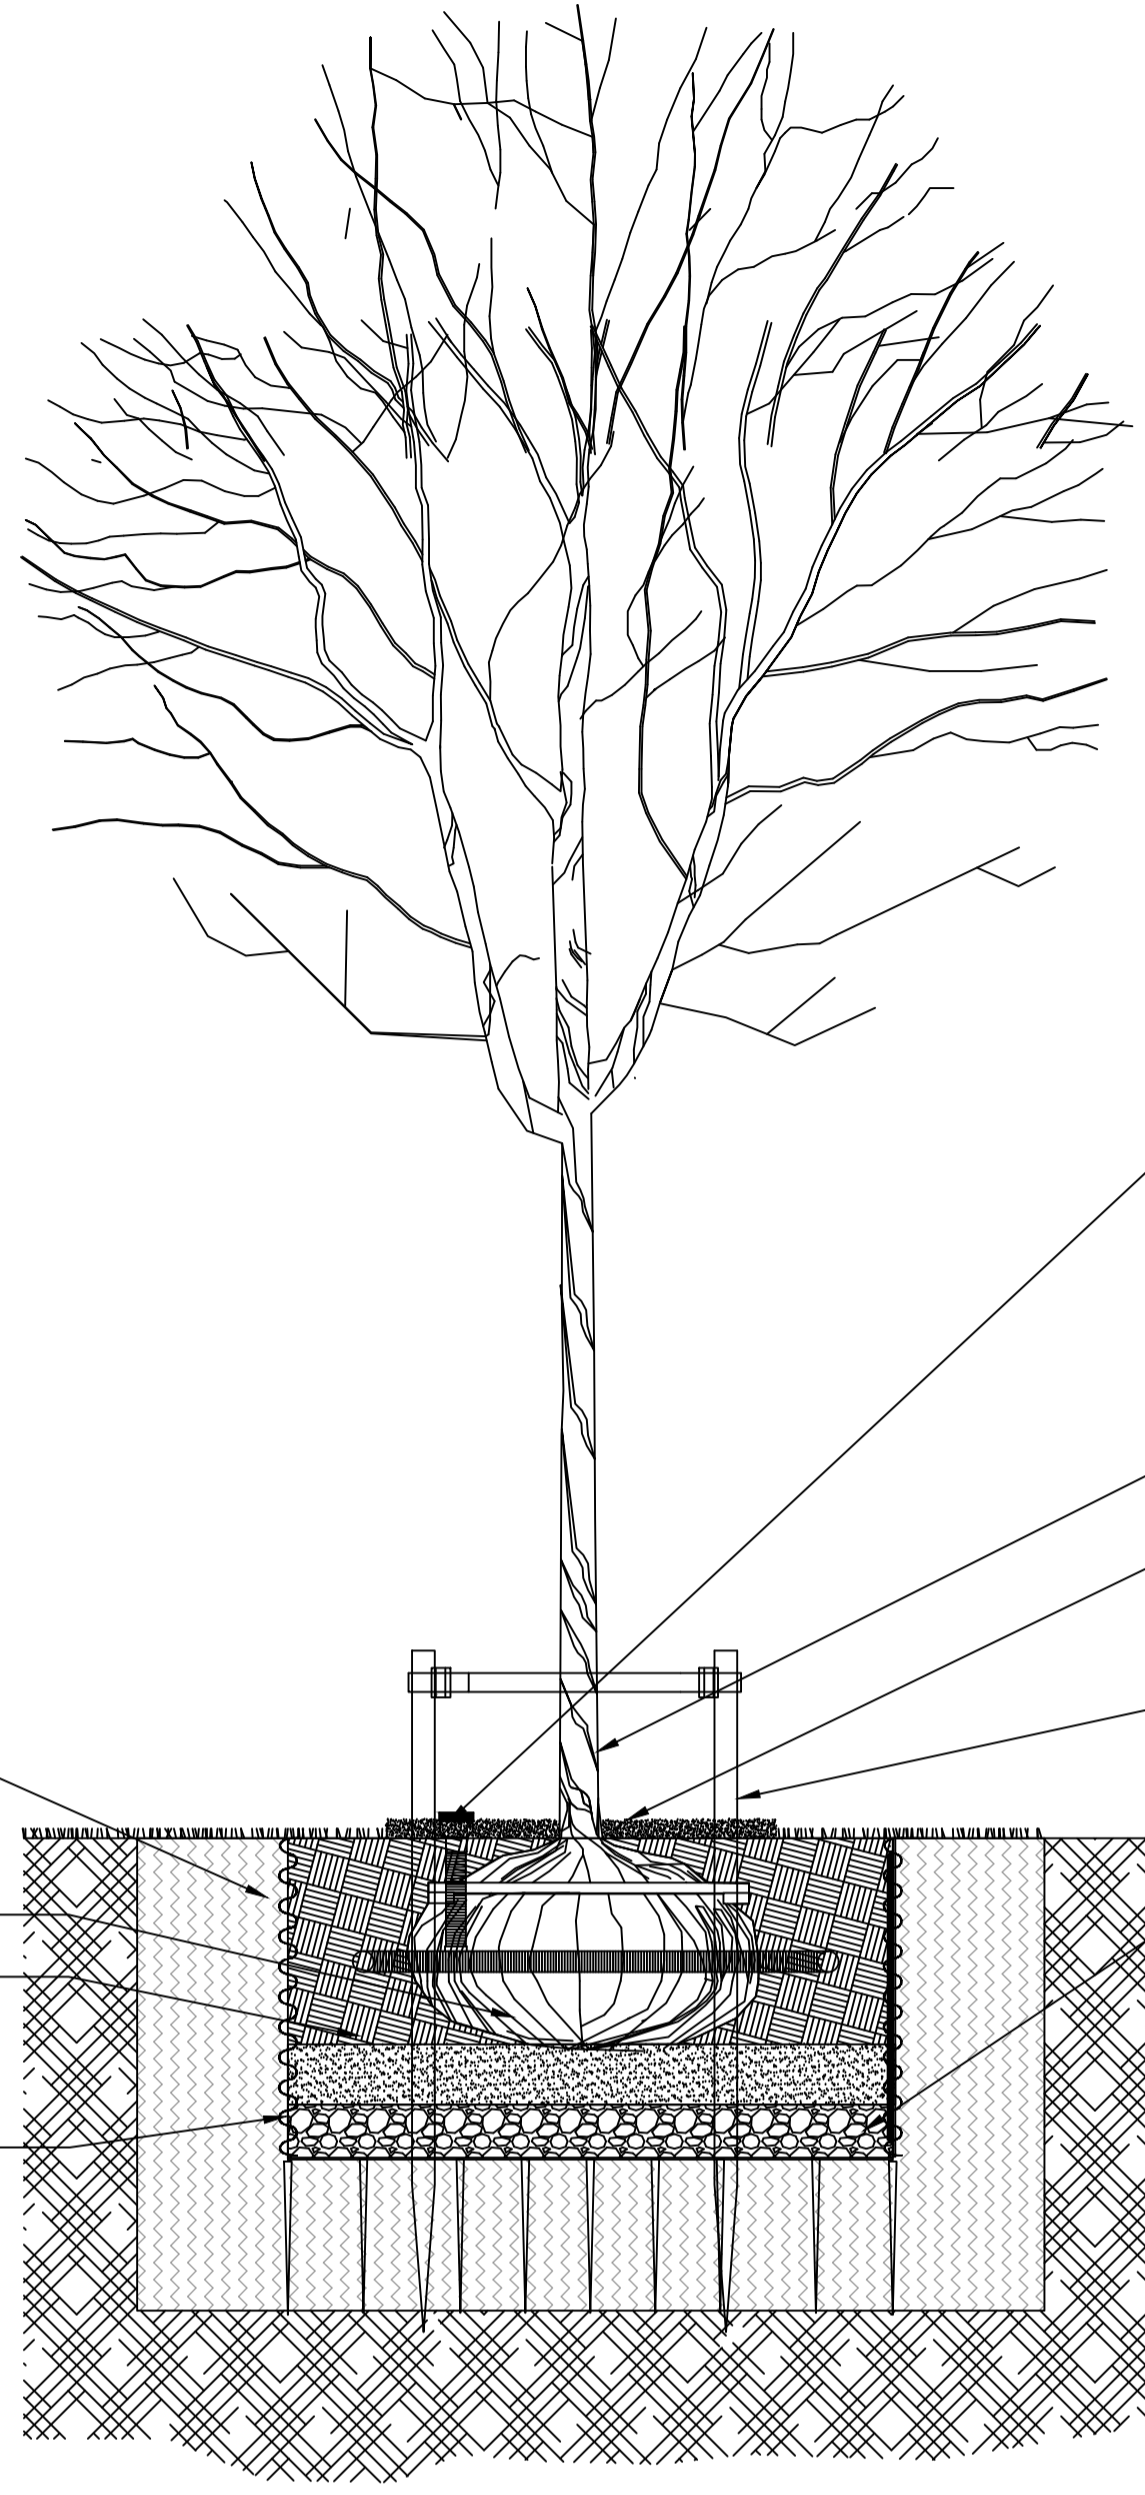

ADJACENT SOFTWORKS CONDITIONS

TREE ROOTBALL

TOPSOIL / BACKFILL MIX TO TREE PITS AS PER SPECIFICATION

SIDES OF PIT SCARIFIED TO REMOVE SMEARING

WATERING/AERATION SYSTEM - PERFORATED PVC WATERING AND AERATION SYSTEM. CAPPED PIPE TO BE LOCATED ACCURATELY AND CONSISTENTLY AND FINISHED FLUSH WITH GROUND LEVEL.


SEMI-MATURE STANDARD TREES.

75MM DEPTH ORNAMENTAL GRADE BARK MULCH RING


2 X 75MM STAKES SECURED WITH 2NO. RUBBER BELT AND SPACER TIES. STAKES TO SIT 450MM ABOVE THE GROUND EITHER SIDE OF TREE PARALLEL TO SLOPE

150MM CLEAN STONE DRAINAGE LAYER WRAPPED IN NON WOVEN GEOTEXTILE.


01 TYPICAL SEMI - MATURE TREE IN SOFT LANDSCAPING (GROUND LEVEL)
 4002 SCALE 1:20 @A1

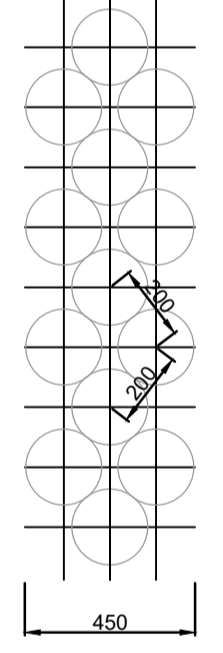


NOTE: PLEASE REFER TO ENGINEER'S DRAWINGS AND SPECIFICATION FOR INFORMATION ON THE SWALE AND RAIN GARDEN DESIGN

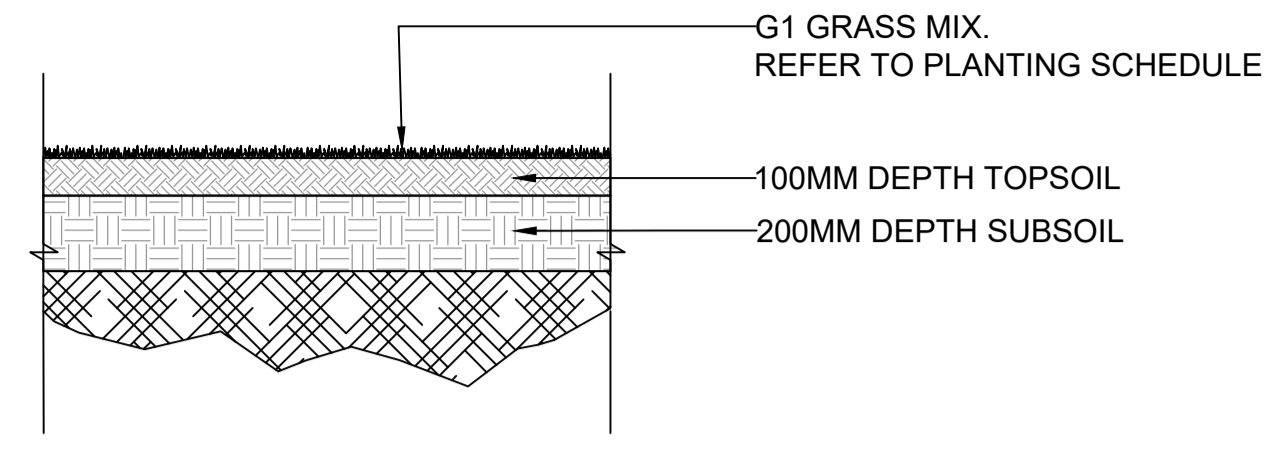

02 TYPICAL GRASS PLANTING
 4002 SCALE 1:20 @A1

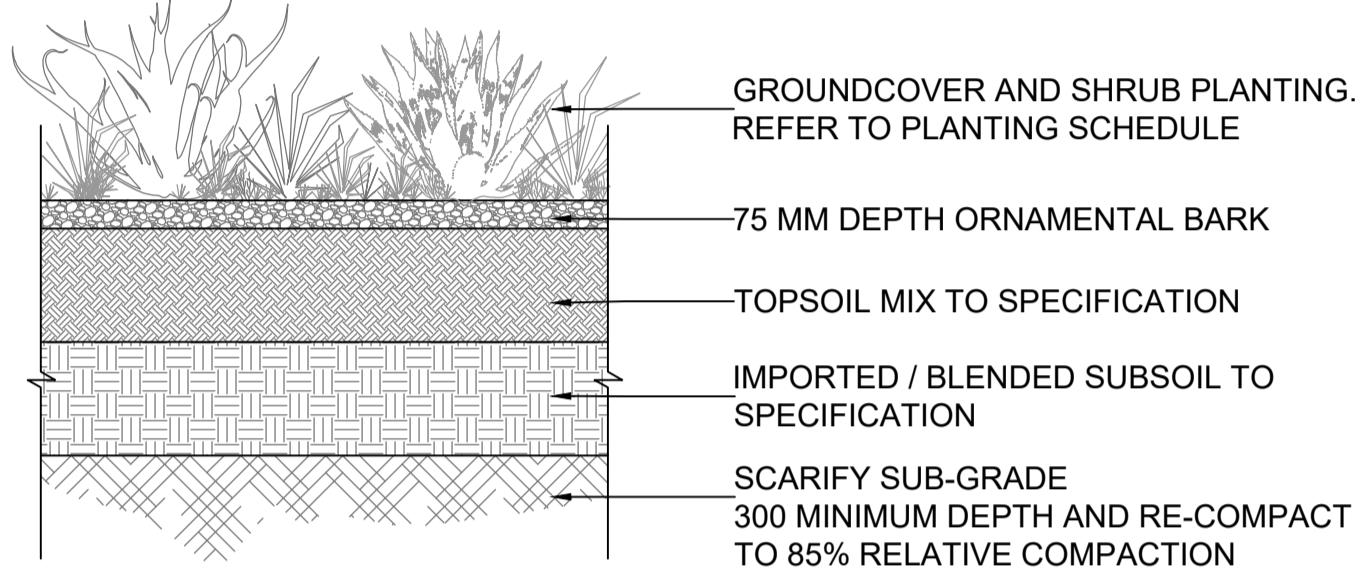

03 TYPICAL SHRUB PLANTING
 4002 SCALE 1:20 @A1

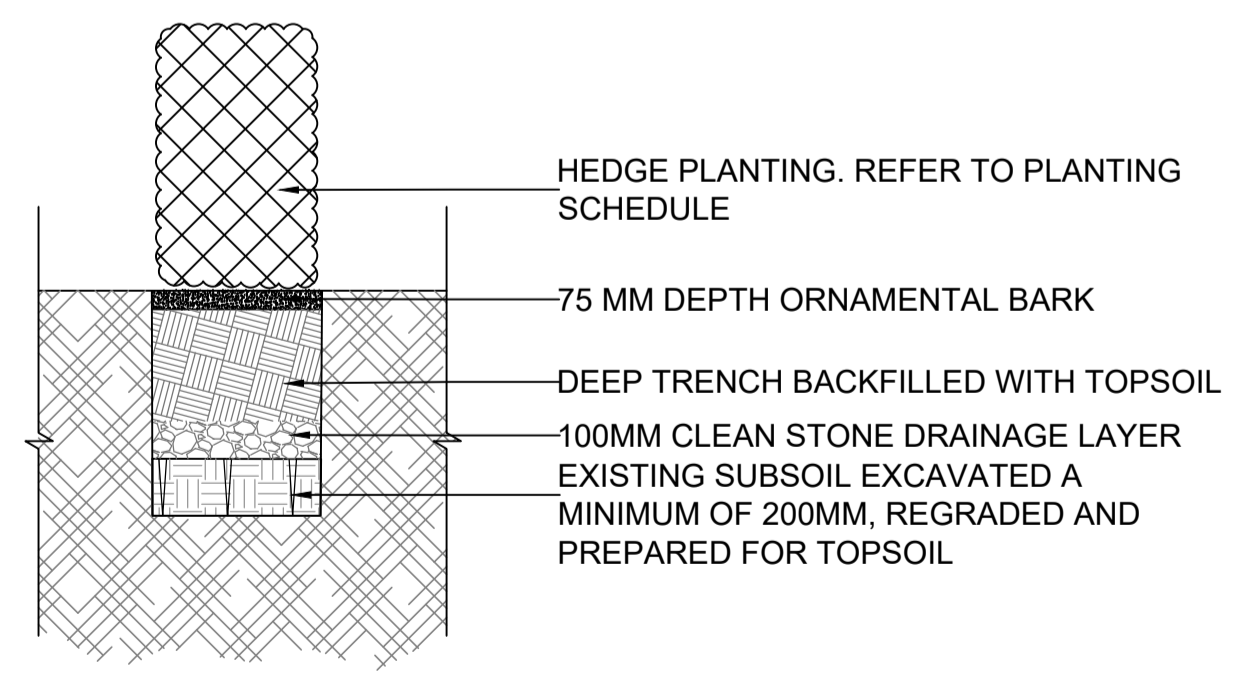

04 TYPICAL HEDGEROW PLANTING
 4002 SCALE 1:20 @A1

ISSUE/REVISION		
P1	DATE	DESCRIPTION
P1	DEC 2022	ISSUED FOR PLANNING
I/R	DATE	DESCRIPTION

PROJECT NUMBER
 60648061

SHEET TITLE
 LANDSCAPE DETAILS
 SHEET 2 OF 6

SHEET NUMBER
 STG-AEC-S1b-00-00-DR-L-0004002

This drawing has been prepared for the use of AECOM's client. It may not be used, modified, reproduced or relied upon by third parties, except as agreed by AECOM or as required by law. AECOM accepts no responsibility, and denies any liability, whatsoever, to any party that uses or relies on this drawing without AECOM's express written consent. Do not scale this document. All measurements must be obtained from the stated dimensions.