

### PROJECT

DONORE PROJECT,  
DONORE AVENUE,  
DUBLIN 8.

### CLIENT

THE LAND DEVELOPMENT AGENCY

### CONSULTANT

AECOM  
4th Floor Adelphi Plaza,  
George's Street Upper,  
Dun Laoghaire,  
Co Dublin  
Tel: +353 (0)1 696-6220  
www.aecom.com


### NOTES

- THIS DRAWING IS TO BE READ IN CONJUNCTION WITH ALL OTHER RELEVANT ARCHITECTURAL AND ENGINEERING DRAWINGS. ANY DISCREPANCIES, ERRORS OR OMISSIONS TO BE BROUGHT TO THE ATTENTION OF THE DESIGNER.
- ALL DIMENSIONS TO BE CHECKED BY THE CONTRACTOR ON SITE PRIOR TO COMMENCEMENT OF WORKS.
- AECOM LIMITED TO BE INFORMED BY THE CONTRACTOR OF ANY DISCREPANCIES PRIOR TO THE COMMENCEMENT OF WORKS ON SITE.
- DIMENSIONS OF ALL BOUNDARIES AND ADJOINING ROADS TO BE CHECKED ON SITE PRIOR TO COMMENCEMENT OF WORKS.
- FOR WATERMAIN LAYOUT REFER TO DRAWING STG-AEC-S1b-00-00-DR-C-0002700.
- FOR DRAINAGE LAYOUT REFER TO DRAWING STG-AEC-S1b-00-00-DR-C-0000501.

This drawing has been prepared for the use of AECOM's client. It may not be used, modified, reproduced or relied upon by third parties, except as agreed by AECOM or as required by law. AECOM accepts no responsibility, and denies any liability, whatsoever, to any party that uses or relies on this drawing without AECOM's express written consent. Do not scale this document. All measurements must be obtained from the stated dimensions.

REFER TO CIVIL ENGINEER'S TYPICAL ROAD DETAILS DRAWING FOR INFORMATION ON ROAD KERB (125 UPSTAND)

01 TYPICAL DETAIL: ROAD KERB (125MM UPSTAND)  
4004 SCALE 1:20 @A1

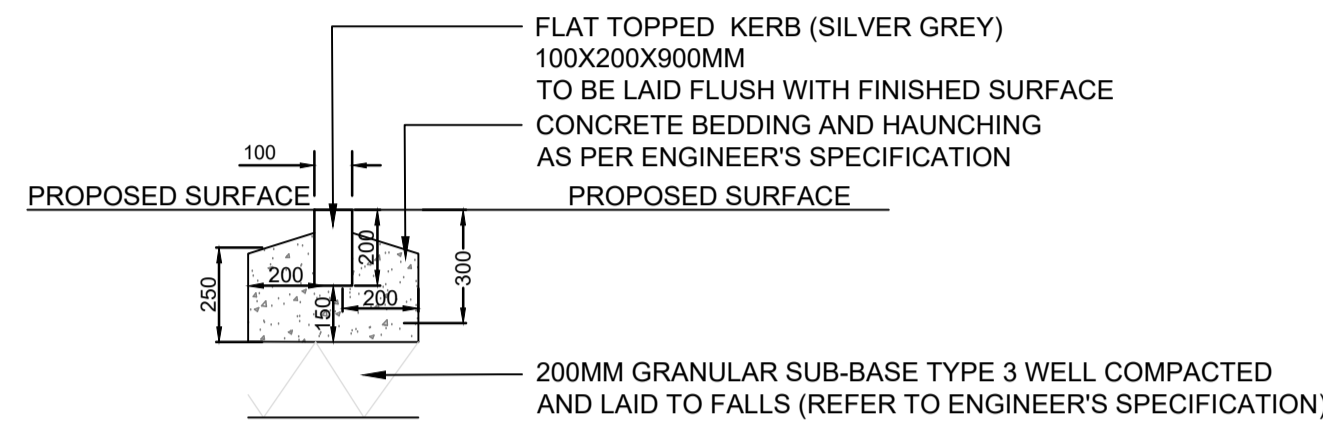


REFER TO CIVIL ENGINEER'S TYPICAL ROAD DETAILS DRAWING FOR INFORMATION ON ROAD KERB (FLUSH 6MM)

02 TYPICAL DETAIL: ROAD KERB (FLUSH - 6MM)  
4004 SCALE 1:20 @A1

REFER TO CIVIL ENGINEER'S TYPICAL ROAD DETAILS DRAWING FOR INFORMATION ON ASPHALT ROAD SURFACE

05 TYPICAL DETAIL: ASPHALT ROAD SURFACE  
4004 SCALE 1:20 @A1



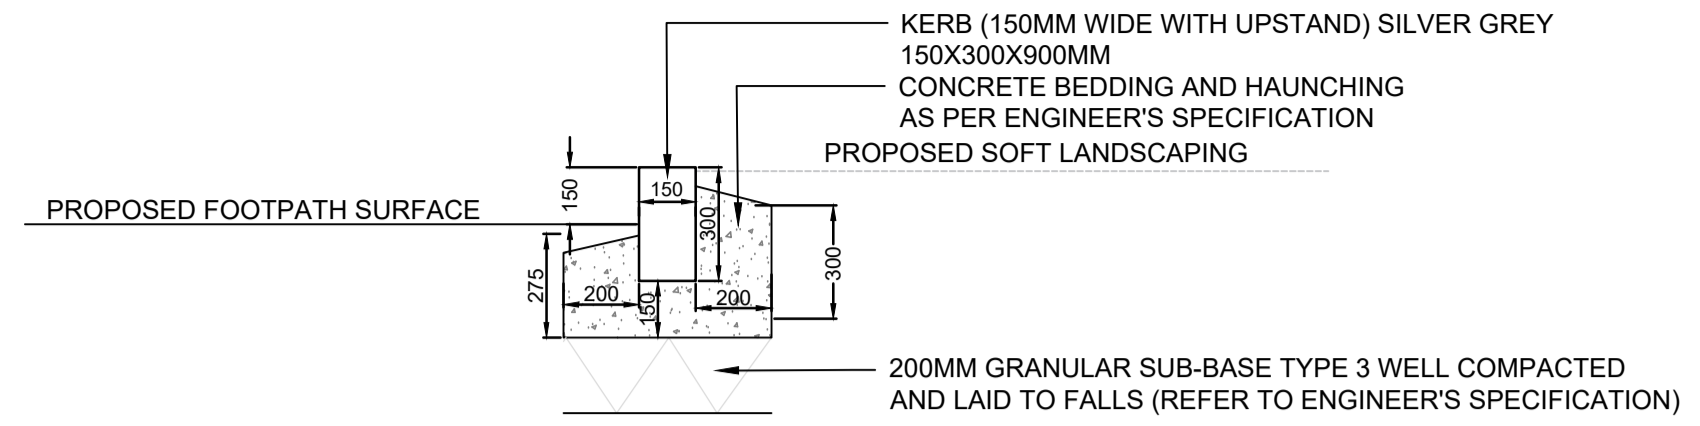


03 TYPICAL DETAIL: KERB WITH UPSTAND (TO SOFT LANDSCAPED AREAS)  
4004 SCALE 1:20 @A1

REFER TO CIVIL ENGINEER'S TYPICAL ROAD DETAILS DRAWING FOR INFORMATION ON ASPHALT PARKING SURFACE (PERMEABLE)

06 TYPICAL DETAIL: ASPHALT PARKING SURFACE (PERMEABLE)  
4004 SCALE 1:20 @A1




04 TYPICAL DETAIL: FLAT TOPPED KERB (TO SITE BOUNDARY)  
4004 SCALE 1:20 @A1

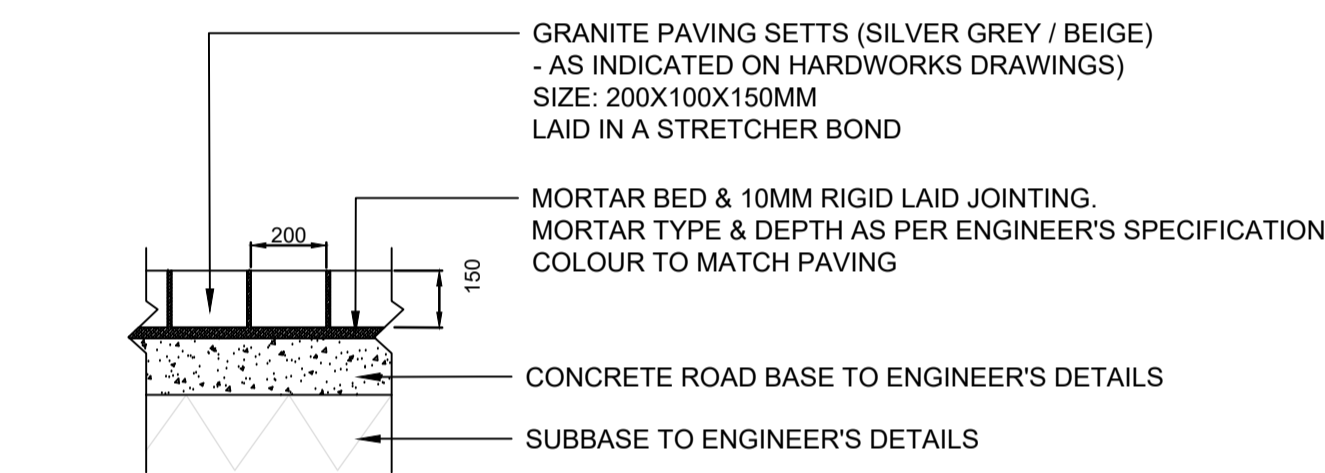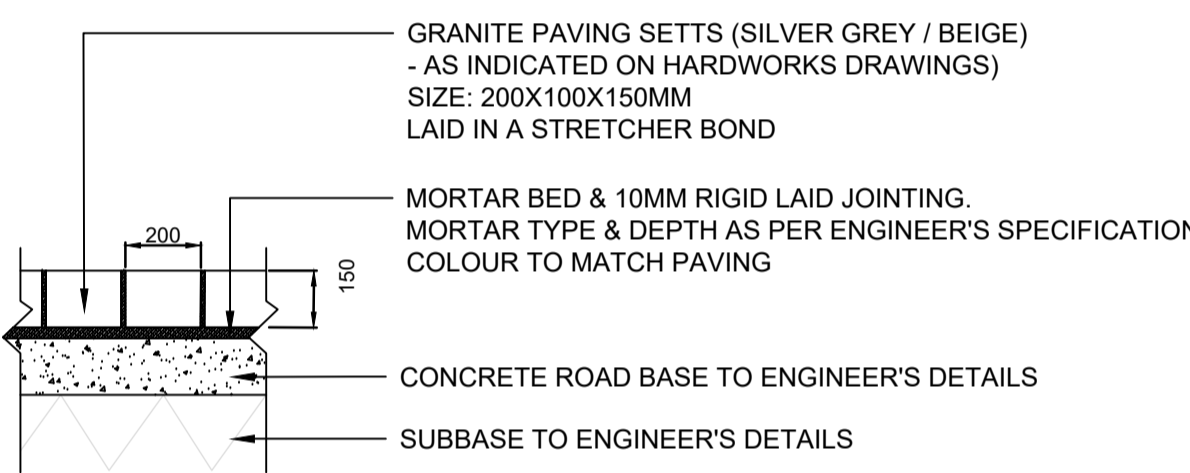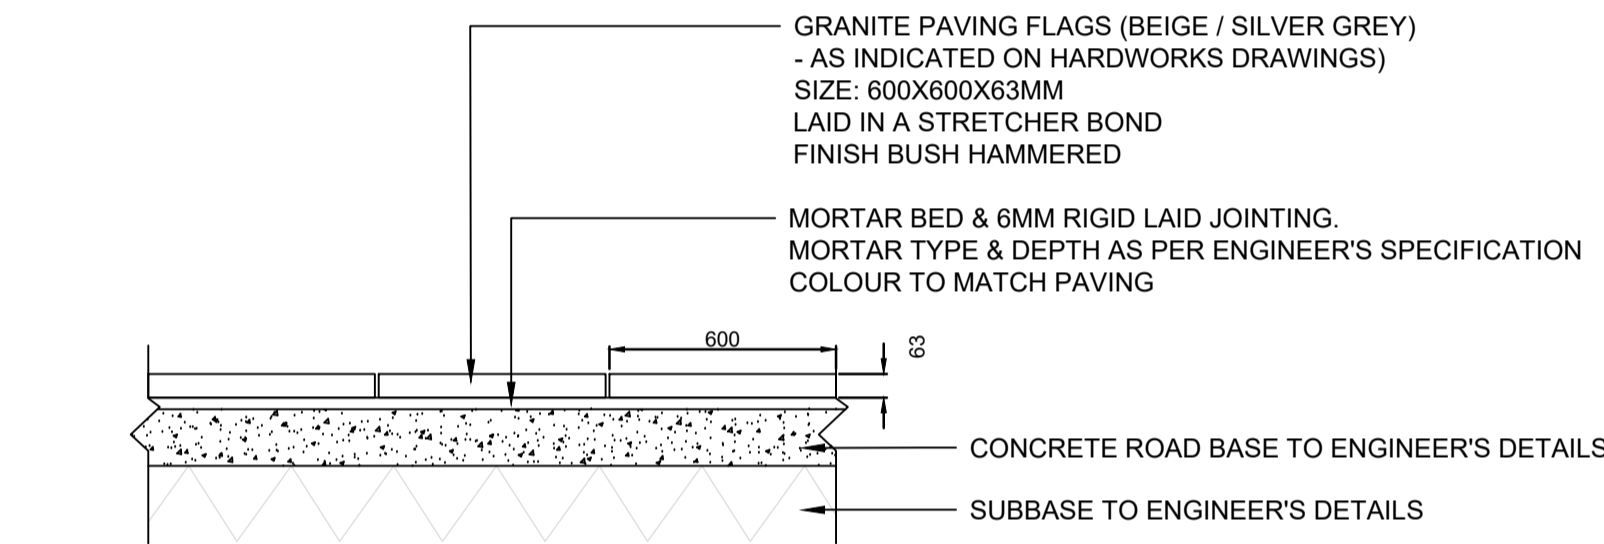

07 TYPICAL DETAIL: HIGH QUALITY PAVING (TYPES A / B)  
4004 SCALE 1:20 @A1

08 TYPICAL DETAIL: HEAVY VEHICLE PAVING (TYPES A / B)  
4004 SCALE 1:20 @A1


09 TYPICAL DETAIL: HIGH QUALITY PAVING (SHARED SURFACE)  
4004 SCALE 1:20 @A1

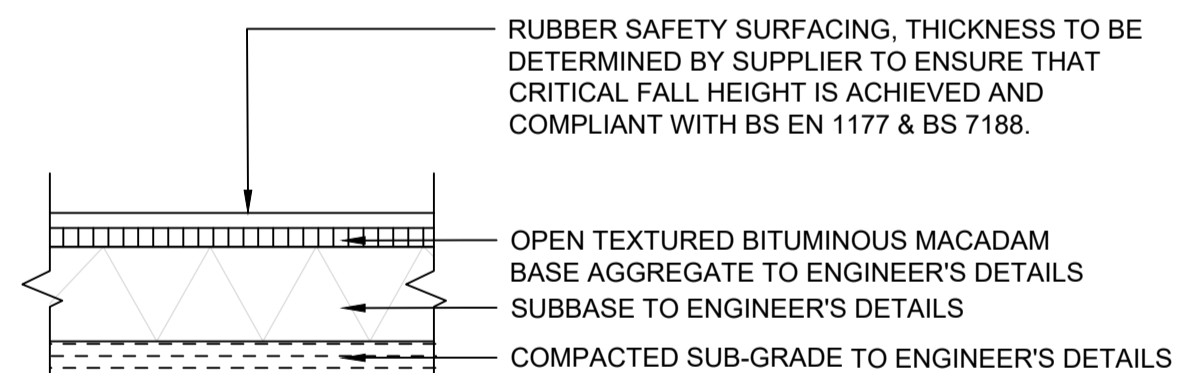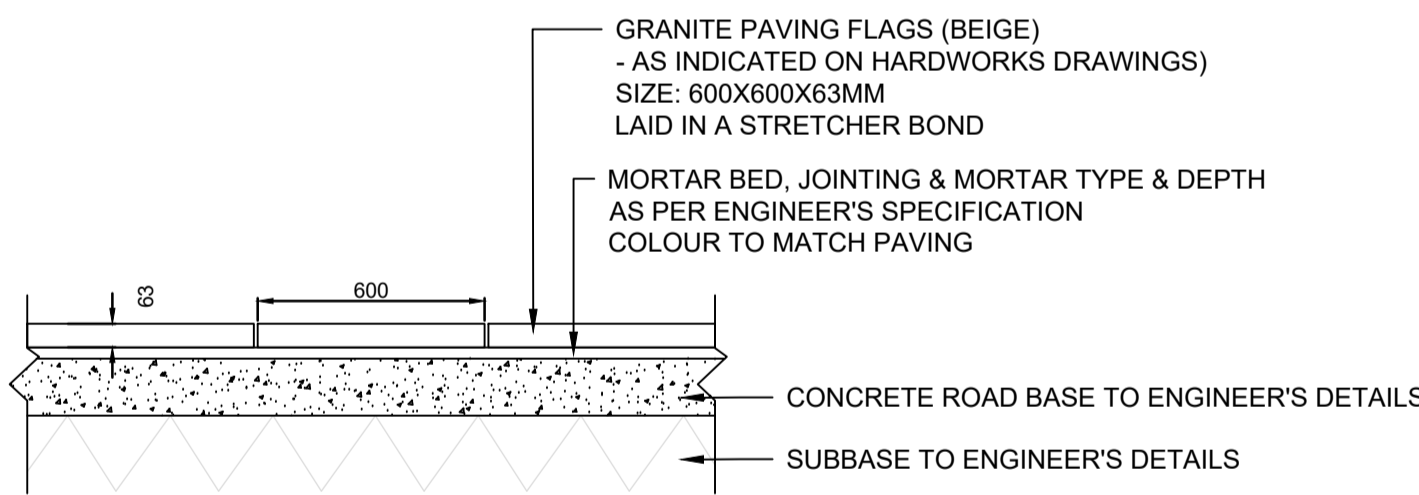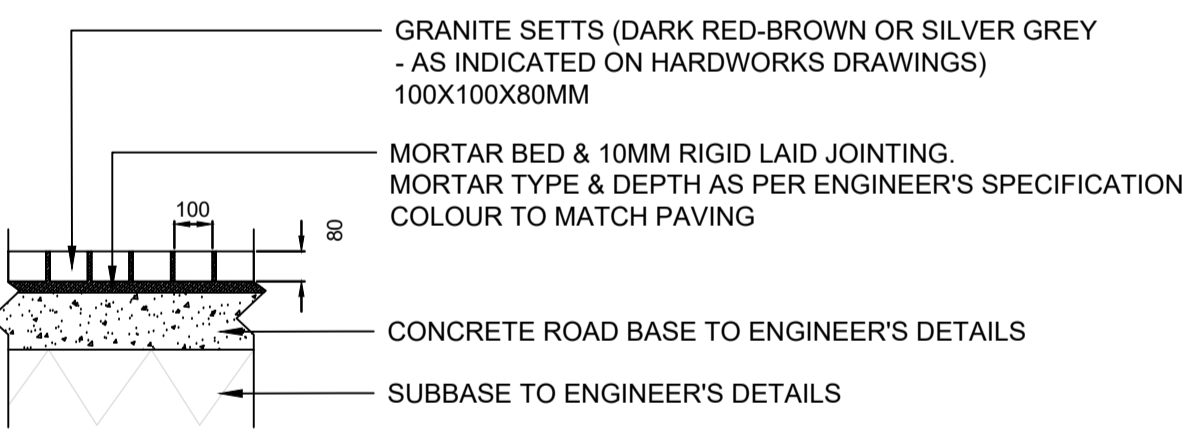

10 TYPICAL DETAIL: PAVING BAND  
4004 SCALE 1:20 @A1

11 TYPICAL DETAIL: PAVING TO FOOTPATHS  
4004 SCALE 1:20 @A1

12 TYPICAL DETAIL: SURFACING TO INFORMAL PLAY SPACES  
4004 SCALE 1:20 @A1

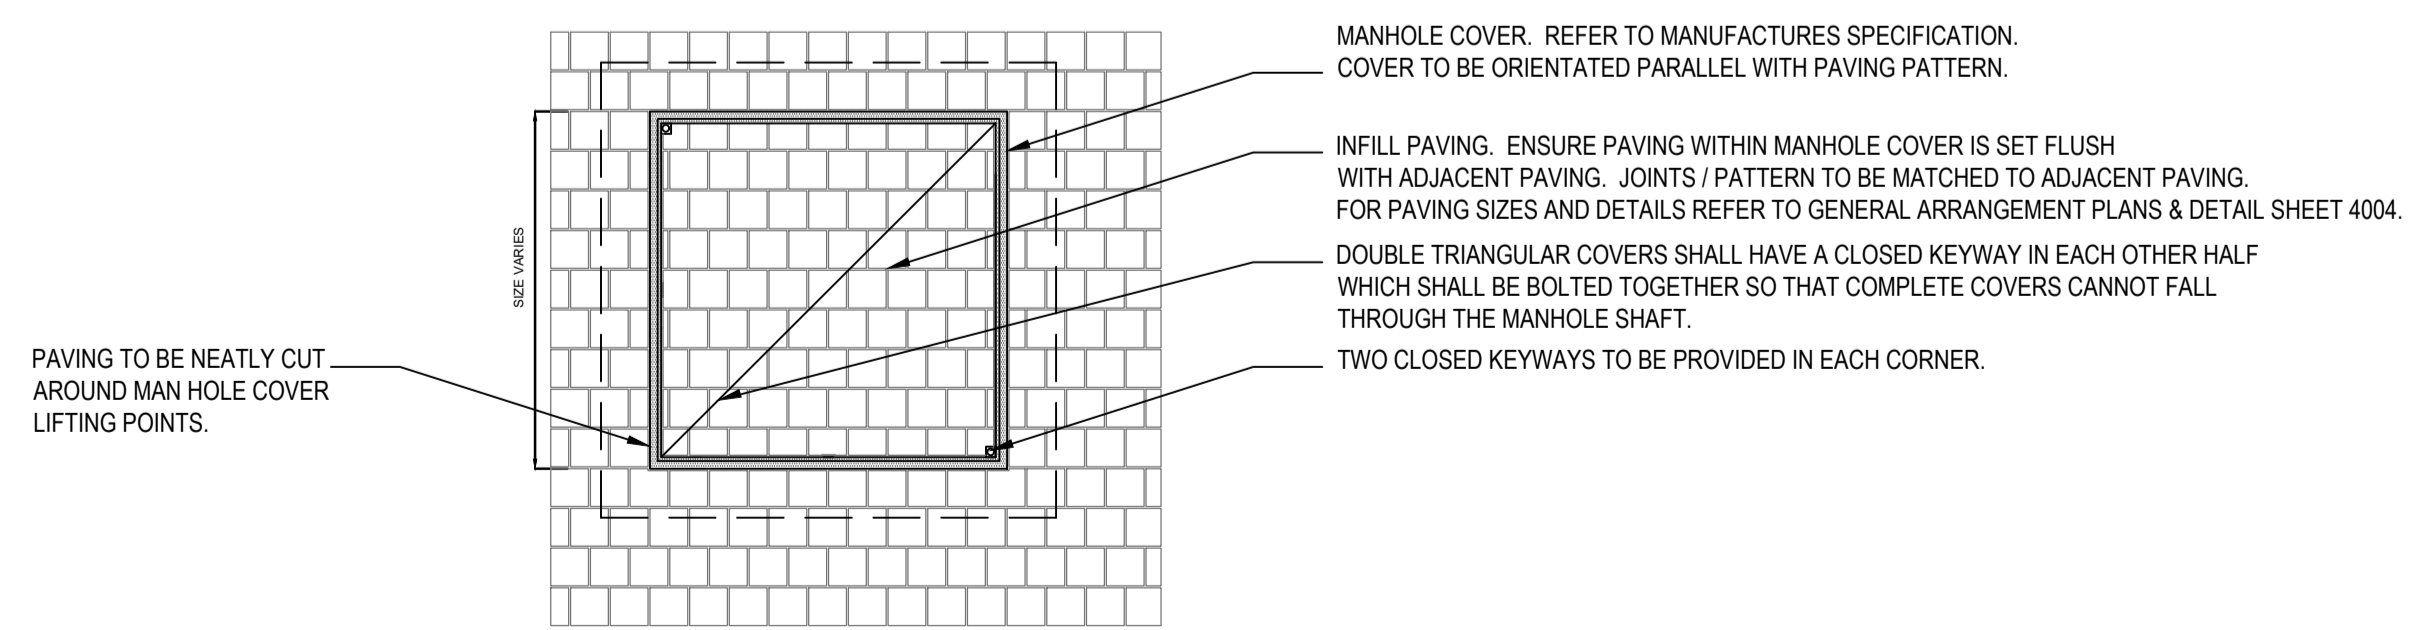

13 TYPICAL DETAIL: RECESSED PAVING COVER  
4004 SCALE 1:20 @A1

### ISSUE/REVISION

I/R	DATE	DESCRIPTION
P1	DEC 2022	ISSUED FOR PLANNING

### PROJECT NUMBER

60648061

### SHEET TITLE

LANDSCAPE DETAILS  
SHEET 4 OF 6

### SHEET NUMBER

STG-AEC-S1b-00-00-DR-L-0004004