

PROJECT

DONORE PROJECT,
DONORE AVENUE,
DUBLIN 8.

CLIENT


THE LAND DEVELOPMENT AGENCY

CONSULTANT

AECOM
4th Floor Adelphi Plaza,
George's Street Upper,
Dun Laoghaire,
Co Dublin
Tel: +353 (0)1 696-6220
www.aecom.com

NOTES

1. THIS DRAWING IS TO BE READ IN CONJUNCTION WITH ALL OTHER RELEVANT ARCHITECTURAL AND ENGINEERING DRAWINGS. ANY DISCREPANCIES, ERRORS OR OMISSIONS TO BE BROUGHT TO THE ATTENTION OF THE DESIGNER.
2. ALL DIMENSIONS TO BE CHECKED BY THE CONTRACTOR ON SITE PRIOR TO COMMENCEMENT OF WORKS.
3. AECOM LIMITED TO BE INFORMED BY THE CONTRACTOR OF ANY DISCREPANCIES PRIOR TO THE COMMENCEMENT OF WORKS ON SITE.
4. DIMENSIONS OF ALL BOUNDARIES AND ADJOINING ROADS TO BE CHECKED ON SITE PRIOR TO COMMENCEMENT OF WORKS.
5. FOR WATERMAIN LAYOUT REFER TO DRAWING STG-AEC-S1b-00-00-DR-C-0002700.
6. FOR DRAINAGE LAYOUT REFER TO DRAWING STG-AEC-S1b-00-00-DR-C-0000501.

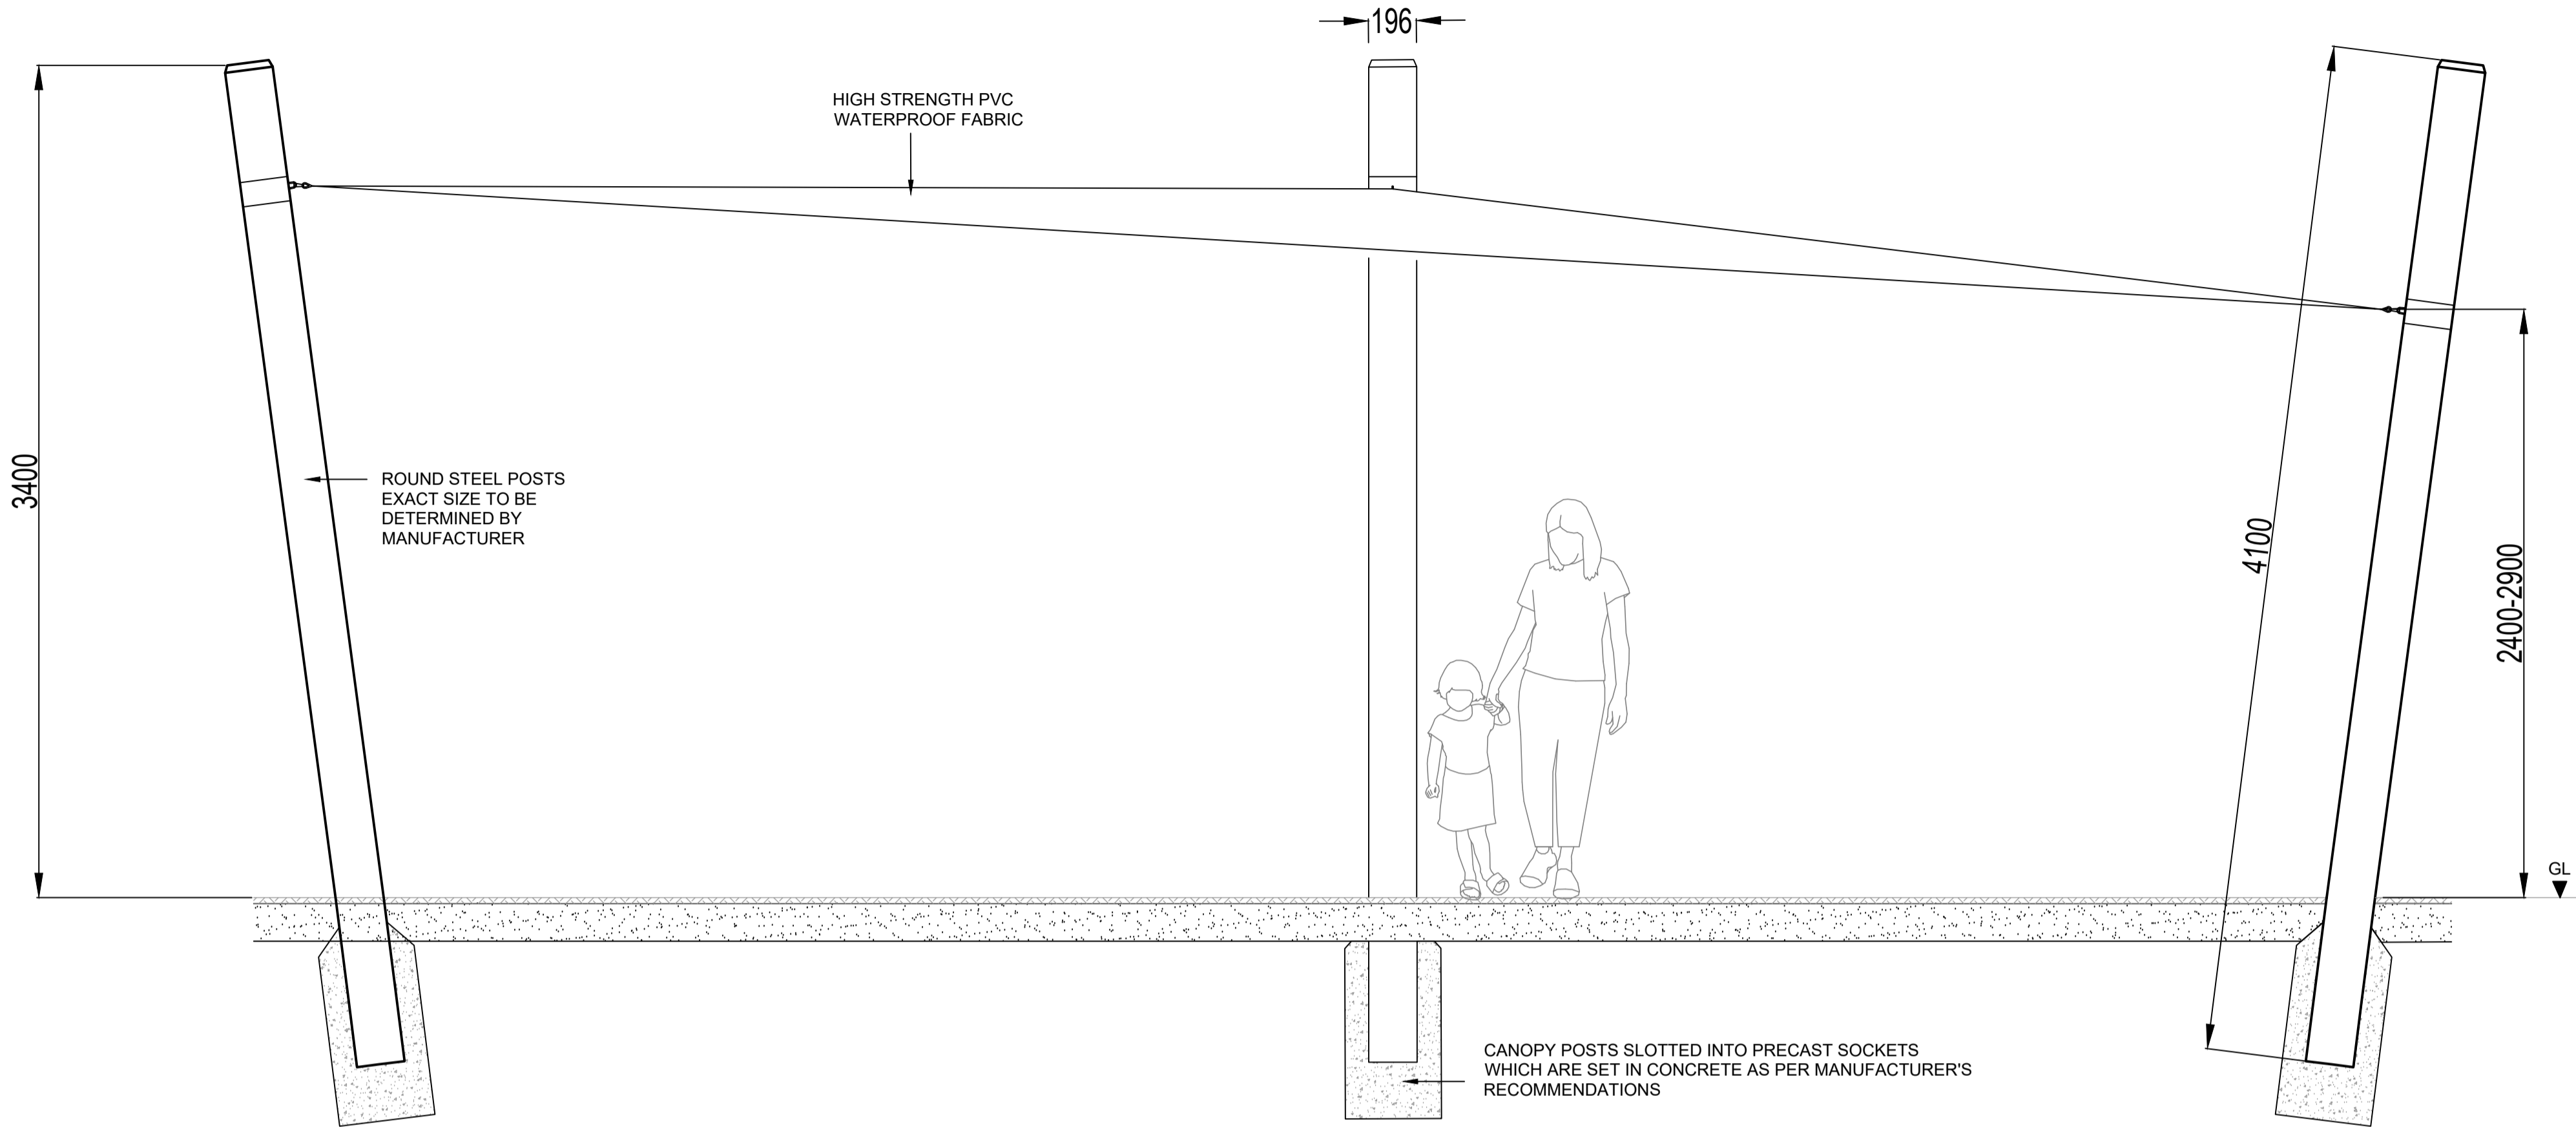

DETAIL REPRESENTING THE DESIGN INTENT FOR THE CANOPY STRUCTURE.



PRECEDENT IMAGE REPRESENTING THE DESIGN INTENT FOR THE CANOPY STRUCTURE.

CANOPY STRUCTURE - DESIGN INTENT

STEELS POSTS
ROUND POSTS, HEAVY DUTY STEEL TO MANUFACTURER'S RECOMMENDATIONS
GALVANISED TO BS EN ISO 1461:2009 & POLYESTER POWDER COATED FINISH
(2NO. COATS) FACTORY FINISHED
COLOUR: SQUIRREL GREY (RAL 7000)

POST PADS/PROTECTOR TO BE INCLUDED ON ALL POSTS
COLOUR: TO MATCH POST COLOUR

CANOPY FABRIC
HIGH STRENGTH WATERPROOF PVC FABRIC
WITH APPROPRIATE GUARANTEE
100% UV PROTECTION
COLOUR: SANDY BEIGE

ALL FIXTURES AND FITTINGS TO BE HOT DIPPED GALVANISED AND INSTALLED AS PER MANUFACTURER'S RECOMMENDATIONS

WIND LOADING AND SAFETY INFORMATION TO BE PROVIDED BY MANUFACTURER. MANUFACTURER TO ENSURE CANOPY SUITABLE FOR SPECIFIC INSTALLATION LOCATION AND APPROPRIATE GUARANTEE TO BE PROVIDED

ISSUE/REVISION

NO	DATE	DESCRIPTION
P1	DEC 2022	ISSUED FOR PLANNING
I/R	DATE	DESCRIPTION

PROJECT NUMBER

60648061

SHEET TITLE

LANDSCAPE DETAILS
SHEET 6 OF 6

SHEET NUMBER

STG-AEC-S1b-00-00-DR-L-0004006