

Last saved by: DEGEUSY(2022-11-17) Last Picked: 2022-11-18
 Filename: \\WA.AECOM\NET\COM\FSE\EA\DU\BL\IN\ED\BL\2\LEGACY\IED\BL\2\FP001\DATA\DCS\PROJECTS\BP\60648061_LDA_STG_TERESAS\900_CAD_GIS\906_LAV02_SHEETS\STG-AEC-S1b-00-00-DR-L-0005001_LANDSCAPE SECTION SHEET.DWG
 Project Management Initials: Drawn by: KC Checked: RM Approved: PG
 ISO A1 594mm x 841mm



PROJECT
 DONORE PROJECT,
 DONORE AVENUE,
 DUBLIN 8.


CLIENT
 THE LAND DEVELOPMENT AGENCY

CONSULTANT
 AECOM
 4th Floor Adelphi Plaza,
 George's Street Upper,
 Dun Laoghaire,
 Co Dublin
 Tel: +353 (0)1 696-6220
 www.aecom.com


- NOTES**
- THIS DRAWING IS TO BE READ IN CONJUNCTION WITH ALL OTHER RELEVANT ARCHITECTURAL AND ENGINEERING DRAWINGS. ANY DISCREPANCIES, ERRORS OR OMISSIONS TO BE BROUGHT TO THE ATTENTION OF THE DESIGNER.
 - ALL DIMENSIONS TO BE CHECKED BY THE CONTRACTOR ON SITE PRIOR TO COMMENCEMENT OF WORKS.
 - AECOM LIMITED TO BE INFORMED BY THE CONTRACTOR OF ANY DISCREPANCIES PRIOR TO THE COMMENCEMENT OF WORKS ON SITE.
 - DIMENSIONS OF ALL BOUNDARIES AND ADJOINING ROADS TO BE CHECKED ON SITE PRIOR TO COMMENCEMENT OF WORKS.
 - FOR WATERMAIN LAYOUT REFER TO DRAWING STG-AEC-S1b-00-00-DR-C-0002700.
 - FOR DRAINAGE LAYOUT REFER TO DRAWING STG-AEC-S1b-00-00-DR-C-0000501.



3 SECTION C-C
 5002 Scale 1:100

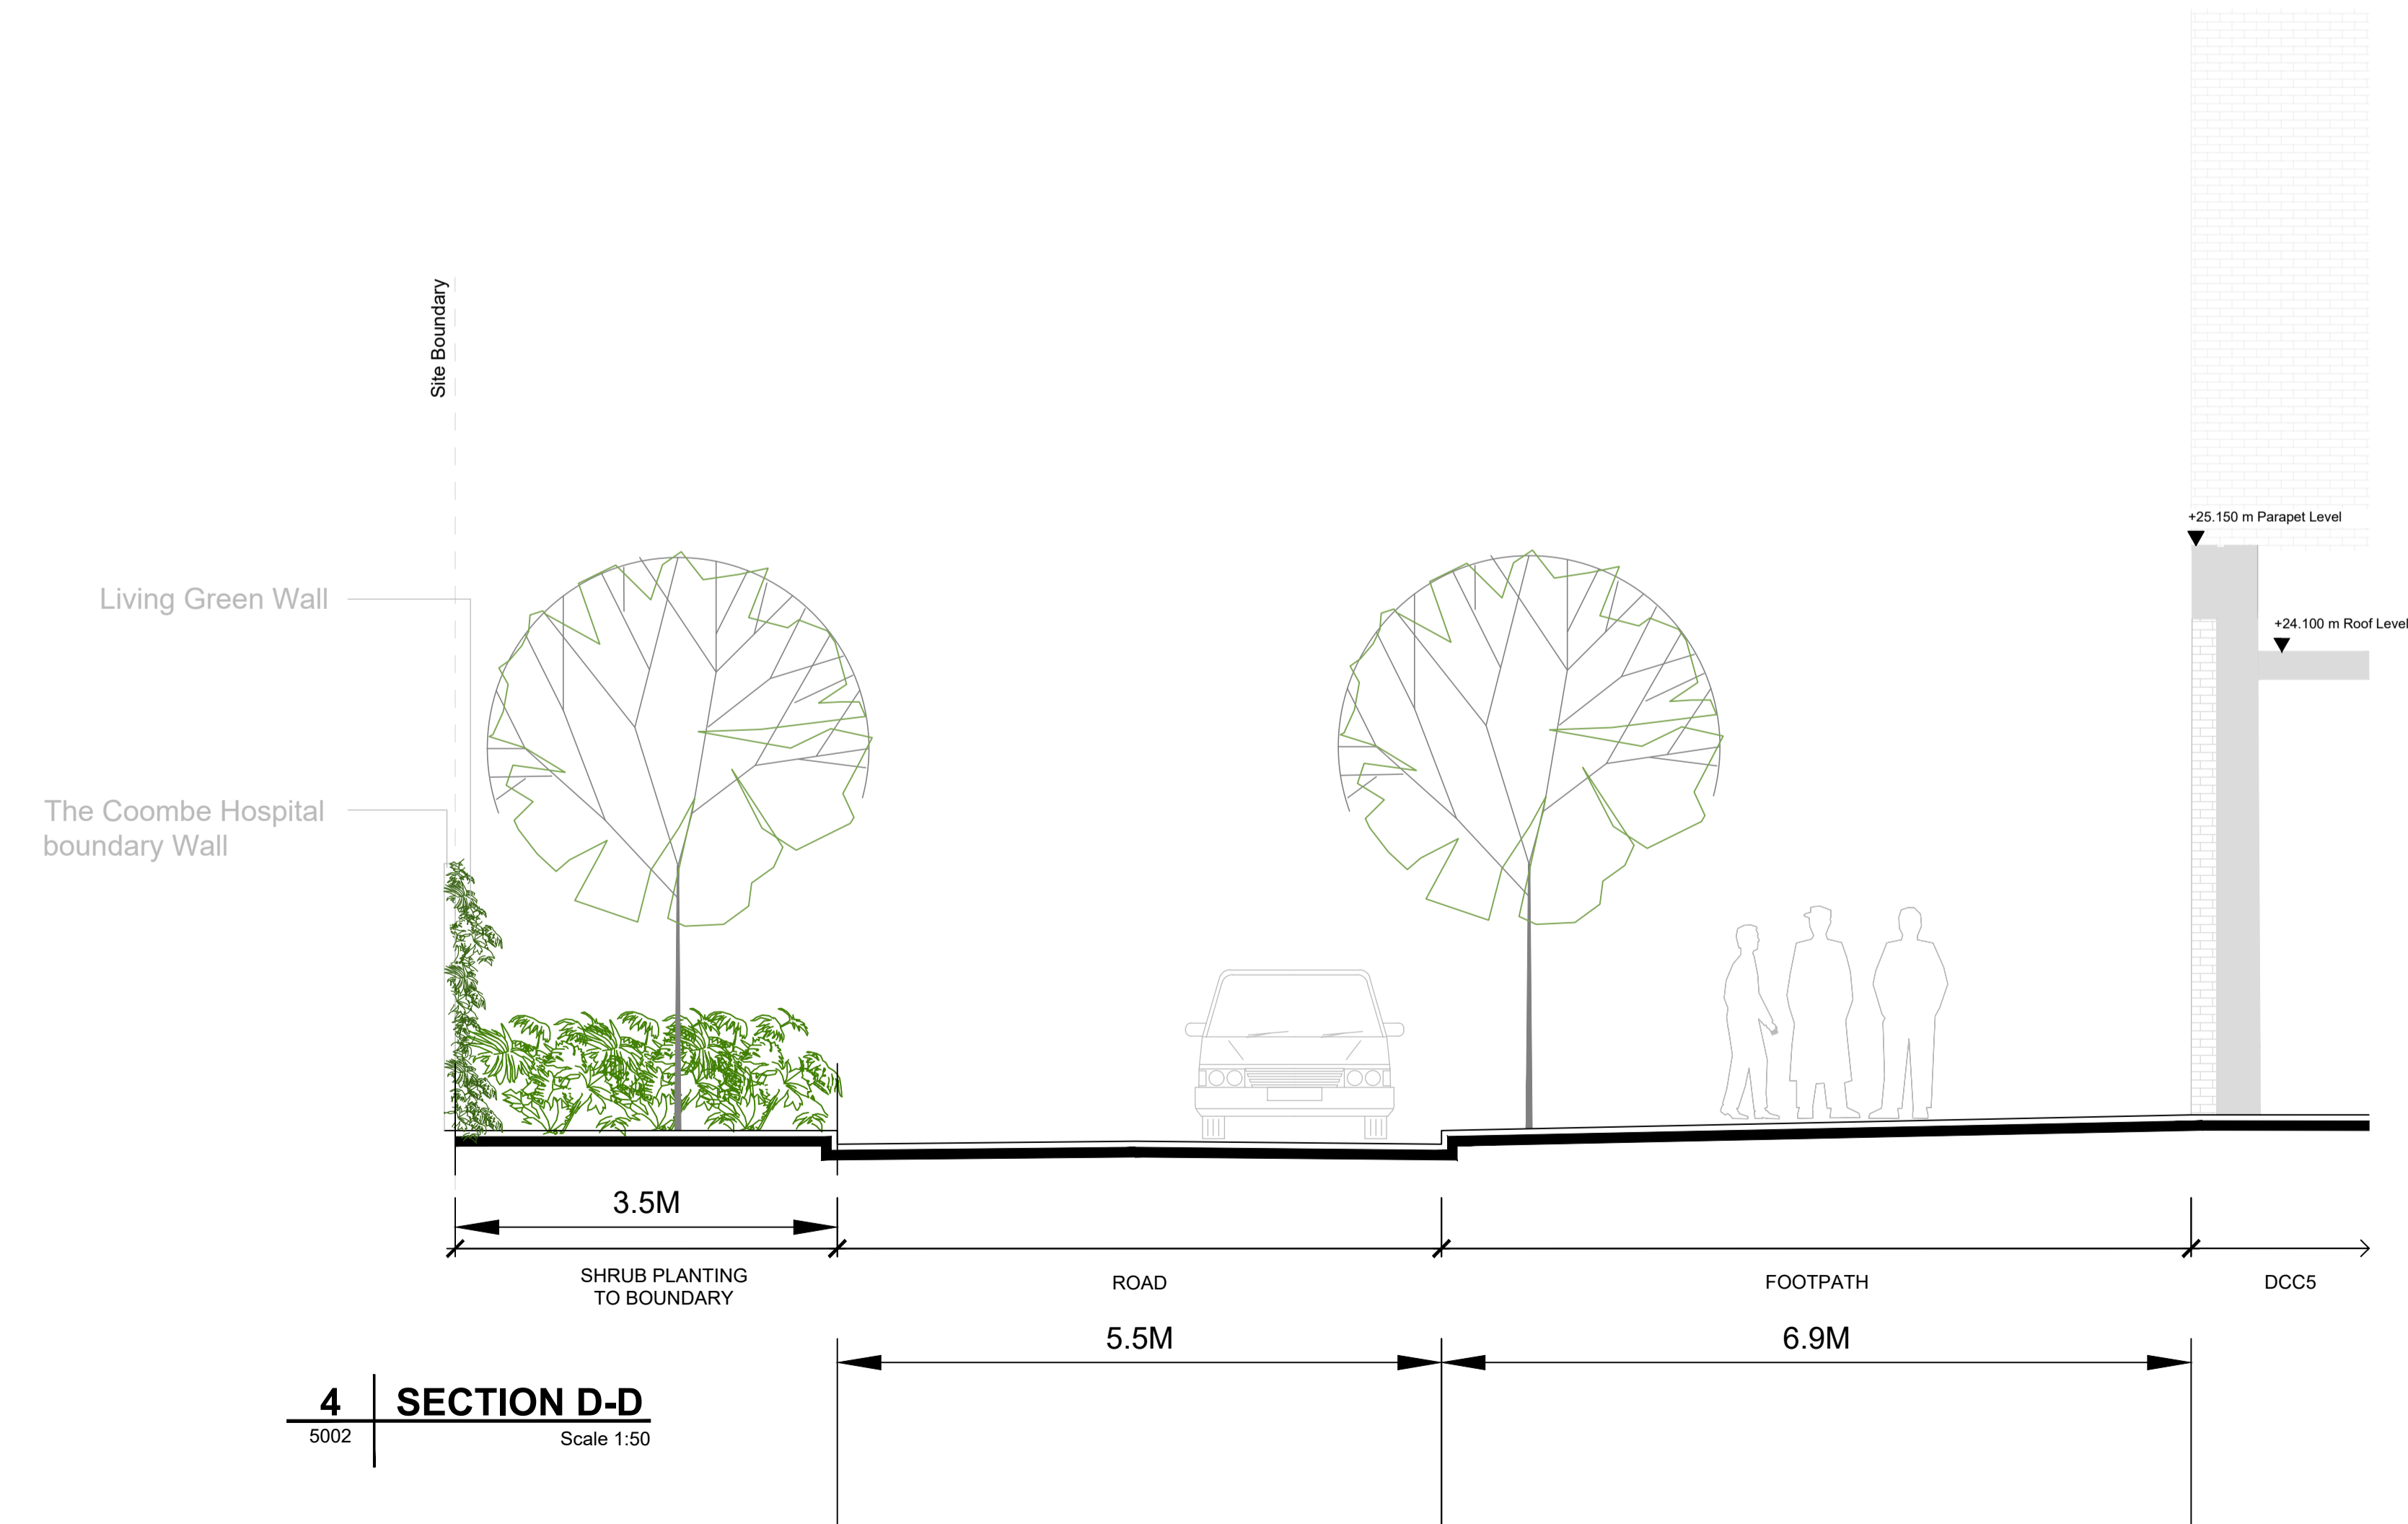

4 SECTION D-D
 5002 Scale 1:50

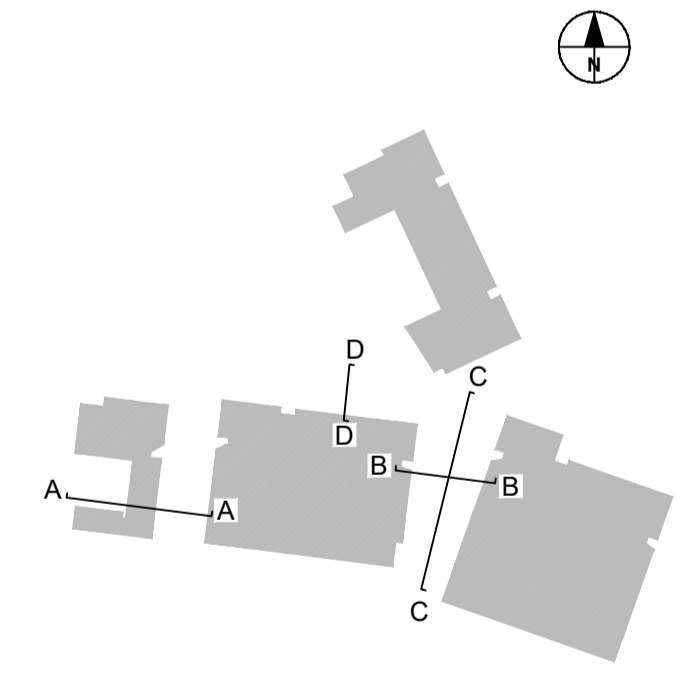

ISSUE/REVISION

NO	DATE	DESCRIPTION
P1	DEC 2022	ISSUED FOR PLANNING
I/R	DATE	DESCRIPTION

PROJECT NUMBER
 60648061

SHEET TITLE
 LANDSCAPE SECTIONS
 SHEET 2 OF 2

SHEET NUMBER
 STG-AEC-S1b-00-00-DR-L-0005002

This drawing has been prepared for the use of AECOM's client. It may not be used, modified, reproduced or relied upon by third parties, except as agreed by AECOM or as required by law. AECOM accepts no responsibility, and denies any liability, whatsoever, for any party that uses or relies on this drawing without AECOM's express written consent. Do not scale this document. All measurements must be obtained from the stipulated dimensions.