


Luminaire A Data		Luminaire B Data	
Supplier	Item	Supplier	Item
Type	ISARO PRO S - 12 x Warm White 3000K LED CRI70 500mA - 10V DC 081	Type	NEOS 1 LED 5102 24 XP-G3@500mA WW 727 230V Back Light
Lamp(s)	12	Lamp(s)	24 XP-G3@500mA WW 727 230V
Lamp Flux (lm)	2181	Lamp Flux (lm)	2227
Maintenance Factor	0.8	Maintenance Factor	0.8
No. in Project	17	No. in Project	12

Luminaire C Data		Luminaire D Data	
Supplier	Item	Supplier	Item
Type	NEOS 1 LED 5119 16 XP-G3@350mA WW 730 230V Back Light	Type	NEOS 1 LED 5119 16 XP-G3@350mA WW 730 230V Back Light
Lamp(s)	16 XP-G3@350mA WW 730 230V	Lamp(s)	16 XP-G3@350mA WW 730 230V
Lamp Flux (lm)	2181	Lamp Flux (lm)	2181
Maintenance Factor	0.8	Maintenance Factor	0.8
No. in Project	17	No. in Project	14

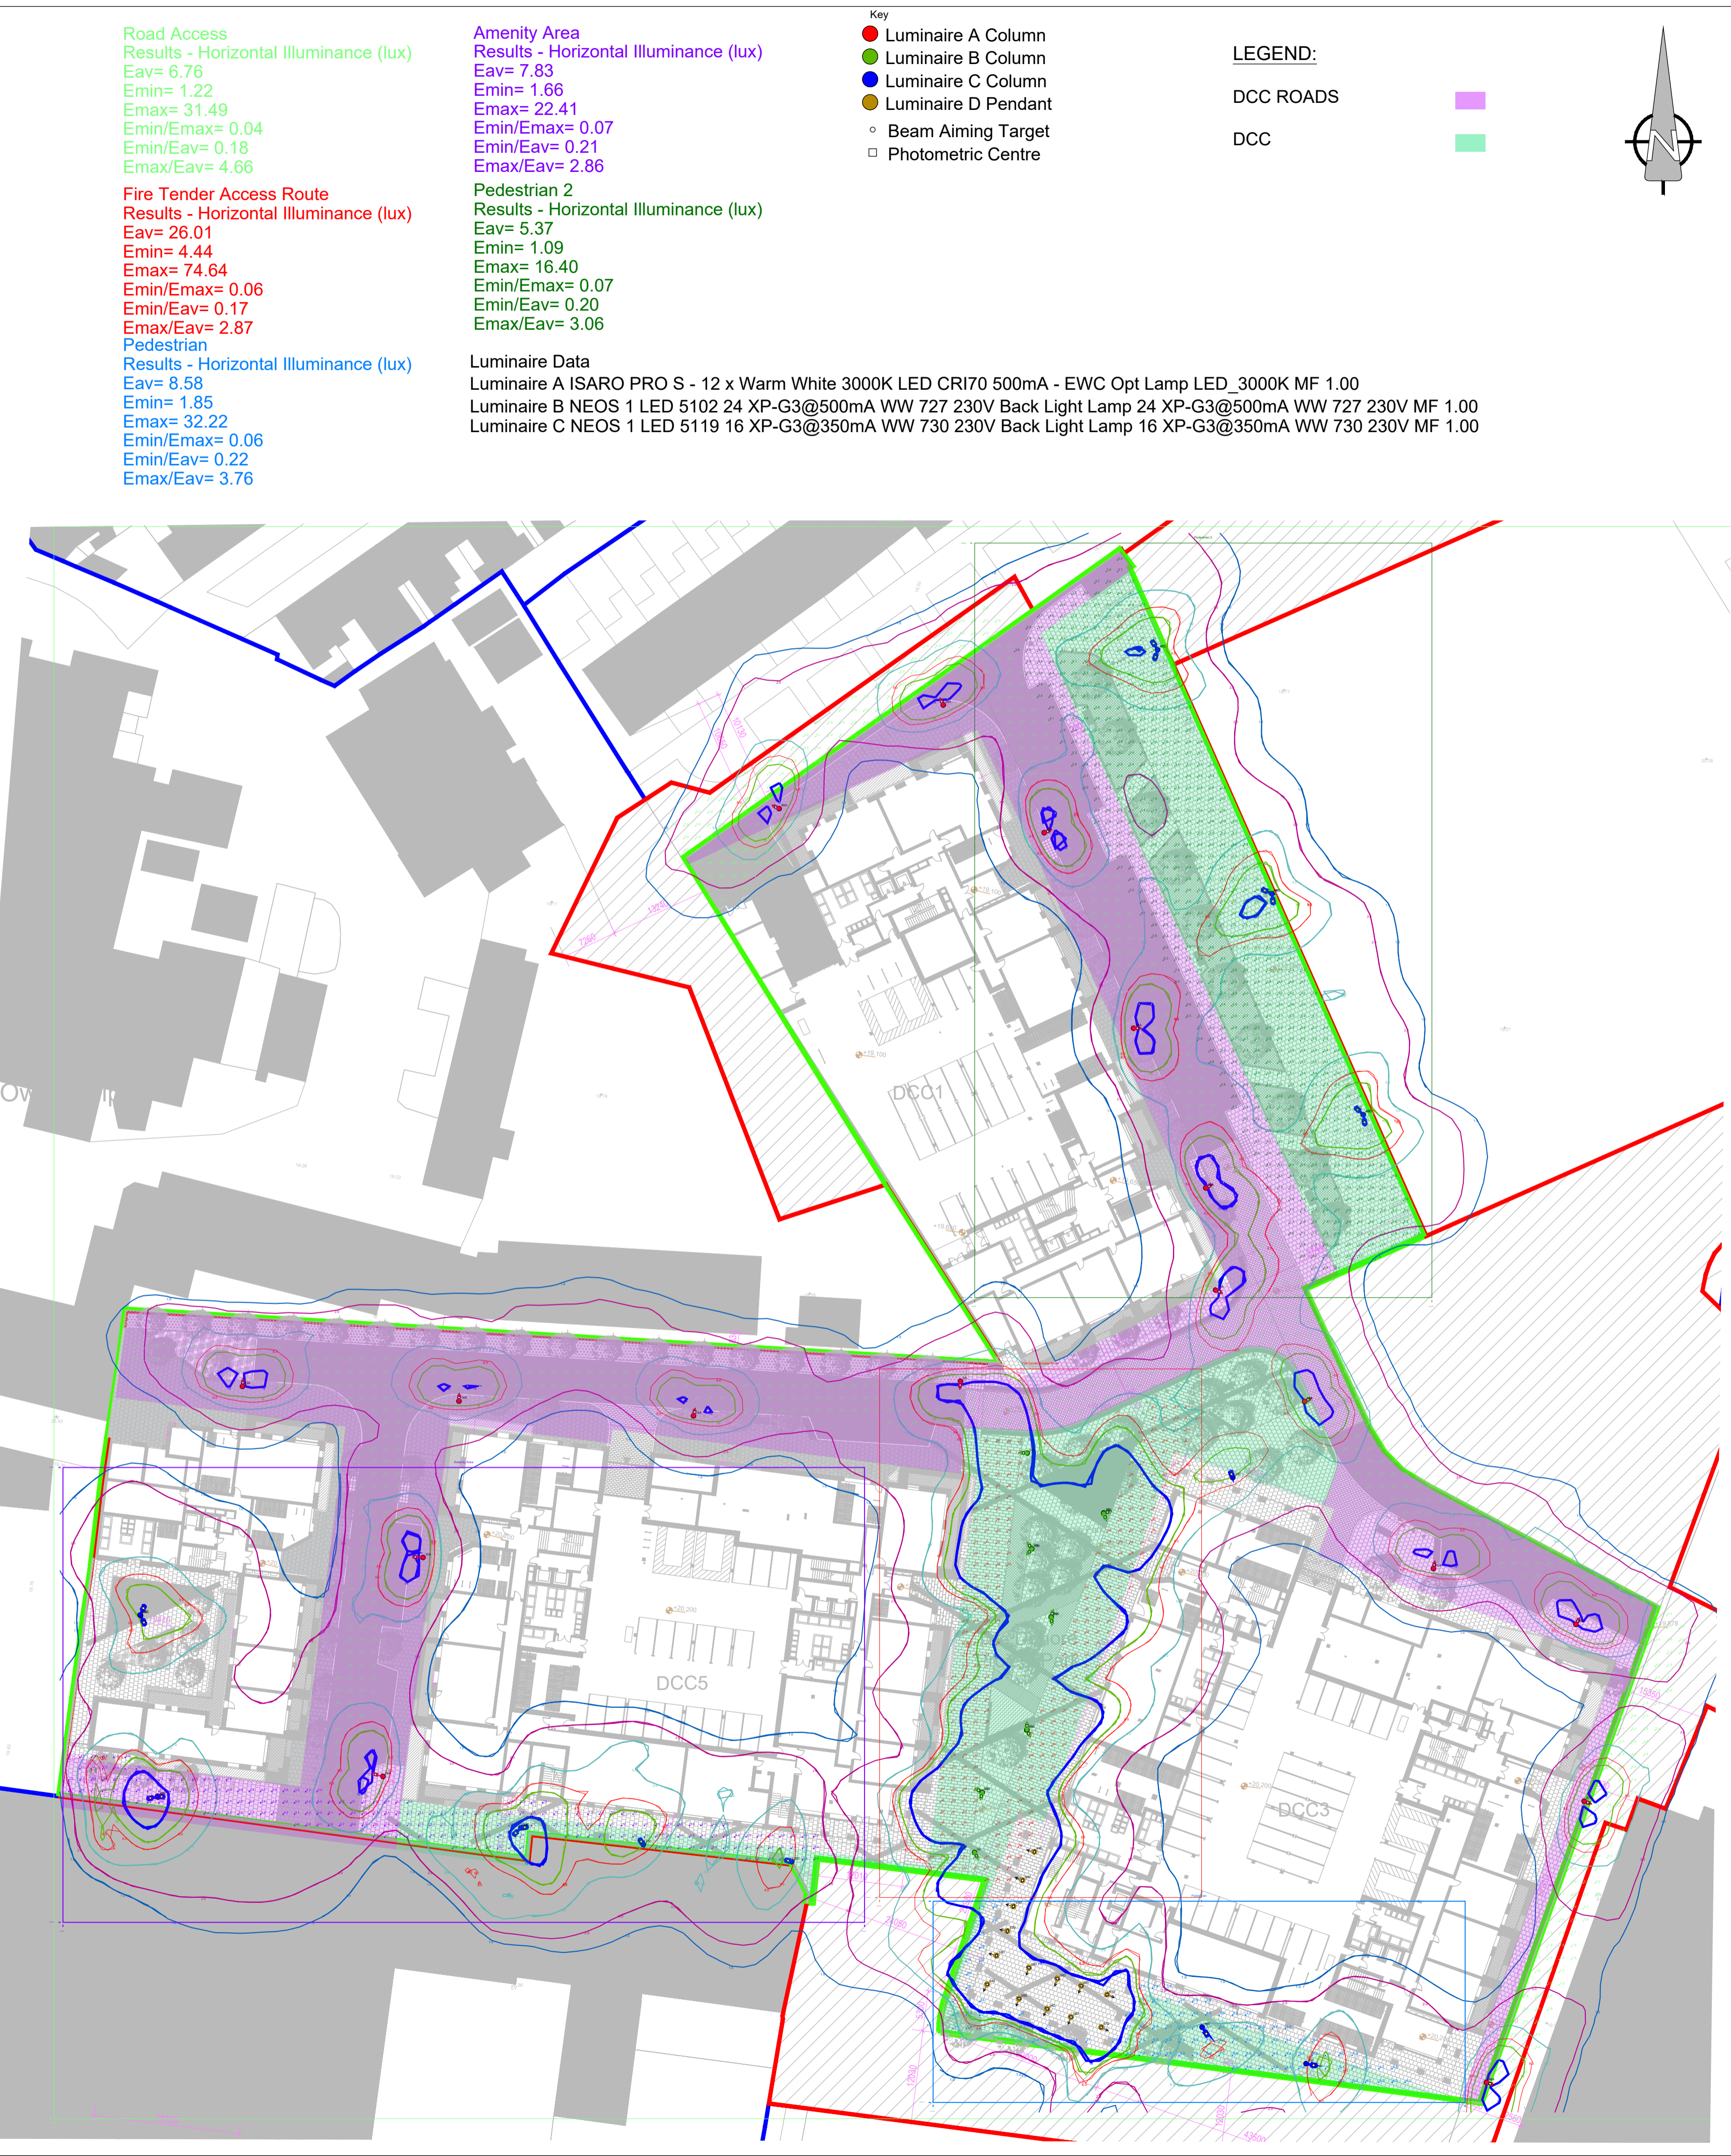

AECOM

Project
**DONORE PROJECT,
 DONORE AVENUE,
 DUBLIN 8**

Client
**THE LAND
 DEVELOPMENT
 AGENCY**

Consultant
 AECOM
 Adelphi Plaza
 George's Street Upper
 Dún Laoghaire, Co. Dublin
 A96 T927
 Ireland
 Tel +353 (0) 1 696 6200
 www.aecom.com

Notes

Issue/Revision	Rev	Date	Description
P1	18.11.2022	Issued for Planning	
Rev	Date	Description	

Key Plan

Purpose Of Issue
 Issued for Planning

Project Number
 60648061

Sheet Title
 PUBLIC REALM
 EXTERNAL LIGHTING LAYOUT

Sheet Number
 STG-AEC-S1b-00-00-DR-EL-020001

Scale: A1 @ 1:500 Rev: P1