

Copyright  
This drawing and any design here on is the copyright of the Consultants and must not be reproduced without their written consent.  
All drawings remain the property of the Consultants.

THIS DRAWING TO BE READ IN CONJUNCTION WITH ALL RELEVANT ARCHITECTS AND ENGINEERS DRAWINGS.

FIGURED DIMENSIONS ONLY TO BE TAKEN FROM THIS DRAWING.  
ALL LEVELS ARE IN METRES AND RELATE TO DATUM AT MALIN HEAD.


THIS DRAWING IS REPRODUCED FROM DIGITAL MAPS:  
O.S. MAPS - Scale 1:2,500  
O.S. MAPS - Scale 1:1,000  
DISCOVERY SERIES - Scale 1:50,000

ALL MAPS ARE REFERENCED TO IRISH NATIONAL GRID (I.T.M.)  
REPRODUCED FROM THE ORDNANCE SURVEY OF IRELAND BY PERMISSION OF THE GOVERNMENT. LICENSE NO. 3-3-34.


THIS DRAWING IS A COPY OF AN ELECTRONIC FILE AND IS COPYRIGHT.  
ALL DIMENSIONS TO BE CHECKED ON SITE.

ALL MATERIALS AND WORKMANSHIP TO BE IN ACCORDANCE WITH ENGINEERS SPECIFICATION.

IT IS THE CONTRACTORS RESPONSIBILITY TO VERIFY ALL DIMENSIONS AND LEVELS PRIOR TO COMMENCEMENT OF CONSTRUCTION.

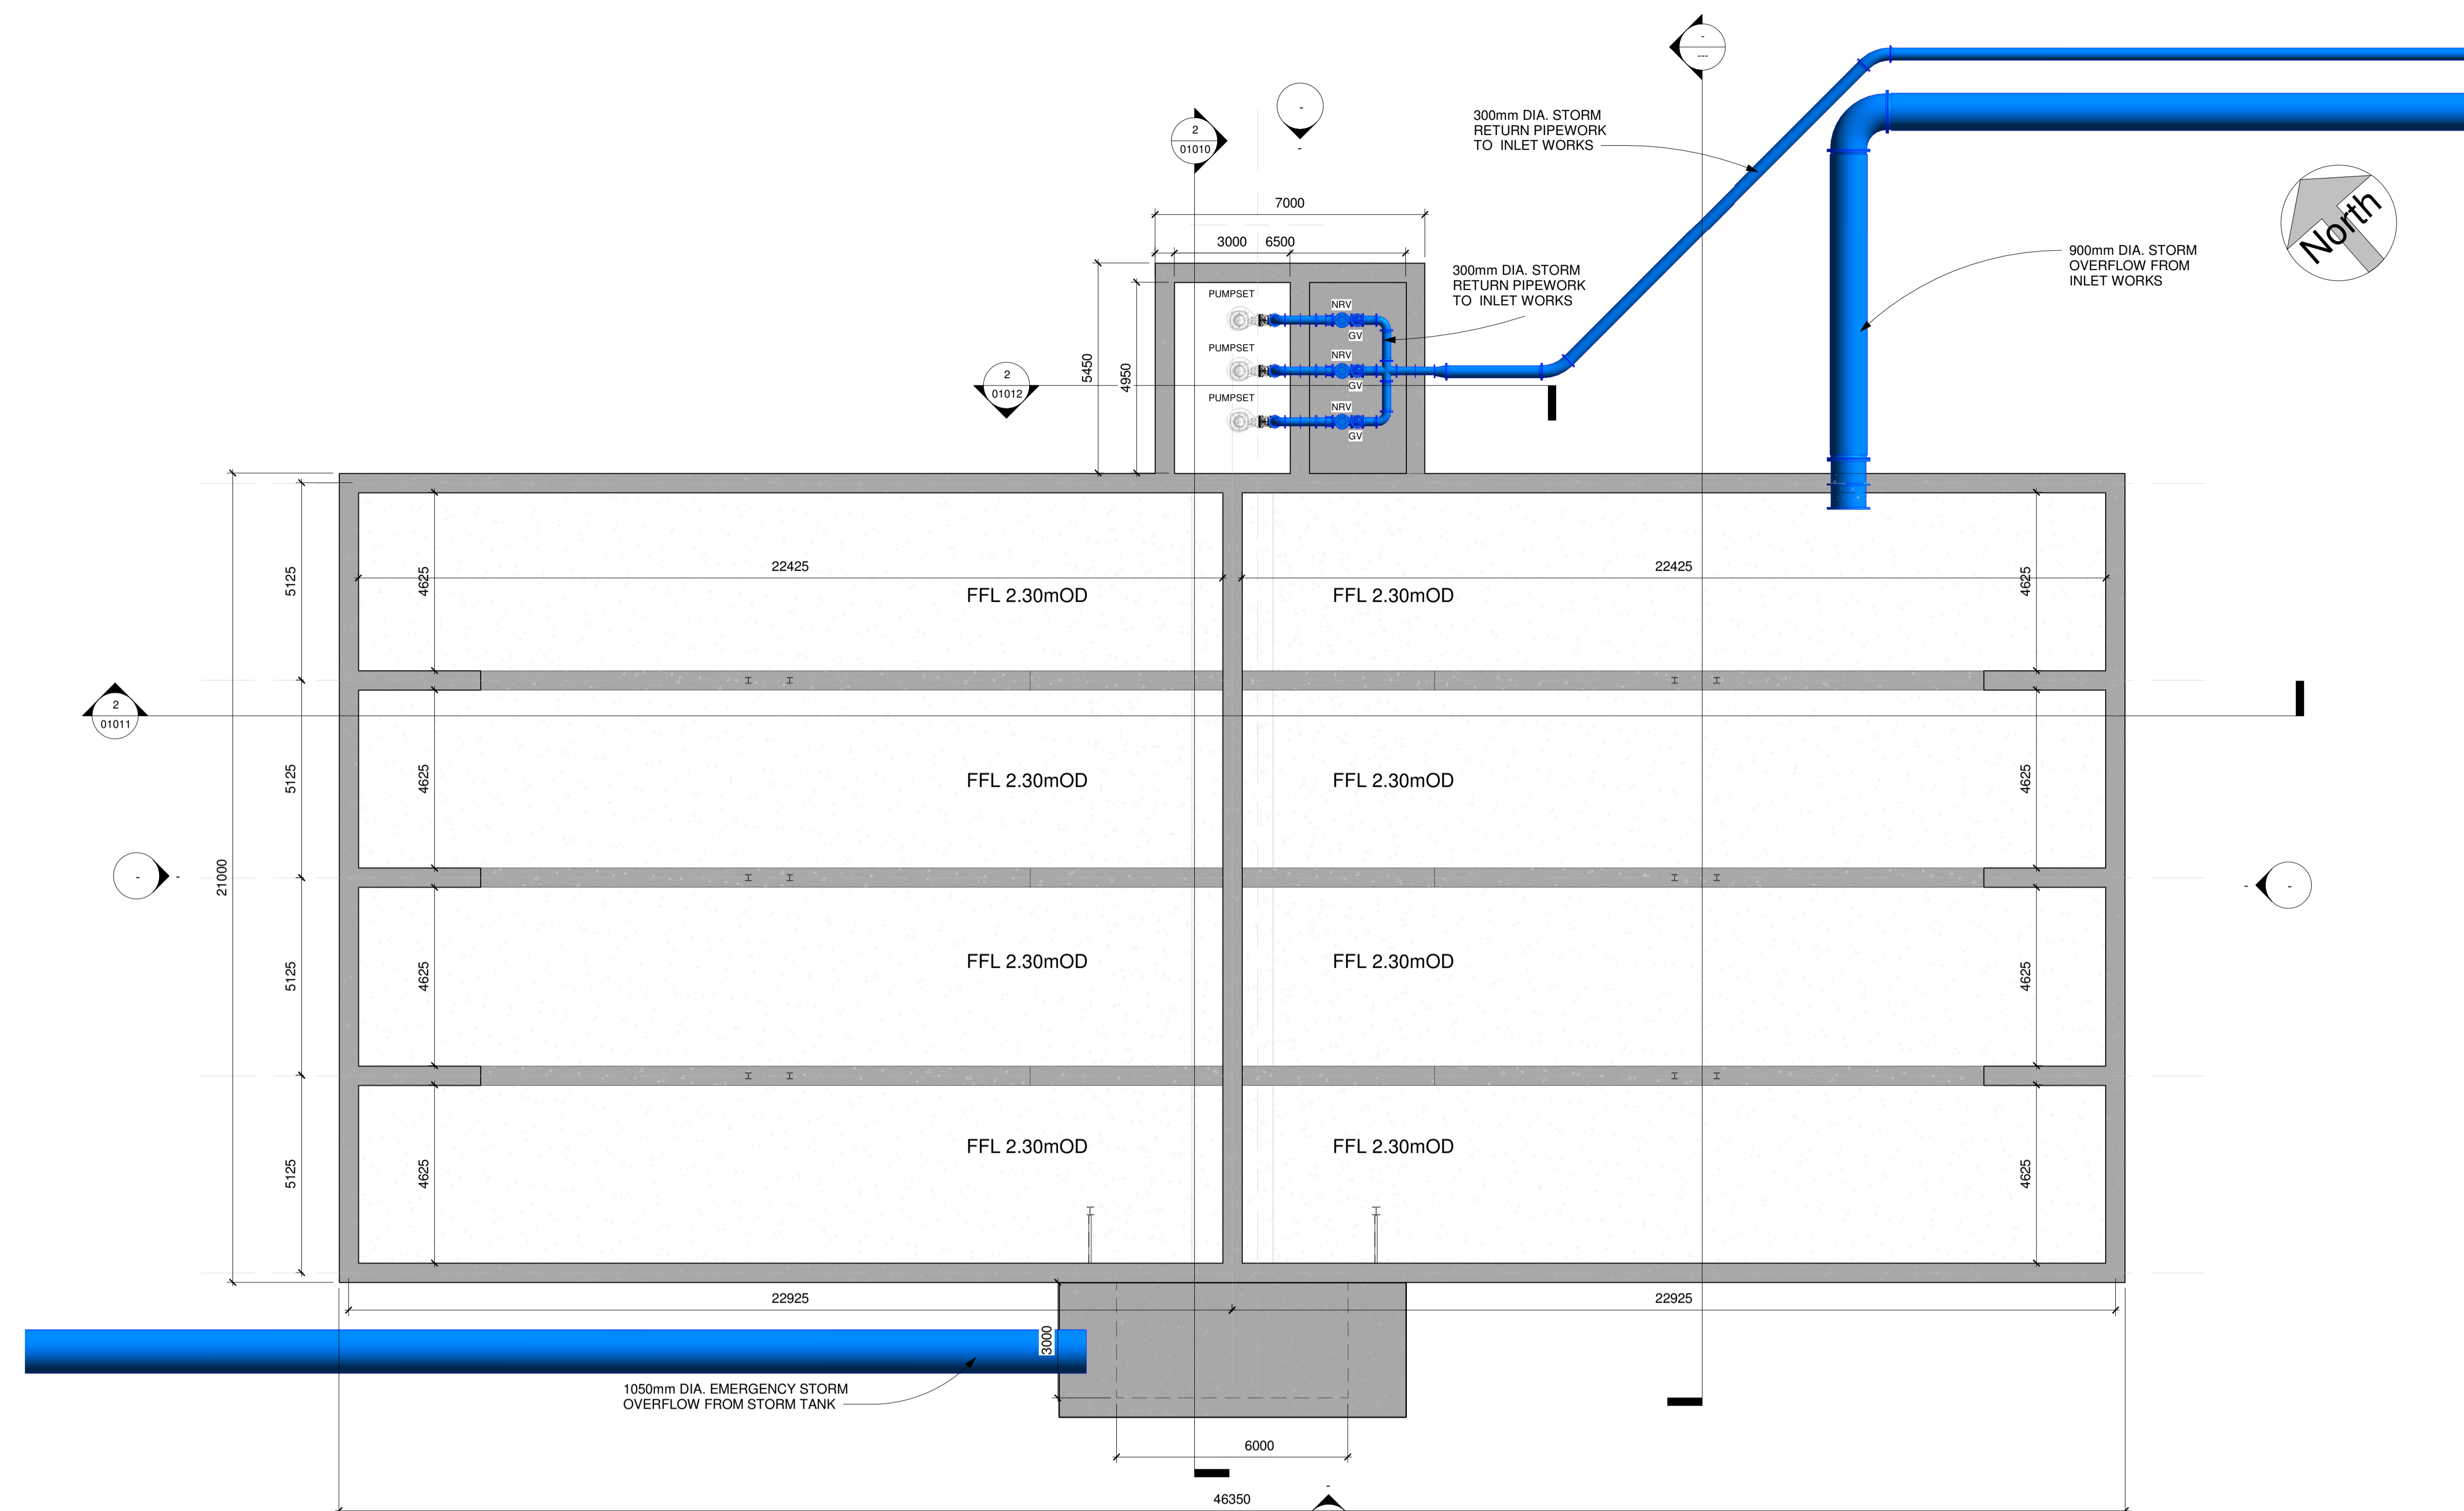

**1 Stormwater Storage Tank Floor Plan**  
1 : 100

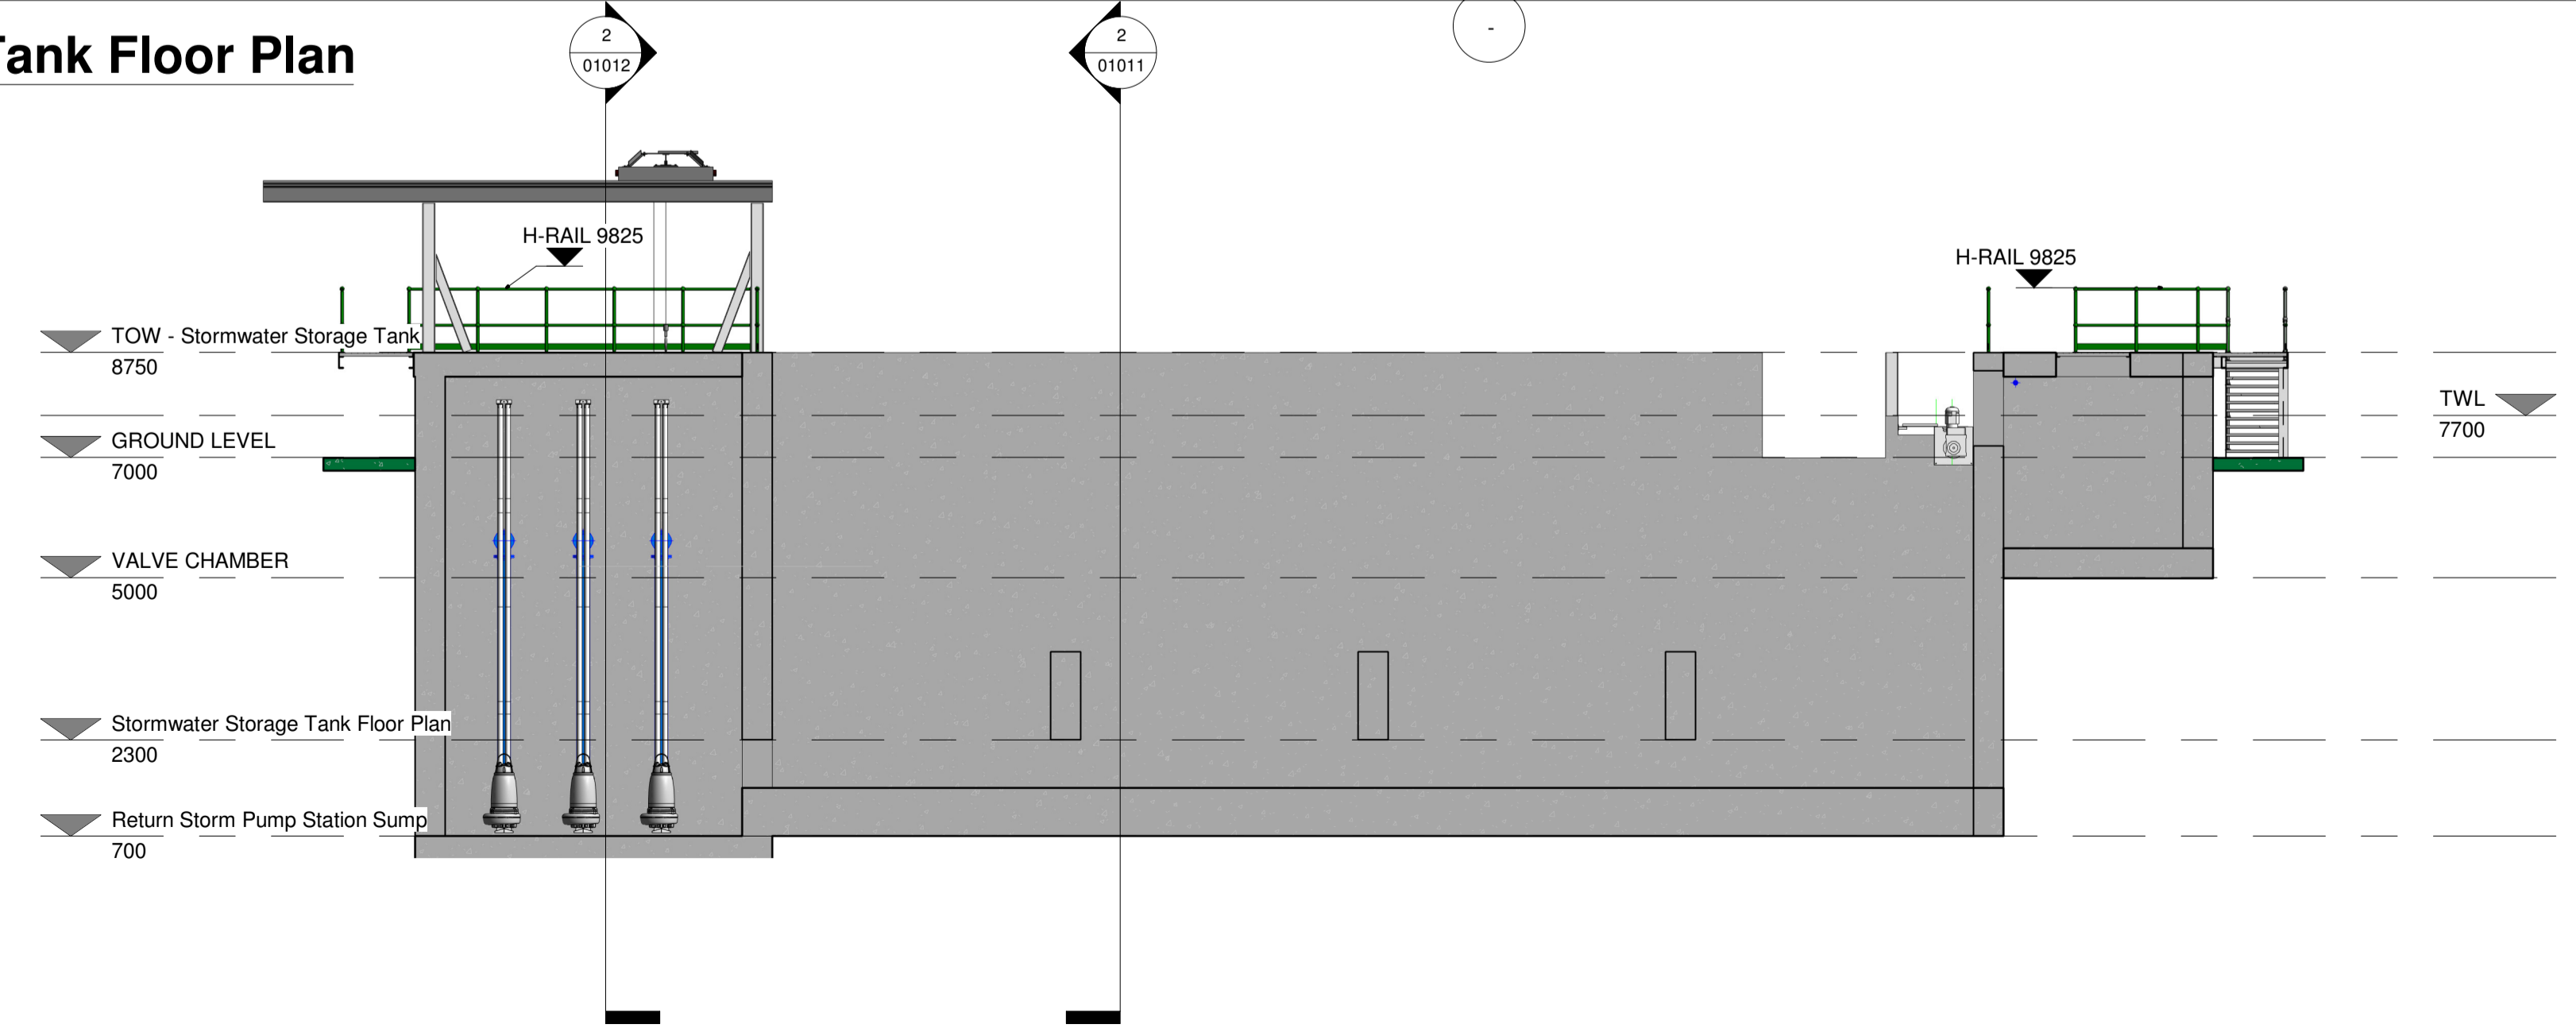

**2 Section 1**  
1 : 100

Rev:	A1	ISSUED FOR PLANNING	PJ	28-05-23
Rev:	Suit:	Revision Description	Checked:	Date:

Client:  
**UISCE EIREANN IRISH WATER**  
Colville House Tel: 1890 275 278  
24-26 Talbot St Int: +353-1-707 2828  
Dublin 1 email: info@water.ie  
Web: www.water.ie

Project:  
**CASTLETROY WASTEWATER TREATMENT PLANT**

Clients Representative:  
**J. B. Barry and Partners Limited Consulting Engineers**  
Classon House Tel: +353 1 485 1400  
Park Dundrum Business email: info@jbbarry.ie  
Dublin 14 web: www.jbbarry.ie

Drawn By:	LA	Date:	06/12/22
Checked By:	PH	Date:	06/12/22
Approved by:	PJ	Date:	06/12/22
Internal Project No.	20701-JBB-00-XX-DR-Z	Stage	PLANNING

Drawing Title:  
**PROPOSED STORMWATER STORAGE TANK AND RETURN PUMP STATION PLAN AND SECTION**

Scales: 1 : 100

Drawing No:	Sheet No:	Revision:	Suitability:
20701-JBB-00-XX-DR-Z	01010	C01	