

Copyright
 This drawing and any design here on is the copyright of the Consultants and must not be reproduced without their written consent.
 All drawings remain the property of the Consultants.

THIS DRAWING TO BE READ IN CONJUNCTION WITH ALL RELEVANT ARCHITECTS AND ENGINEERS DRAWINGS.

FIGURED DIMENSIONS ONLY TO BE TAKEN FROM THIS DRAWING.

ALL LEVELS ARE IN METRES AND RELATE TO DATUM AT MALIN HEAD.

THIS DRAWING IS REPRODUCED FROM DIGITAL MAPS:
 O.S. MAPS - Scale 1:2,500
 O.S. MAPS - Scale 1:1,000
 DISCOVERY SERIES - Scale 1:50,000

ALL MAPS ARE REFERENCED TO IRISH NATIONAL GRID (I.T.M.)


REPRODUCED FROM THE ORDNANCE SURVEY OF IRELAND BY PERMISSION OF THE GOVERNMENT. LICENSE NO. 3-3-34.

THIS DRAWING IS A COPY OF AN ELECTRONIC FILE AND IS COPYRIGHT.


ALL DIMENSIONS TO BE CHECKED ON SITE.

ALL MATERIALS AND WORKMANSHIP TO BE IN ACCORDANCE WITH ENGINEERS SPECIFICATION.


IT IS THE CONTRACTORS RESPONSIBILITY TO VERIFY ALL DIMENSIONS AND LEVELS PRIOR TO COMMENCEMENT OF CONSTRUCTION.

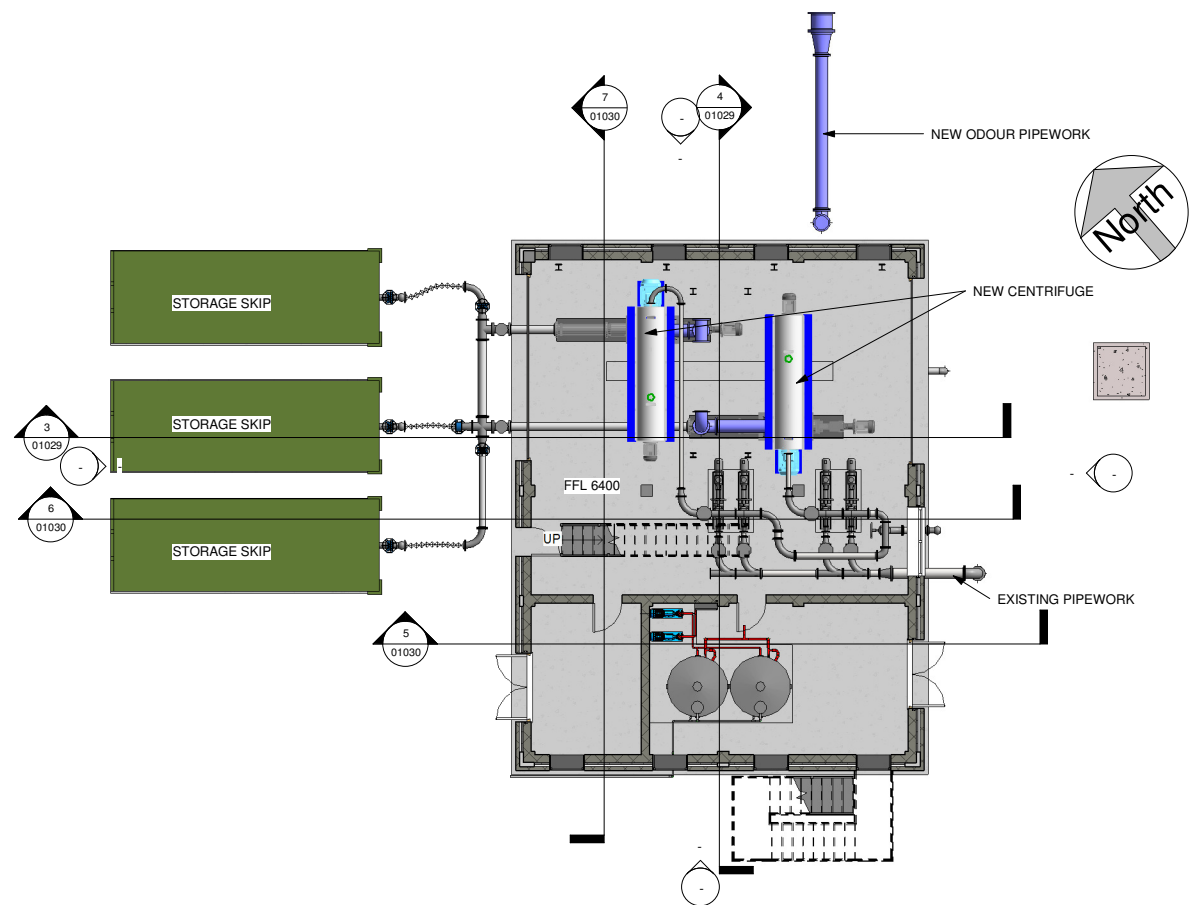


1 Ground Floor Plan
 1 : 100

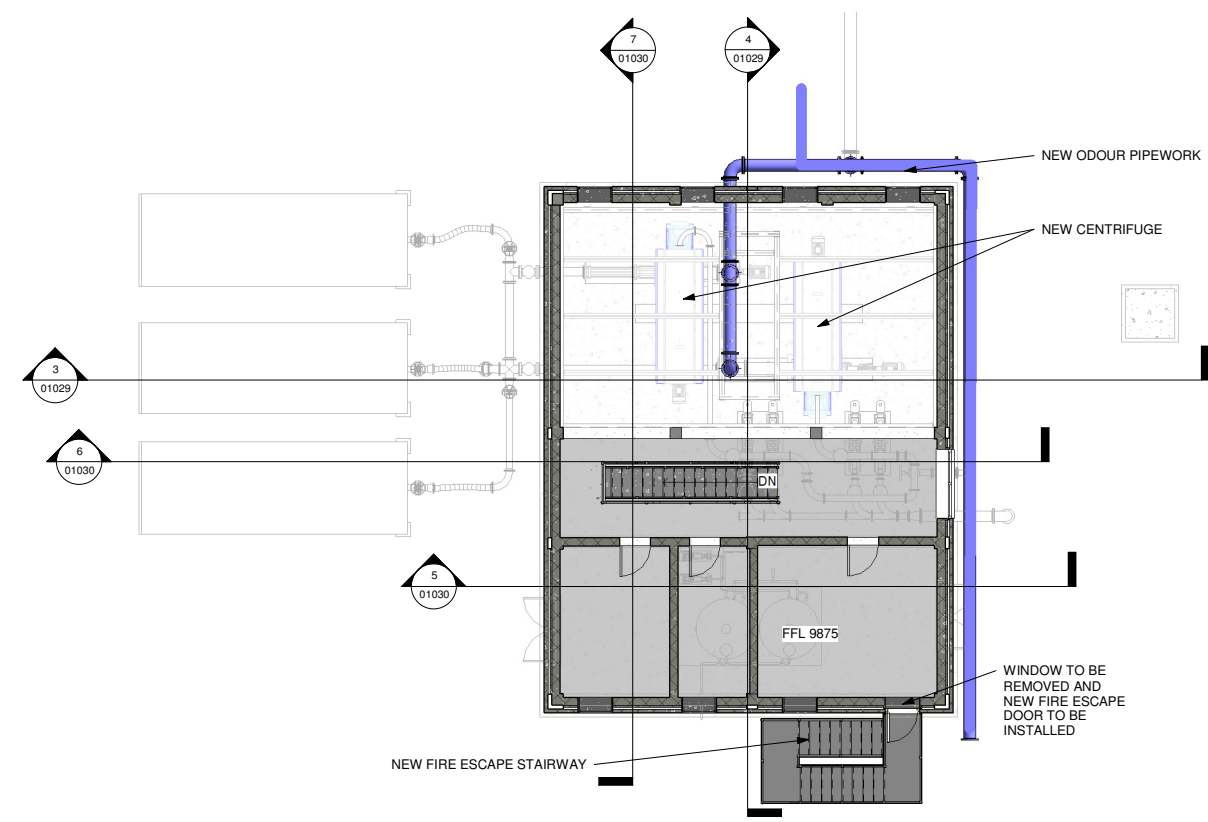

2 Second Floor Plan
 1 : 100

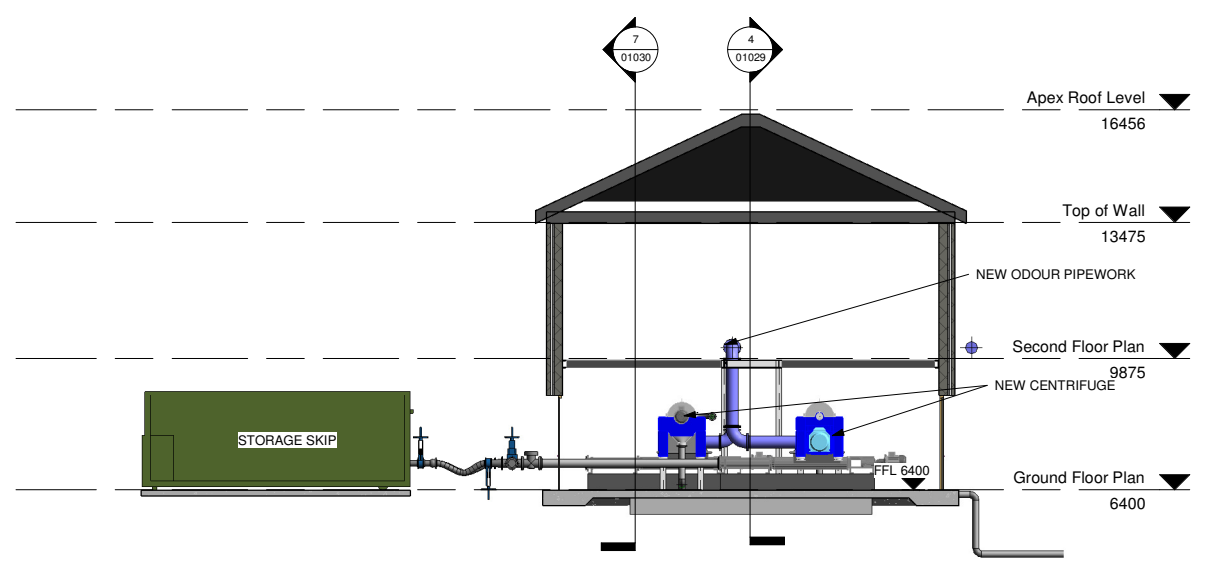

3 Section 1
 1 : 100

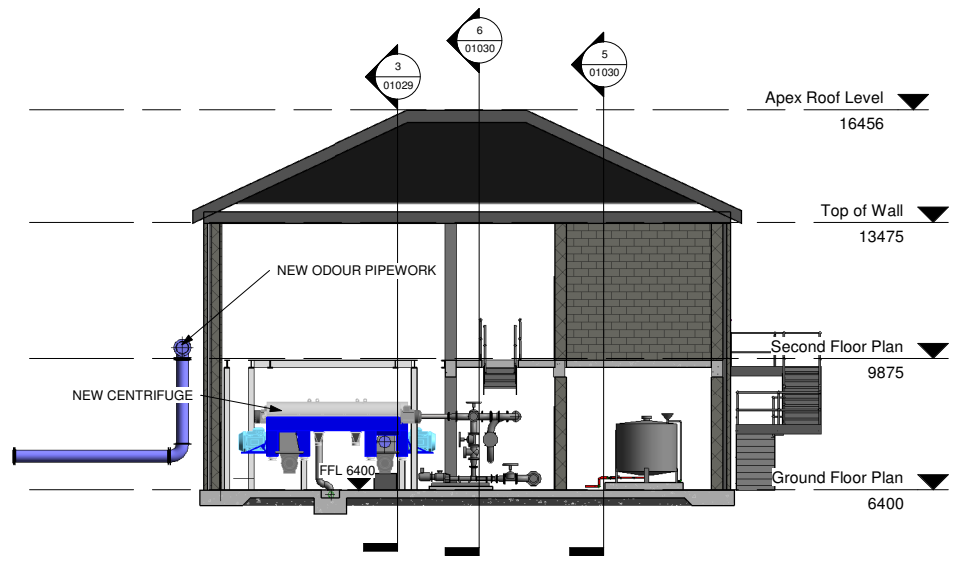

4 Section 2
 1 : 100

DO NOT SCALE REDUCED COPY -A3 PRINT

C01	A1	ISSUED FOR E.I.A.R.	PJ	28-02-23
Rev:	Suit:	Revision Description	Checked:	Date:

Client:
UISCE Colvill House Tel: 1890 278 278
 EIREANN - IRISH 24-26 Talbot St Int: +353-1-707 2828
 WATER Dublin 1 email: info@water.ie
 Web: www.water.ie

Project:
CASTLETROY WASTEWATER TREATMENT PLANT

Clients Representative:
J. B. Barry and Partners Limited
 Consulting Engineers
 Classon House Tel: +353 1 485 1400
 Dundrum Business email: info@jbbarry.ie
 Park Dundrum Road web: www.jbbarry.ie
 Dublin 14

Drawn By:	LHA	Date:	06/12/22
Checked By:	PH	Date:	06/12/22
Approved by:	PJ	Date:	06/12/22
Internal Project No.	20701-JBB-00-XX-DR-Z	Stage	E.I.A.R.

Drawing Title:
MODIFICATIONS TO EXISTING DEWATERING HOUSE PLAN LAYOUTS AND SECTIONS

Scales:	1 : 100
Drawing No:	20701-JBB-00-XX-DR-Z
Sheet No:	01029
Revision:	C01
Suitability:	

0:20 Project: 20701 - Castletroy WWTp - Glabe 2-4000/WP/Dwg/E.I.A.R. Drawings March 2023/20701-JBB-00-XX-DR-Z-01029-01030-Existing Sludge Dewatering Plant House.rvt