


Map Series:  
Prime2 Vector Data - 1:2500  
Map Sheets:  
3325-B, 3326-A, 3325-D & 3326-C  
Ordnance Survey Ireland Licence No.  
CYAL50261649  
Copyright:  
© Suirbhéireacht Ordnáis Éireann, 2023  
© Ordnance Survey Ireland, 2023

**LEGEND: -**  
Proposed 110kV Grid Connection UGC (0.266km)   
Planning Boundary shown thus   
\*Approved gas fired Power Plant application reference SD21A/0167 - currently under construction\*   
Proposed Compound Levels shown thus FCL 74.6m  
Proposed Finished Floor Levels shown thus FFL 74.8m

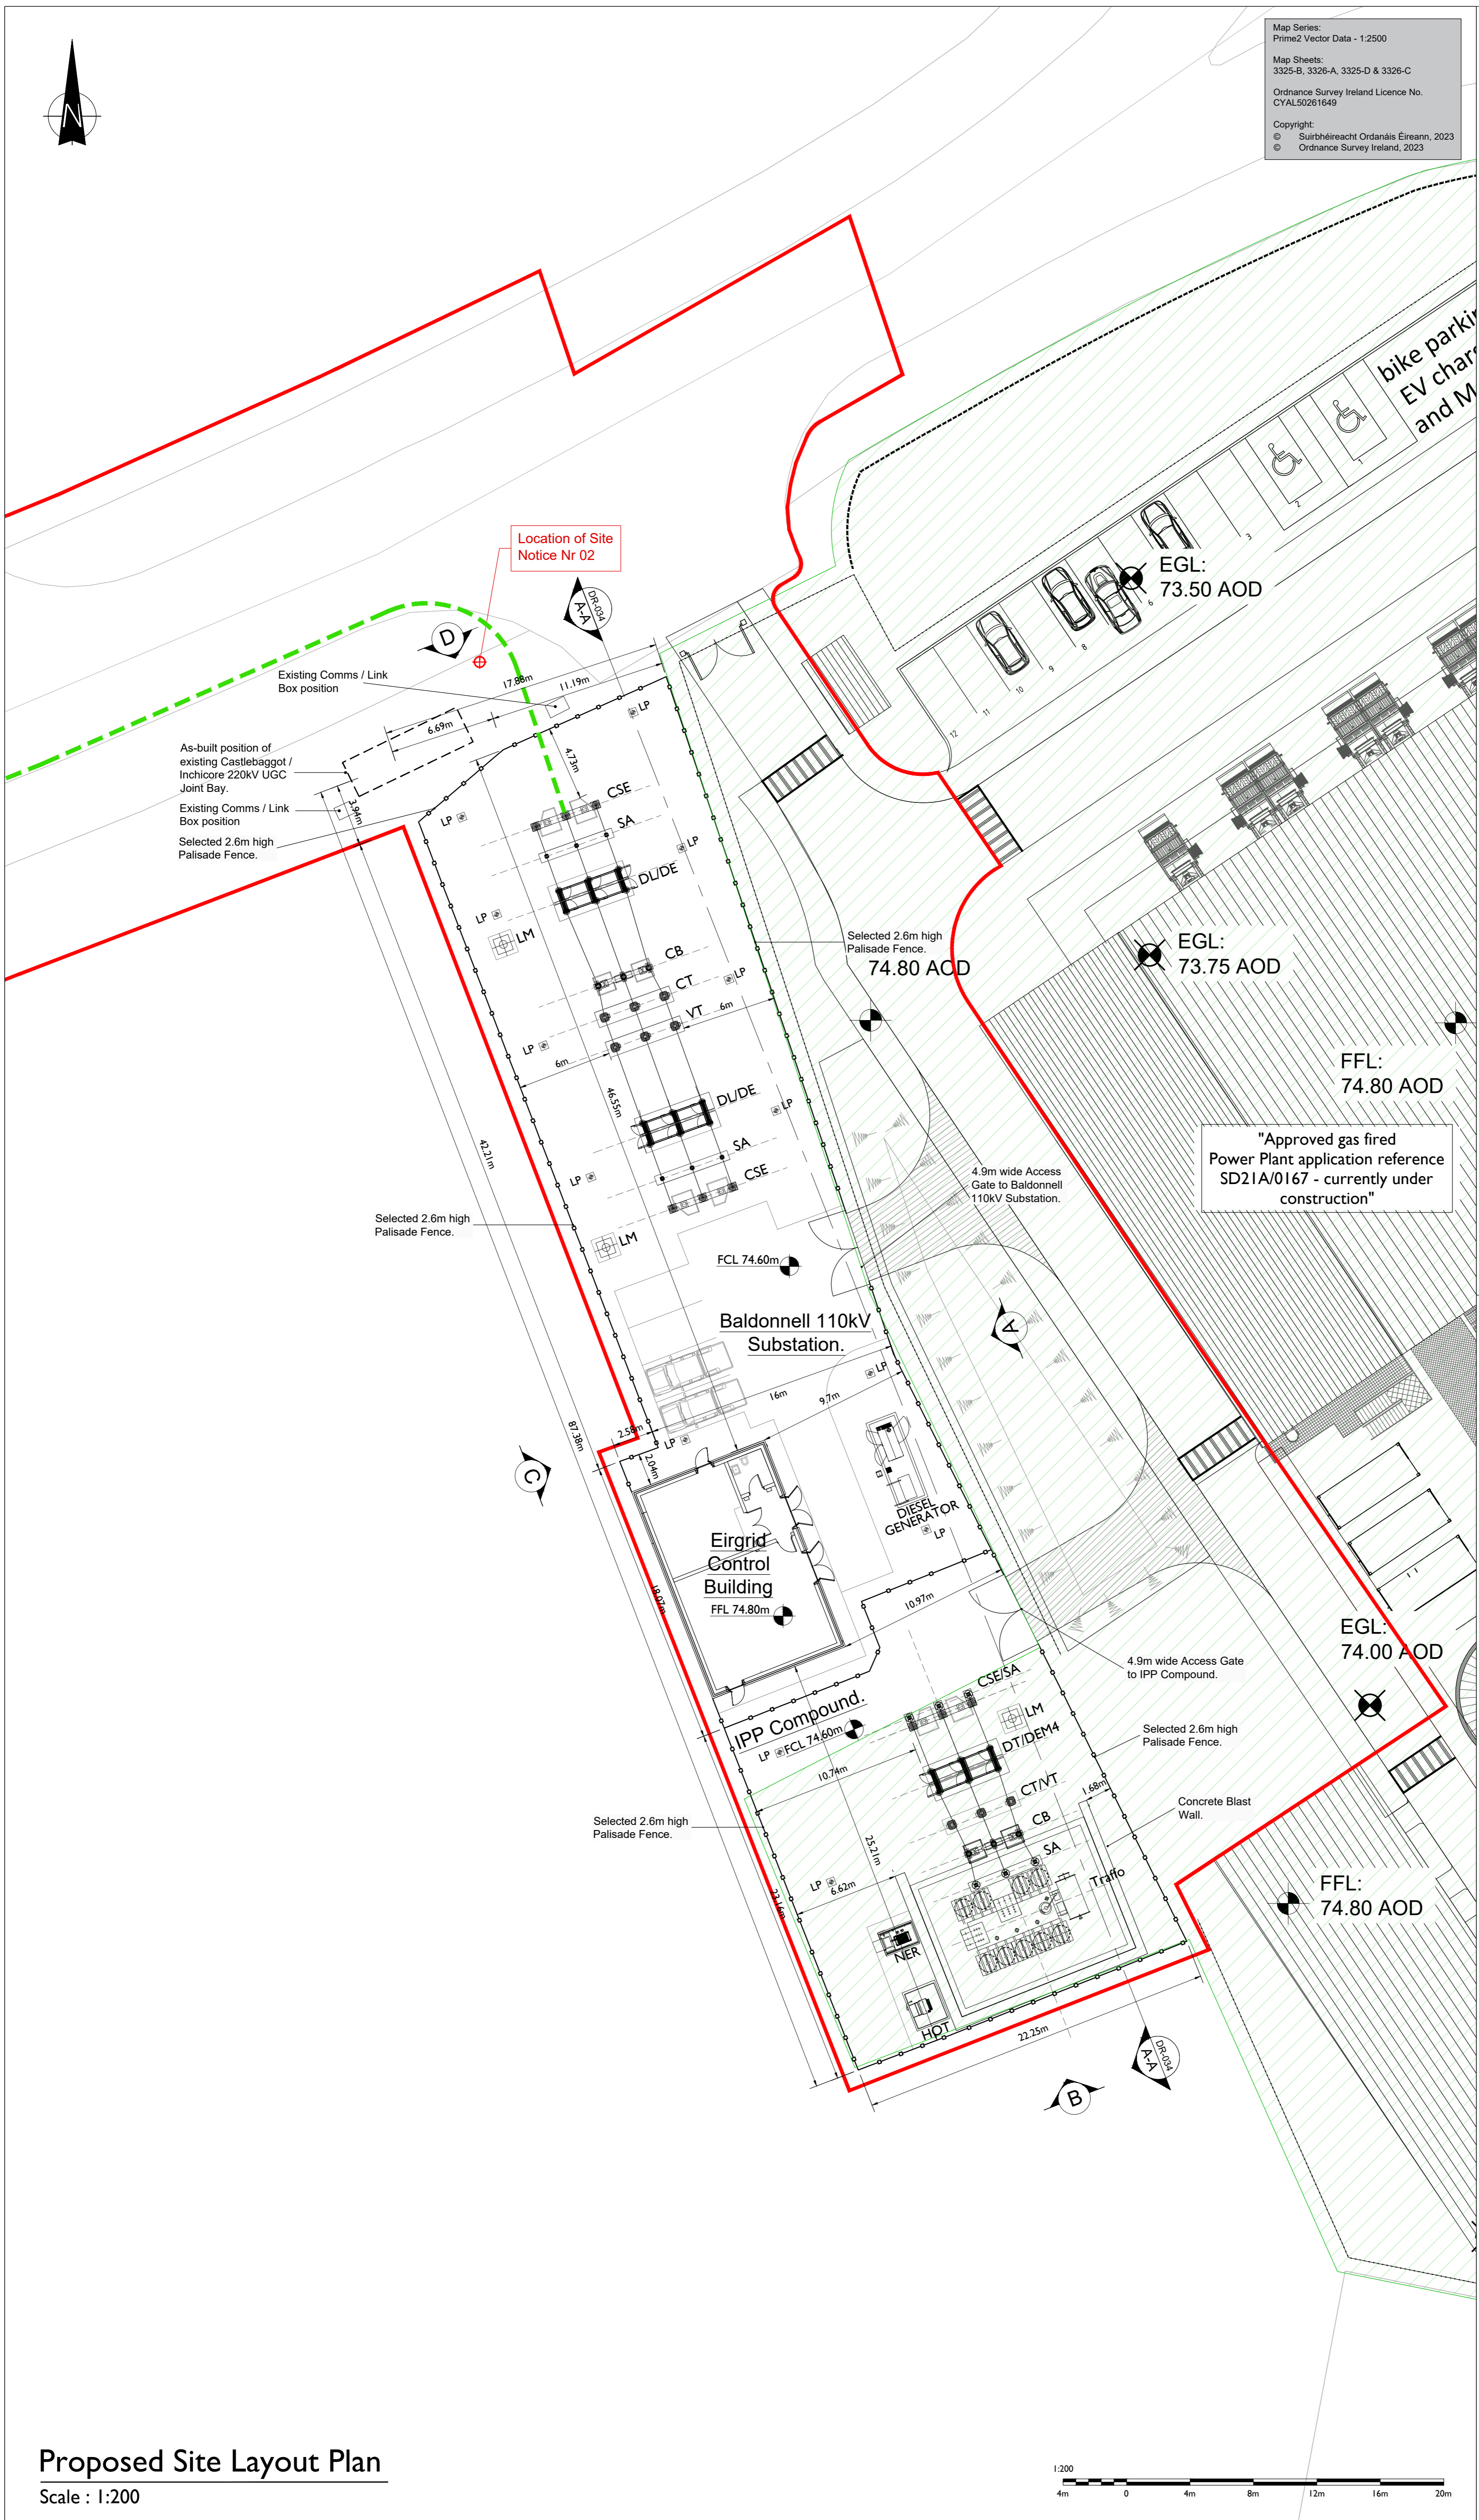

Location of Site Notice Nr 02

As-built position of existing Castlebaggot / Inchicore 220kV UGC Joint Bay.  
Existing Comms / Link Box position  
Selected 2.6m high Palisade Fence.

Selected 2.6m high Palisade Fence.

"Approved gas fired Power Plant application reference SD21A/0167 - currently under construction"

**NOTES: -**  
• This drawing is to be read in conjunction with relevant drawings, specifications and reports.  
• Dimensions are in Meters, unless noted otherwise.  
• Drawings are not to be scaled. Use figured dimensions only.  
• For Site Drainage Layout and Details please refer to Drainage Consultants drawing nos I1069-2201\_P01, I1069-2203\_P01, I1069-2210\_P01, I1069-2230\_P01, I1069-2240\_P01, I1069-2241\_P01, I1069-2242\_P01 & I1069-2243\_P01.

**tli GROUP**  
Head Office: Beenreigh, Abbeydorney, Tralee, Co. Kerry, Ireland. Tel: 00353 66 7135710  
Regional Office: Basepoint Business Centre, Stroudley Road, Basingstoke, Hampshire, RG24 8UP, UK. Tel: 00 44 1256406664

**PROJECT**  
110kV Baldonnell Substation

**CLIENT**  
Greener Ideas

**CONSULTANTS**

**ISSUE/REVISION**

NO	DATE	DESCRIPTION
P5	31.05.23	Issued for Planning
P4	23.05.23	Issued for Planning
P3	19.05.23	Issued for Planning
P2	15.03.23	Issued for Planning
P1	24.02.23	Issued for Planning

**PROJECT NUMBER**  
05-868

**SHEET TITLE**  
Site Layout Plan - Proposed Baldonnell 110kV Substation

**SHEET NUMBER**  
05868-DR-031

**Proposed Site Layout Plan**  
Scale : 1:200

