




KEYPLAN
1:500

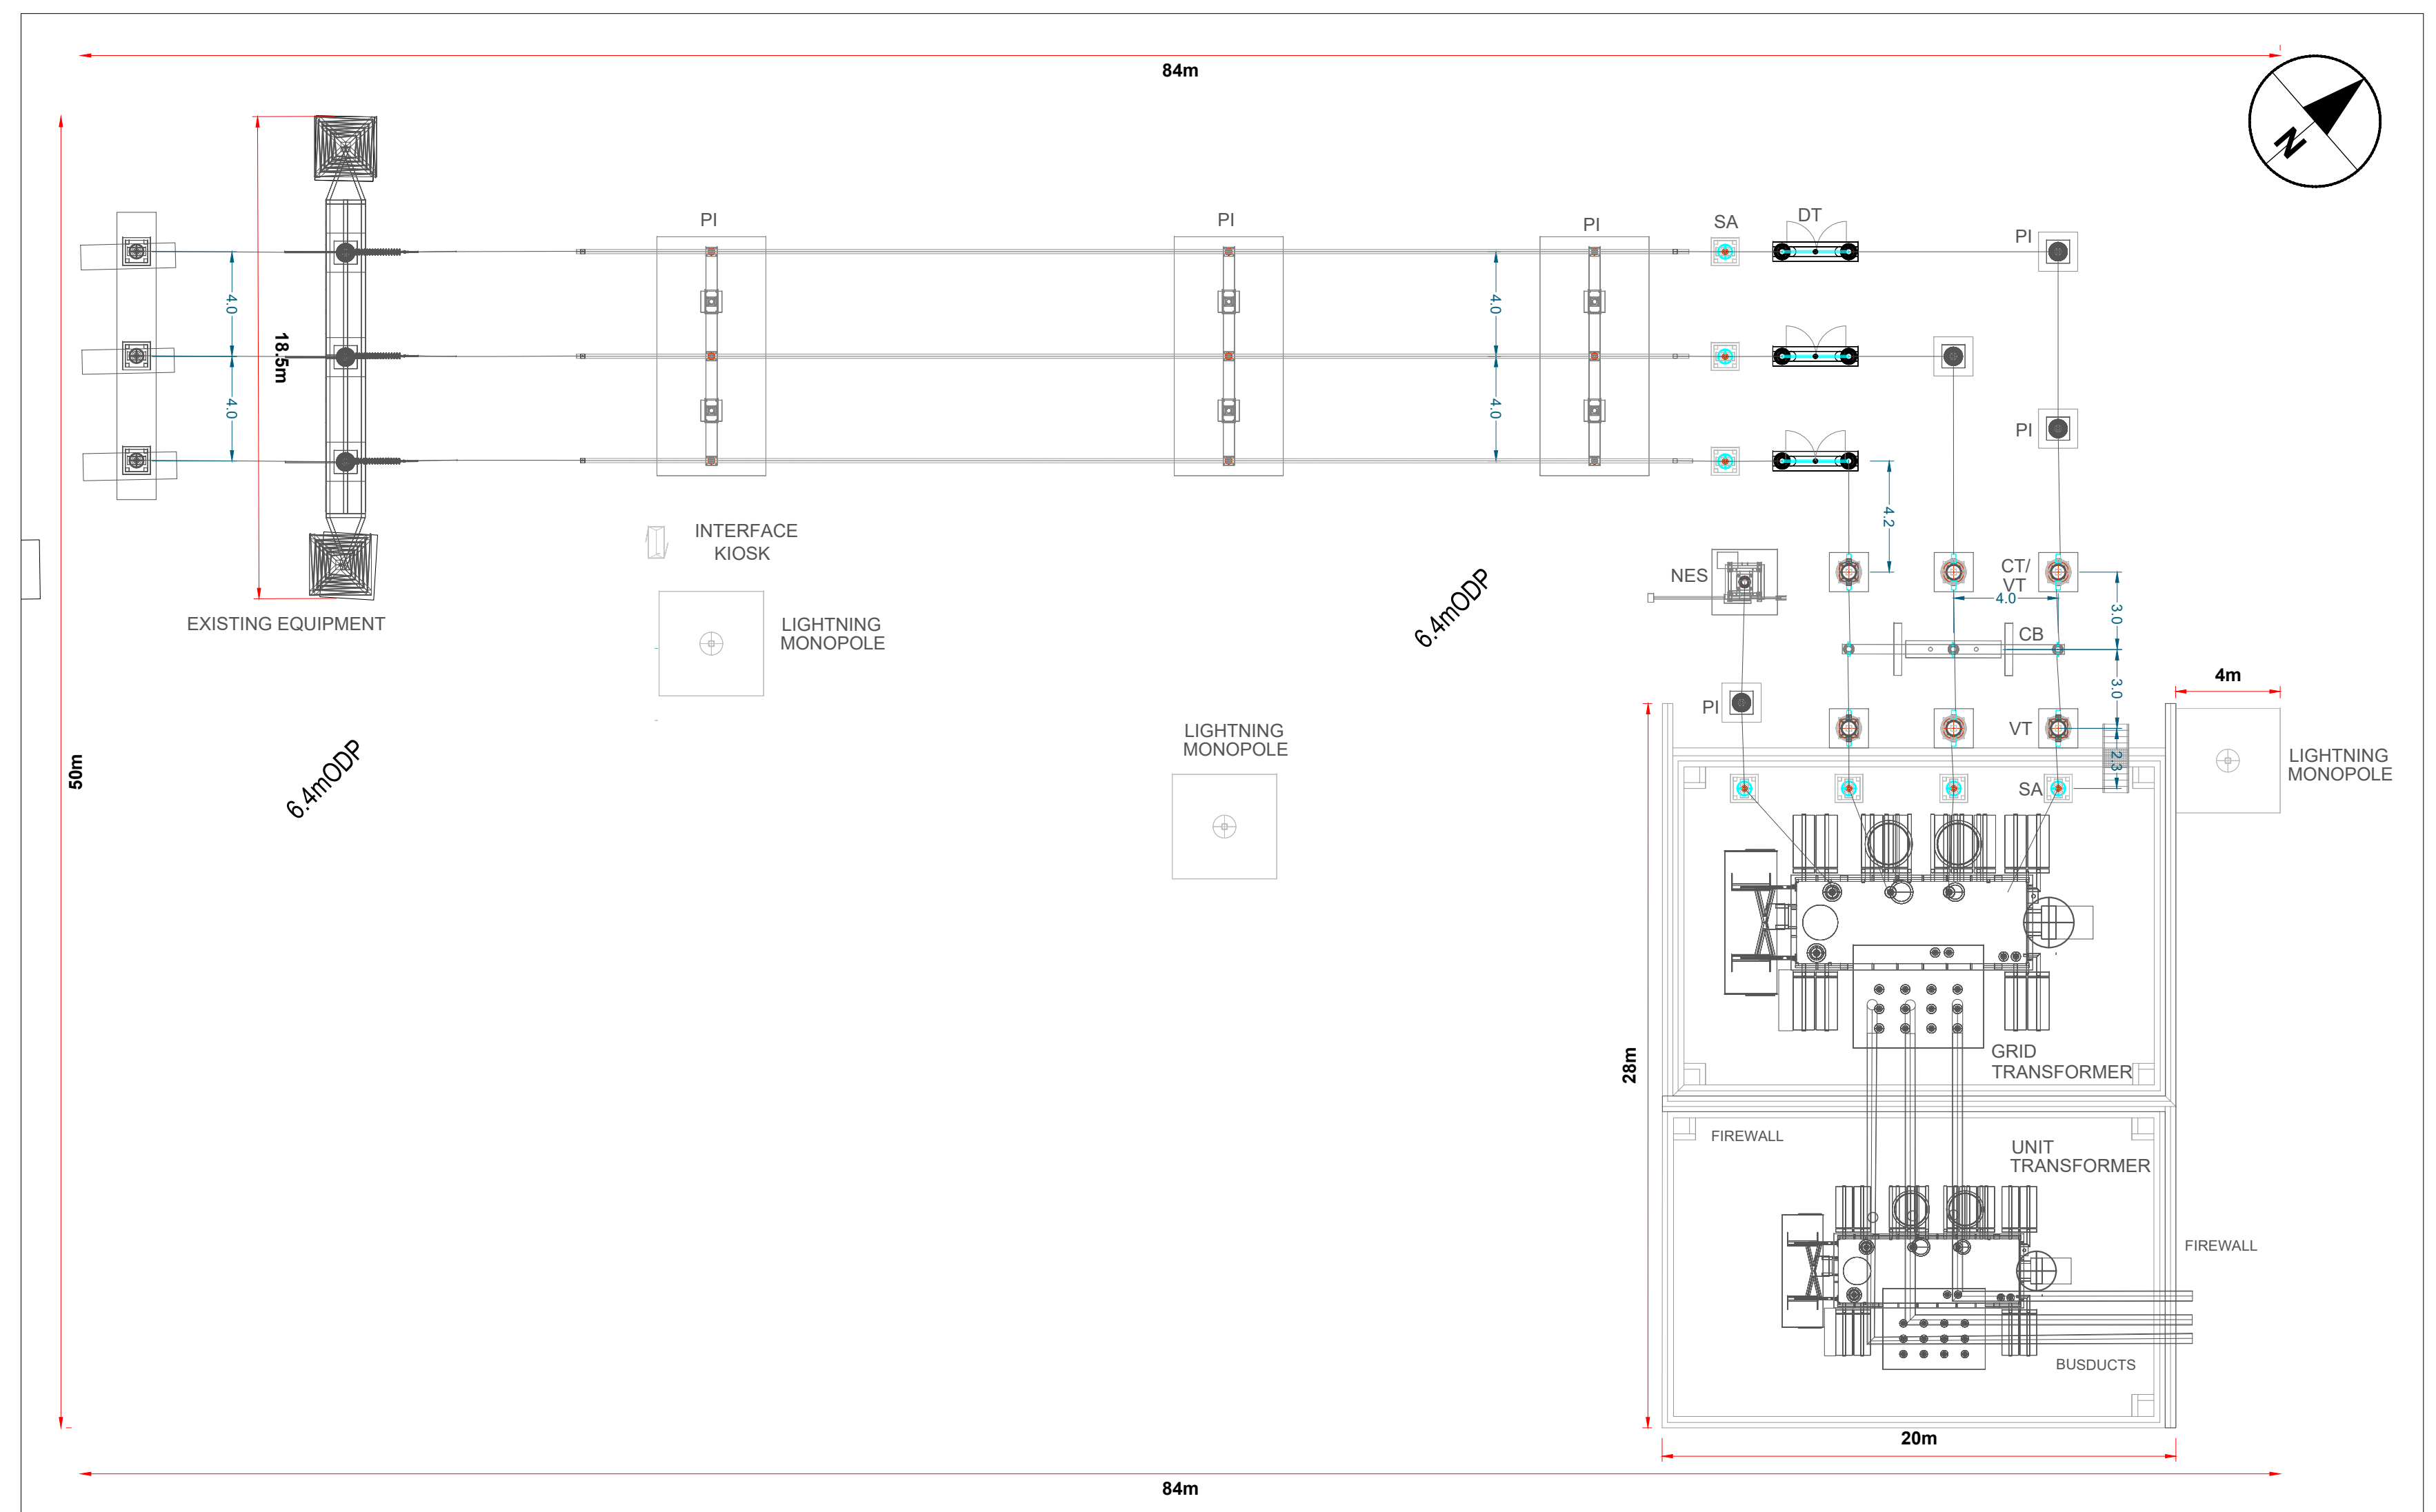


HV Connection & Transformer Plan View
Scale 1:200

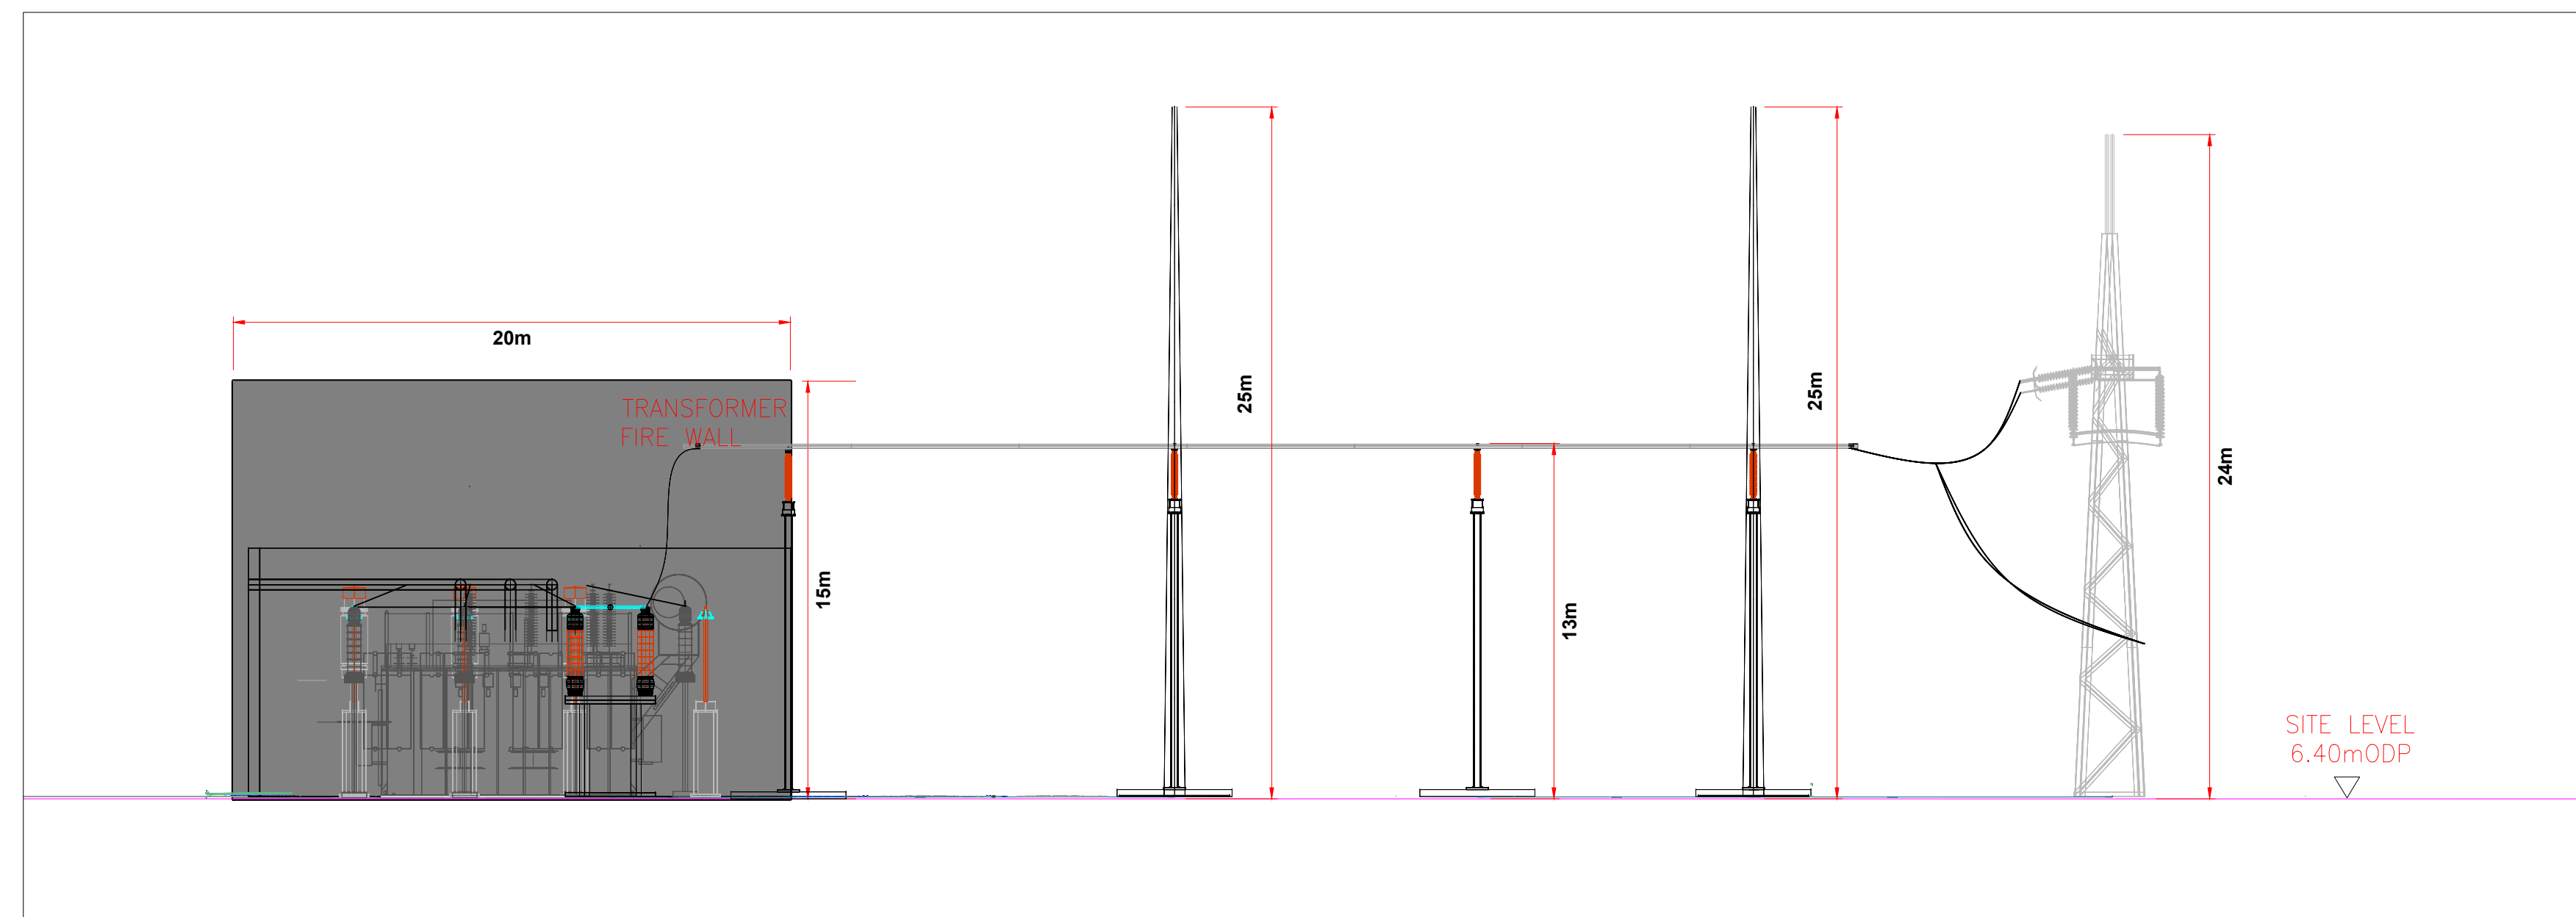


A-A NORTH WEST ELEVATION
1:200

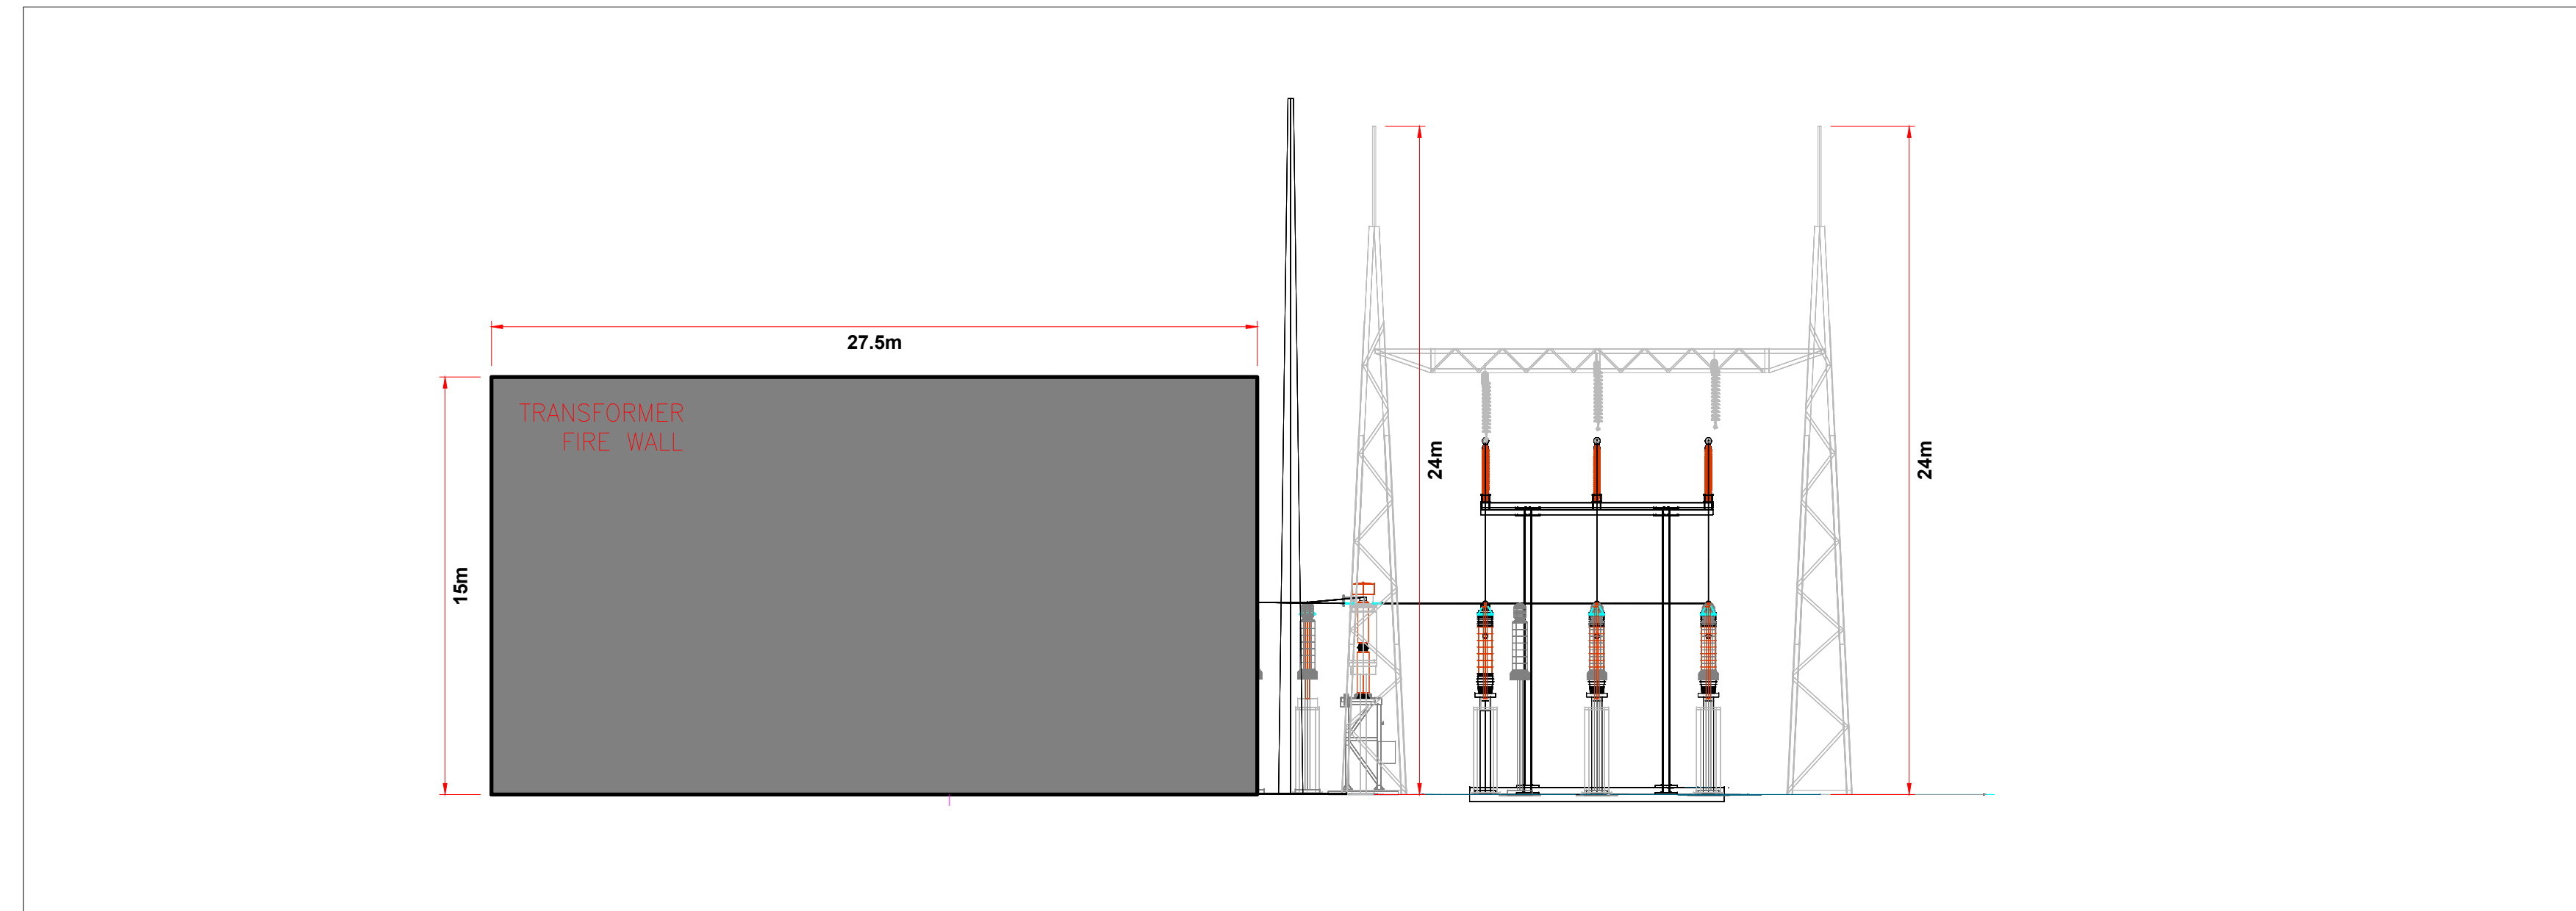

B-B NORTH EAST ELEVATION
1:200

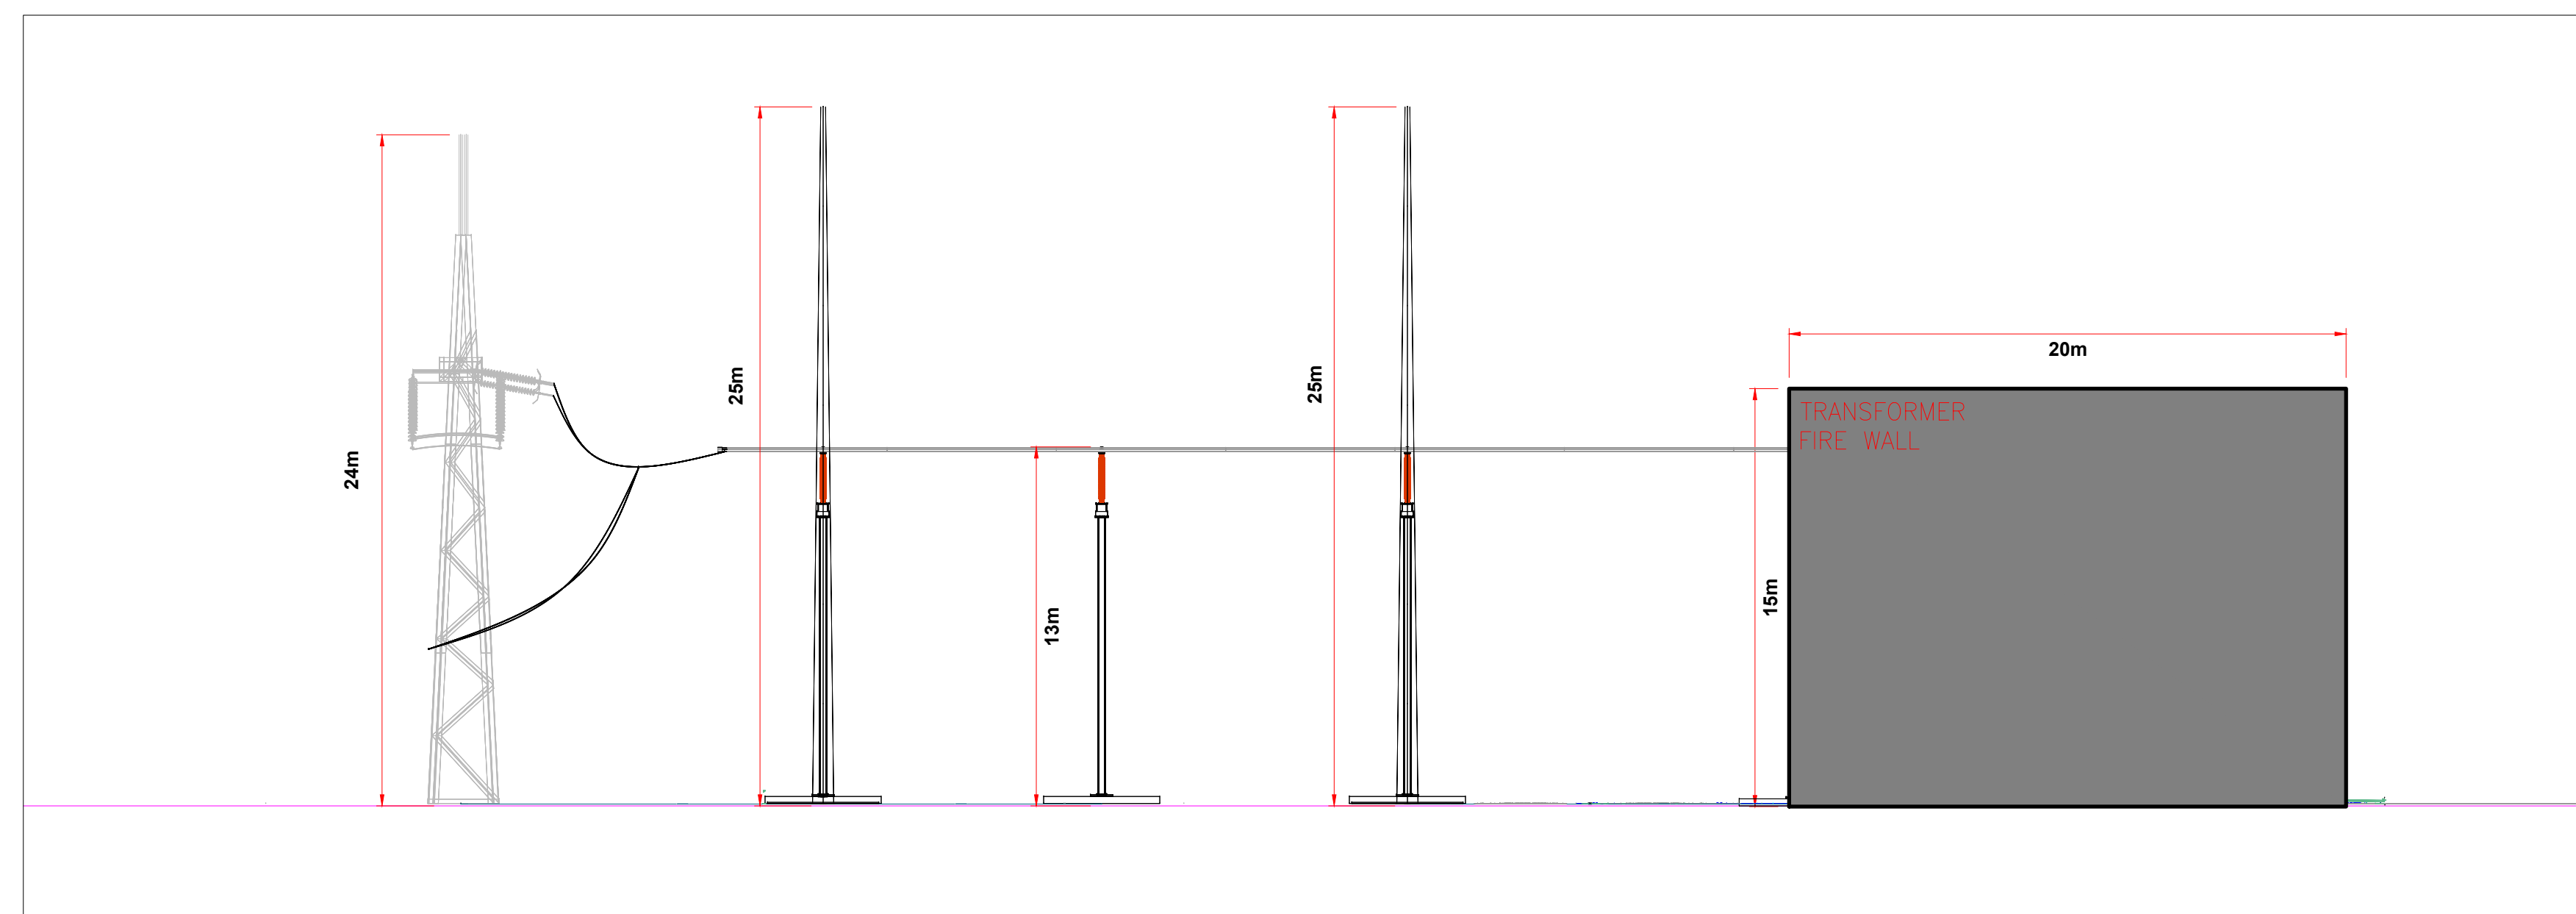

C-C SOUTH EAST ELEVATION
1:200

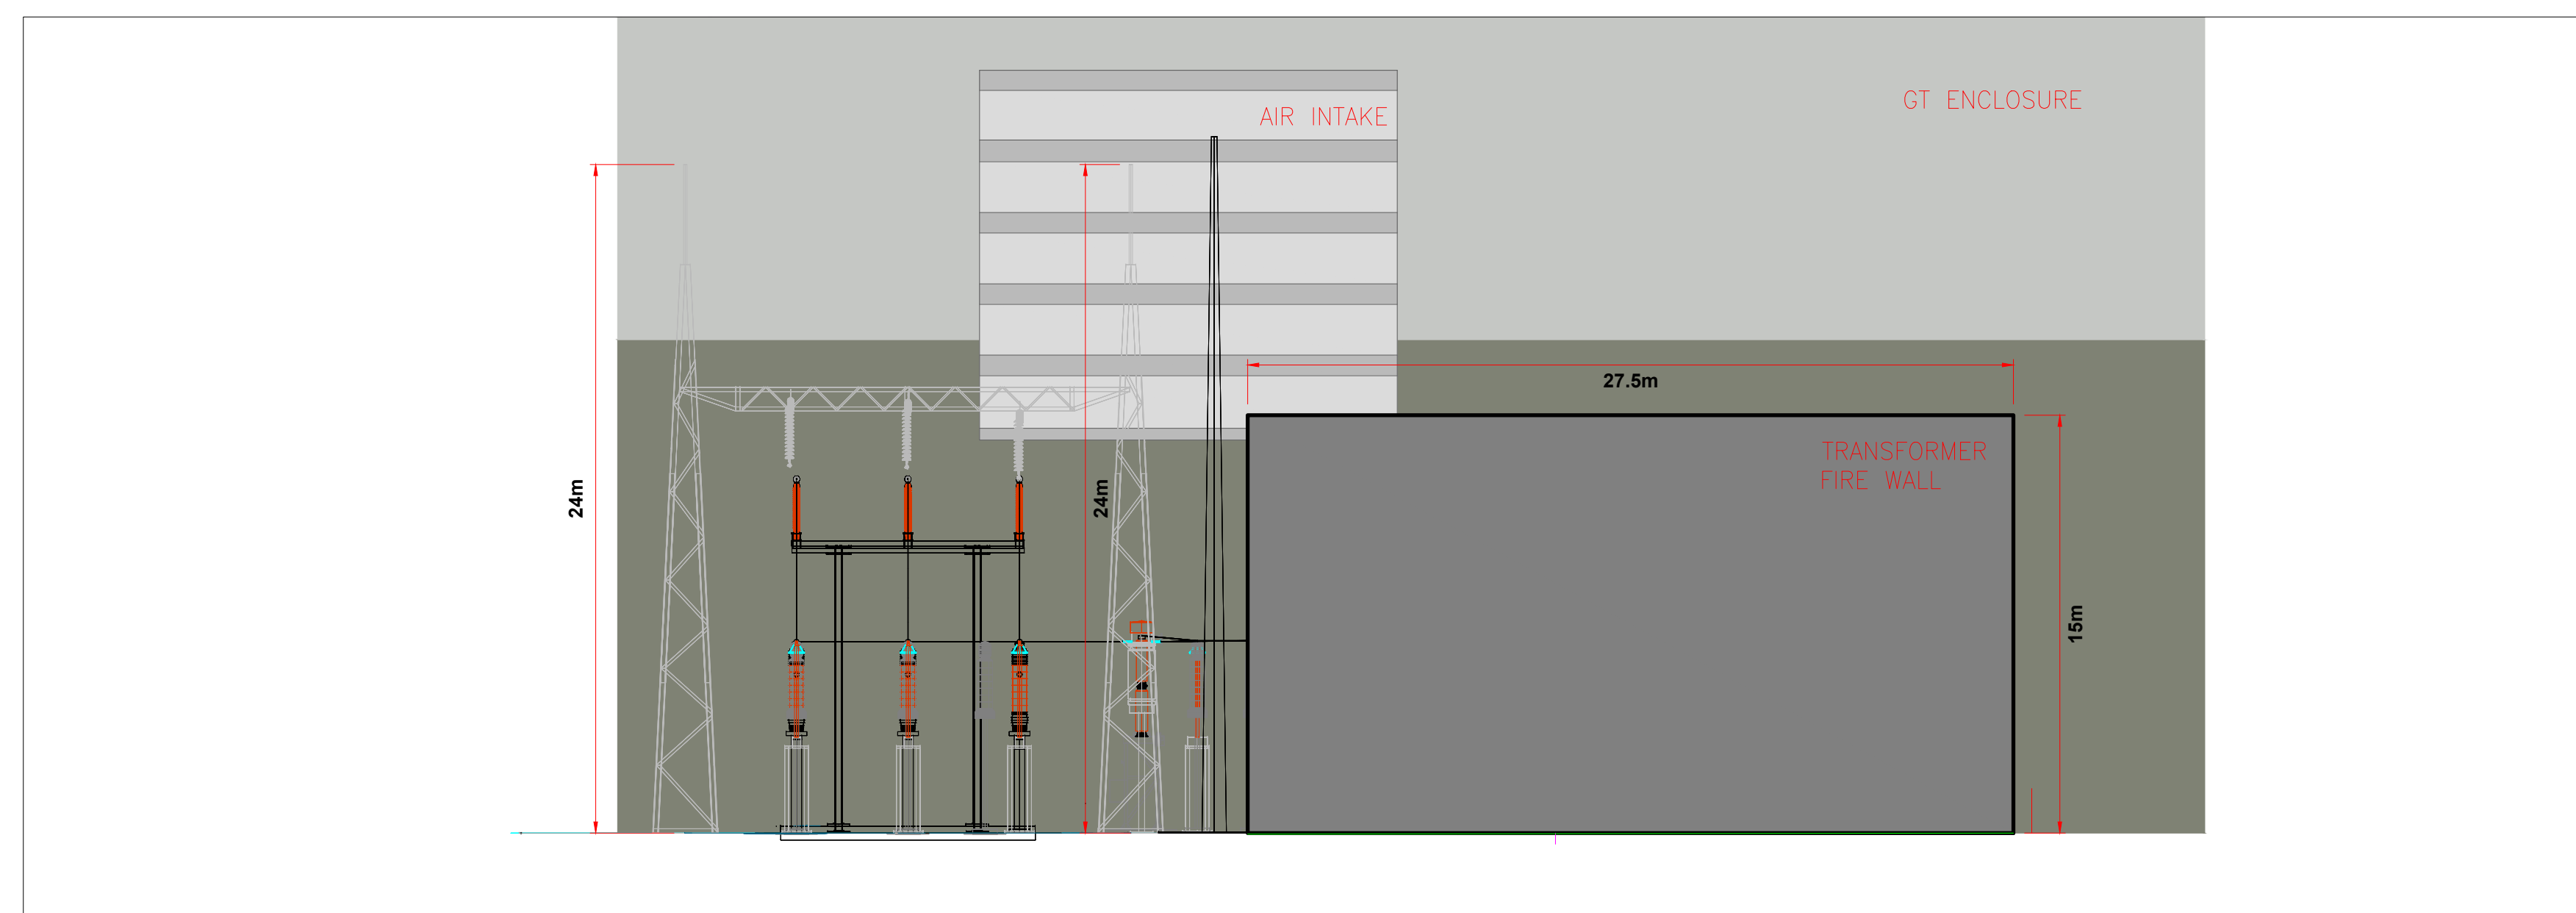

D-D SOUTH WEST ELEVATION
1:200

- NOTES**
1. PROPOSED ELEVATIONS ARE RELATIVE TO ORDNANCE DATUM POOLBEG
 2. TO BE PRINTED AT A0
 3. DETAIL OF FLOOD DEFENCE EXCLUDED
 4. REFER TO PROPOSED SITE ELEVATIONS FOR CONTIGUOUS DETAIL
 5. LIGHTNING PROTECTION LAYOUT IS INDICATIVE. LIGHTNING PROTECTION STUDY TO BE COMPLETED AT DETAILED DESIGN.

DRAWN BY
CONOR COONEY

ISSUE/REVISION

I/R	DATE	DESCRIPTION
B	22/11/2023	FOR PLANNING
A	10/11/2023	FOR COMMENT

PROJECT NUMBER
60695232

SHEET TITLE
HV CONNECTION & TRANSFORMERS
PLAN & ELEVATIONS

SHEET NUMBER
60695232-TBT-DR-016

This drawing has been prepared for the use of AECOM's client. It may not be used, modified, reproduced or relied upon by third parties, except as agreed by AECOM or as required by law. AECOM accepts no responsibility, and denies any liability, whatsoever, to any party that uses or relies on this drawing without AECOM's express, written consent. All measurements must be obtained from the stated dimensions.