

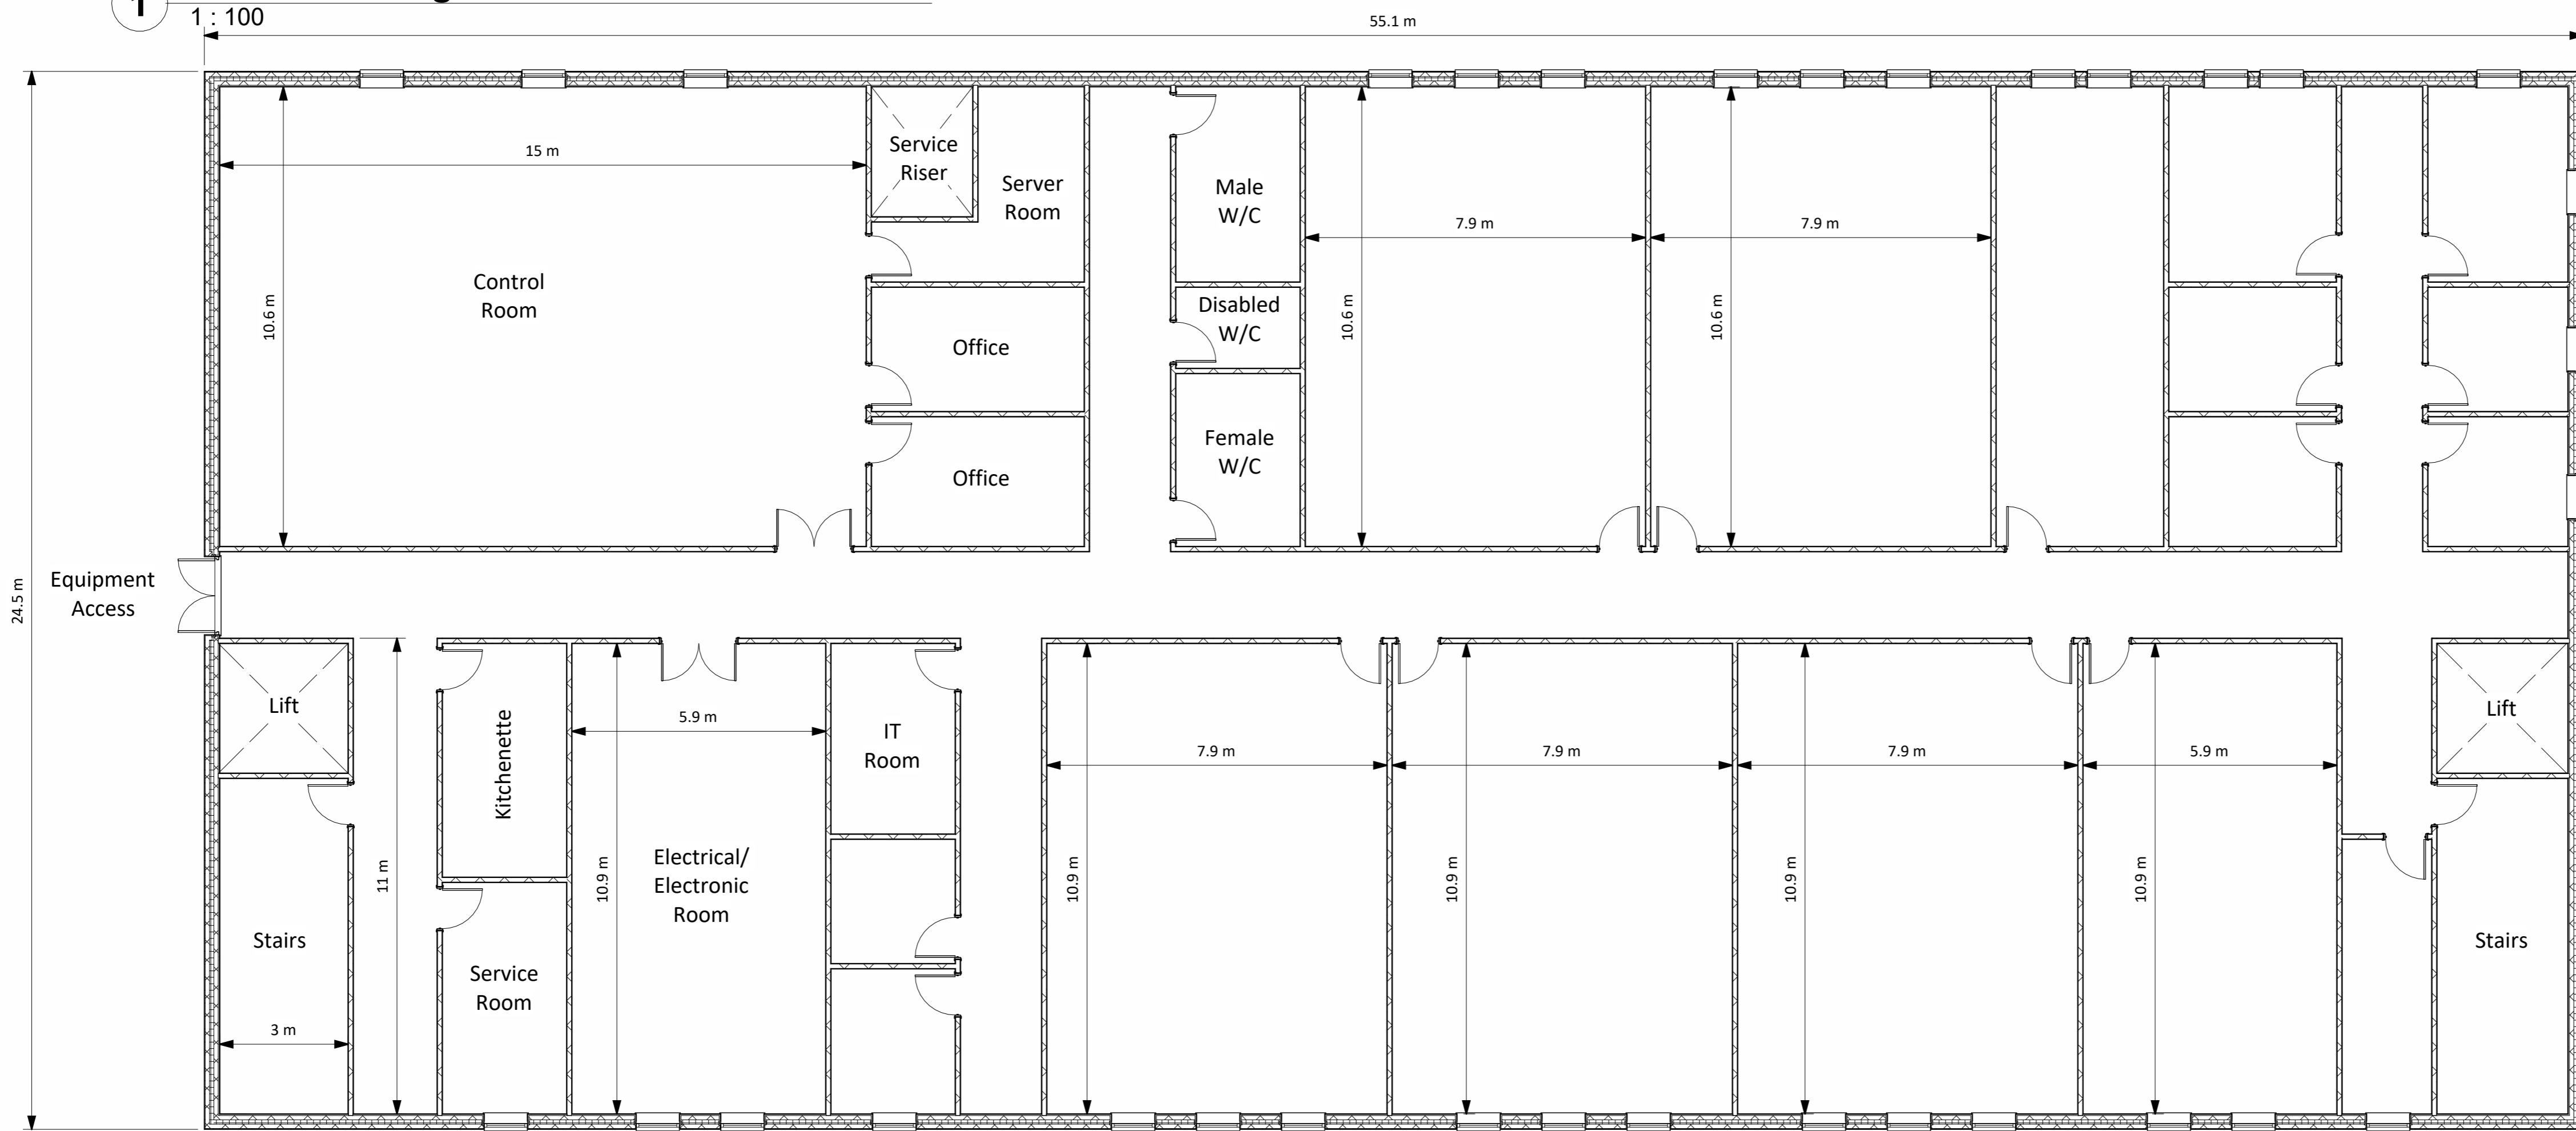


1 Admin Building Ground Floor 85.250m AOD
1 : 100

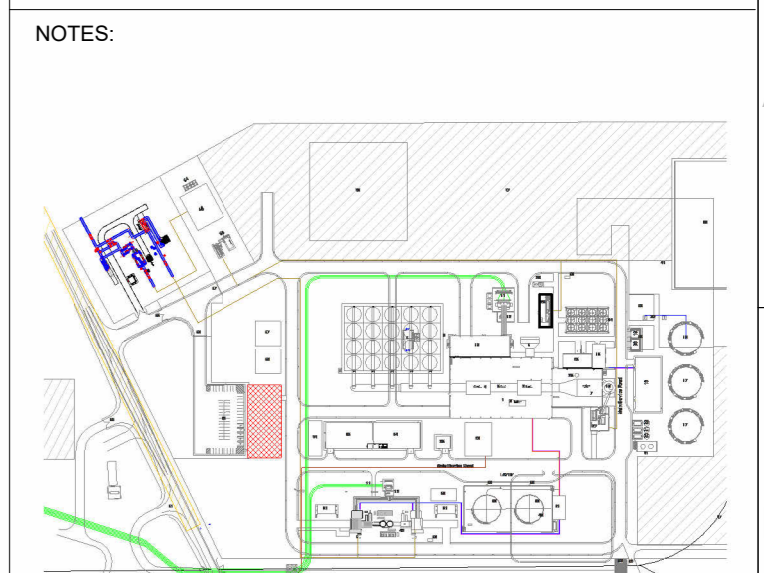

2 Admin Building First Floor 89.250m AOD
1 : 100

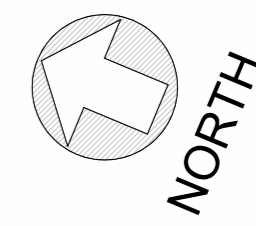

Key Plan
1 : 6000

NOTES:

R1.0	FOR PLANNING	DTW	AO1	BAB	26.01.24
REV.	DETAILS OF REVISION	DRAWN	CHKD	APR	DATE

FICHTNER
CONSULTING ENGINEERS LIMITED
7 Sir John Rogerson's Quay, Block C,
Grand Canal Docklands,
Dublin 2, D02 VK60
Tel: +353 (1) 506 0632
Website: www.fichtner.ie

CLIENT: **Bord na Móna Powergen Limited**

SITE:

PROJECT: **Derrygreenagh Power**

TITLE: **ADMIN BUILDING
GROUND & FIRST FLOOR FLOOR PLAN**

DRAWING STATUS:	For Planning
DRAWN BY:	DTW
CHECKED BY:	AO1
APPROVED BY:	BAB
DATE:	26.01.24

FILENAME: **DUBLIN**
OFFICE OF ISSUE: **A1**
SHEET SIZE: **A1**
DRAWING No.: **S7060-8050-0007**
SCALE: 1:100
REVISION: **R1.0**

