



1 Main Site North South Section A-A
1 : 500

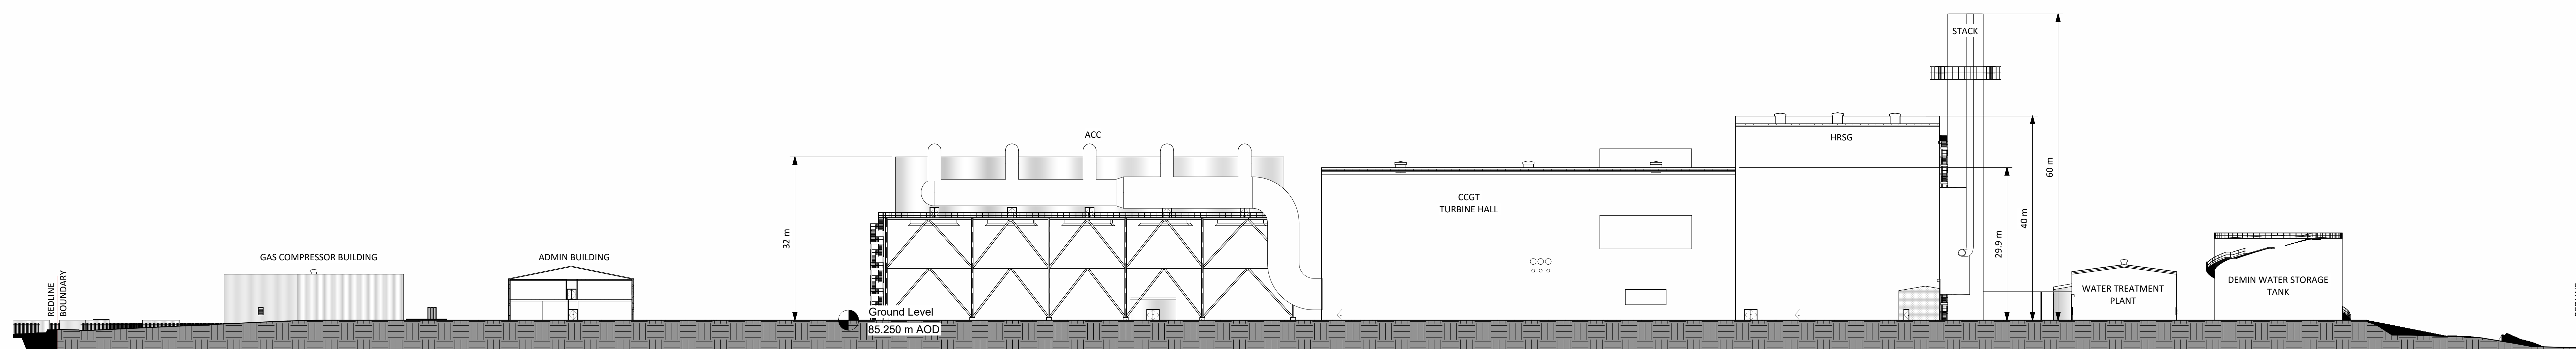

2 Main Site East West Section B-B
1 : 500

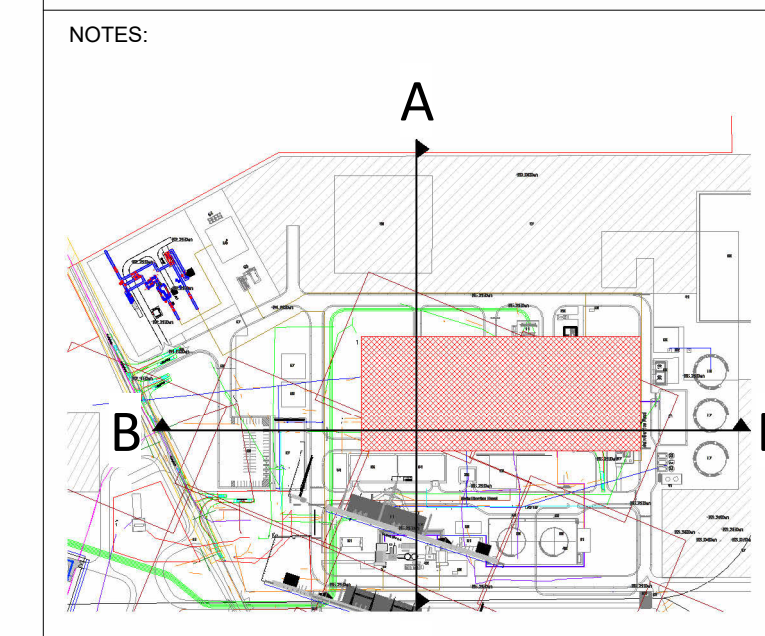

Key Plan
1 : 6000

- Building colours will range within a muted mid-dark grey and green spectrum. Refer to EIA Vol. II, Appendix 10A for detail
- Final detail of building finishes to be agreed with planning authority in advance of development commencing

R1.0	FOR PLANNING	DTW	AD1	BAB	26.01.24
REV	DETAILS OF REVISION	DRAWN	CHKD	APR	DATE

FICHTNER
CONSULTING ENGINEERS LIMITED
92 George's Street Lower
Dun Laoghaire
Co. Dublin, A98 V866
Tel: +353 (1) 508 0632
Website: www.fichtner.ie

CLIENT: Bord na Móna Powergen Limited

SITE:

PROJECT: Derrygreenagh Power

TITLE: POWER PLANT AREA - MAIN SITE SECTIONS

DRAWING STATUS:	For Planning	DATE:	26.01.24
DRAWN BY:	DTW	DATE:	26.01.24
CHECKED BY:	AD1	DATE:	26.01.24
APPROVED BY:	BAB	DATE:	26.01.24
FILENAME:			
OFFICE OF ISSUE:	DUBLIN	SCALE:	AS SHOWN
DRAWING No.:	S7060-8050-0037	Sheet:	011