




1 West
1 : 500

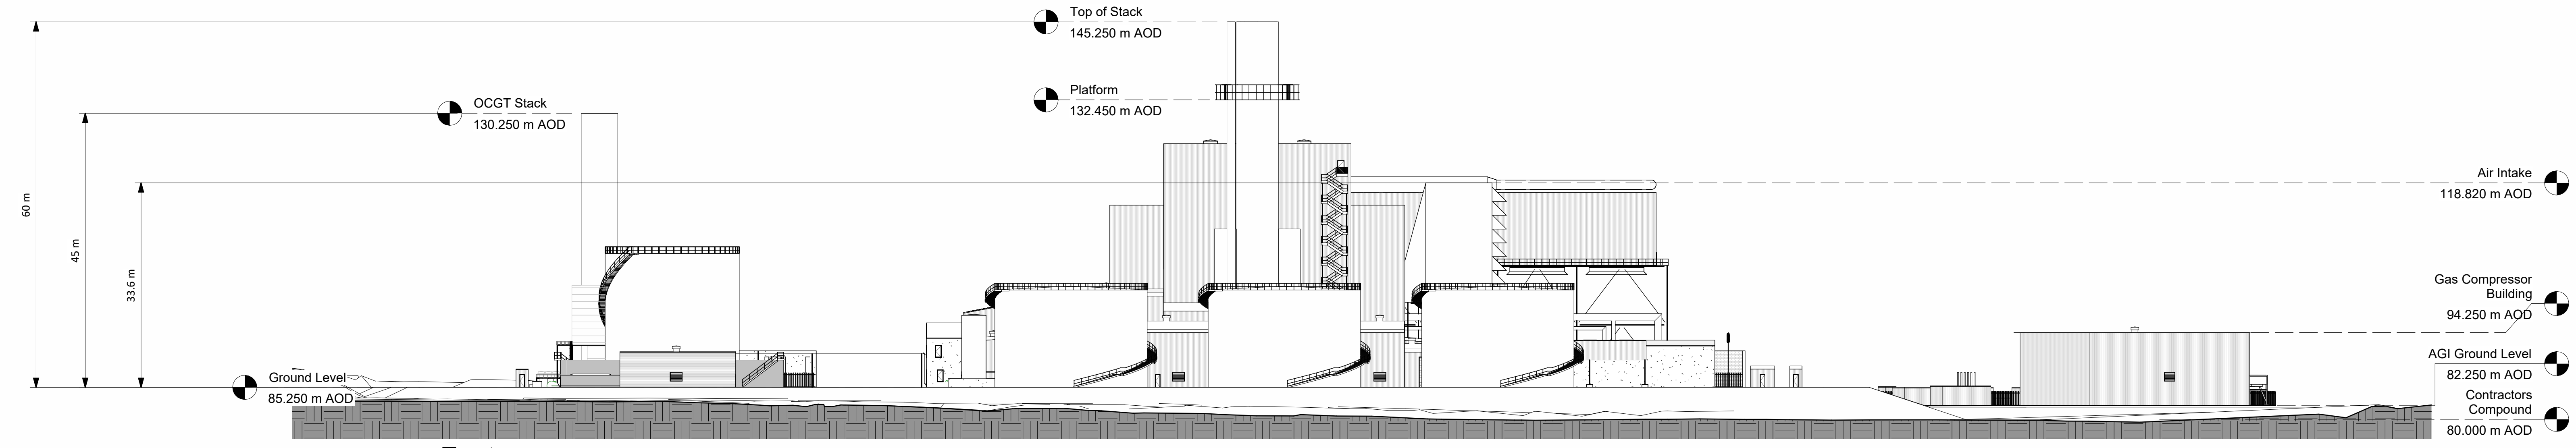


2 East
1 : 500

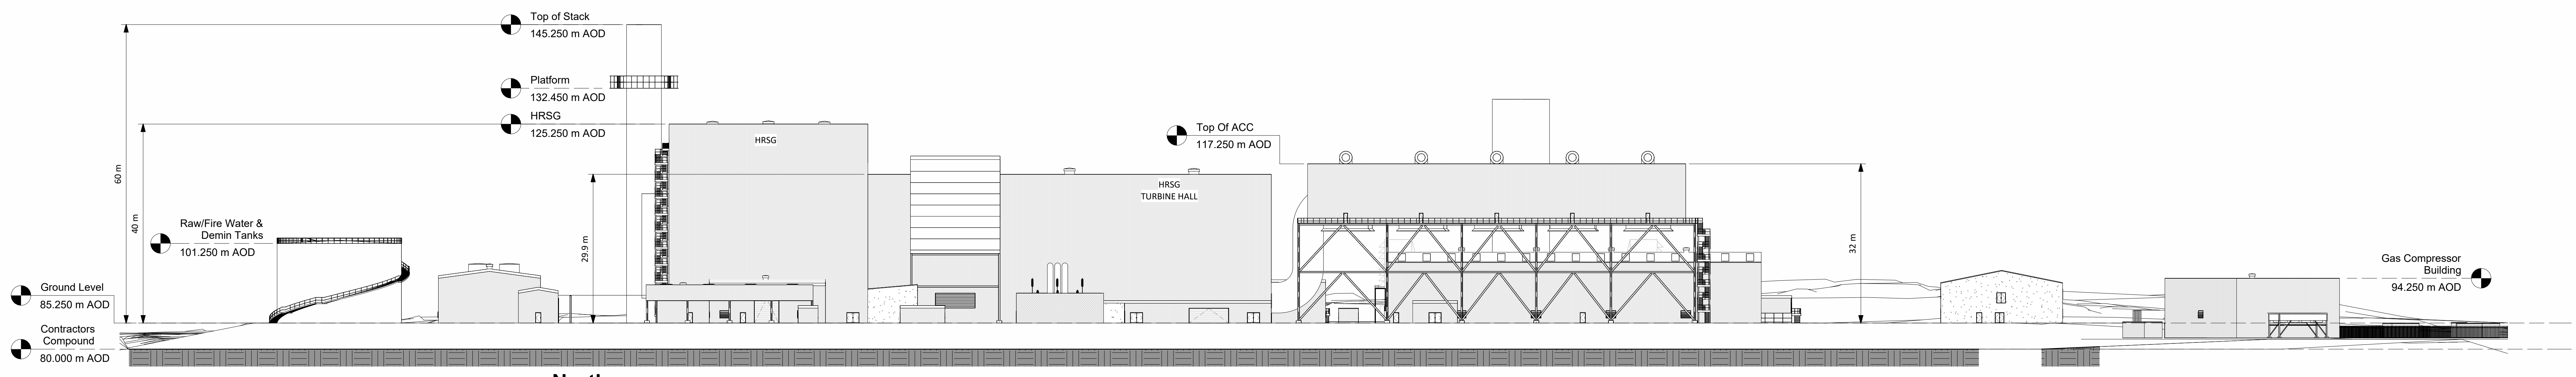

3 North
1 : 500

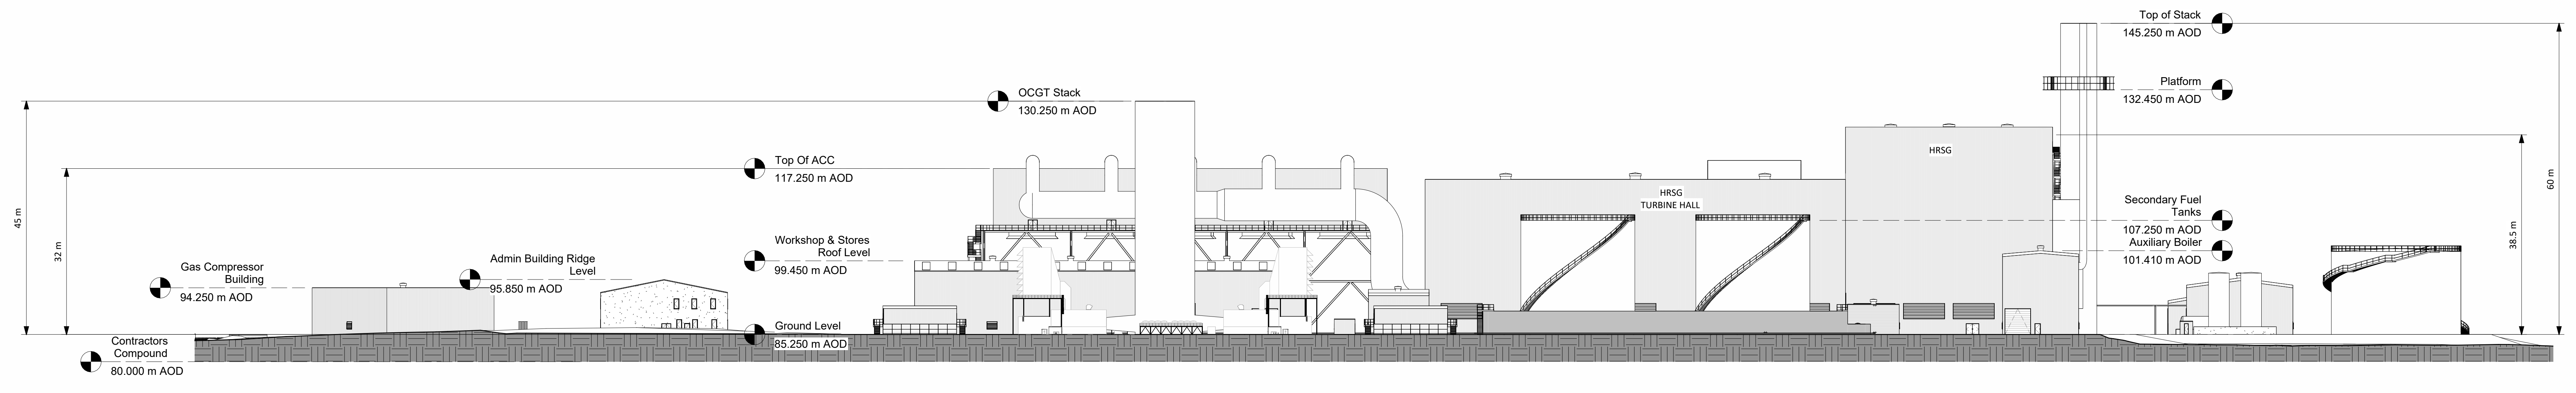

4 South
1 : 500

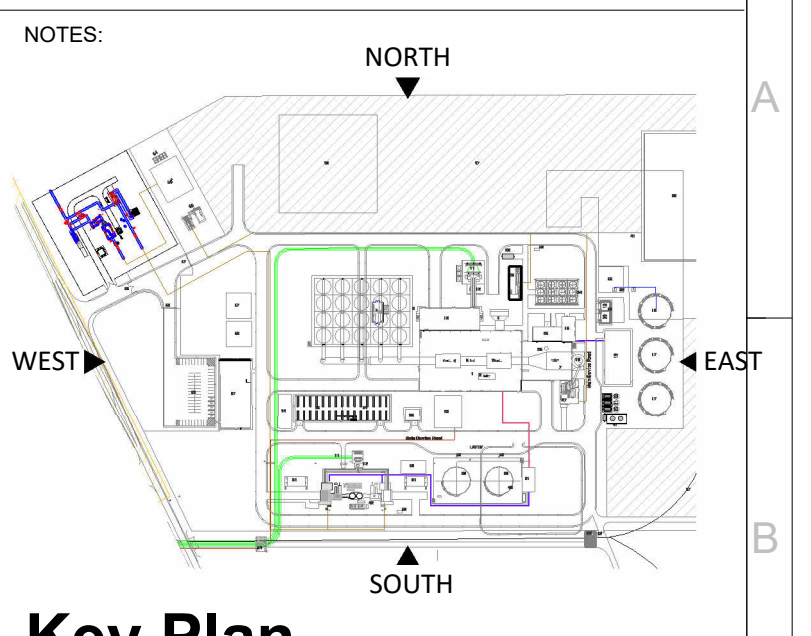

Key Plan
1 : 6000

- Building colours will range within a muted mid-dark grey and green spectrum. Refer to EIA R Vol. II, Appendix 10A for detail
- Final detail of building finishes to be agreed with planning authority in advance of development commencing

R1.0 FOR PLANNING	DTW	A01	BAB	26.01.24
REV. DETAILS OF REVISION	DRAWN/CHKD	APR	DATE	
FICHTNER CONSULTING ENGINEERS LIMITED				
92 George's Street Lower Dublin Co. Dublin A98 V966 Tel: +353 (0)1 508 0632 Website: www.fichtner.ie				
CLIENT:	Bord na Móna Powergen Limited			
PROJECT:	Derrygreenagh Power			
TITLE:	POWER PLANT AREA MAIN SITE ELEVATIONS			
DRAWING STATUS:	For Planning	DTW	DATE	26.01.24
CHECKED BY:	A01	DATE	26.01.24	
APPROVED BY:	BAB	DATE	26.01.24	
FILENAME:				
OFFICE OF ISSUE:	DUBLIN		SCALE: 1:100	
SHEET SIZE:	A0		SCALE: 1:100	
DRAWING No.:	S7060-8050-0057		REVISION:	
	Sheet	001	R1.0	

