


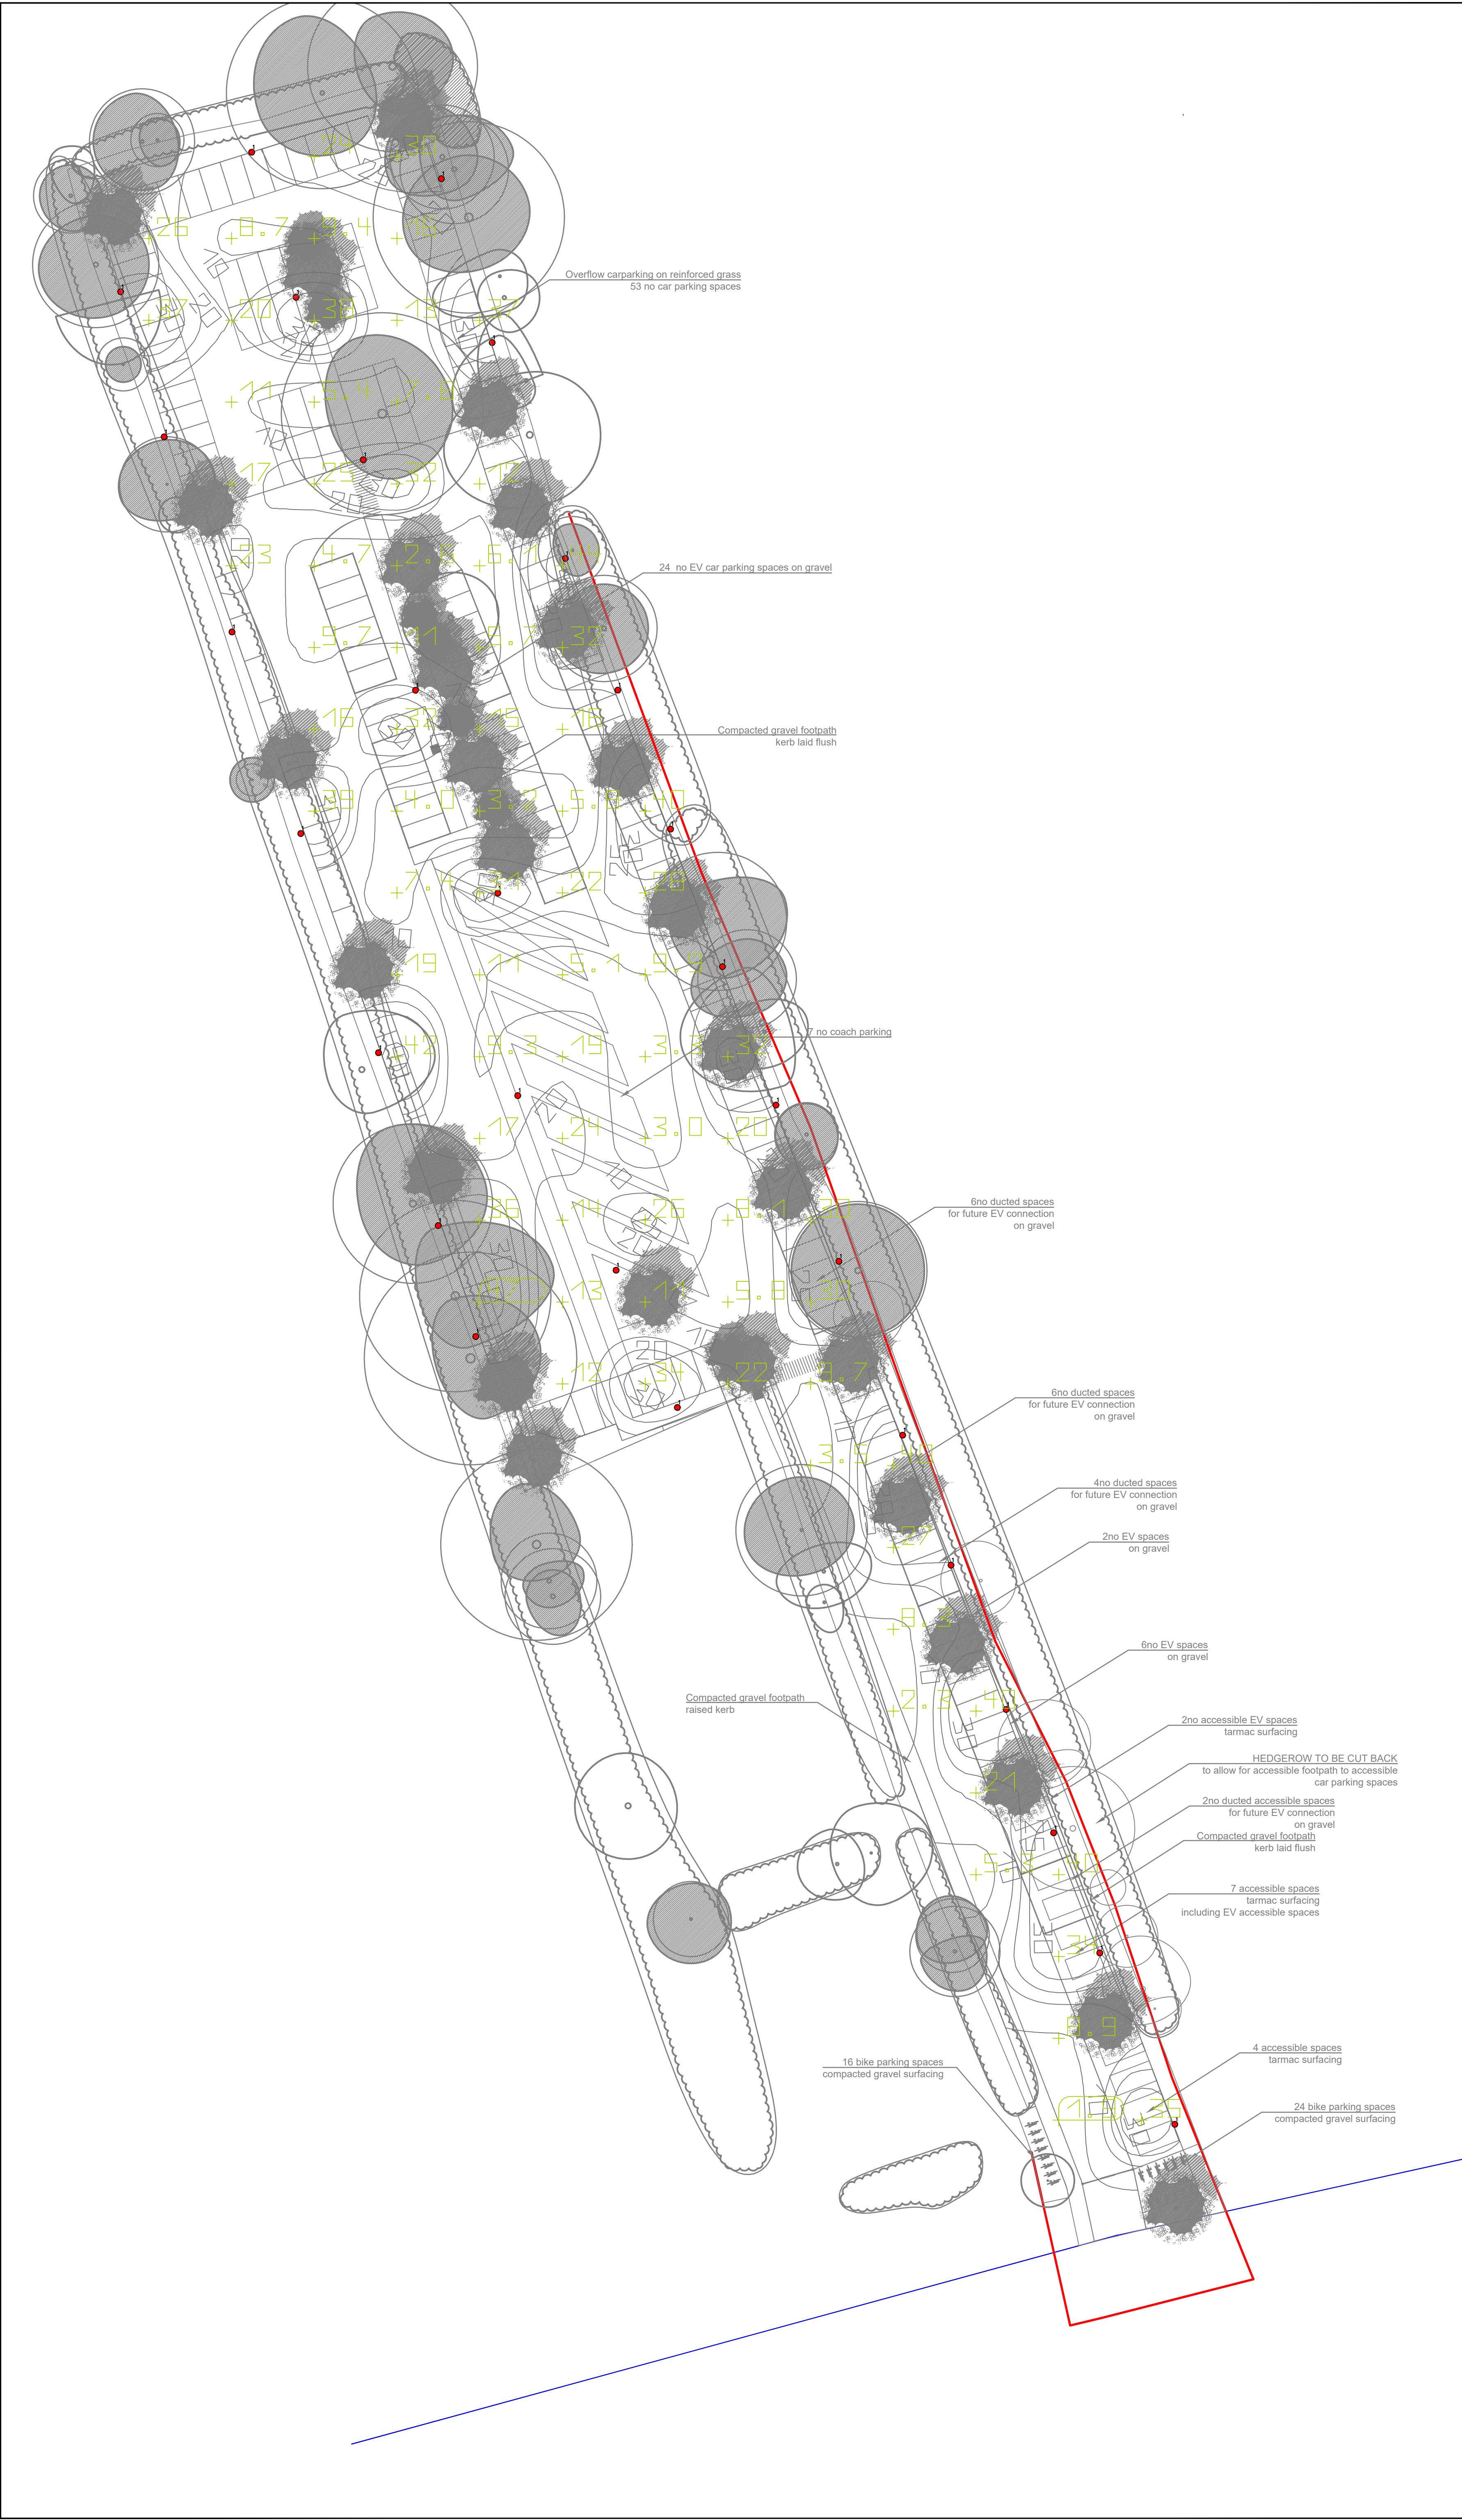

DO NOT SCALE FROM THIS DRAWING. USE FIGURED DIMENSIONS IN ALL CASES. VERIFY DIMENSIONS ON SITE AND REPORT ANY DISCREPANCIES TO THE DESIGNERS IMMEDIATELY.
THIS DRAWING IS TO BE READ IN CONJUNCTION WITH THE DESIGNERS SPECIFICATION.
© THIS DRAWING IS COPYRIGHT AND MAY ONLY BE REPRODUCED WITH THE DESIGNERS PERMISSION.

PUBLIC LIGHTING

1 Garrabridge - SLI.2.LA093.2S.W068 S-LINE
Streetlighting luminaire mounted on 6m columns.
Luminous emittance 1
Fitting: 1 x LED C.9000 Lumens
Absolute photometry
Luminaire luminous flux: 7809 lm
Power: 68.0W
Luminous efficacy: 114.8 lm/W
Colourimetric data:
1x: CCT 3000 K, CRI 100



Garrabridge - SLI.2

P01		29/11/24		ISSUED FOR PLANNING		S.C.		I.B.	
REV		DATE		DESCRIPTION		BY		APP	
PROJECT: MOUNTSHANNON CARPARK									
TITLE: SITE LIGHTING LAYOUT									
CLIENT: CLARE COUNTY COUNCIL									
MWP ENGINEERING AND ENVIRONMENTAL CONSULTANTS CORK TRALEE LONDON LIMERICK mwp.ie									
DRAWN:		CHECKED:				APPROVED:			
S.C.		F.F.				FF			
PROJECT NUMBER:		DATE:		SCALE @ A1:					
21760		NOV' 24		1:350					
STATUS DESCRIPTION								STATUS:	
FOR INFORMATION								S2	
DRAWING NUMBER:								REV:	
21760 - MWP -00 -VC-DR-E-9100								P01	