


Manhole access size as per table NA.22 BS EN 752		
Depth	< 1.5m cover to pipe soffit	> 1.5m cover to pipe soffit
Min clear opening	1200mm x 675mm	600mm x 600mm

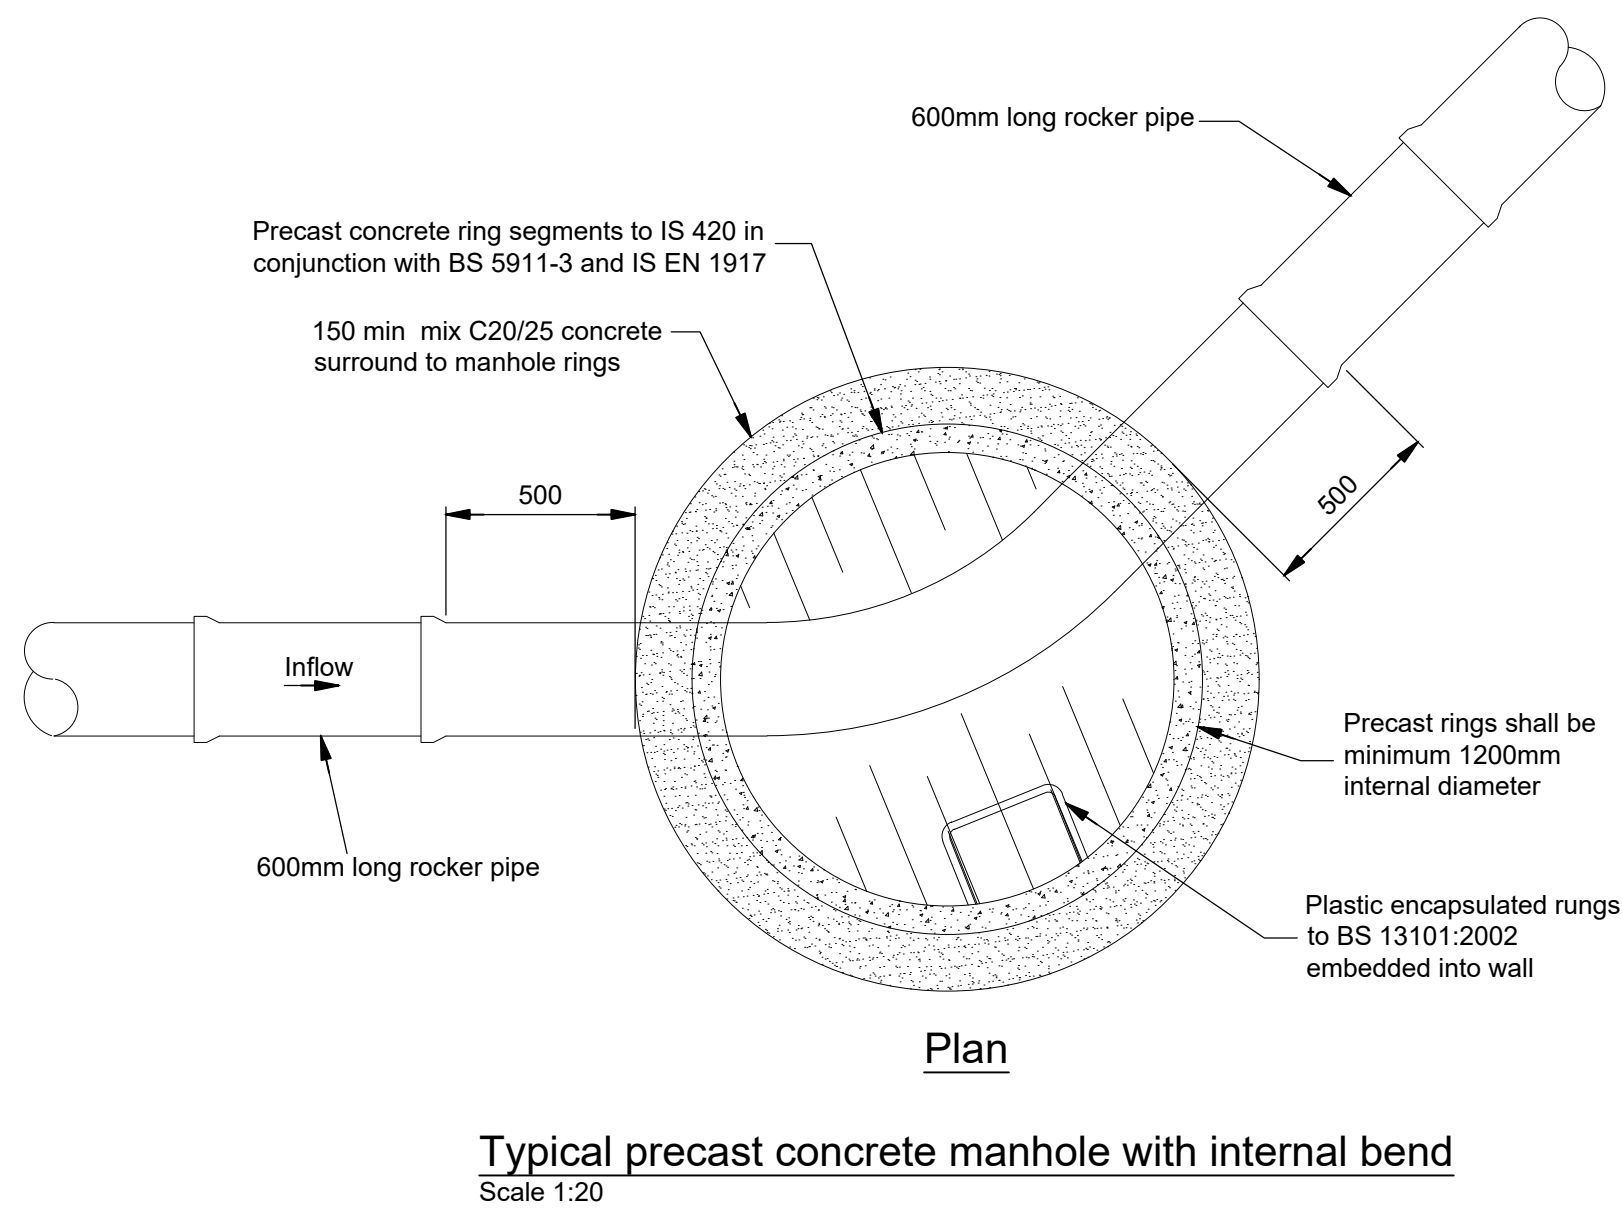

- ### KEY TO SYMBOLS

REFERENCE DRAWINGS	
229100714-MMD-00-XX-DR-C-5050	- OSS Site Drainage and Watermain Layout
229100714-MMD-00-XX-DR-C-5051	- OSS Site Drainage Layout - Sheet 01
229100714-MMD-00-XX-DR-C-5052	- OSS Site Drainage Layout - Sheet 02
229100714-MMD-00-XX-DR-C-5053	- OSS Watermain Layout - Sheet 01
229100714-MMD-00-XX-DR-C-5054	- OSS Watermain Layout - Sheet 02
229100714-MMD-00-XX-DR-C-5056	- OSS Drainage Details Sheet 02
229100714-MMD-00-XX-DR-C-5057	- OSS Drainage Details Sheet 03
229100714-MMD-00-XX-DR-C-5058	- OSS Drainage Details Sheet 04

EcoDoc NUMBER:  
005396095-03

DRAWING STATUS	
1	1
2	2
3	3
100	100

**PUBLIC**

DISCLAIMER

THIS IS MADE AVAILABLE "AS IS" AND NO WARRANTIES ARE GIVEN OR LIABILITIES OF ANY KIND ARE ASSUMED WITH RESPECT TO THE QUALITY OF SUCH INFORMATION, INCLUDING, BUT NOT LIMITED, TO ITS FITNESS FOR A SPECIFIC PURPOSE, NON-INFRINGEMENT OF THIRD PARTY RIGHTS OR ITS CORRECTNESS. THE REPRODUCTION, DISTRIBUTION AND UTILISATION OF THIS DOCUMENT AS WELL AS THE COMMUNICATION OF ITS CONTENTS TO OTHERS WITHOUT EXPLICIT AUTHORISATION IS PROHIBITED.

COPIES - DIGITAL OR PRINTED ARE NOT CONTROLLED.

MAP NOTES / DATA SOURCES:

PROJECT TITLE:  
Dublin Array Offshore Wind Farm

DRAWING TITLE:  
OSS - Drainage Details - Sheet 01

DRAWING NUMBER:  
229100714-MMD-00-XX-DR-C-5055

SHEET NUMBER:  
01 of 04

VER	DATE	REMARKS	DRAW	CHECK	APPROVE
PL1	23-10-2024	For Submission	ERN	DMY	DM
PL2	2024-11-04	For Submission	SHY	DMY	DM

SCALE: 1:20	DATUM: IREN95	VERTICAL REF:
PLOT SIZE: A1	PRJ: IREN95 IRISH TRANSVERSE MERCATOR	

