


No part of this document may be re-produced or transmitted in any form or stored in any retrieval system of any nature without the written permission from Homan O'Brien Associates as copyright holder except as agreed for use on the project for which the document was originally issued. © Homan O'Brien Associates Copyright.

Symbols Reference:

- | | |
|--|-----------------------------------|
|  | Eir Duct. |
|  | ESB LV Duct. |
| | Virgin Duct. |
|  | ELV Duct. |
|  | Centralised Heating F&R Pipework. |
|  | Boosted Water Pipework. |
| MH  | Manhole. |

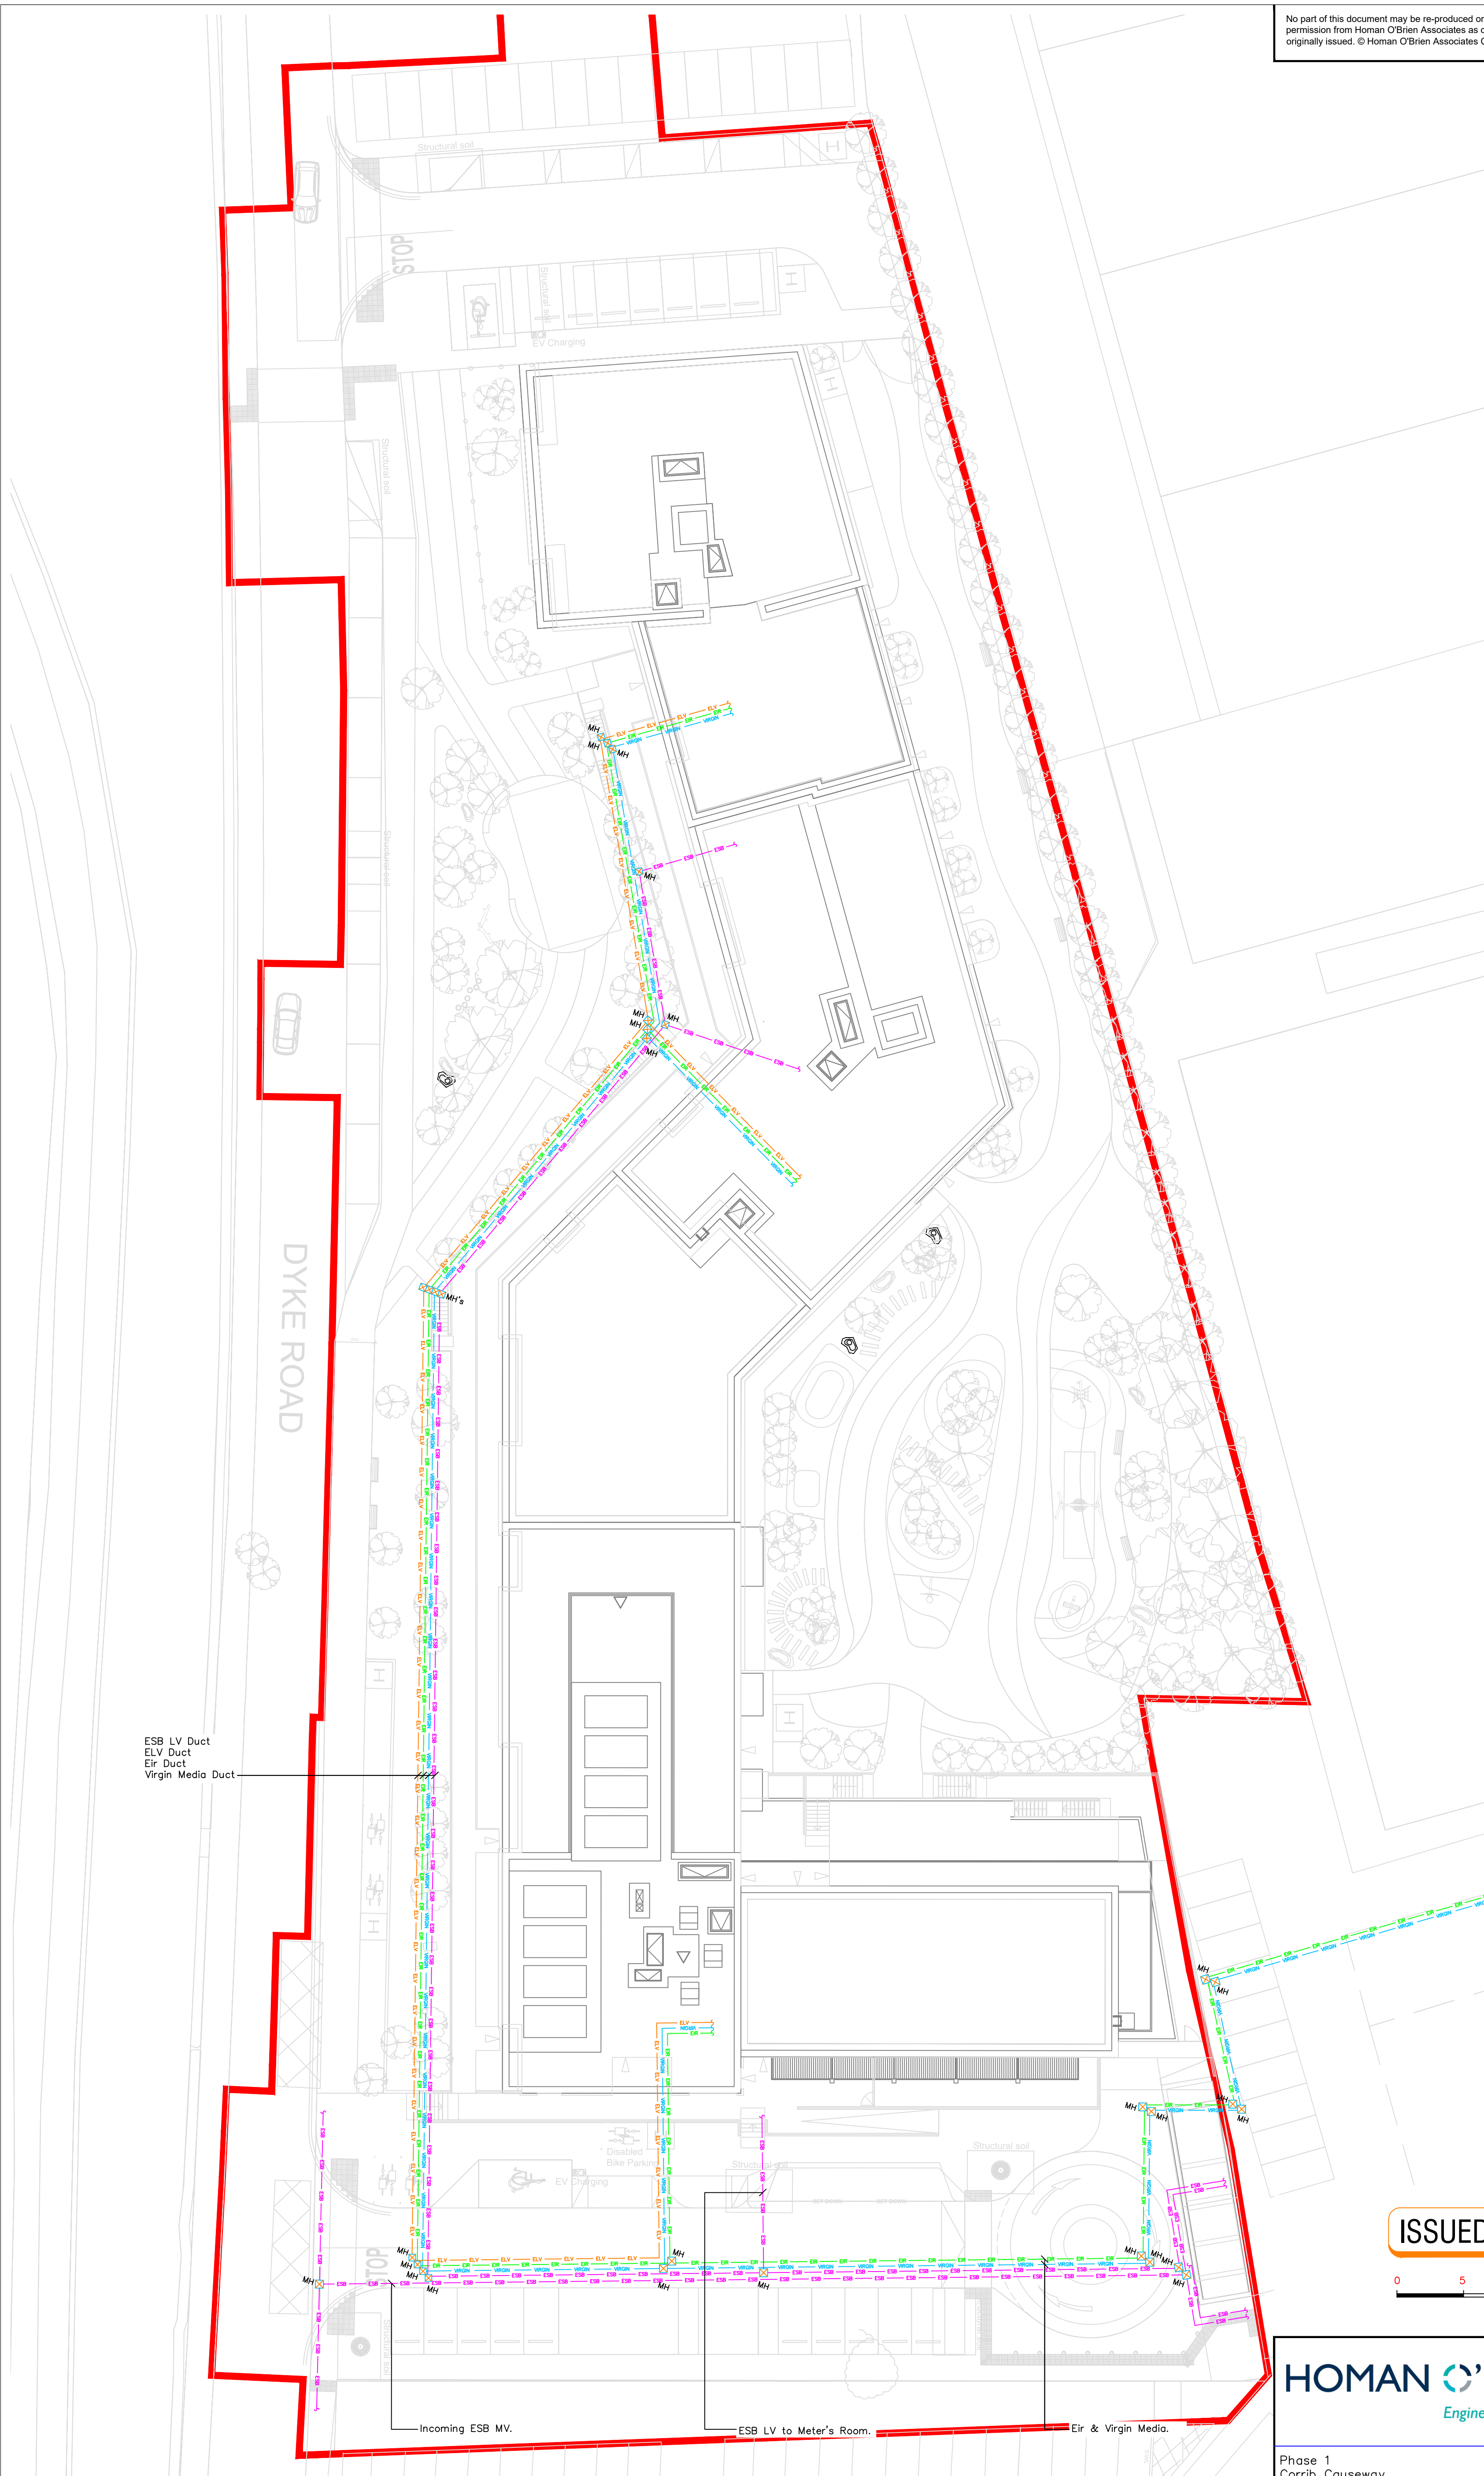

ISSUED FOR INFORMATION



HOMAN O'BRIEN
Engineering Excellence.

Consulting Engineers
89 Booterstown Avenue, Blackrock, Co. Dublin.
Telephone: 2056300, Fax: 2056301
E-mail: info@homanobrien.ie
Web: www.homanobrien.ie

Phase 1 Corrib Causeway Dyke Road, Galway.		Galway City Council (GCC)		
Mechanical/Electrical Services Installation		MOLA Architects 2 Donnybrook Rd, Dublin 4.		
Site Plan M&E Site Services Layout				
Date 17-10-2023	Scale Refer to Scalebar	Drawn S.O.B.	Checked B.H.	Issue 102
Drawing Number DYR-HOB-XX-XX-DR-ME-1000				

[illegible]