



NOTES:
1. THIS DRAWING IS THE PROPERTY OF DELAP & WALLER AND MAY ONLY BE USED WITH THEIR WRITTEN APPROVAL.
2. DO NOT SCALE FROM THIS DRAWING.

THIS DRAWING SERVES AS A REFERENCE TO THE DIMENSIONS OF THE
REQUIRED ESB TRANSFORMER LOCATION ONLY.
REFER TO ESB MV SUBSTATION DRAWINGS FOR DETAILED INFORMATION.

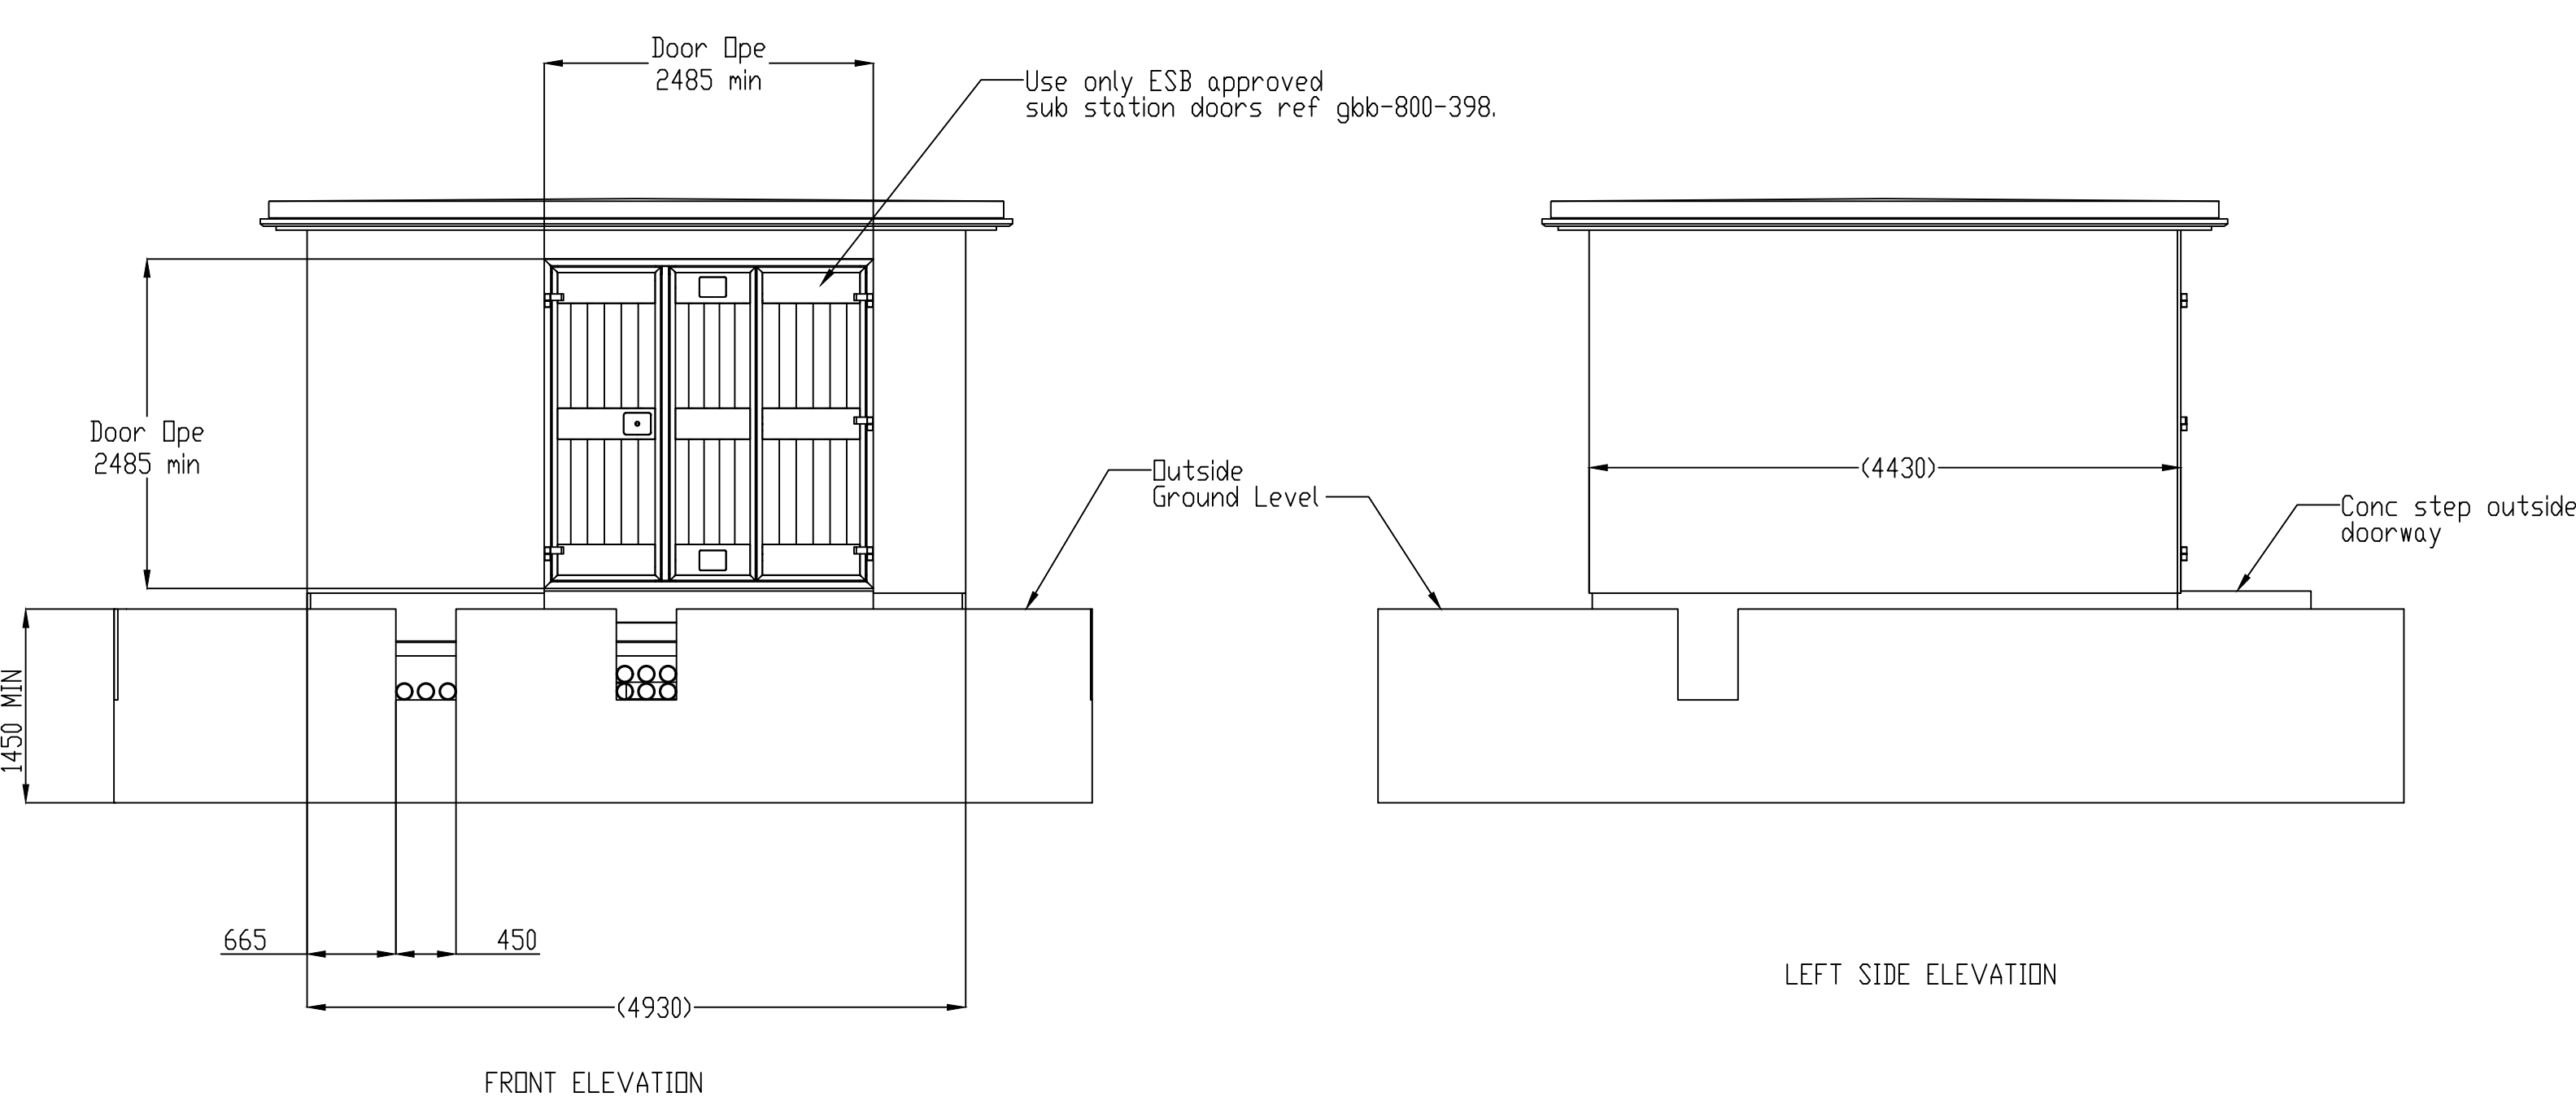

Before work commences be sure to read
and fully understand the requirements
as detailed in DDC-280518-DFK

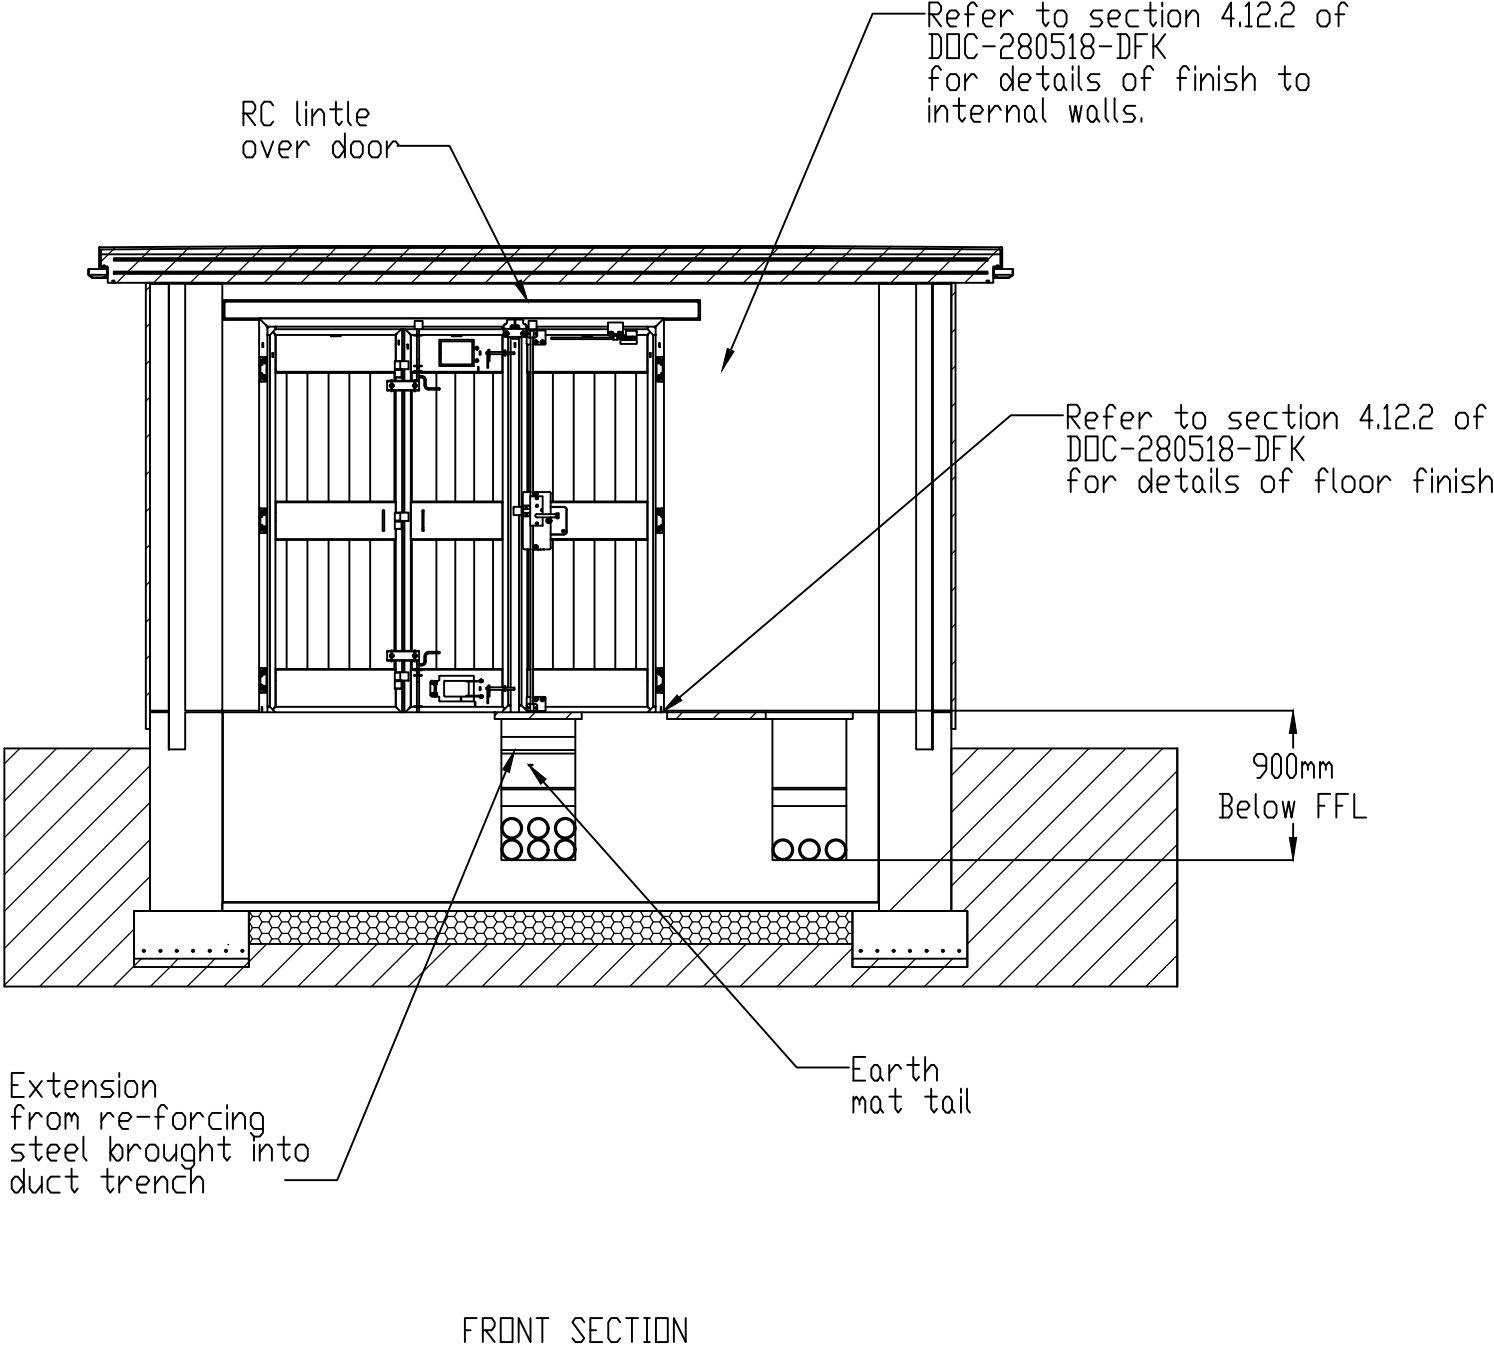

P04	ADB	ISSUED FOR PLANNING	27.01.2024
P03	ADB	ISSUED FOR PLANNING	05.12.2024
P02	ADB	PRELIMINARY DRAWING	15.11.2024
P01	ADB	PRELIMINARY DRAWING	12.08.2024
REV	BY	DESCRIPTION	DATE
PROJECT: DUBLIN STREET NORTH REGENERATION			
 www.delapandwaller.com ☐ Antrim: T +44 (0) 28 9448 3800 ☐ Dublin: T +353 (0) 1 535 5900 ☐ London: T +44 (0) 20 8059 7373			
CLIENT: MONAGHAN COUNTY COUNCIL			
SCALE AT A1: 1:500		CHK: ADB DES: ADB	APP: RS DRW: ADB
WORK PACKAGE: M&E DESIGN			
DRAWING TITLE: ESB SUBSTATION			
DRAWING NUMBER: Project Originator Zone Level Type Role - Number 22268 DLW- XX - XX - XX - E - 00500			
SUITABILITY: Suitable for review and comment			REV: P04