

MATCHLINE - FOR CONTINUATION SEE E2603

C

D

MATCHLINE - FOR CONTINUATION SEE E2602

F

G

AIR COOLED CONDENSER
TOP - 52 STANCHION MTD LED FIXTURES (FVA TYPE FIXTURES)
2 STAIR TOWERS - 10 STANCHION MTD LED FIXTURES (FVA TYPE FIXTURES)
UNDER FOR ROAD LIGHTING - 2 BRACKET MTD LED FIXTURES (BLA TYPE FIXTURES)

AIR COOLED CONDENSER
TOP - 52 STANCHION MTD LED FIXTURES (FVA TYPE FIXTURES)
2 STAIR TOWERS - 10 STANCHION MTD LED FIXTURES (FVA TYPE FIXTURES)
UNDER FOR ROAD LIGHTING - 2 BRACKET MTD LED FIXTURES (BLA TYPE FIXTURES)

AIR COOLED CONDENSER
TOP - 52 STANCHION MTD LED FIXTURES (FVA TYPE FIXTURES)
2 STAIR TOWERS - 10 STANCHION MTD LED FIXTURES (FVA TYPE FIXTURES)
UNDER FOR ROAD LIGHTING - 2 BRACKET MTD LED FIXTURES (BLA TYPE FIXTURES)

CONSTRUCTION FACILITIES AREA

BATTERY STORAGE AREA

RETAINING WALL

MATCHLINE
FOR CONTINUATION SEE E2606

AIR COOLED HEAT EXCHANGERS


NOTES

1. FOR GENERAL NOTES AND SYMBOL LEGEND SEE DRAWING 1LTA-E2600.

FIXTURE LIST

SYMBOL	DESCRIPTION	COUNT
BLA	2688 LUMEN, LED BRACKET MOUNTED FIXTURE, TYPE I OPTICS	12
FVA	2688 LUMEN, LED STANCHION MOUNTED FIXTURE, TYPE I OPTICS	156
SLA	7,000 LUMEN, LED ROADWAY LIGHT FIXTURE, TYPE II OPTICS	15
SLB	10,500 LUMEN, LED ROADWAY LIGHT FIXTURE, TYPE III OPTICS	4
SLD	35,100 LUMEN, LED ROADWAY LIGHT FIXTURE, TYPE V OPTICS	6

KEY PLAN

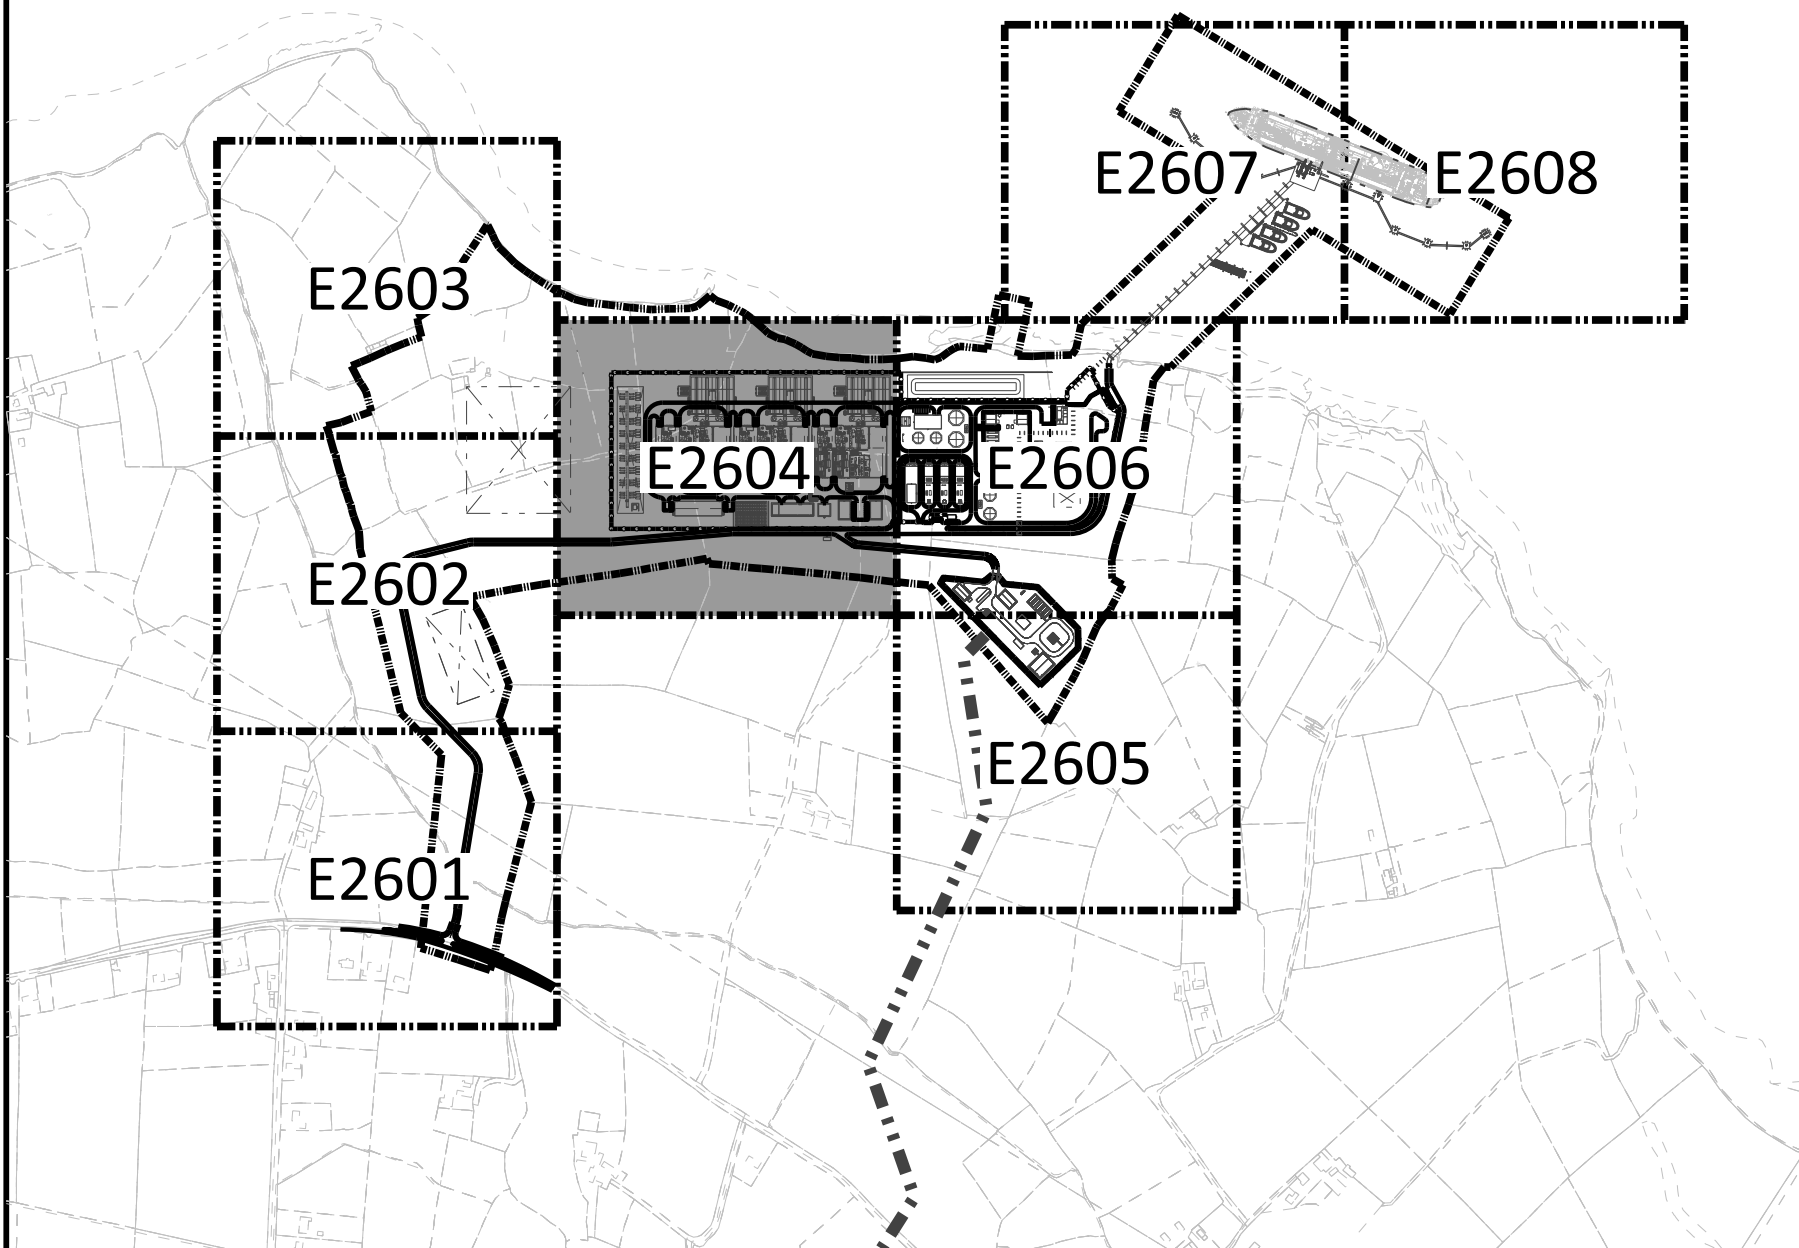


**NOT TO BE USED
FOR CONSTRUCTION**

THE DISTRIBUTION AND USE OF THE NATIVE FORMAT CAD
FILE OF THIS DRAWING IS UNCONTROLLED. THE USER
SHALL VERIFY TRACEABILITY OF THIS DRAWING TO THE
LATEST CONTROLLED VERSION.

PROJECT	DRAWING NUMBER	REV
SHANNON LNG LIMITED SHANNON TECHNOLOGY AND ENERGY PARK (STEP) LIGHTING - SITE PLAN - AREA 4	198291-1LTA-E2604	1
CODE	AREA	

BLACK & VEATCH CORP HEADQUARTERS:
11401 LAMAR AVENUE, OVERLAND PARK,
KANSAS, USA

DESIGNER	DRAWN
BMD	BMD
CHECKED	DATE

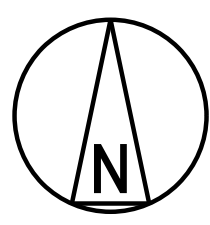

1:500
0 10 20 30 40
SCALE IN METERS

NO	DATE	REVISIONS AND RECORD OF ISSUE	DRN	DES	CHK	PDE	APP
1	18/JUN/2021	ISSUED FOR PLANNING		BMD	BMD	DAC	
0	15/MAR/2021	ISSUED FOR PLANNING		BMD	BMD	DAC	