




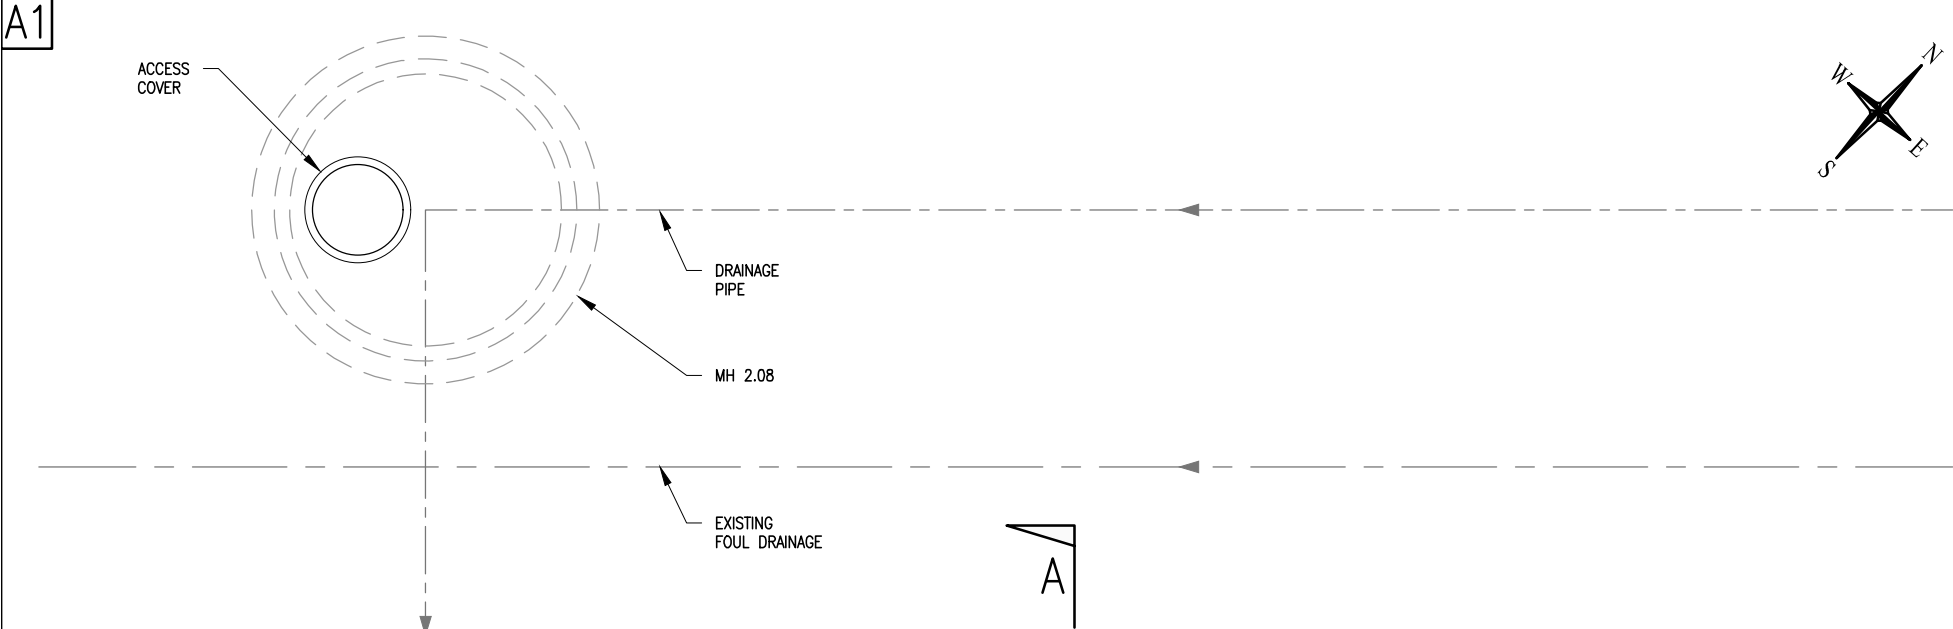


PS ROOF PLAN
(SCALE 1:50)

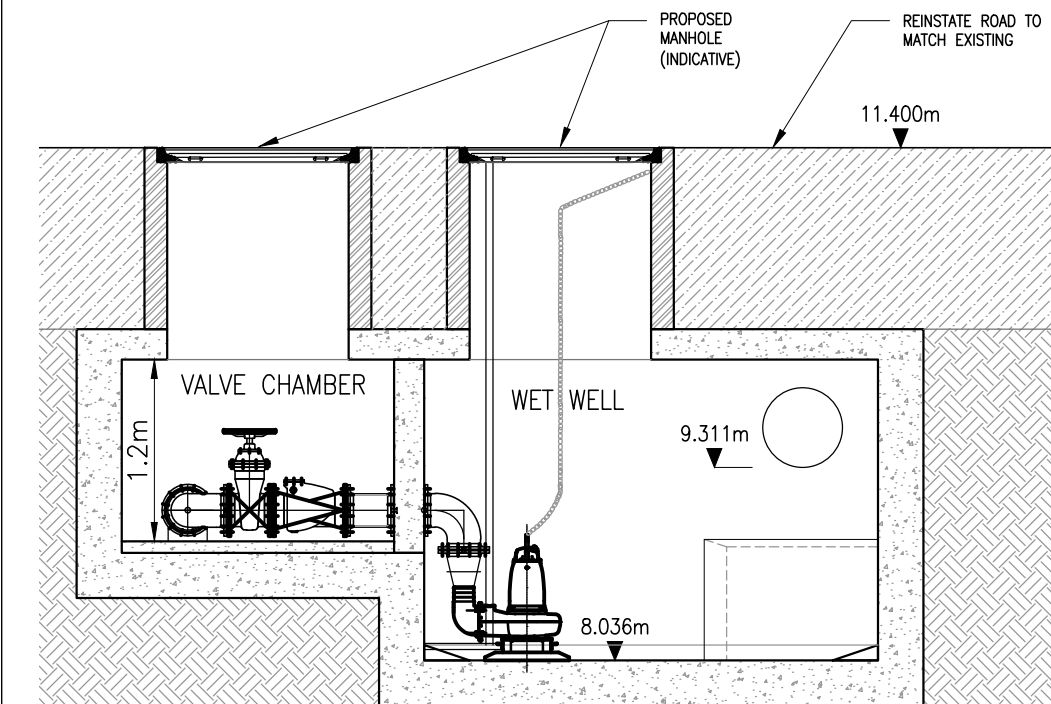


SECTION A-A
(SCALE 1:50)

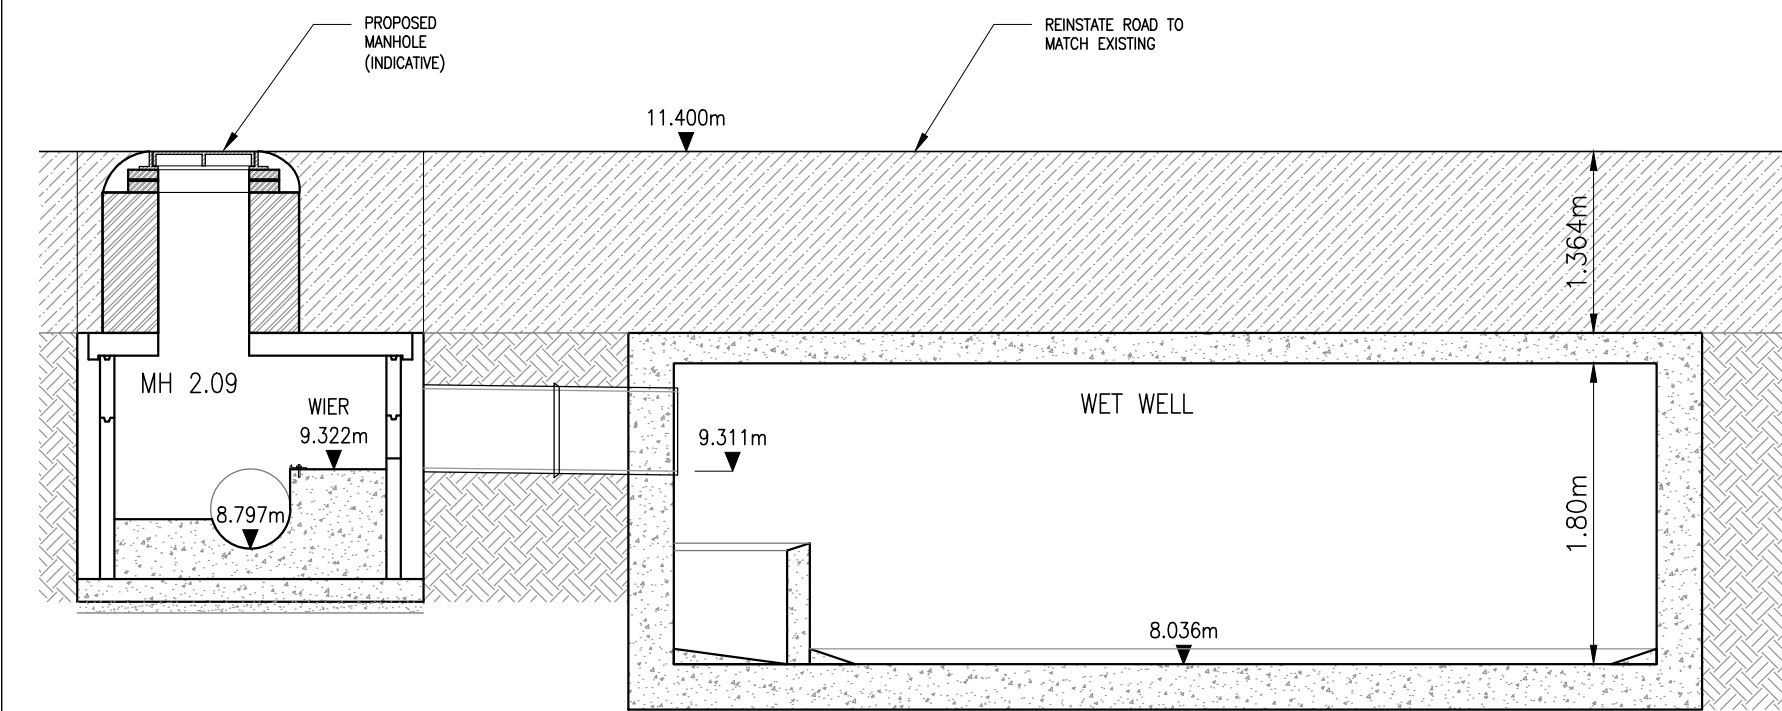


SECTION B-B
(SCALE 1:50)

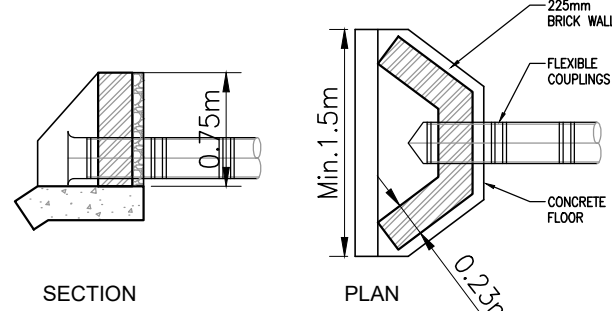

TYPICAL HEADER WALL
(SCALE 1:50)

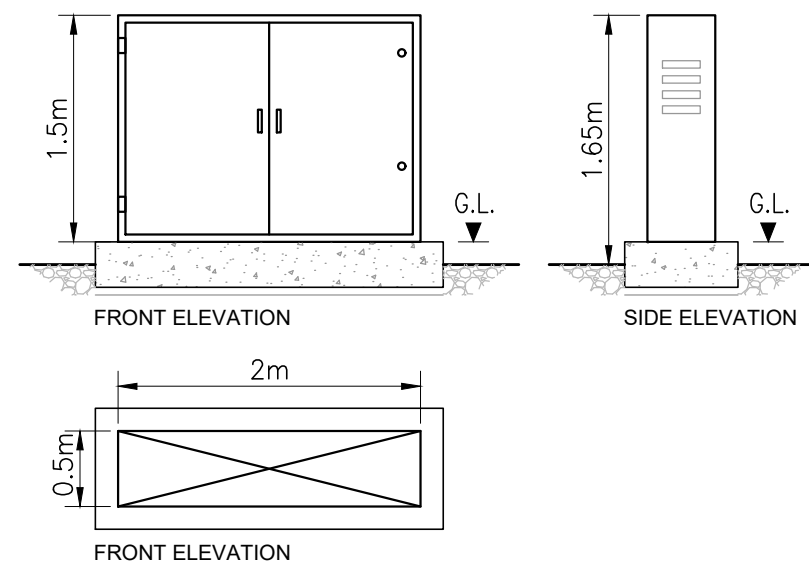

CONTROL KIOSK
(SCALE 1:50)

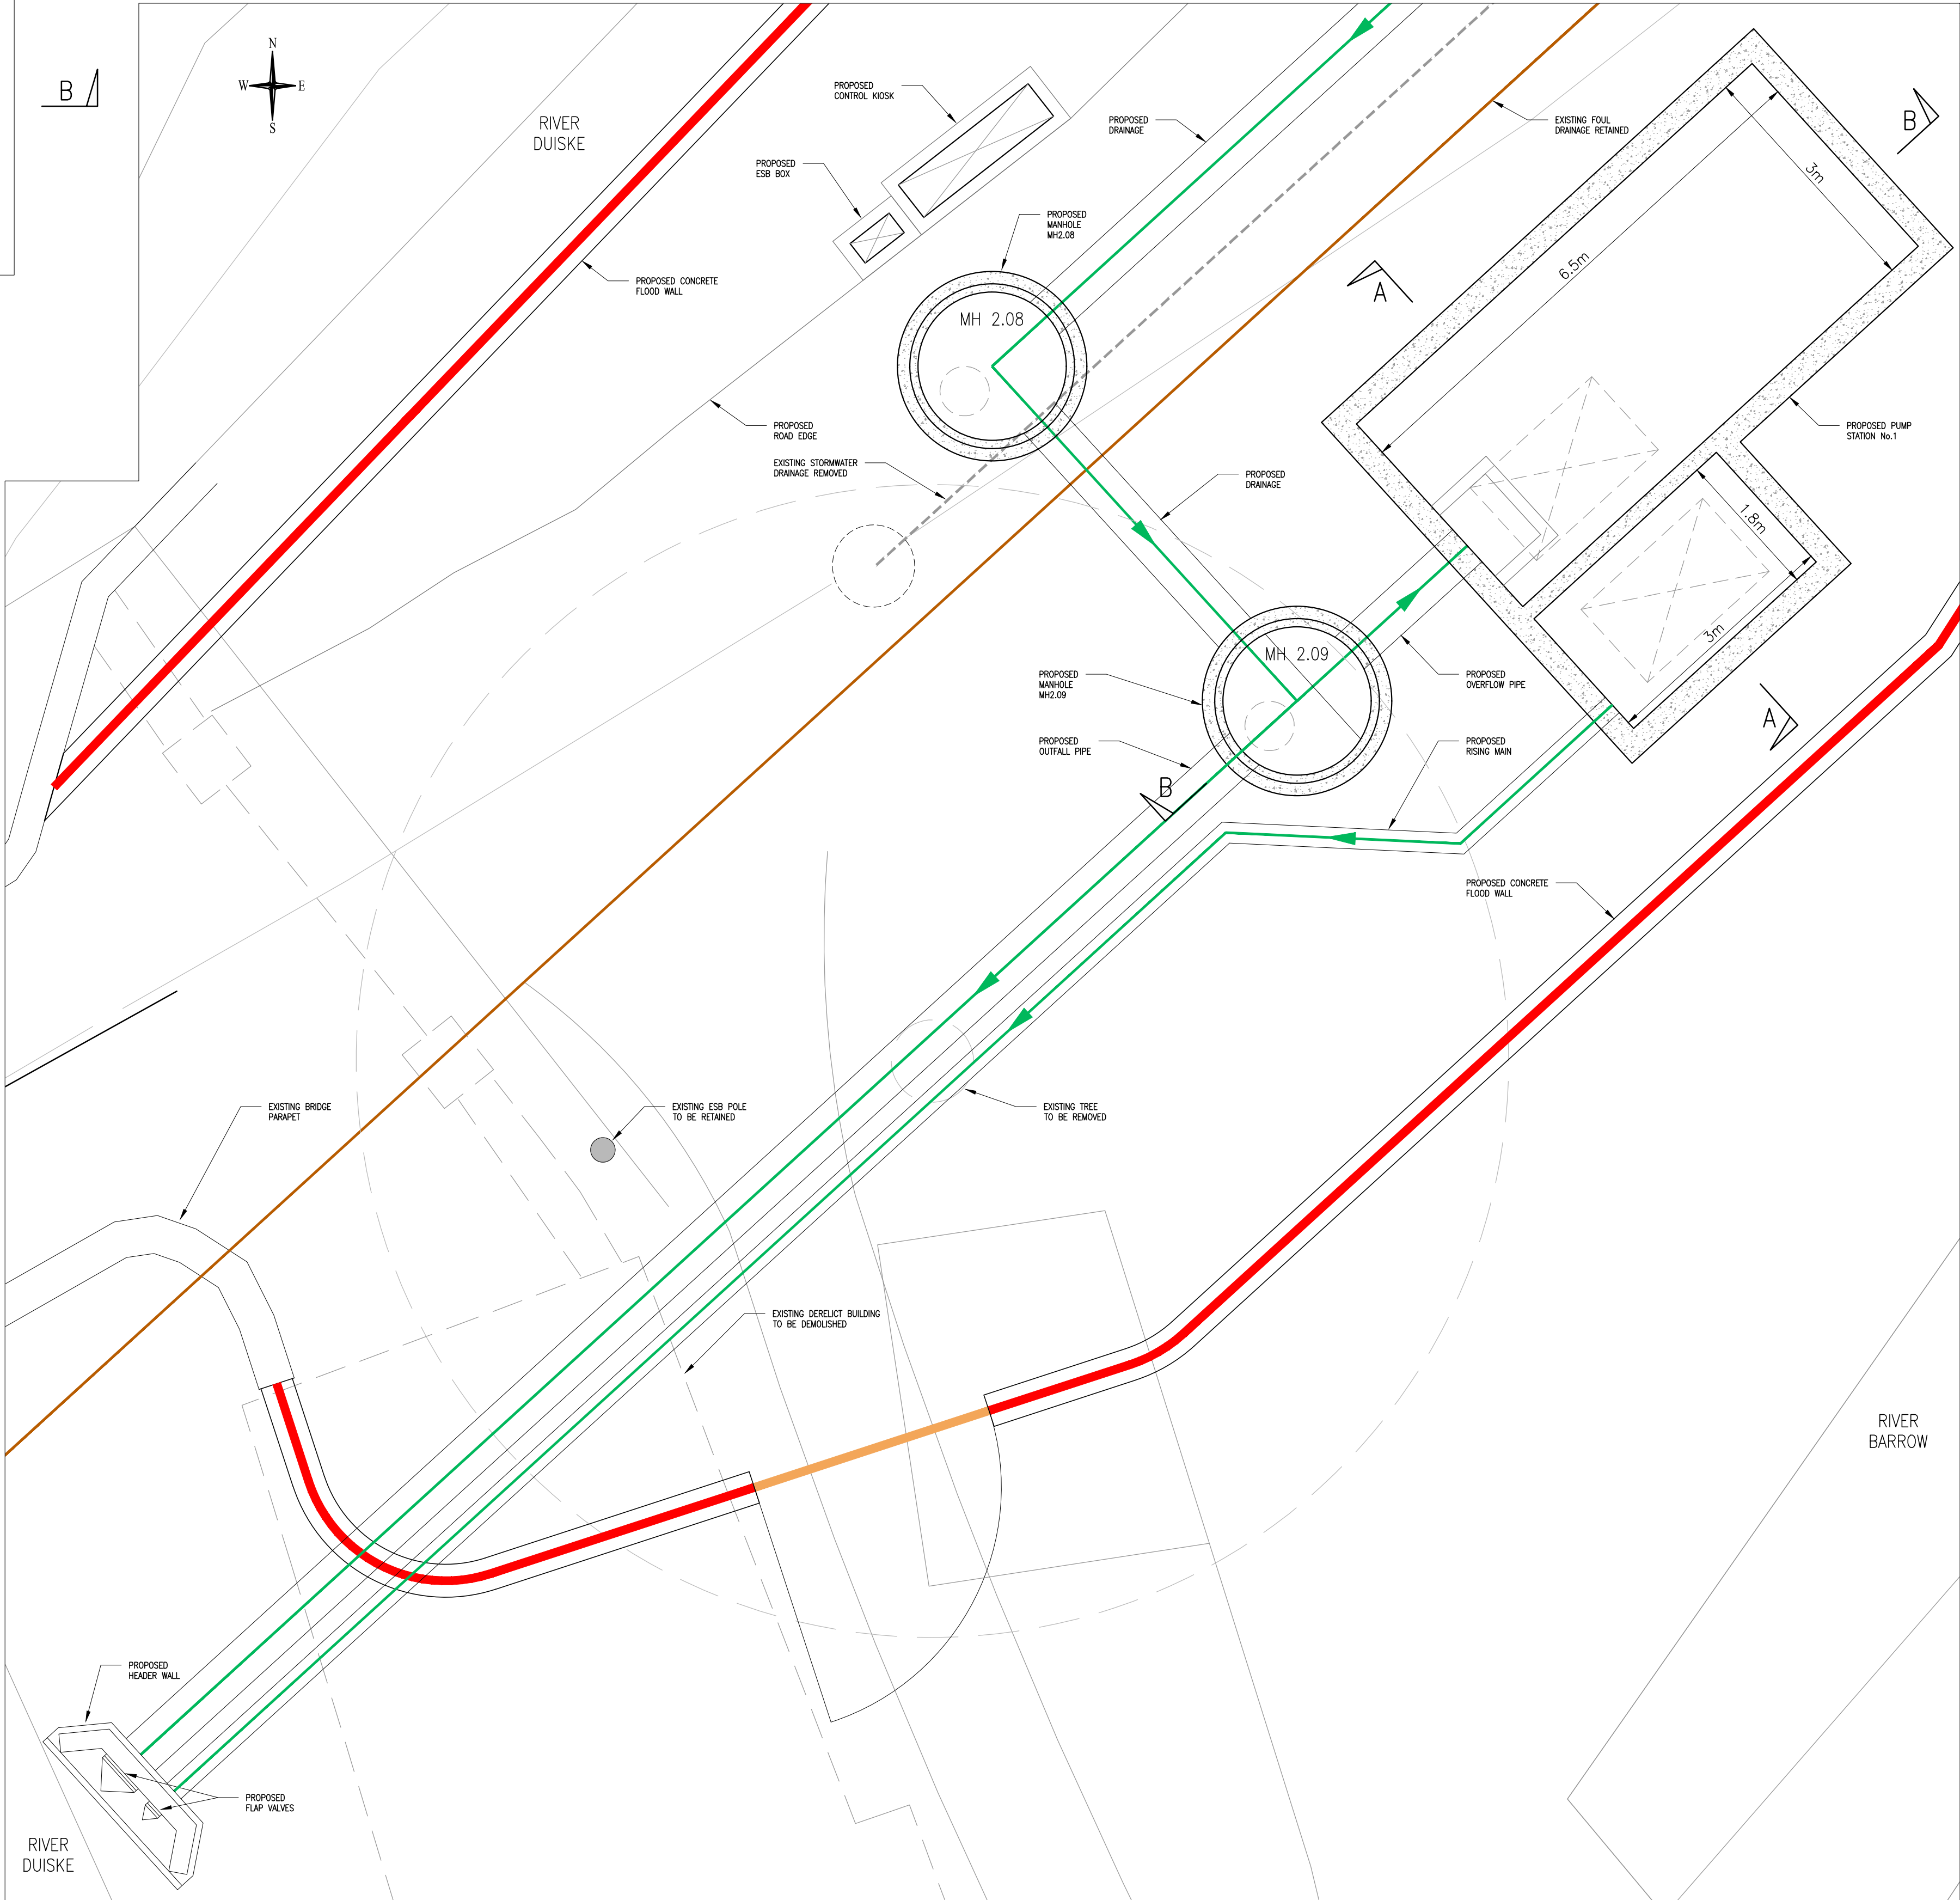

LAYOUT PLAN
SCALE: 1:50


GENERAL NOTES

- NOTES:
1. CIAL50338216 © NATIONAL MAPPING DIVISION OF TAILTE EIREANN.
 2. FIGURED DIMENSIONS ONLY TO BE TAKEN FROM THIS DRAWING.
 3. FOR DETAILS OF FLOOD DEFENCES SEE DWGS W3451-AYE-DWG-W-1404 - W3451-AYE-DWG-W-1422.

LEGEND:

- EXISTING SEWER
EXISTING STORM DRAINAGE
PROPOSED STORM DRAINAGE
PROPOSED FLOOD DEFENCE WALL
PROPOSED FLOOD GATE WITHIN FLOOD DEFENCE WALL

KEYPLAN:

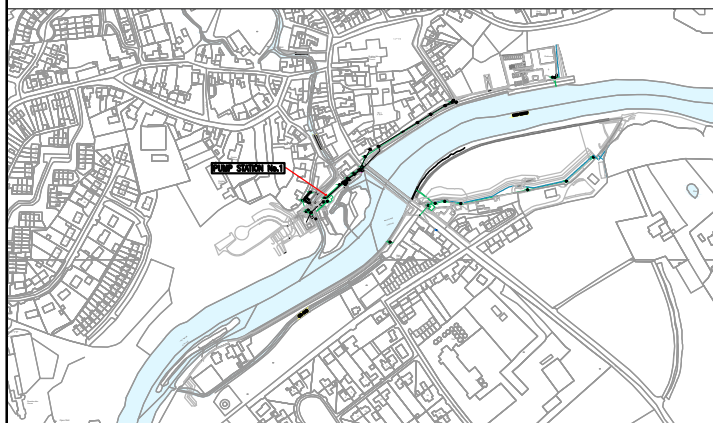

00	31.07.24	ISSUE FOR PLANNING	LT	OL	SH
Rev	Date	Description	By	Chk	App

ayesa

CLIENT
KILKENNY COUNTY COUNCIL

PROJECT
GRAIGUENAMAGH TINNAHINCH
FLOOD RELIEF SCHEME

DRAWING TITLE
STORMWATER DRAINAGE
PUMPING STATION NO.1
GA LAYOUT, PLAN & SECTIONS

STATUS
FOR PLANNING

Date: 31.07.24	Scale: 1:50	Drawn: LT	Chk: SH	App: SH
Project No: W3451	Dwg. No: W3451-AYE-DWG-W-1434	Rev: 00		