



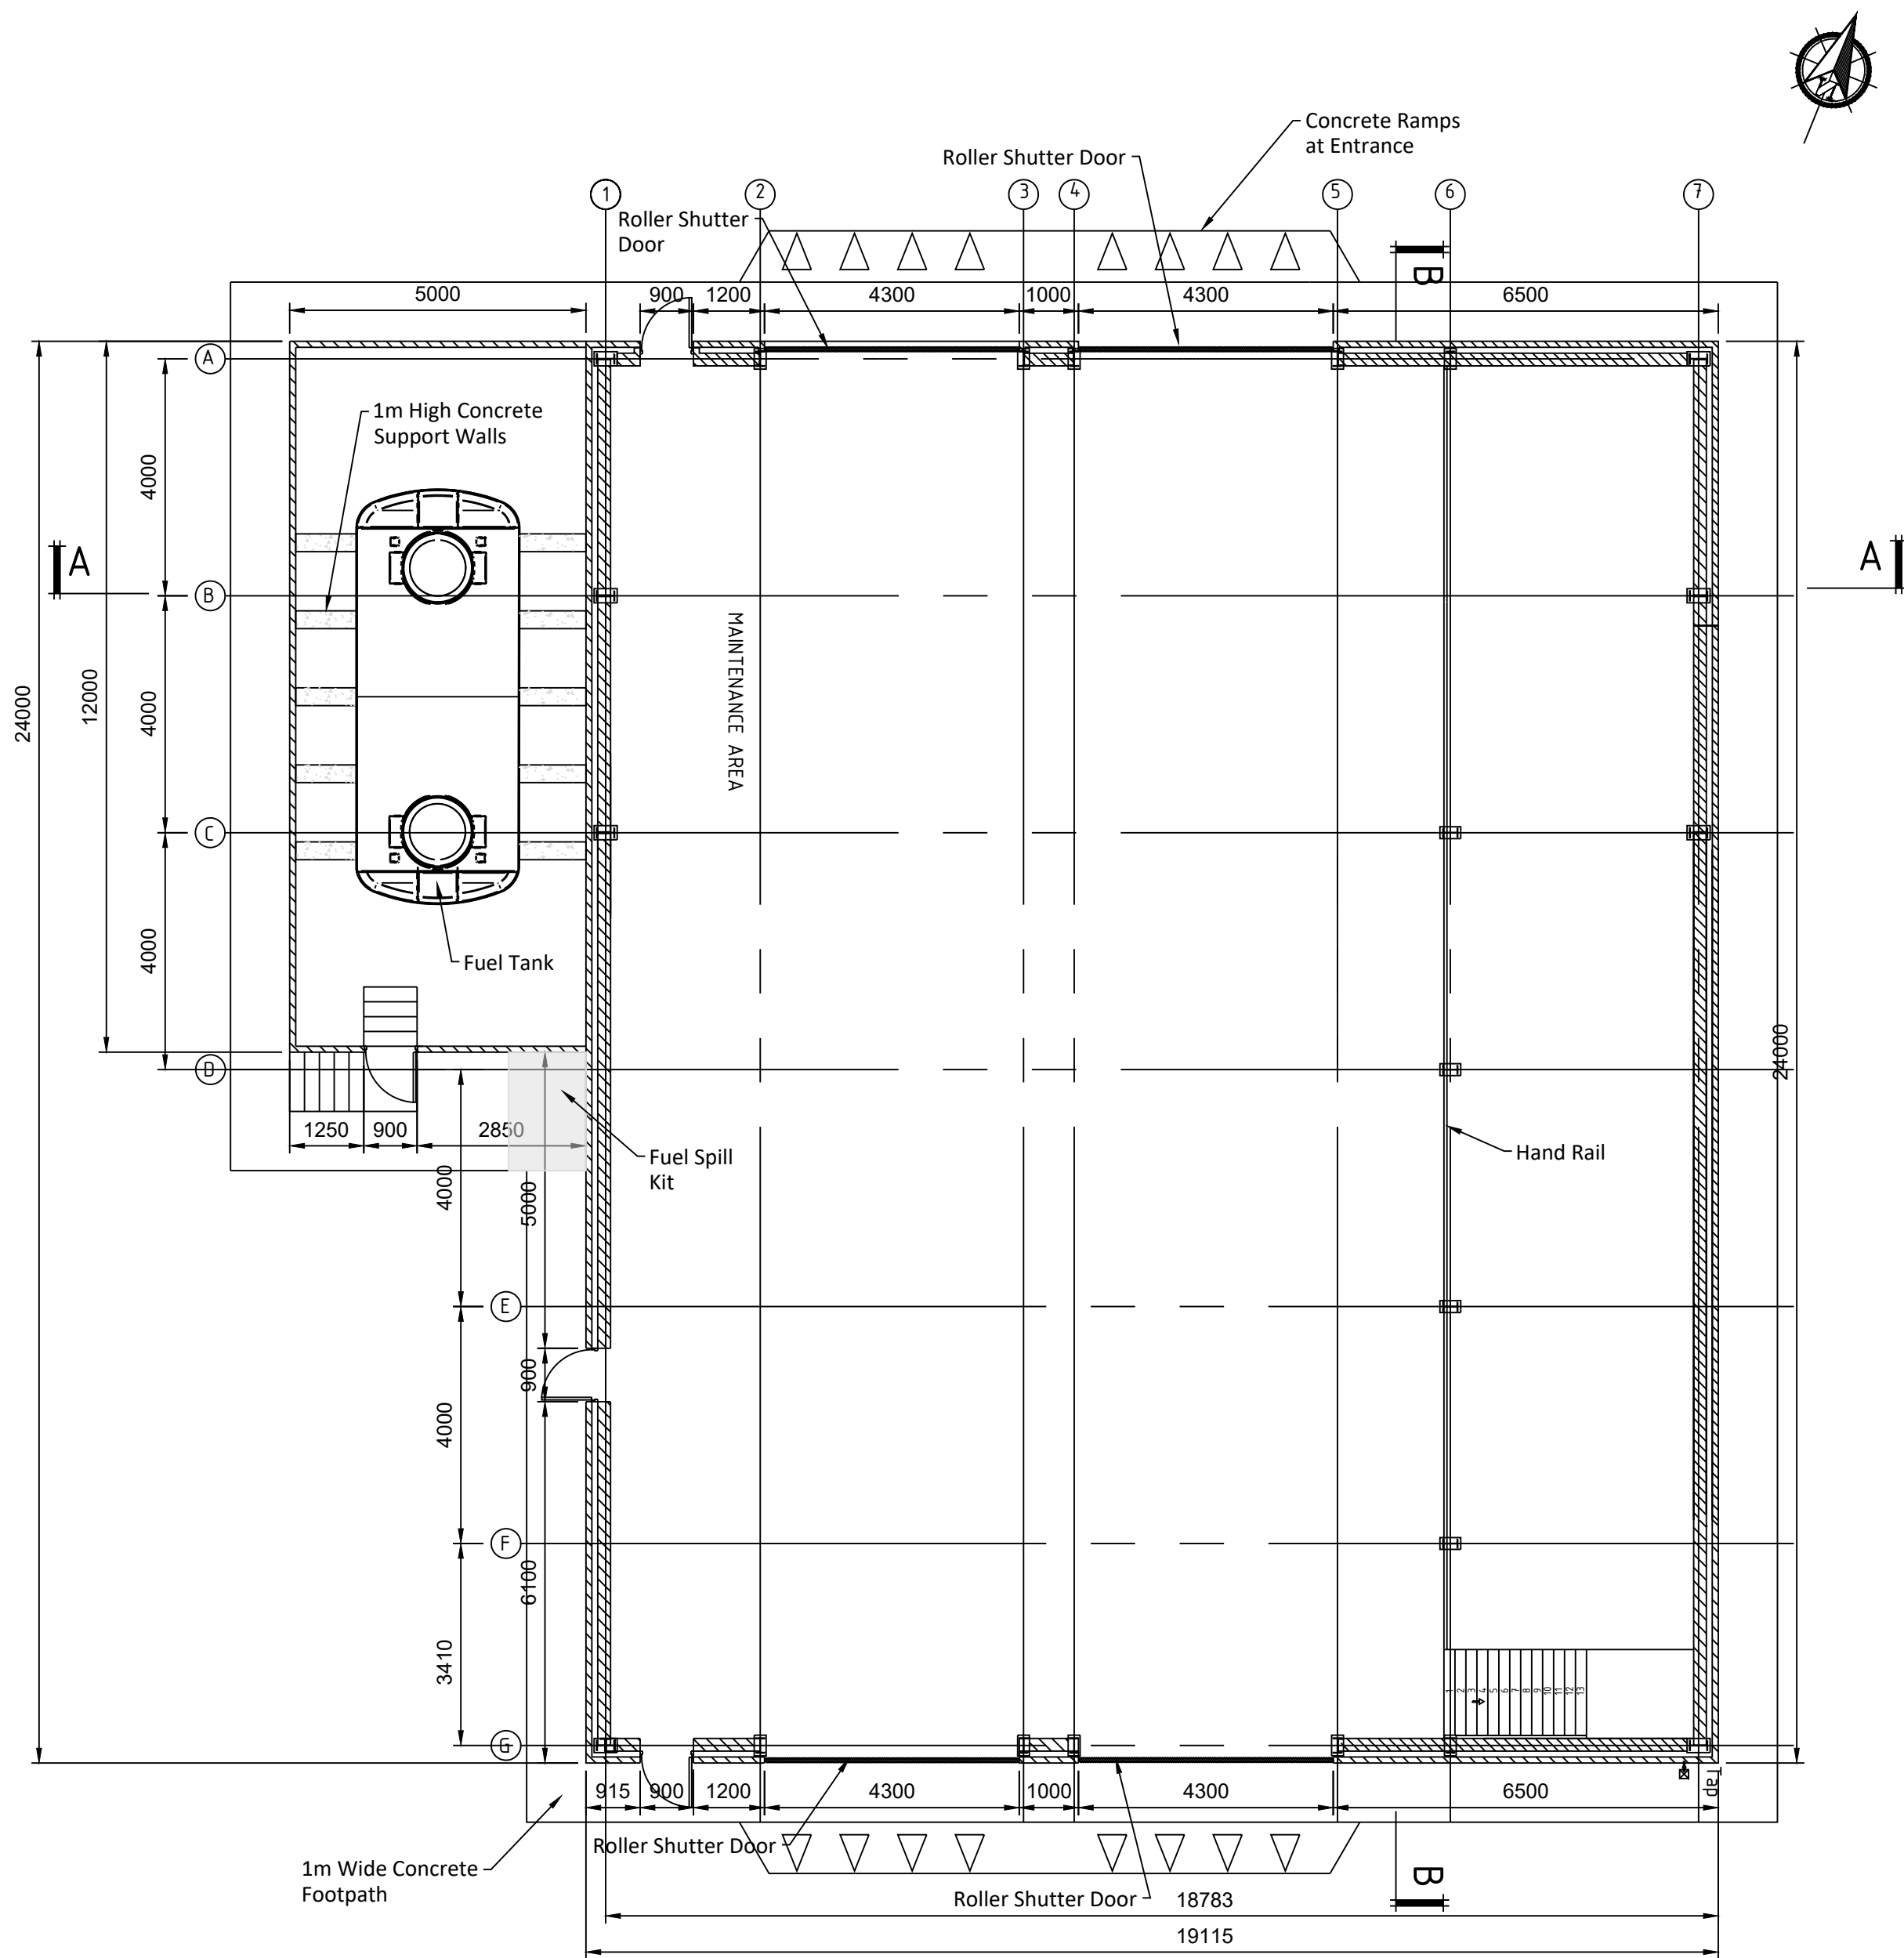


GROUND FLOOR PLAN
Scale 1:100

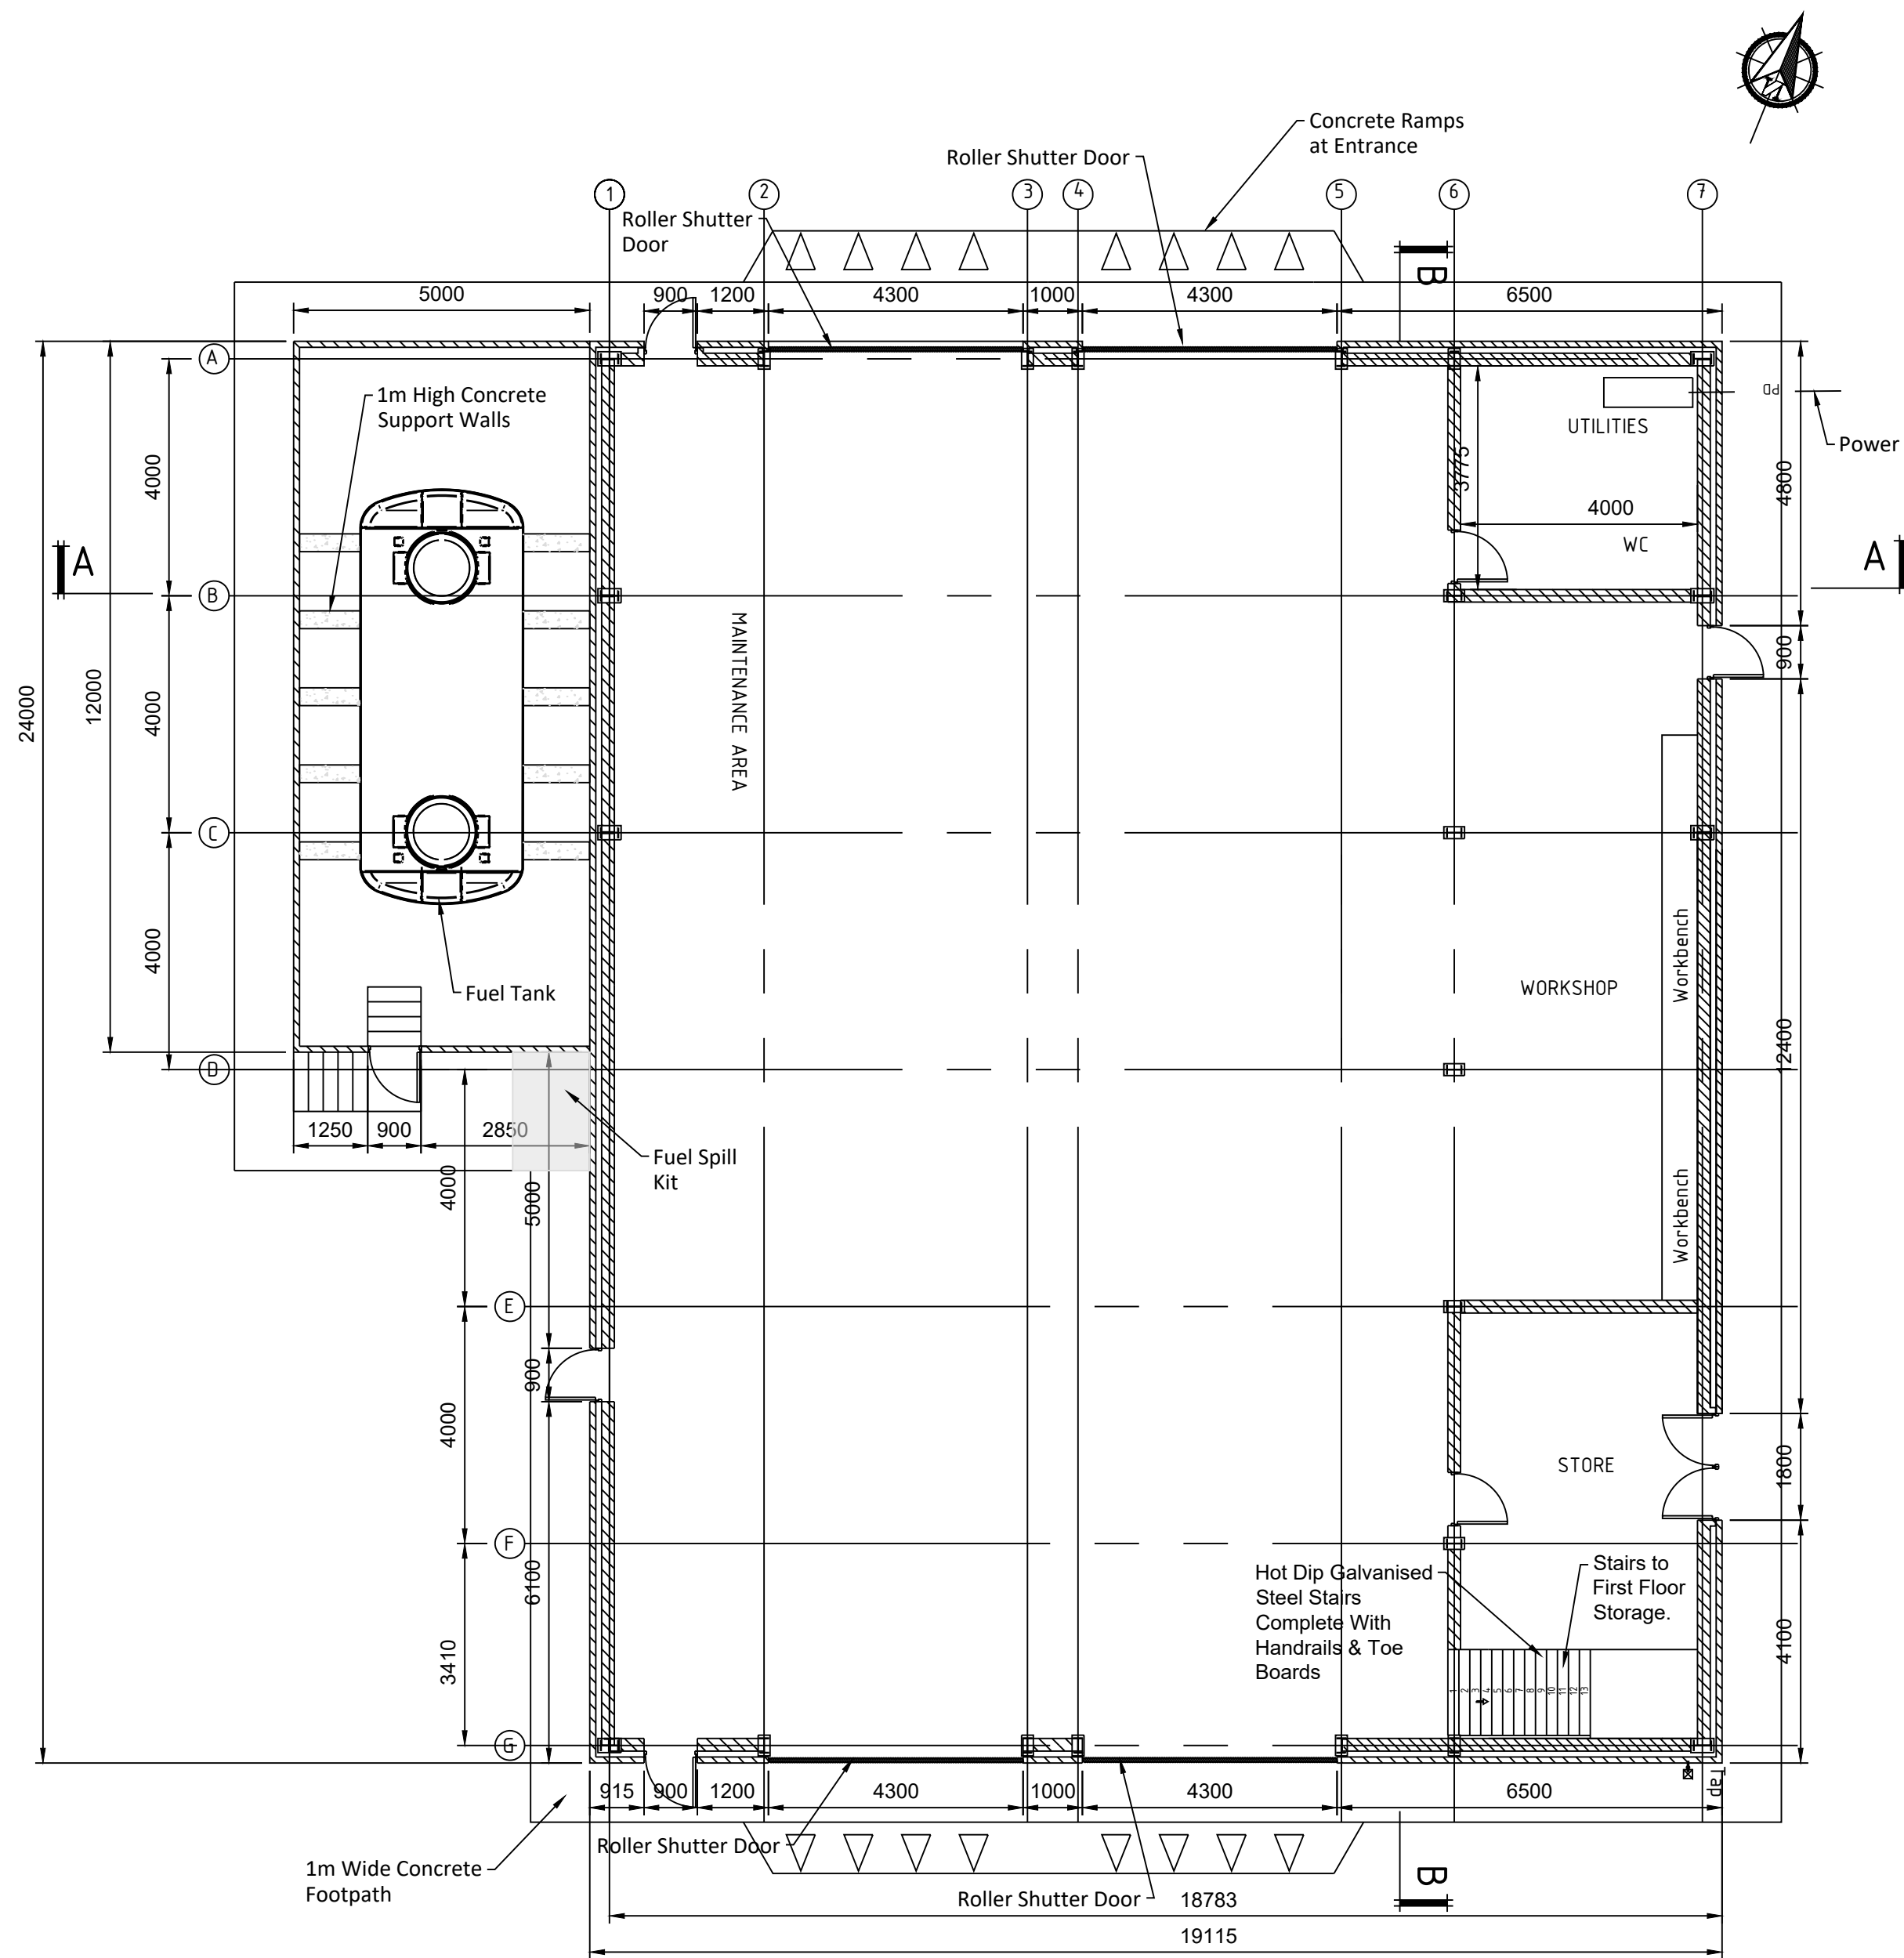

FIRST FLOOR PLAN
Scale 1:100

If Applicable : Ordnance Survey Ireland Licence No. EN 0001220 © Ordnance Survey Ireland and Government of Ireland

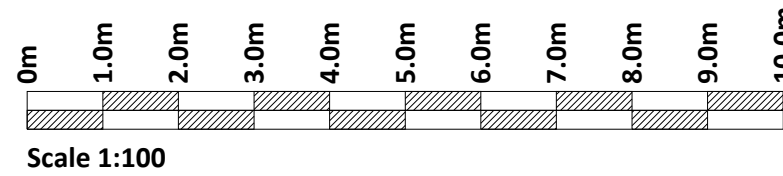

Rev.	Description	App By	Date
A	ISSUE FOR PLANNING	CC	18.05.22
B	ISSUE FOR PLANNING	CC	22.11.23

PROJECT	CLIENT		
SID APPLICATION, EIAR & IE LICENCE APPLICATION FOR THORNTONS CAPPAGH	THORNTONS RECYCLING		
SHEET	WORKSHOP & FUEL REFILLING FACILITY GROUND & FIRST FLOOR PLANS	Date 18.05.22	Project number P21-150
		Drawn by CS	Drawing Number P21-150-0307-0001
		Checked by FC	Rev B