




APPENDIX 2

UPDATE TO PLANNING DRAWINGS




Schedule of Planning Drawings

Drawing No.	Drawing Title	Scale	Page Size
180740 – 01 FI	Location Context Map	1: 50,000	A3
180740 – 03 FI	Site Layout Key Plan (1:5,000)	1: 5,000	A3
180740 – 04 FI	Site Layout Sheet 1 of 3	1: 5,000	A1
180740 – 05 FI	Site Layout Sheet 2 of 3	1: 5,000	A1
180740 – 07 FI	Site Layout Key Plan (1:2,500)	1: 2,500	A3
180740 – 08 FI	Site Layout Sheet 1 of 8	1: 2,500	A1
180740 – 09 FI	Site Layout Sheet 2 of 8	1: 2,500	A1
180740 – 10 FI	Site Layout Sheet 3 of 8	1: 2,500	A1
180740 – 12 FI	Site Layout Sheet 5 of 8	1: 2,500	A1
180740 – 13 FI	Site Layout Sheet 6 of 8	1: 2,500	A1
180740 – 16 FI	Turbine 1 Layout	1:500	A3
180740 – 17 FI	Turbine 2 Layout	1:500	A3
180740 – 18 FI	Turbine 3 Layout	1:500	A3
180740 – 19 FI	Turbine 4 Layout	1:500	A3
180740 – 20 FI	Turbine 5 Layout	1:500	A3
180740 – 21 FI	Turbine 6 Layout	1:500	A3
180740 – 31 FI	Temporary Construction Compound 1	1:500	A3
180740 – 33 FI	Peatland Enhancement Area	1: 2,500	A3
180740 – 48 FI	Junction A Boundary Treatment Plan	1:500	A2
Hydro Environmental Services Ltd.			
P1508-2-1125-A3-FI-101-00A	Local Road L-22321 and Bridge-1 Cross Sections Sheet 1/4	As Shown (A3)	A3
P1508-2-1125-A3-FI-102-00A	Local Road L-22321 and Bridge-2 Cross Sections Sheet 2/4	As Shown (A3)	A3
P1508-2-1125-A3-FI-103-00A	Existing Road Proposed to be Upgraded Cross Sections Sheet 3/4	As Shown (A3)	A3
P1508-2-1125-A3-FI-104-00A	Proposed Spoil Storage Areas Cross Sections Sheet 4/4	As Shown (A3)	A3

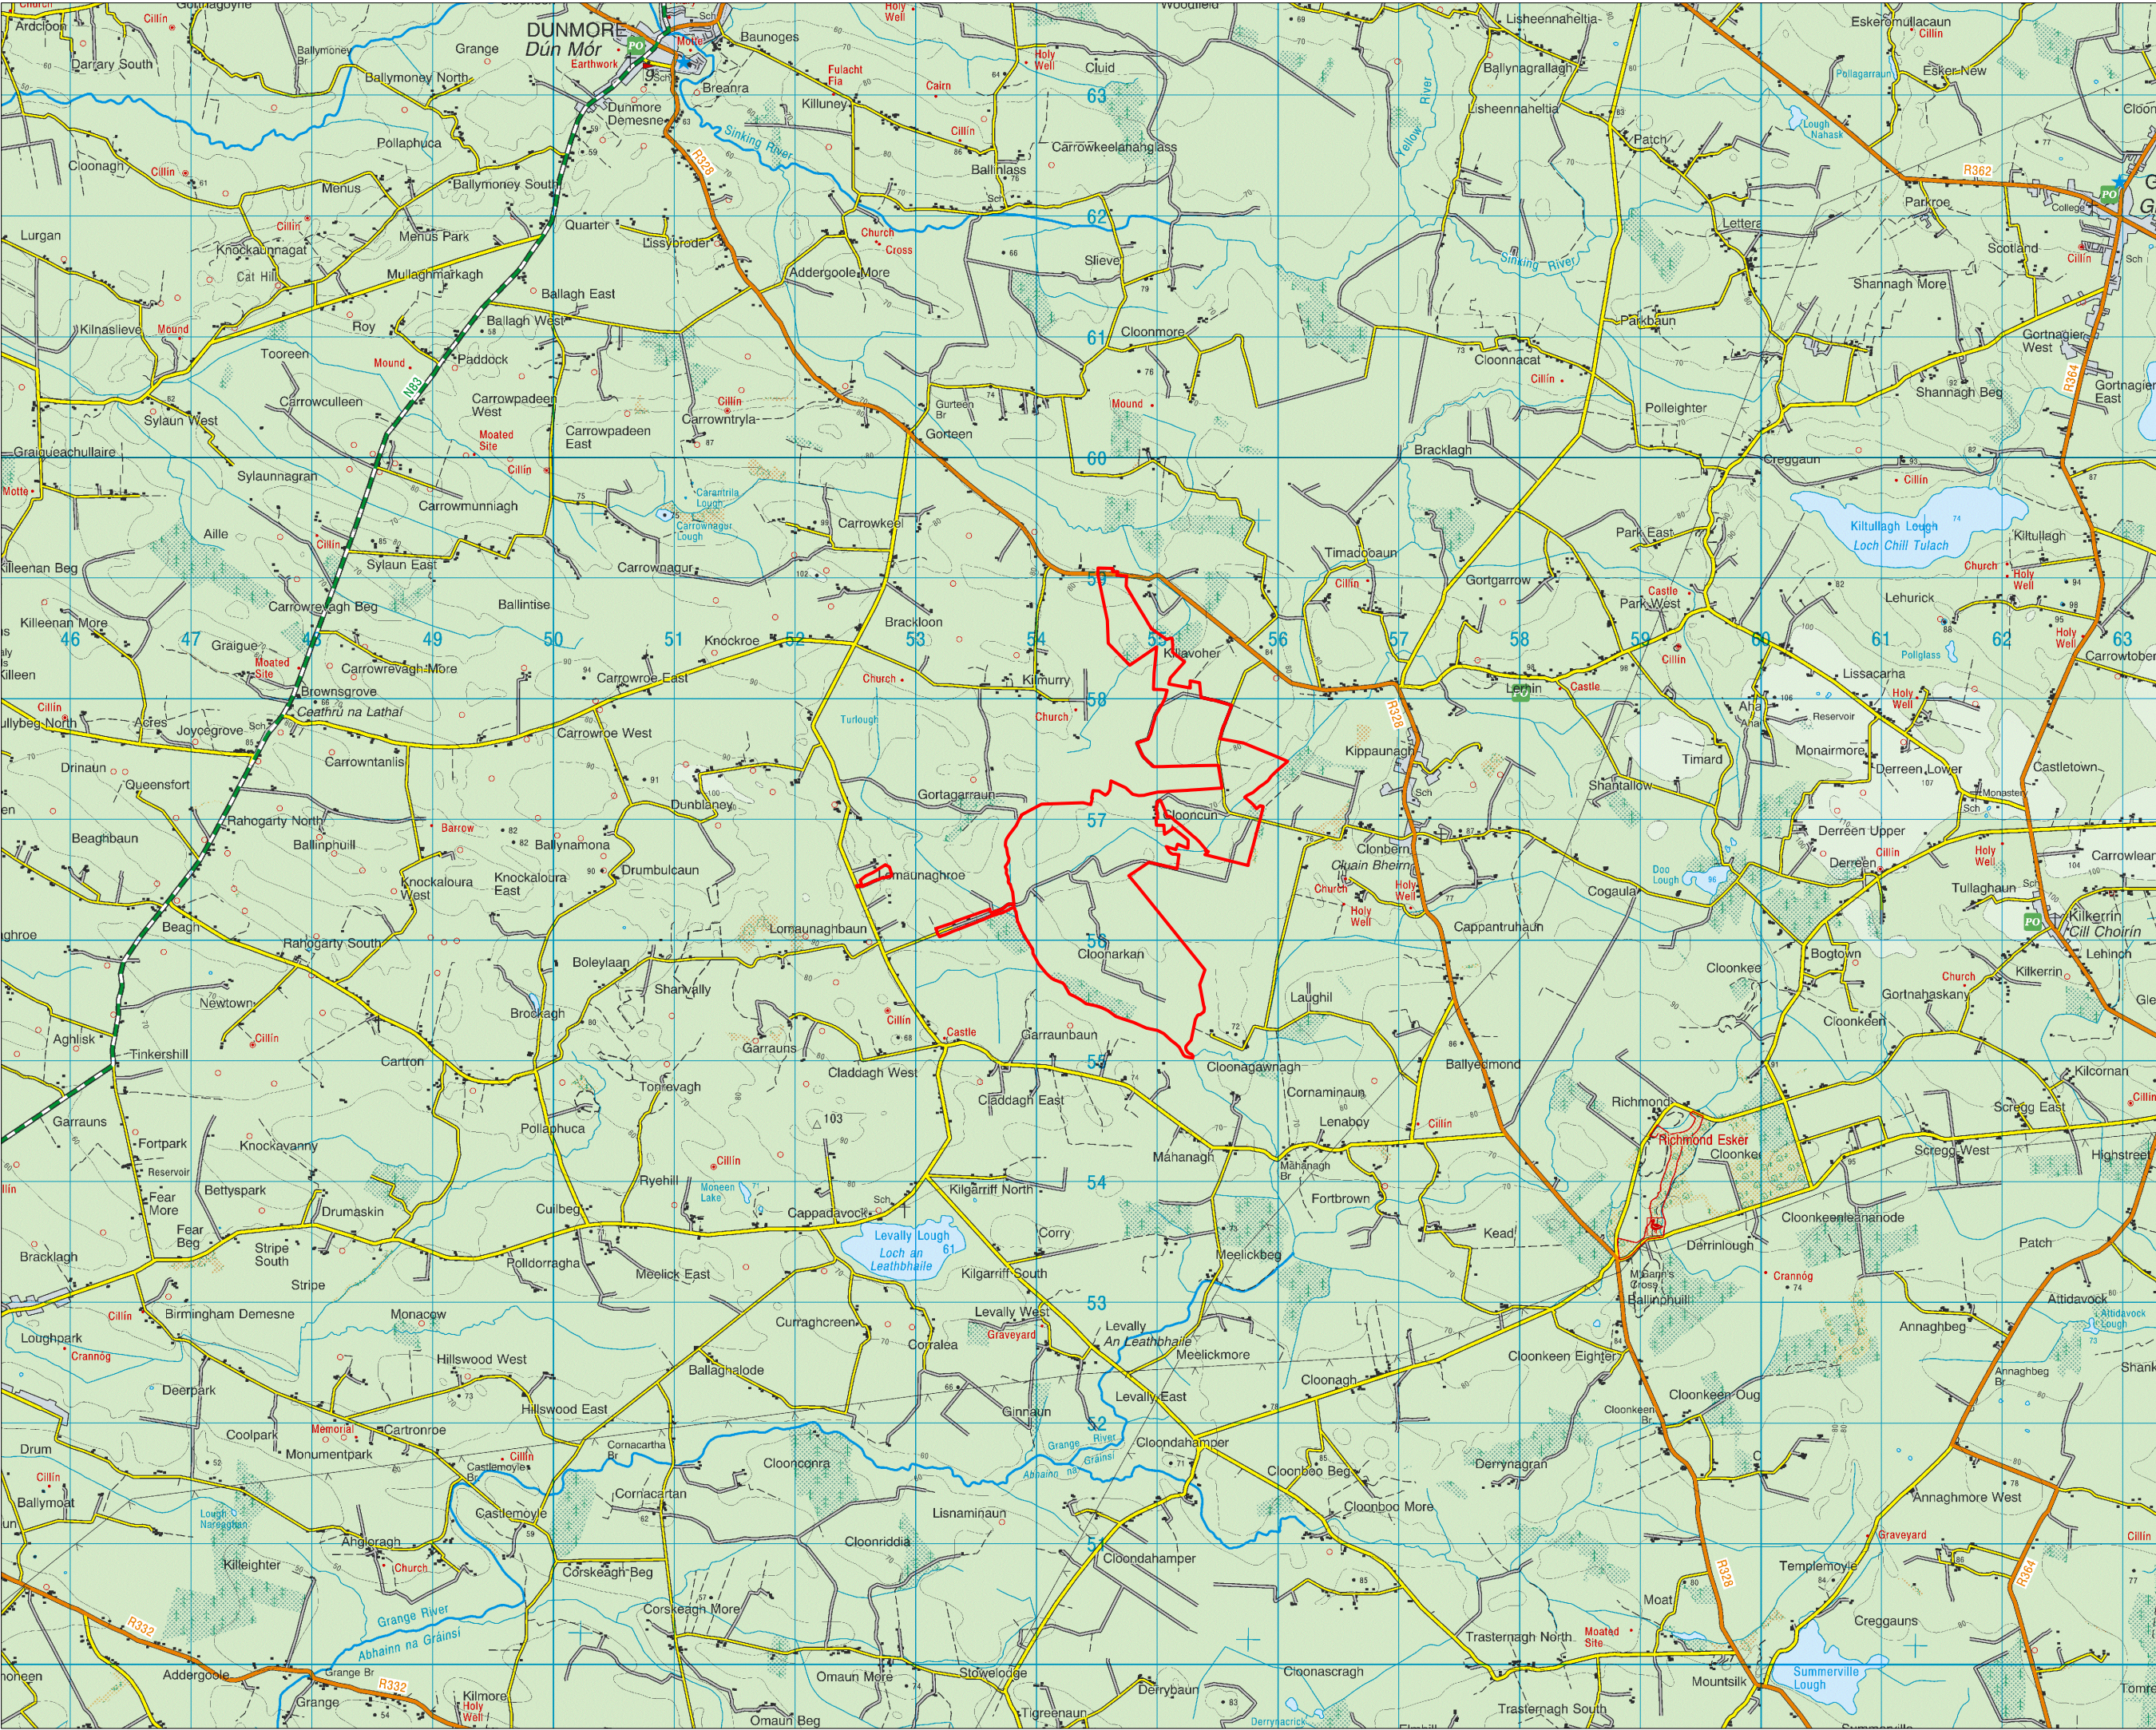

Project Design Drawing Notes

1. Drawings issued are for planning application purposes only.
2. Drawings not to be used for construction/contract conditions.
3. Copyright, all rights reserved. No part herewith may be copied or reproduced partially or wholly in any form whatsoever without the prior notice of the copyright owner McCarthy Keville O'Sullivan.
4. Do not scale off this drawing. Figured metric dimensions only should be taken off this drawing.
5. All contractors, whether main or sub-contractors, must visit the site and are responsible for taking and checking any and all dimensions and levels that relate to the works.
6. The use of or reliance upon this drawing shall be deemed to be acceptance of these conditions of use unless otherwise agreed in writing, such written agreement to be sought from and issued by the copyright holder to the use or reliance upon this drawing.
7. Layout plans show Turbine rotor diameter as per turbine drawing.
8. Final levels may vary depending on local ground conditions.

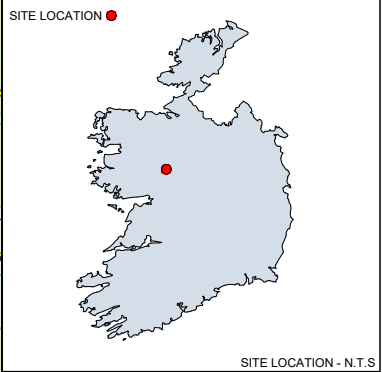

Drawing Legend

— Planning Application Boundary




Location Context Map

PROJECT TITLE:
Clonberne Wind Farm Fl, Co. Galway

DRAWING BY: JOB	CHECKED BY: AC
PROJECT No.: 180740	DRAWING No.: 180740 - 01FI
SCALE: 1:50,000 @ A3	DATE: 02.12.2025
OS SHEET No.: OS1424, OS1426, OS1624, OS1626	

MKO
Planning and Environmental Consultants
Tuum Road, Galway
Ireland, H91 VW84
+353 (0) 91 735611
email: info@www.mkofireland.ie
Website: www.mkofireland.ie

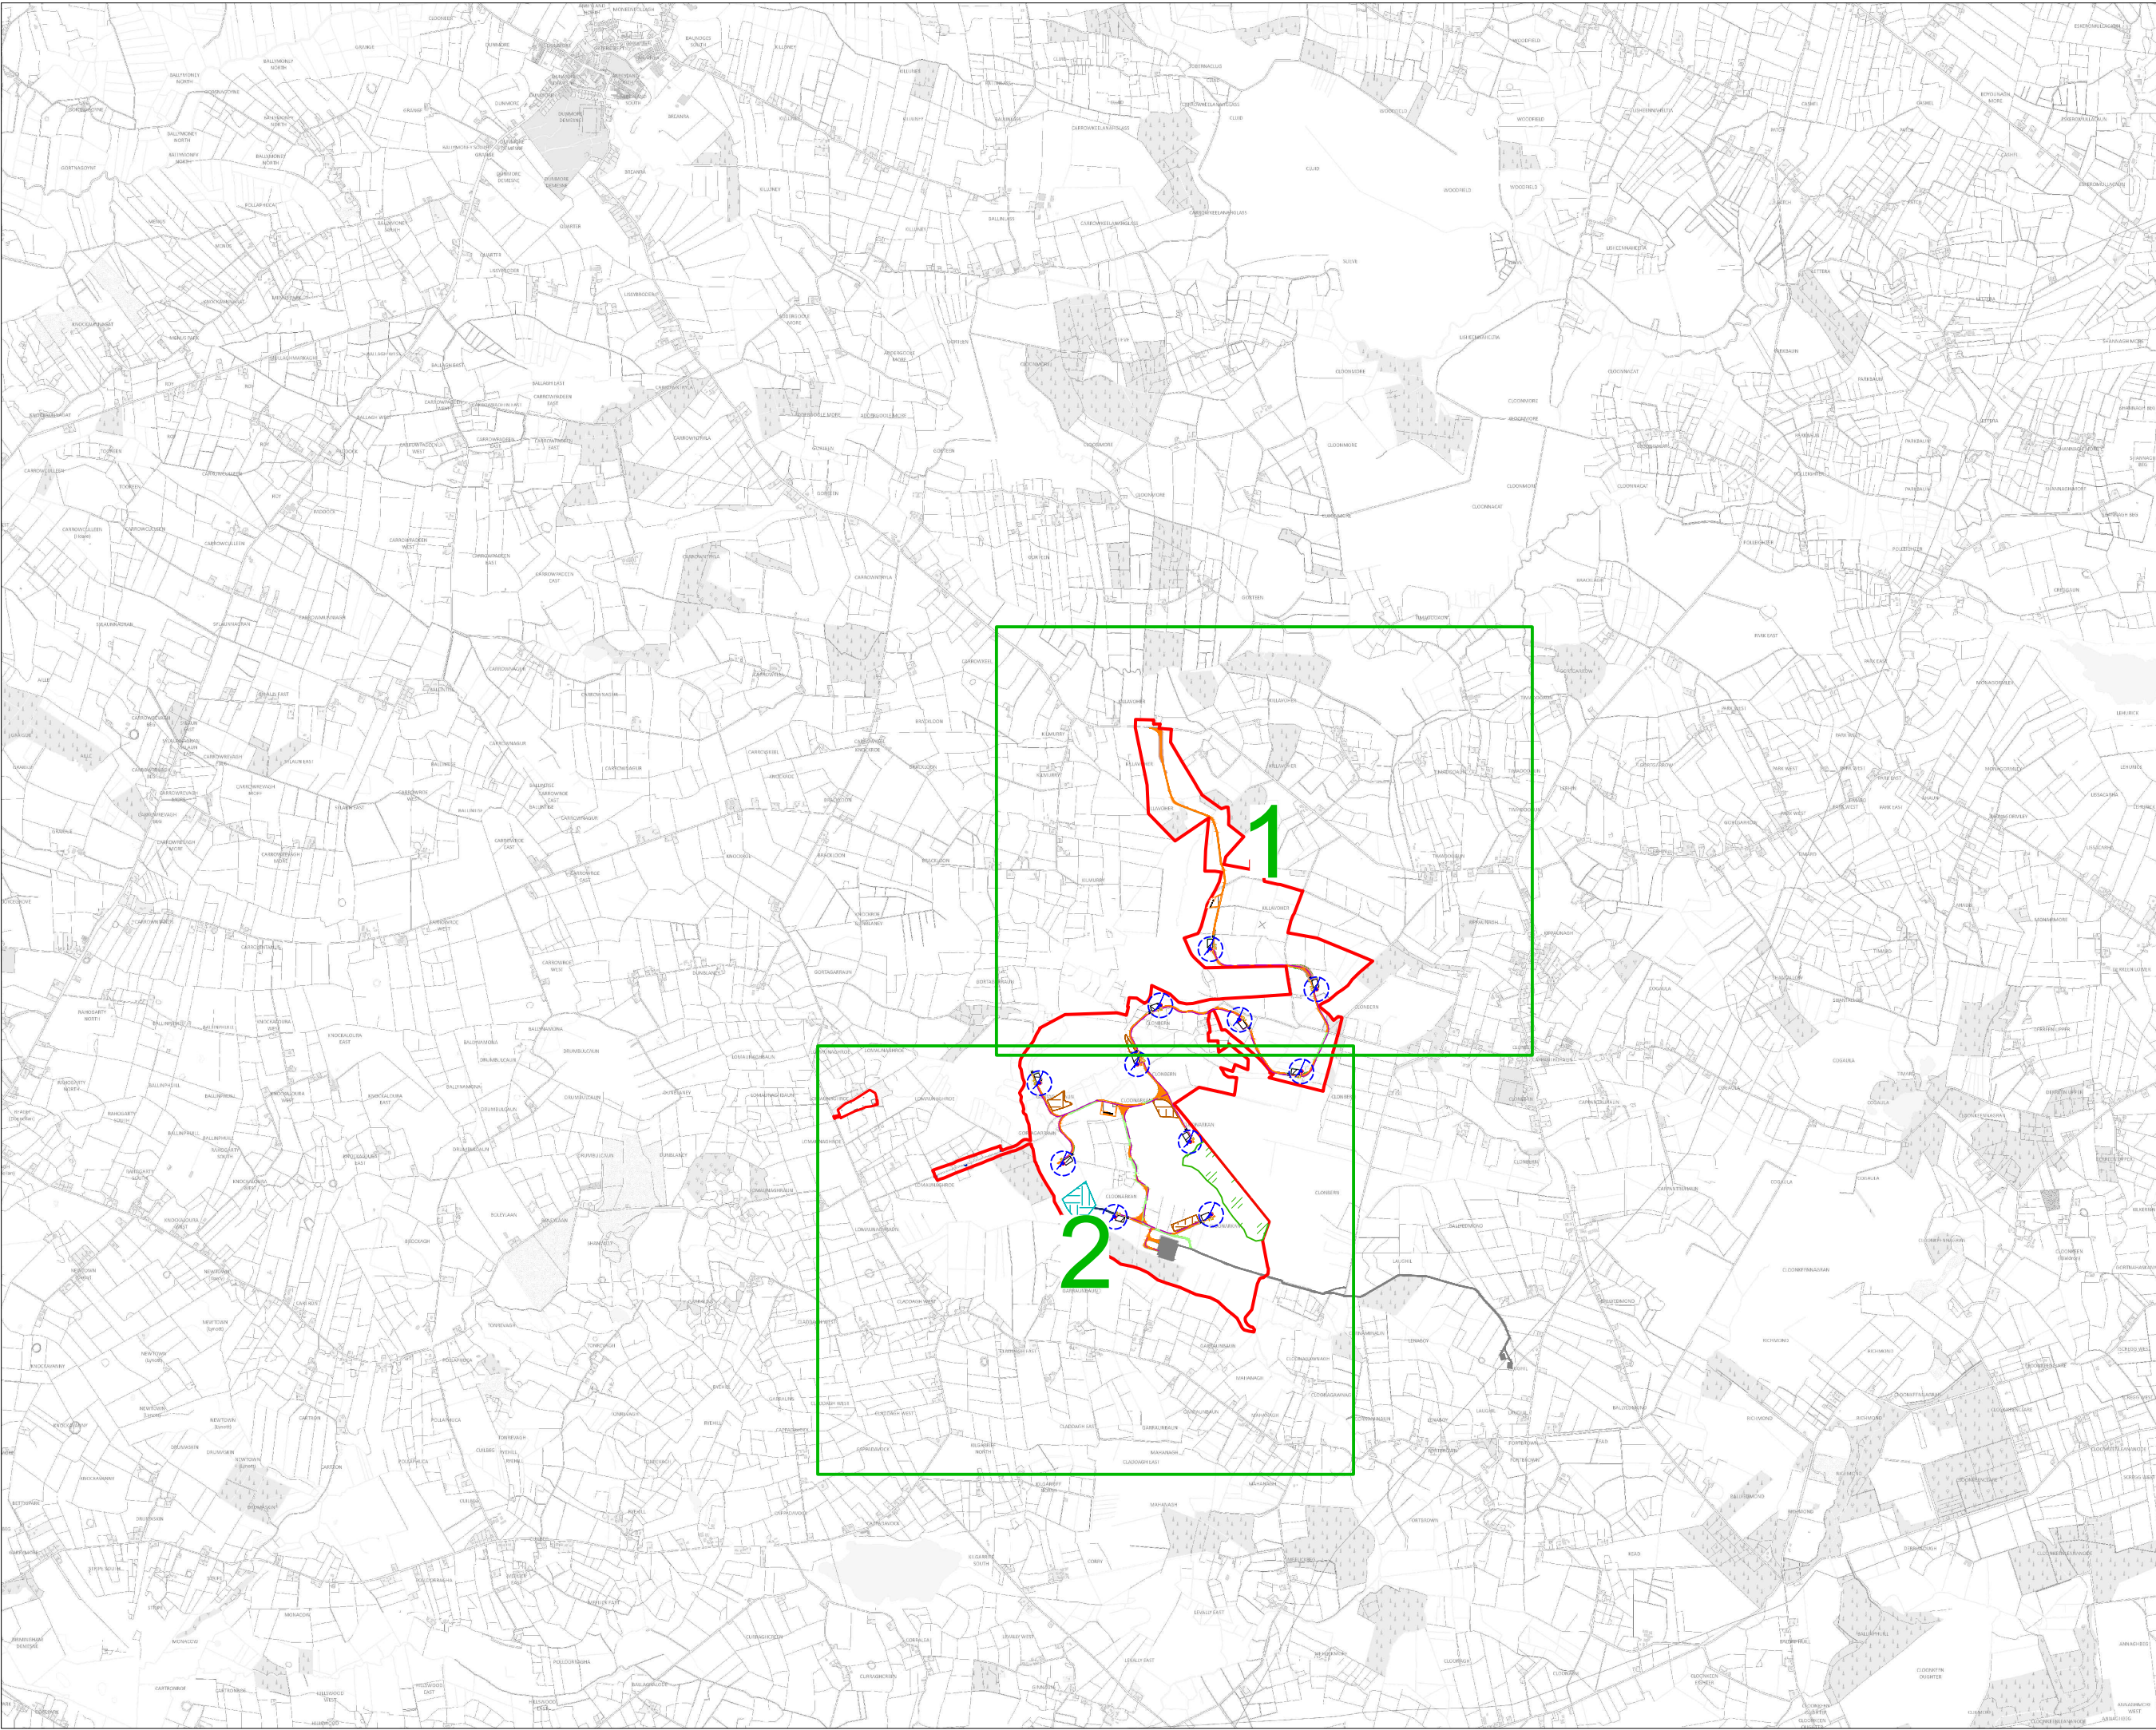

Project Design Drawing Notes

1. Drawings issued are for planning application purposes only.
2. Drawings not to be used for construction/contract conditions.
3. Copyright, all rights reserved. No part herewith may be copied or reproduced partially or wholly in any form whatsoever without the prior notice of the copyright owner McCarthy Keville O'Sullivan.
4. Do not scale off this drawing. Figured metric dimensions only should be taken off this drawing.
5. All contractors, whether main or sub-contractors, must visit the site and are responsible for taking and checking any and all dimensions and levels that relate to the works.
6. The use of or reliance upon this drawing shall be deemed to be acceptance of these conditions of use unless otherwise agreed in writing, such written agreement to be sought from and issued by the copyright holder to the use or reliance upon this drawing.
7. Layout plans show Turbine rotor diameter as per turbine drawing.
8. Final levels may vary depending on local ground conditions.

Drawing Legend

- Planning Application Boundary
- Existing Road to be Upgraded
- Proposed Road
- Temporary Access Road
- Temporary New Road (to facilitate delivery of abnormal loads)
- Passing Bay
- Electrical Cable Trench
- Soft Levelled Area
- Crane Pad Hardstanding Area
- Turbine Foundation
- Turbine Sweep Area
- Borrow Pit
- Peat Repository Area
- Spoil Repository Area
- Peatland Enhancement Area
- Area Part of Separate Application
- Cut
- Fill




**Site Layout Key Plan
(1:5,000)**

PROJECT TITLE:
Clonberne Wind Farm FI, Co. Galway

DRAWING BY: JOB	CHECKED BY: AC
PROJECT No.: 180740	DRAWING No.: 180740 - 03FI
SCALE: 1:5,000 @ A3	DATE: 02.12.2025




MKO
Planning and
Environmental
Consultants
Tuam Road, Galway
Ireland, H91 VW84
+353 (0) 91 735611
email: info@www.mkoireland.ie
Website: www.mkoireland.ie

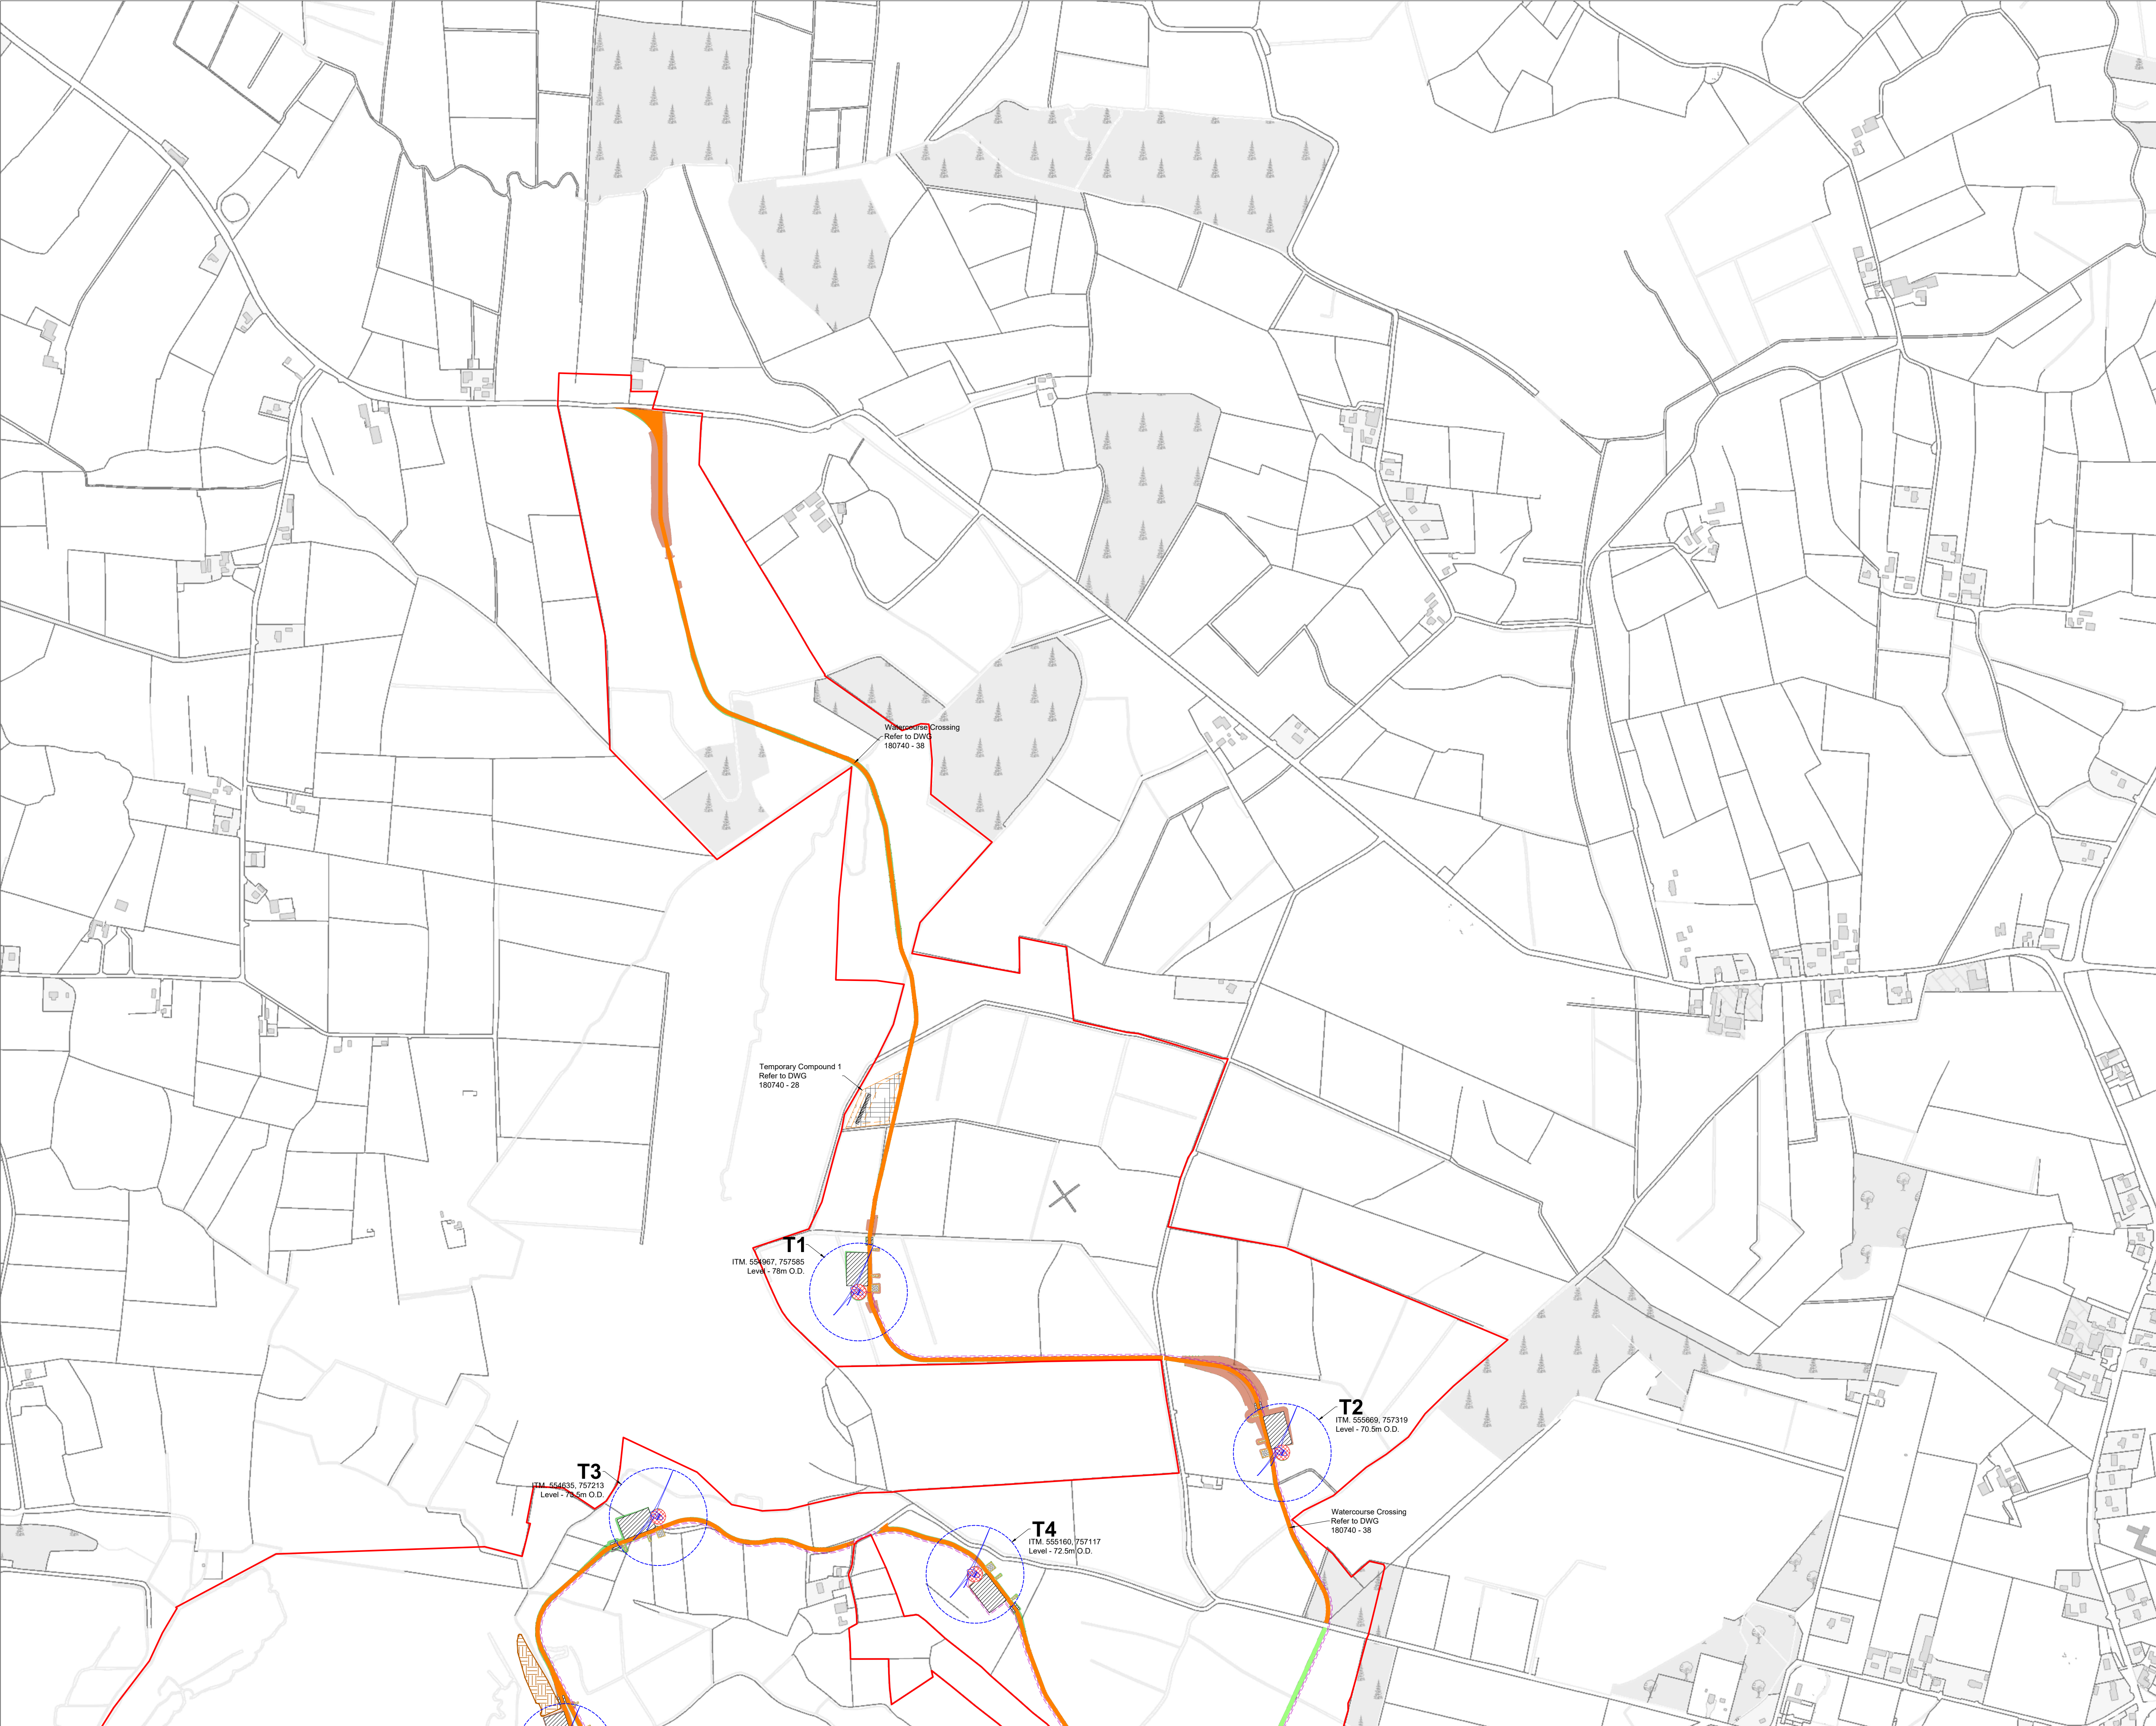

- Project Design Drawing Notes**
1. Drawings issued are for planning application purposes only.
 2. Drawings not to be used for construction/contract conditions.
 3. Copyright, all rights reserved. No part herewith may be copied or reproduced partially or wholly in any form whatsoever without the prior notice of the copyright owner McCarthy Keville O'Sullivan.
 4. Do not scale off this drawing. Figured metric dimensions only should be taken off this drawing.
 5. All contractors, whether main or sub-contractors, must visit the site and are responsible for taking and checking any and all dimensions and levels that relate to the works.
 6. The use of or reliance upon this drawing shall be deemed to be acceptance of these conditions of use unless otherwise agreed in writing, such written agreement to be sought from and issued by the copyright holder to the use or reliance upon this drawing.
 7. Layout plans show Turbine rotor diameter as per turbine drawing.
 8. Final levels may vary depending on local ground conditions.

Drawing Legend

- Planning Application Boundary
- Existing Road to be Upgraded
- Proposed Road
- Electrical Cable Trench
- Crane Pad Hardstanding Area
- Turbine Foundation
- Turbine Sweep Area
- Peat Repository Area
- Area Part of Separate Application
- Cut
- Fill

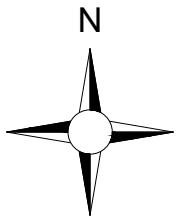

Ordnance Survey Ireland Licence No. CYAL50267517© Ordnance Survey Ireland/Government of Ireland


DRAWING TITLE:
**Site Layout Plan
Sheet 1 of 3**

PROJECT TITLE:
Clonberne Wind Farm FI, Co. Galway

DRAWING BY: JOB	CHECKED BY: AC
PROJECT No.: 180740	DRAWING No.: 180740 - 04FI
SCALE: 1:5,000 @ A1	DATE: 02.12.2025

OS SHEET No.: 2541, 2542, 2543, 2544, 2607, 2608, 2609, 2610, 2611, 2677, 2678, 2679, 2680, 2681, 2746, 2747, 2748, 2749, 2750, 2814, 2815, 2816, 2817, 2818


MKO
Planning and
Environmental
Consultants
Tuam Road, Galway
Ireland, H91 YW84
+353 (0) 91 735611
email: info@www.mkoireland.ie
Website: www.mkoireland.ie

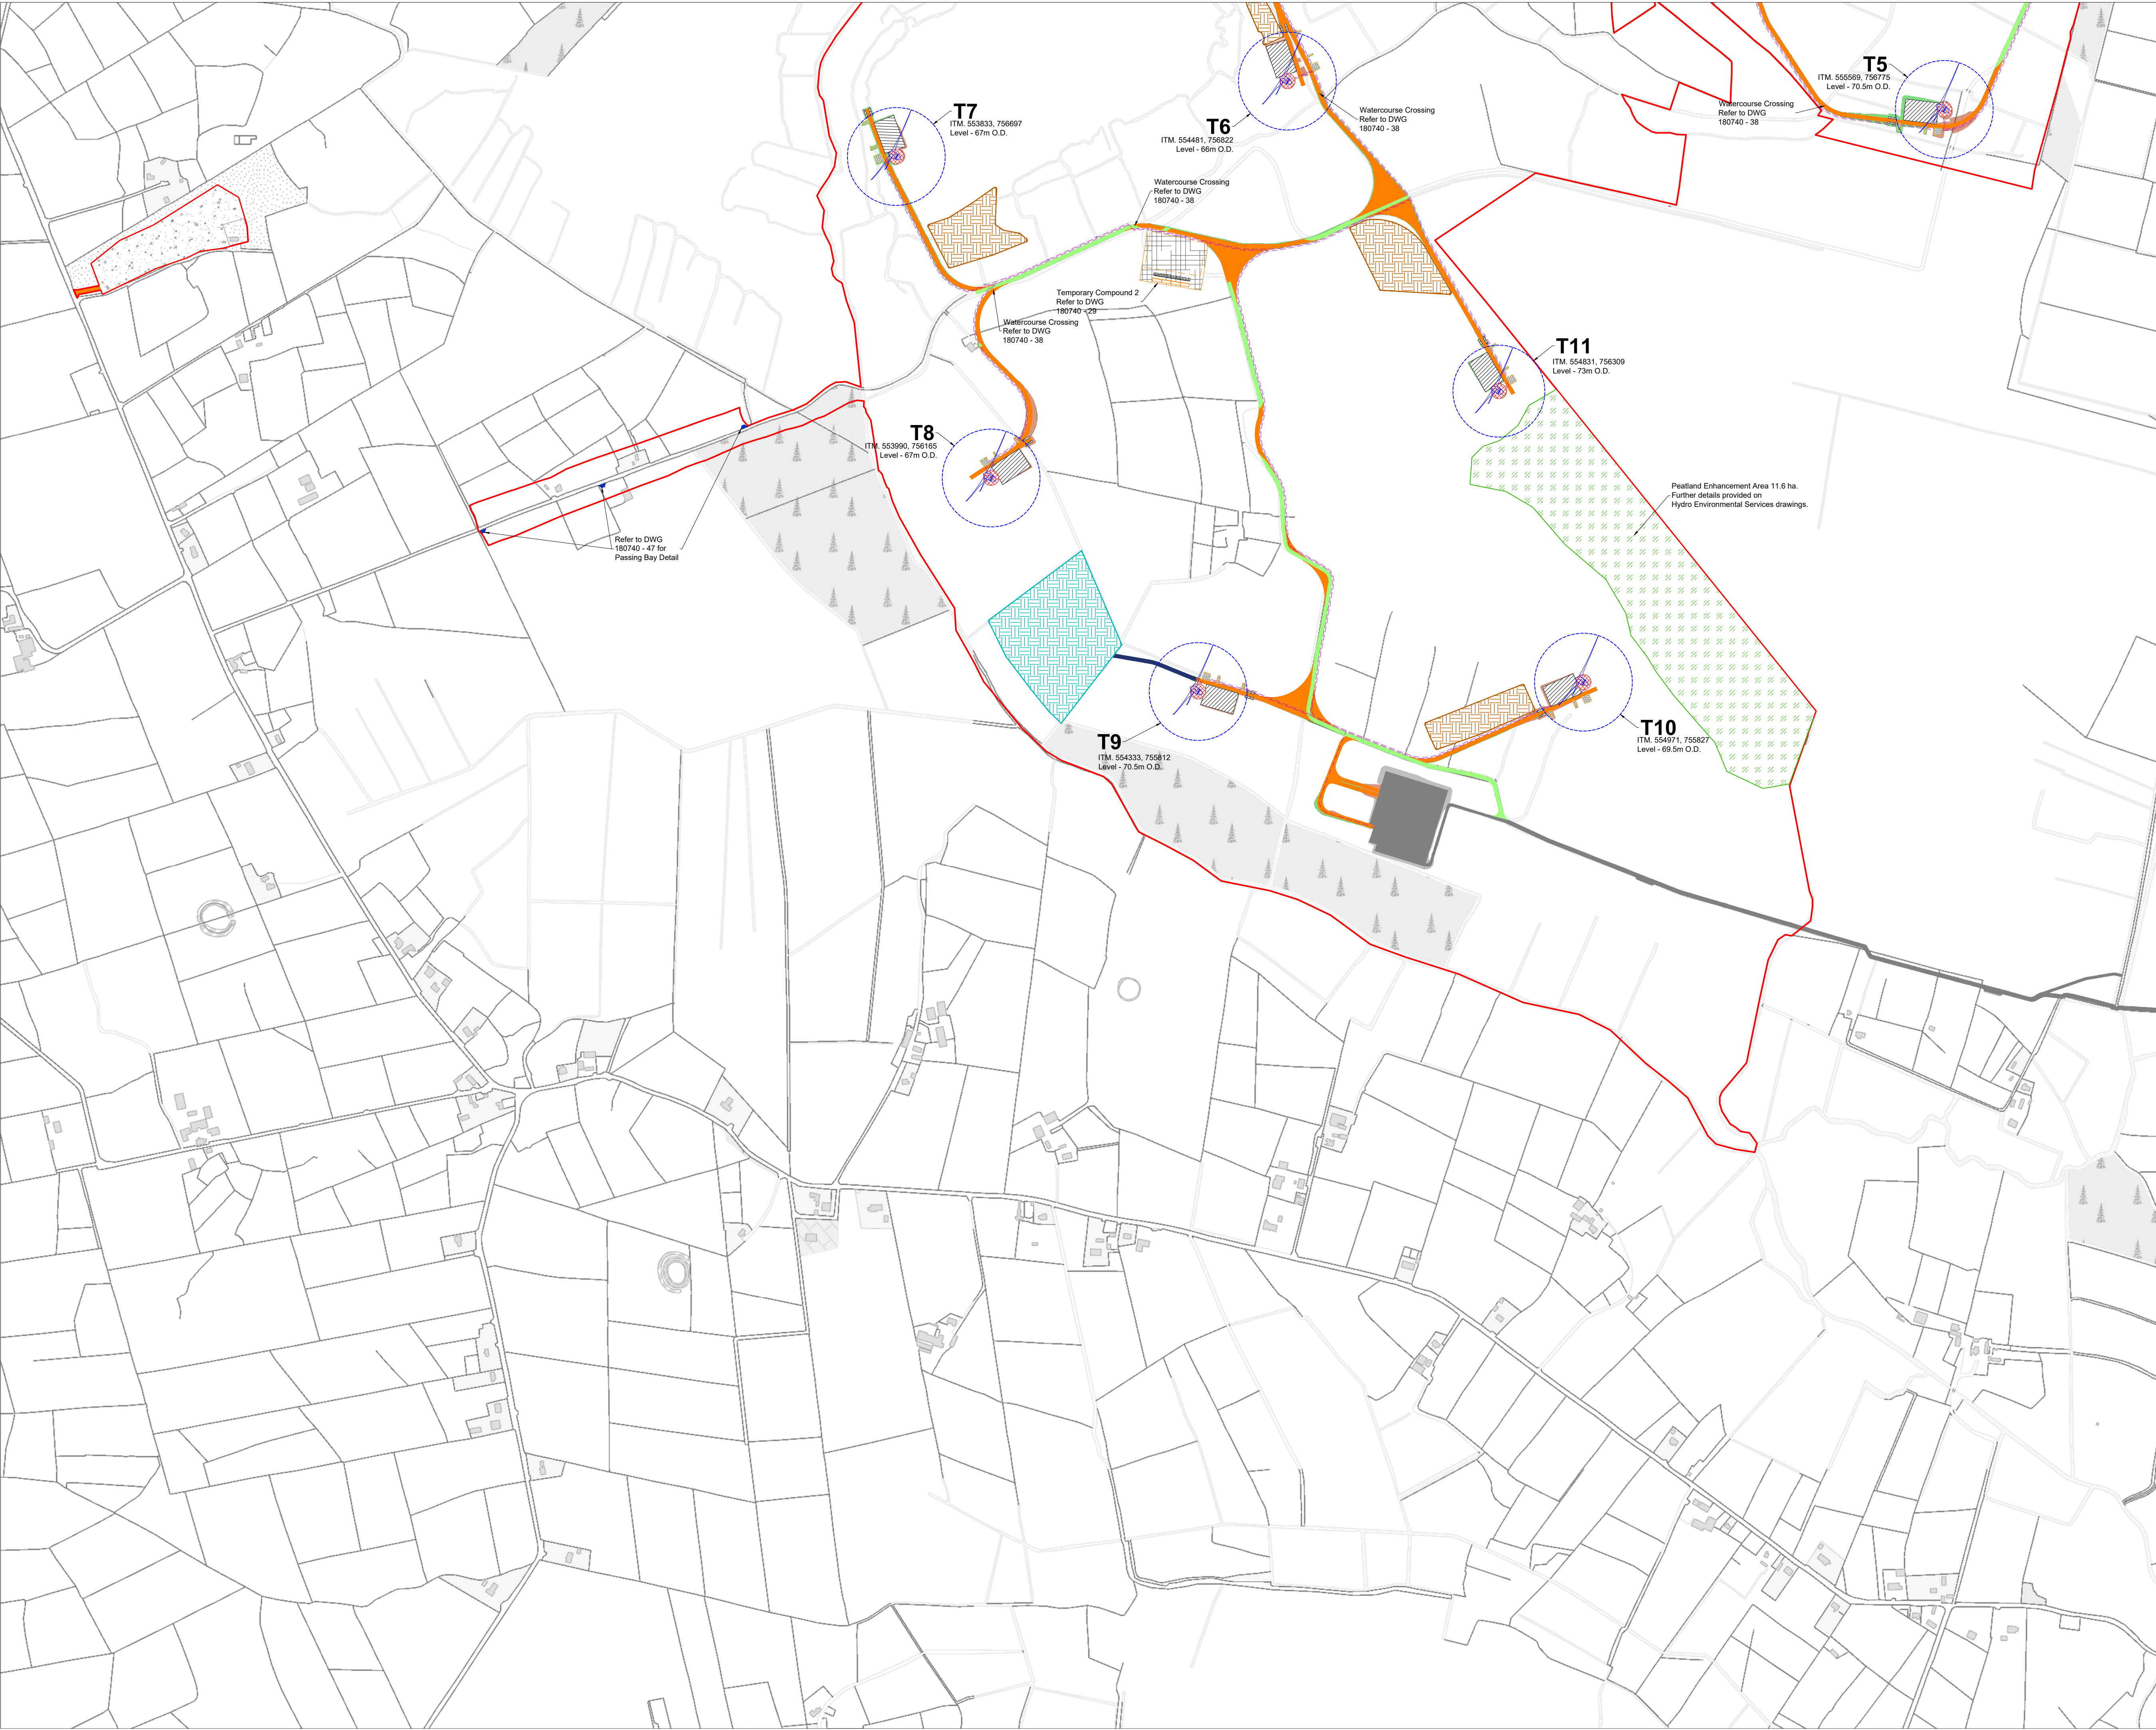

- Project Design Drawing Notes**
1. Drawings issued are for planning application purposes only.
 2. Drawings not to be used for construction/contract conditions.
 3. Copyright, all rights reserved. No part herewith may be copied or reproduced partially or wholly in any form whatsoever without the prior notice of the copyright owner McCarthy Keville O'Sullivan.
 4. Do not scale off this drawing. Figured metric dimensions only should be taken off this drawing.
 5. All contractors, whether main or sub-contractors, must visit the site and are responsible for taking and checking any and all dimensions and levels that relate to the works.
 6. The use of or reliance upon this drawing shall be deemed to be acceptance of these conditions of use unless otherwise agreed in writing, such written agreement to be sought from and issued by the copyright holder to the use or reliance upon this drawing.
 7. Layout plans show Turbine rotor diameter as per turbine drawing.
 8. Final levels may vary depending on local ground conditions.

Drawing Legend

- Planning Application Boundary
- Existing Road to be Upgraded
- Proposed Road
- Temporary Access Road
- Passing Bay
- Electrical Cable Trench
- Crane Pad Hardstanding Area
- Turbine Foundation
- Turbine Sweep Area
- Borrow Pit
- Peat Repository Area
- Spoil Repository Area
- Peatland Enhancement Area
- Area Part of Separate Application
- Cut
- Fill

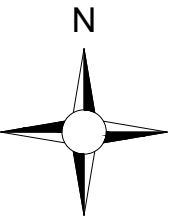


DRAWING TITLE:
**Site Layout Plan
Sheet 2 of 3**

PROJECT TITLE:
Clonberne Wind Farm FI, Co. Galway

DRAWING BY: JOB	CHECKED BY: AC
PROJECT No.: 180740	DRAWING No.: 180740 - 05FI
SCALE: 1:5,000 @ A1	DATE: 02.12.2025

OS SHEET No.: 2541, 2542, 2543, 2544, 2607, 2608, 2609, 2610, 2611, 2677, 2678, 2679, 2680, 2681, 2746, 2747, 2748, 2749, 2750, 2814, 2815, 2816, 2817, 2818

MKO
Planning and
Environmental
Consultants
Tuam Road, Galway
Ireland, H91 YW84
+353 (0) 91 735611
email: info@www.mkoireland.ie
Website: www.mkoireland.ie

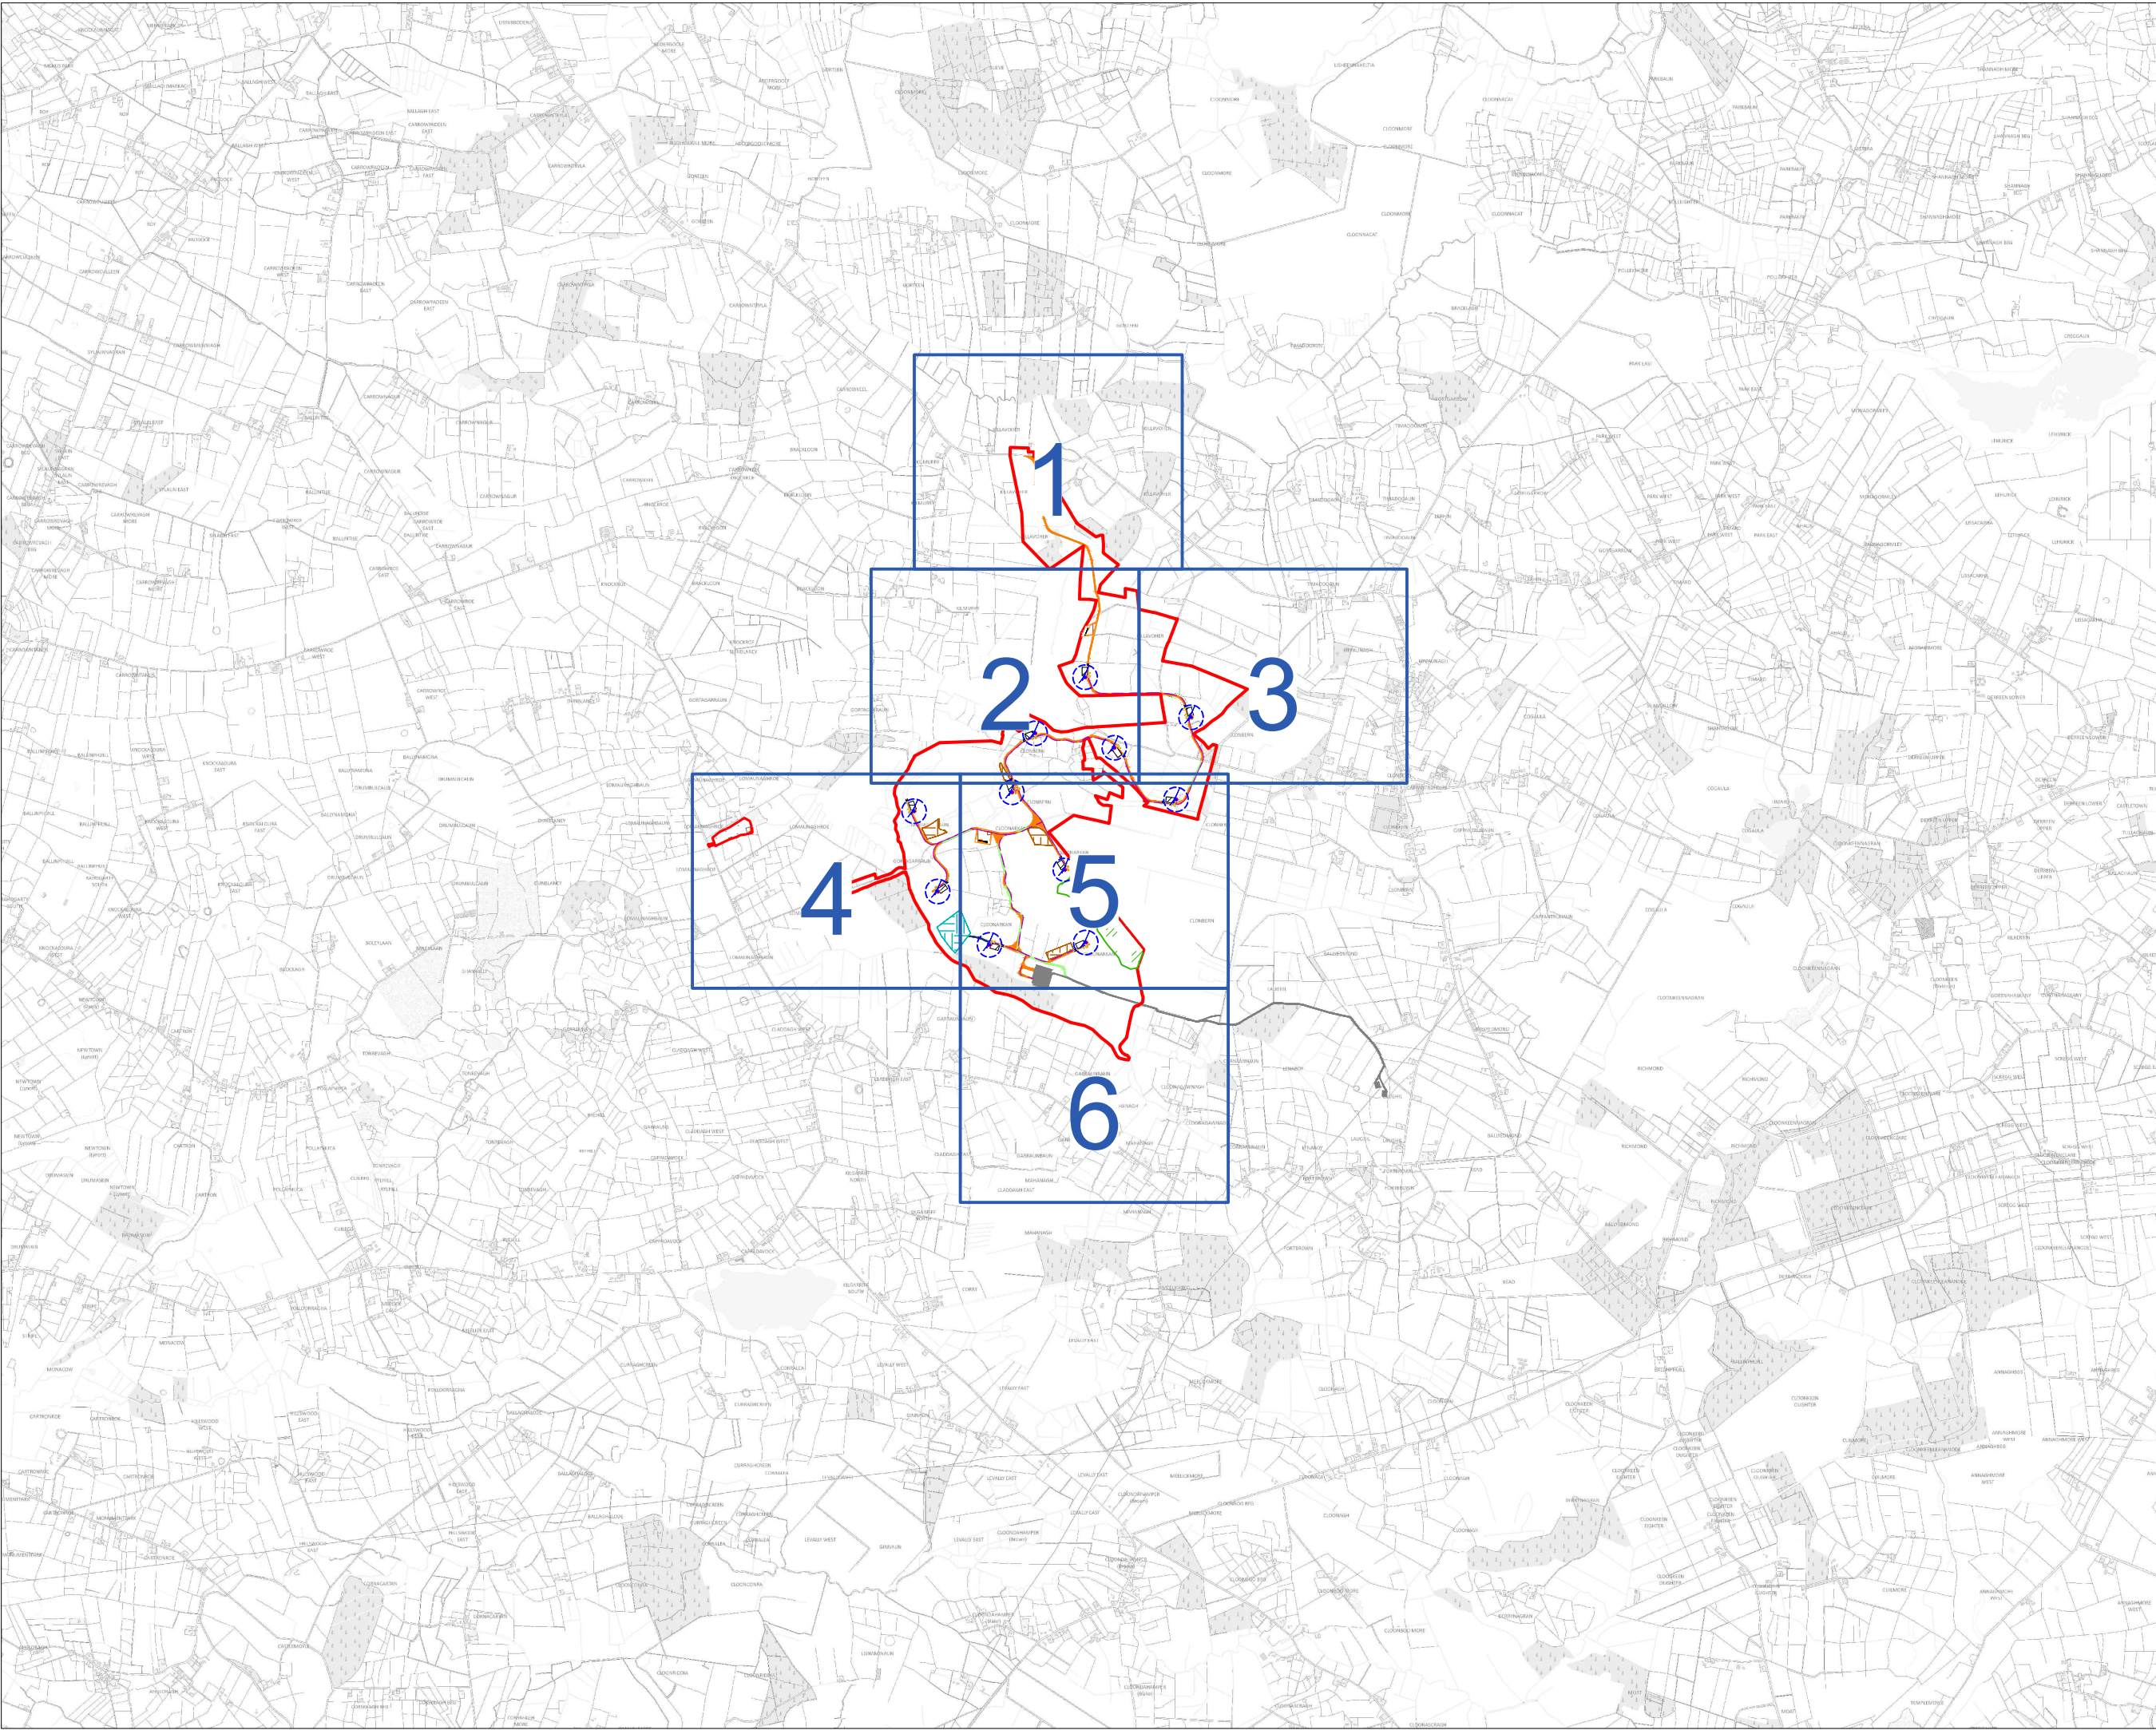

Project Design Drawing Notes

1. Drawings issued are for planning application purposes only.
2. Drawings not to be used for construction/contract conditions.
3. Copyright, all rights reserved. No part herewith may be copied or reproduced partially or wholly in any form whatsoever without the prior notice of the copyright owner McCarthy Keville O'Sullivan.
4. Do not scale off this drawing. Figured metric dimensions only should be taken off this drawing.
5. All contractors, whether main or sub-contractors, must visit the site and are responsible for taking and checking any and all dimensions and levels that relate to the works.
6. The use of or reliance upon this drawing shall be deemed to be acceptance of these conditions of use unless otherwise agreed in writing, such written agreement to be sought from and issued by the copyright holder to the use or reliance upon this drawing.
7. Layout plans show Turbine rotor diameter as per turbine drawing.
8. Final levels may vary depending on local ground conditions.

Drawing Legend

- Planning Application Boundary
- Existing Road to be Upgraded
- Proposed Road
- Temporary Access Road
- Temporary New Road (to facilitate delivery of abnormal loads)
- Passing Bay
- Electrical Cable Trench
- Soft Levelled Area
- Crane Pad Hardstanding Area
- Turbine Foundation
- Turbine Sweep Area
- Borrow Pit
- Peat Repository Area
- Spoil Repository Area
- Peatland Enhancement Area
- Area Part of Separate Application
- Cut
- Fill



**Site Layout Key Plan
(1:2,500)**

Clonberne Wind Farm FI, Co. Galway

DRAWING BY:	CHECKED BY:
JOB	AC
180740	180740 - 07FI
PROJECT No.:	DRAWING No.:
1:2,500 @ A3	02.12.2025
SCALE:	DATE:
OS SHEET: 2541, 2542, 2543, 2544, 2607, 2608, 2609, 2610, 2611, 2677, 2678, 2679, 2680, 2681, 2746, 2747, 2748, 2749, 2750, 2814, 2815, 2816, 2817, 2818	




MKO
Planning and
Environmental
Consultants
Tuam Road, Galway
Ireland, H91 VW84
+353 (0) 91 735611
email: info@www.mkofireland.ie
Website: www.mkofireland.ie



- Project Design Drawing Notes**
1. Drawings issued are for planning application purposes only.
 2. Drawings not to be used for construction/contract conditions.
 3. Copyright, all rights reserved. No part herewith may be copied or reproduced partially or wholly in any form whatsoever without the prior notice of the copyright owner McCarthy Keville O'Sullivan.
 4. Do not scale off this drawing. Figured metric dimensions only should be taken off this drawing.
 5. All contractors, whether main or sub-contractors, must visit the site and are responsible for taking and checking any and all dimensions and levels that relate to the works.
 6. The use of or reliance upon this drawing shall be deemed to be acceptance of these conditions of use unless otherwise agreed in writing, such written agreement to be sought from and issued by the copyright holder to the use or reliance upon this drawing.
 7. Layout plans show Turbine rotor diameter as per turbine drawing.
 8. Final levels may vary depending on local ground conditions.

Drawing Legend

- Planning Application Boundary
- Proposed Road
- Watercourse
- Cut
- Fill

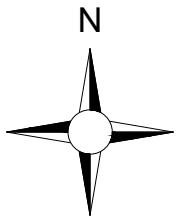


Ordnance Survey Ireland Licence No. CYAL502675176 Ordnance Survey Ireland/Government of Ireland

DRAWING TITLE:
**Site Layout Plan
Sheet 1 of 8**


PROJECT TITLE:
Clonberne Wind Farm Fl, Co. Galway

DRAWING BY: JOB	CHECKED BY: AC
PROJECT No.: 180740	DRAWING No.: 180740 - 08FI
SCALE: 1:2,500 @ A1	DATE: 02.12.2025

OS SHEET No.: 2541, 2542, 2543, 2544, 2607, 2608, 2609, 2610, 2611, 2677, 2678, 2679, 2680, 2681, 2746, 2747, 2748, 2749, 2750, 2814, 2815, 2816, 2817, 2818




MKO
Planning and
Environmental
Consultants
Tuam Road, Galway
Ireland, H91 YW84
+353 (0) 91 735611
email: info@www.mkoireland.ie
Website: www.mkoireland.ie

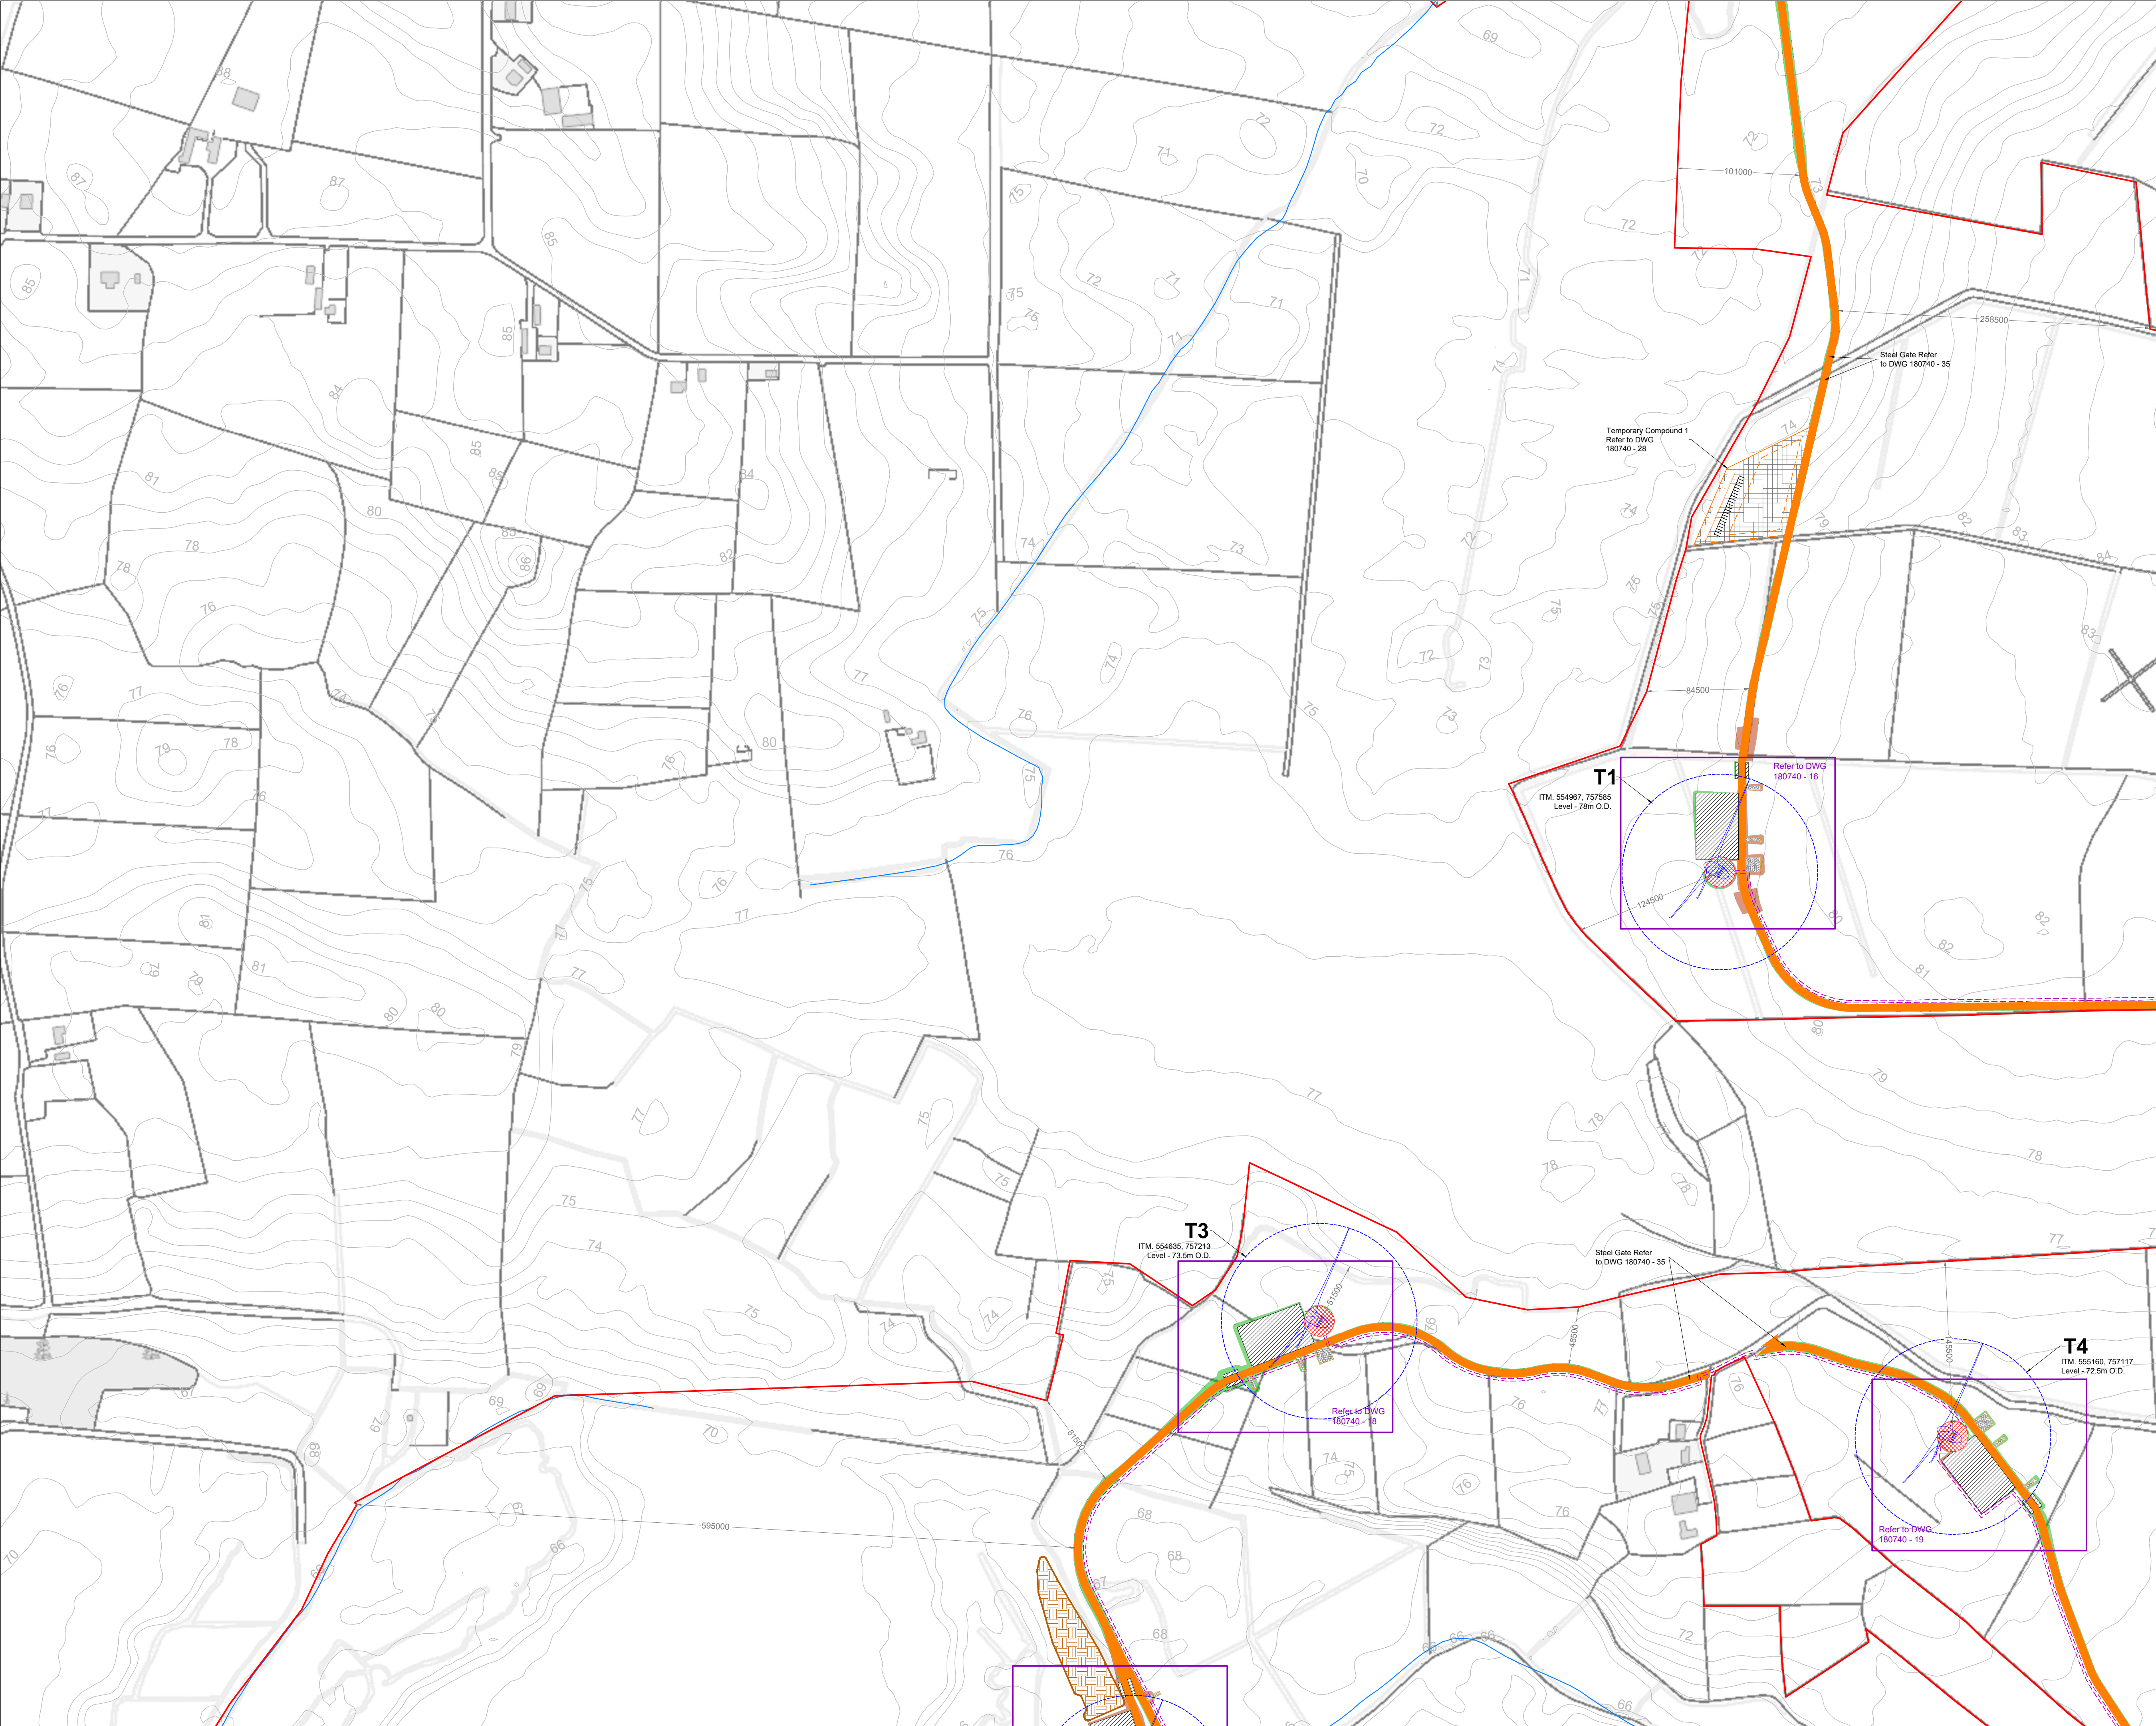

- Project Design Drawing Notes**
1. Drawings issued are for planning application purposes only.
 2. Drawings not to be used for construction/contract conditions.
 3. Copyright, all rights reserved. No part herewith may be copied or reproduced partially or wholly in any form whatsoever without the prior notice of the copyright owner McCarthy Keville O'Sullivan.
 4. Do not scale off this drawing. Figured metric dimensions only should be taken off this drawing.
 5. All contractors, whether main or sub-contractors, must visit the site and are responsible for taking and checking any and all dimensions and levels that relate to the works.
 6. The use of or reliance upon this drawing shall be deemed to be acceptance of these conditions of use unless otherwise agreed in writing, such written agreement to be sought from and issued by the copyright holder to the use or reliance upon this drawing.
 7. Layout plans show Turbine rotor diameter as per turbine drawing.
 8. Final levels may vary depending on local ground conditions.

Drawing Legend

- Planning Application Boundary
- Proposed Road
- Electrical Cable Trench
- Soft Levelled Area
- Crane Pad Hardstanding Area
- Turbine Foundation
- Turbine Sweep Area
- Peat Repository Area
- Watercourse
- Cut
- Fill

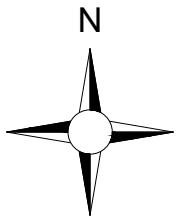

Site Layout Plan
Sheet 2 of 8

PROJECT TITLE:
Clonberne Wind Farm Fl, Co. Galway

DRAWING BY: JOB	CHECKED BY: AC
PROJECT No.: 180740	DRAWING No.: 180740 - 09FI
SCALE: 1:2,500 @ A1	DATE: 02.12.2025

OS SHEET No.: 2540, 2541, 2542, 2543, 2544, 2607, 2608, 2609, 2610, 2611, 2677, 2678, 2679, 2680, 2681, 2746, 2747, 2748, 2749, 2750, 2814, 2815, 2816, 2817, 2818


MKO
Planning and
Environmental
Consultants
Tuam Road, Galway
Ireland, H91 YW84
+353 (0) 91 735611
email: info@www.mkoireland.ie
Website: www.mkoireland.ie



- Project Design Drawing Notes**
1. Drawings issued are for planning application purposes only.
 2. Drawings not to be used for construction/contract conditions.
 3. Copyright, all rights reserved. No part herewith may be copied or reproduced partially or wholly in any form whatsoever without the prior notice of the copyright owner McCarthy Keville O'Sullivan.
 4. Do not scale off this drawing. Figured metric dimensions only should be taken off this drawing.
 5. All contractors, whether main or sub-contractors, must visit the site and are responsible for taking and checking any and all dimensions and levels that relate to the works.
 6. The use of or reliance upon this drawing shall be deemed to be acceptance of these conditions of use unless otherwise agreed in writing, such written agreement to be sought from and issued by the copyright holder to the use or reliance upon this drawing.
 7. Layout plans show Turbine rotor diameter as per turbine drawing.
 8. Final levels may vary depending on local ground conditions.

Drawing Legend

- Planning Application Boundary
- Existing Road to be Upgraded
- Proposed Road
- Electrical Cable Trench
- Soft Levelled Area
- Crane Pad Hardstanding Area
- Turbine Foundation
- Turbine Sweep Area
- Watercourse
- Cut
- Fill

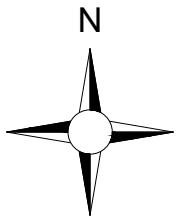


DRAWING TITLE:
**Site Layout Plan
Sheet 3 of 8**

PROJECT TITLE:
Clonberne Wind Farm FI, Co. Galway

DRAWING BY: JOB	CHECKED BY: AC
PROJECT No.: 180740	DRAWING No.: 180740 - 10FI
SCALE: 1:2,500 @ A1	DATE: 02.12.2025

OS SHEET No.: 2541, 2542, 2543, 2544, 2607, 2608, 2609, 2610, 2611, 2677, 2678, 2679, 2680, 2681, 2746, 2747, 2748, 2749, 2750, 2814, 2815, 2816, 2817, 2818

MKO
Planning and
Environmental
Consultants
Tuam Road, Galway
Ireland, H91 YW84
+353 (0) 91 735611
email: info@www.mkoireland.ie
Website: www.mkoireland.ie

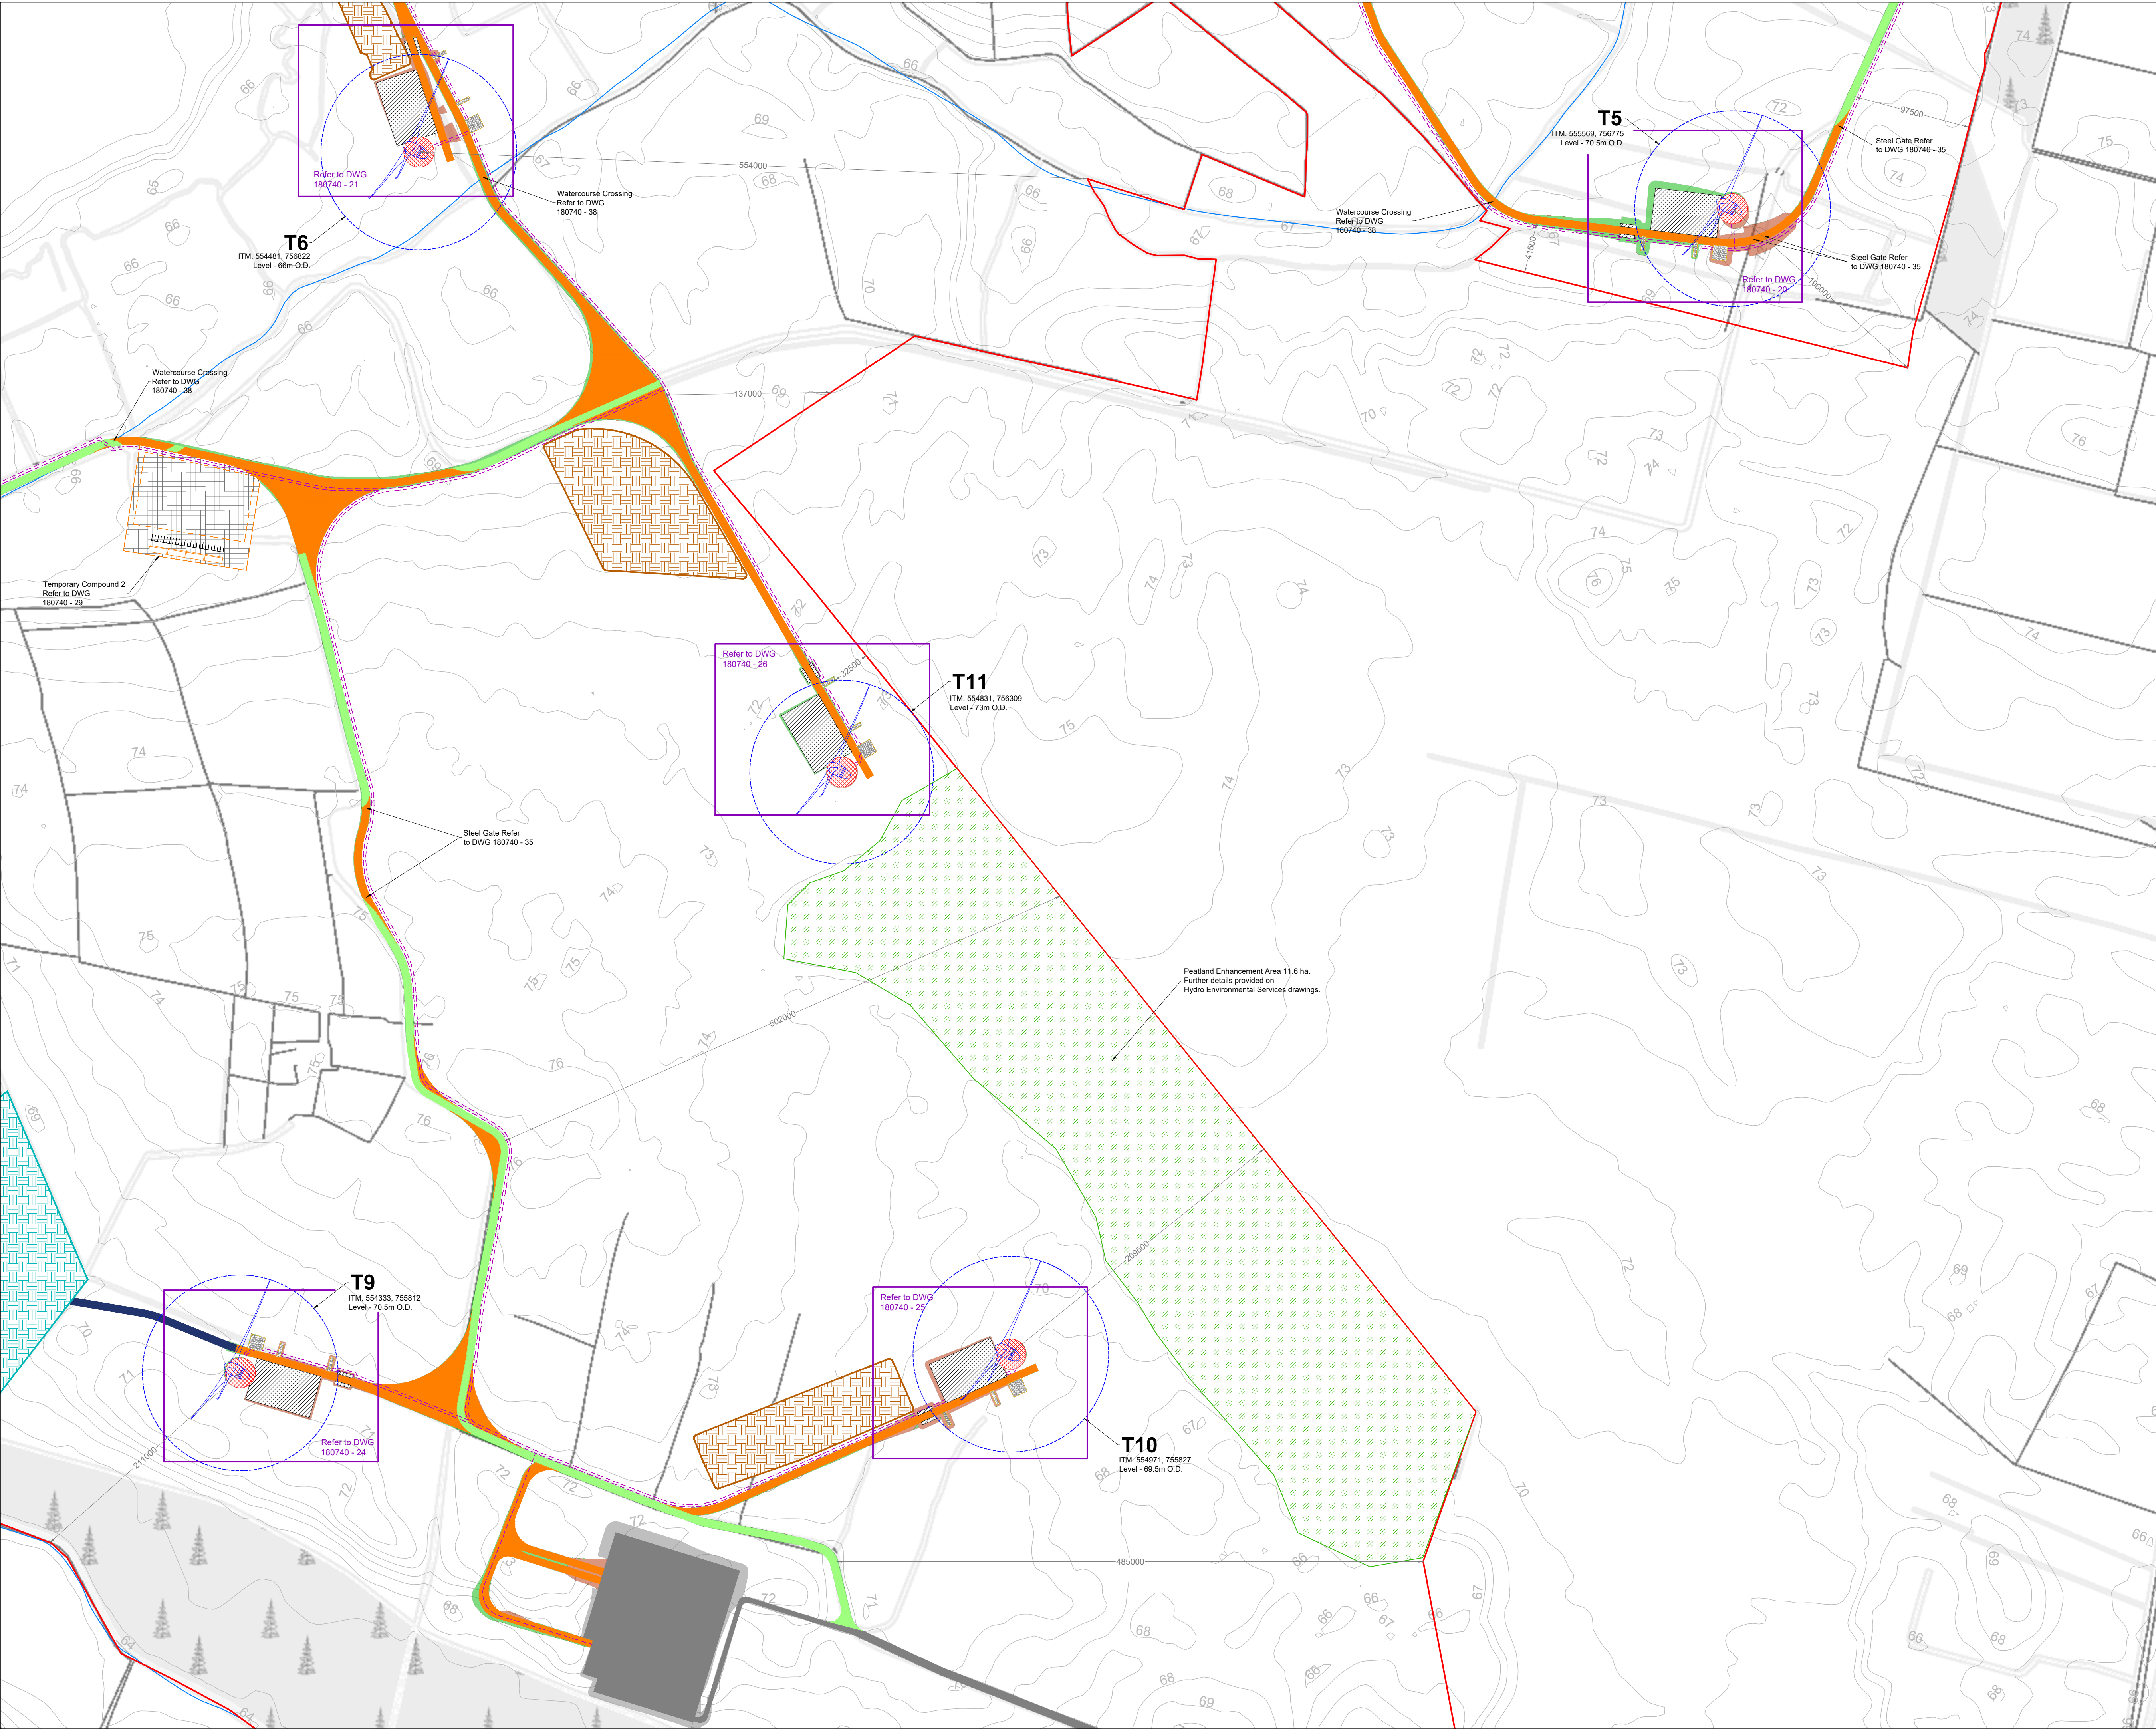


Project Design Drawing Notes

1. Drawings issued are for planning application purposes only.
2. Drawings not to be used for construction/contract conditions.
3. Copyright, all rights reserved. No part herewith may be copied or reproduced partially or wholly in any form whatsoever without the prior notice of the copyright owner McCarthy Keville O'Sullivan.
4. Do not scale off this drawing. Figured metric dimensions only should be taken off this drawing.
5. All contractors, whether main or sub-contractors, must visit the site and are responsible for taking and checking any and all dimensions and levels that relate to the works.
6. The use of or reliance upon this drawing shall be deemed to be acceptance of these conditions of use unless otherwise agreed in writing, such written agreement to be sought from and issued by the copyright holder to the use or reliance upon this drawing.
7. Layout plans show Turbine rotor diameter as per turbine drawing.
8. Final levels may vary depending on local ground conditions.

Drawing Legend

- Planning Application Boundary
- Existing Road to be Upgraded
- Proposed Road
- Temporary Access Road
- Electrical Cable Trench
- Soft Levelled Area
- Crane Pad Hardstanding Area
- Turbine Foundation
- Turbine Sweep Area
- Peat Repository Area
- Spoil Repository Area
- Watercourse
- Area Part of Separate Application
- Cut
- Fill
- Peatland Enhancement Area

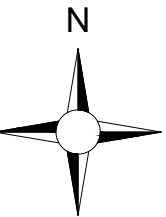

Ordnance Survey Ireland Licence No. CYAL502675176 Ordnance Survey Ireland/Government of Ireland


DRAWING TITLE:
**Site Layout Plan
Sheet 5 of 8**

PROJECT TITLE:
Clonberne Wind Farm Fl, Co. Galway

DRAWING BY: JOB	CHECKED BY: AC
PROJECT No.: 180740	DRAWING No.: 180740 - 12FI
SCALE: 1:2,500 @ A1	DATE: 02.12.2025

OS SHEET No.: 2541, 2542, 2543, 2544, 2607, 2608, 2609, 2610, 2611, 2677, 2678, 2679, 2680, 2681, 2746, 2747, 2748, 2749, 2750, 2814, 2815, 2816, 2817, 2818


MKO
Planning and
Environmental
Consultants
Tuam Road, Galway
Ireland, H91 VV84
+353 (0) 91 735611
email: info@www.mkofireland.ie
Website: www.mkofireland.ie

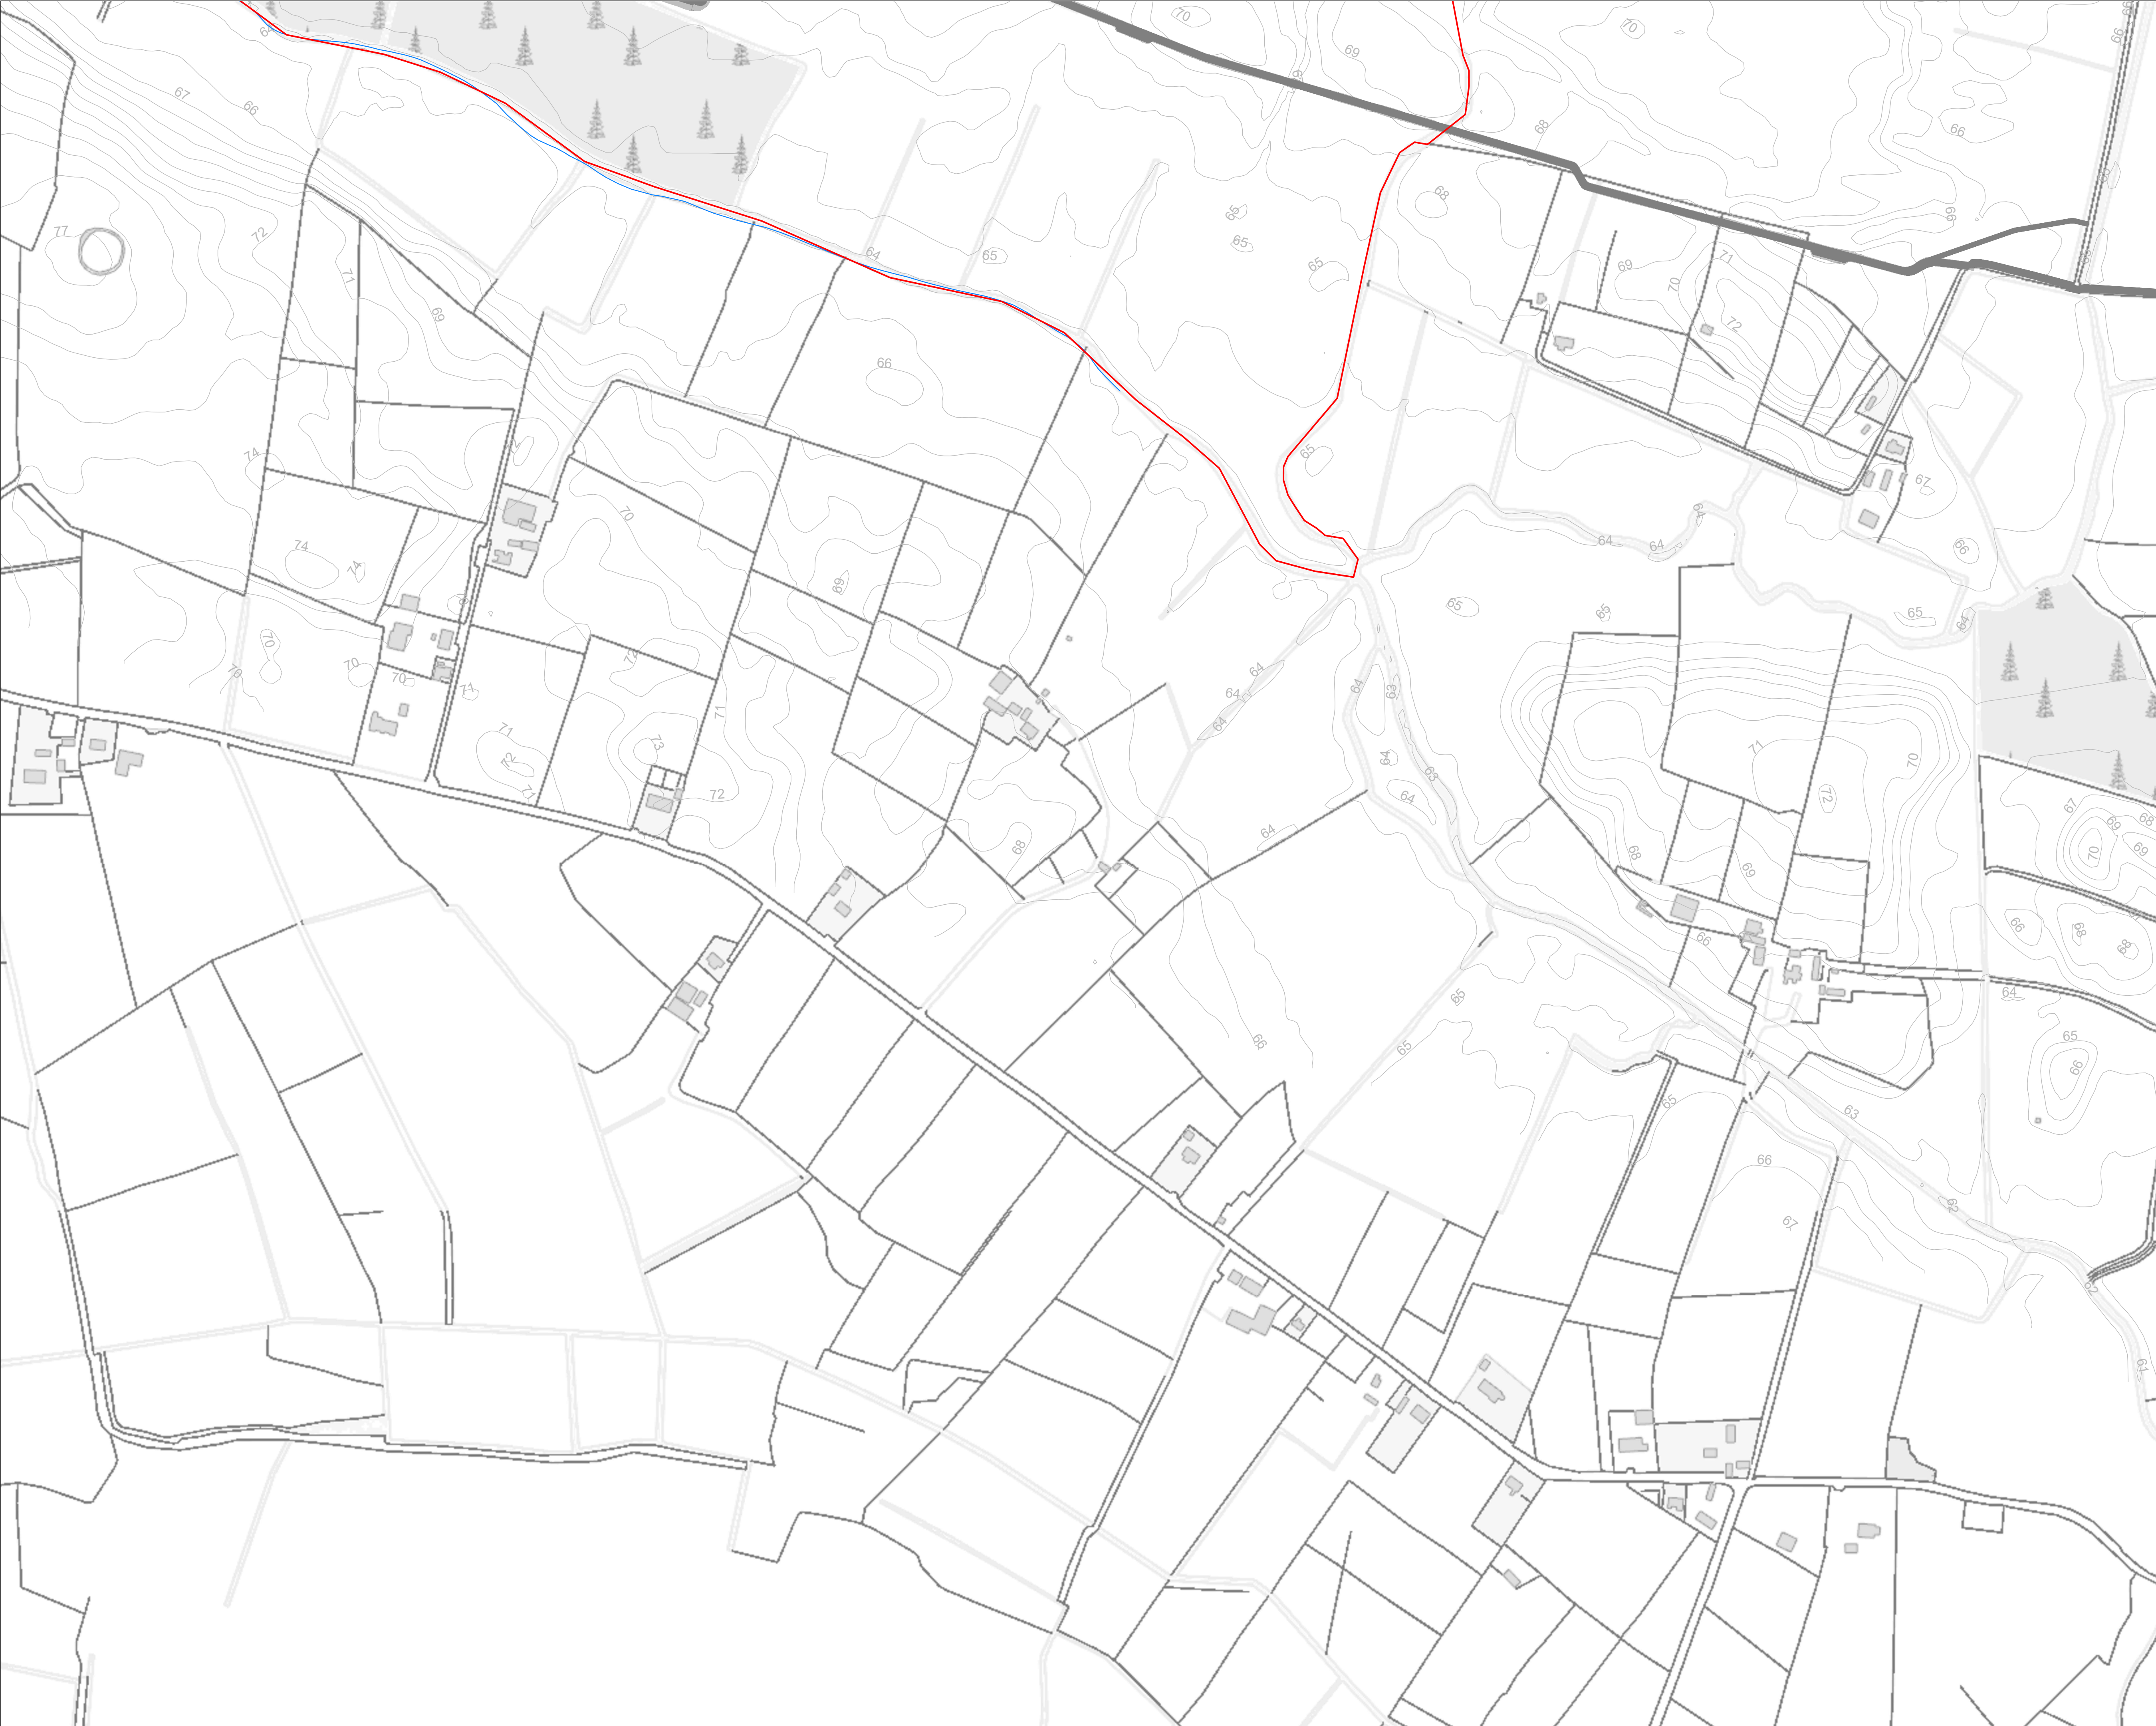

- Project Design Drawing Notes**
1. Drawings issued are for planning application purposes only.
 2. Drawings not to be used for construction/contract conditions.
 3. Copyright, all rights reserved. No part herewith may be copied or reproduced partially or wholly in any form whatsoever without the prior notice of the copyright owner McCarthy Keville O'Sullivan.
 4. Do not scale off this drawing. Figured metric dimensions only should be taken off this drawing.
 5. All contractors, whether main or sub-contractors, must visit the site and are responsible for taking and checking any and all dimensions and levels that relate to the works.
 6. The use of or reliance upon this drawing shall be deemed to be acceptance of these conditions of use unless otherwise agreed in writing, such written agreement to be sought from and issued by the copyright holder to the use or reliance upon this drawing.
 7. Layout plans show Turbine rotor diameter as per turbine drawing.
 8. Final levels may vary depending on local ground conditions.

Drawing Legend

- Planning Application Boundary
- Area Part of Separate Application
- Watercourse

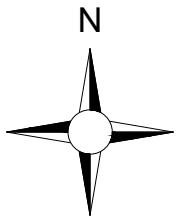

Ordnance Survey Ireland Licence No. CYAL50267517© Ordnance Survey Ireland/Government of Ireland

DRAWING TITLE:

Site Layout Plan Sheet 6 of 8

PROJECT TITLE:

Clonberne Wind Farm Fl, Co. Galway

DRAWING BY:	CHECKED BY:
JOB	AC
PROJECT No.: 180740	DRAWING No.: 180740 - 13FI
SCALE: 1:2,500 @ A1	DATE: 02.12.2025

OS SHEET No.:
2540, 2541, 2542, 2543, 2544, 2607, 2608, 2609, 2610, 2611, 2677, 2678, 2679, 2680, 2681, 2746, 2747, 2748, 2749, 2750, 2814, 2815, 2816, 2817, 2818

MKO
Planning and
Environmental
Consultants
Tuam Road, Galway
Ireland, H91 YW84
+353 (0) 91 735611
email: info@www.mkoireland.ie
Website: www.mkoireland.ie



T1
ITM. 554967, 757585
Level - 78m O.D.

76m

77m

+78m

79m

80m

- Project Design Drawing Notes**
1. Drawings issued are for planning application purposes only.
 2. Drawings not to be used for construction/contract conditions.
 3. Copyright, all rights reserved. No part herewith may be copied or reproduced partially or wholly in any form whatsoever without the prior notice of the copyright owner McCarthy Keville O'Sullivan.
 4. Do not scale off this drawing. Figured metric dimensions only should be taken off this drawing.
 5. All contractors, whether main or sub-contractors, must visit the site and are responsible for taking and checking any and all dimensions and levels that relate to the works.
 6. The use of or reliance upon this drawing shall be deemed to be acceptance of these conditions of use unless otherwise agreed in writing, such written agreement to be sought from and issued by the copyright holder to the use or reliance upon this drawing.
 7. Layout plans show Turbine rotor diameter as per turbine drawing.
 8. Final levels may vary depending on local ground conditions.

Drawing Legend

- Proposed Road
- Electrical Cable Trench
- Soft Levelled Area
- Crane Pad Hardstanding Area
- Turbine Foundation
- Turbine Sweep Area
- Cut
- Fill



Ordnance Survey Ireland Licence No. CYAL50267517© Ordnance Survey Ireland/Government of Ireland


DRAWING TITLE:
Turbine 1 Layout

PROJECT TITLE:
Clonberne Wind Farm FI, Co. Galway

DRAWING BY: JOB	CHECKED BY: AC
PROJECT No.: 180740	DRAWING No.: 180740 - 16F1
SCALE: 1:500 @ A3	DATE: 02.12.2025

OS SHEET No.: 2540, 2541, 2542, 2543, 2544, 2607, 2608, 2609, 2610, 2611, 2677, 2678, 2679, 2680, 2681, 2746, 2747, 2748, 2749, 2750, 2814, 2815, 2816, 2817, 2818

MKO
Planning and
Environmental
Consultants
Tuam Road, Galway
Ireland, H91 YW84
+353 (0) 91 735611
email: info@www.mkofireland.ie
Website: www.mkofireland.ie

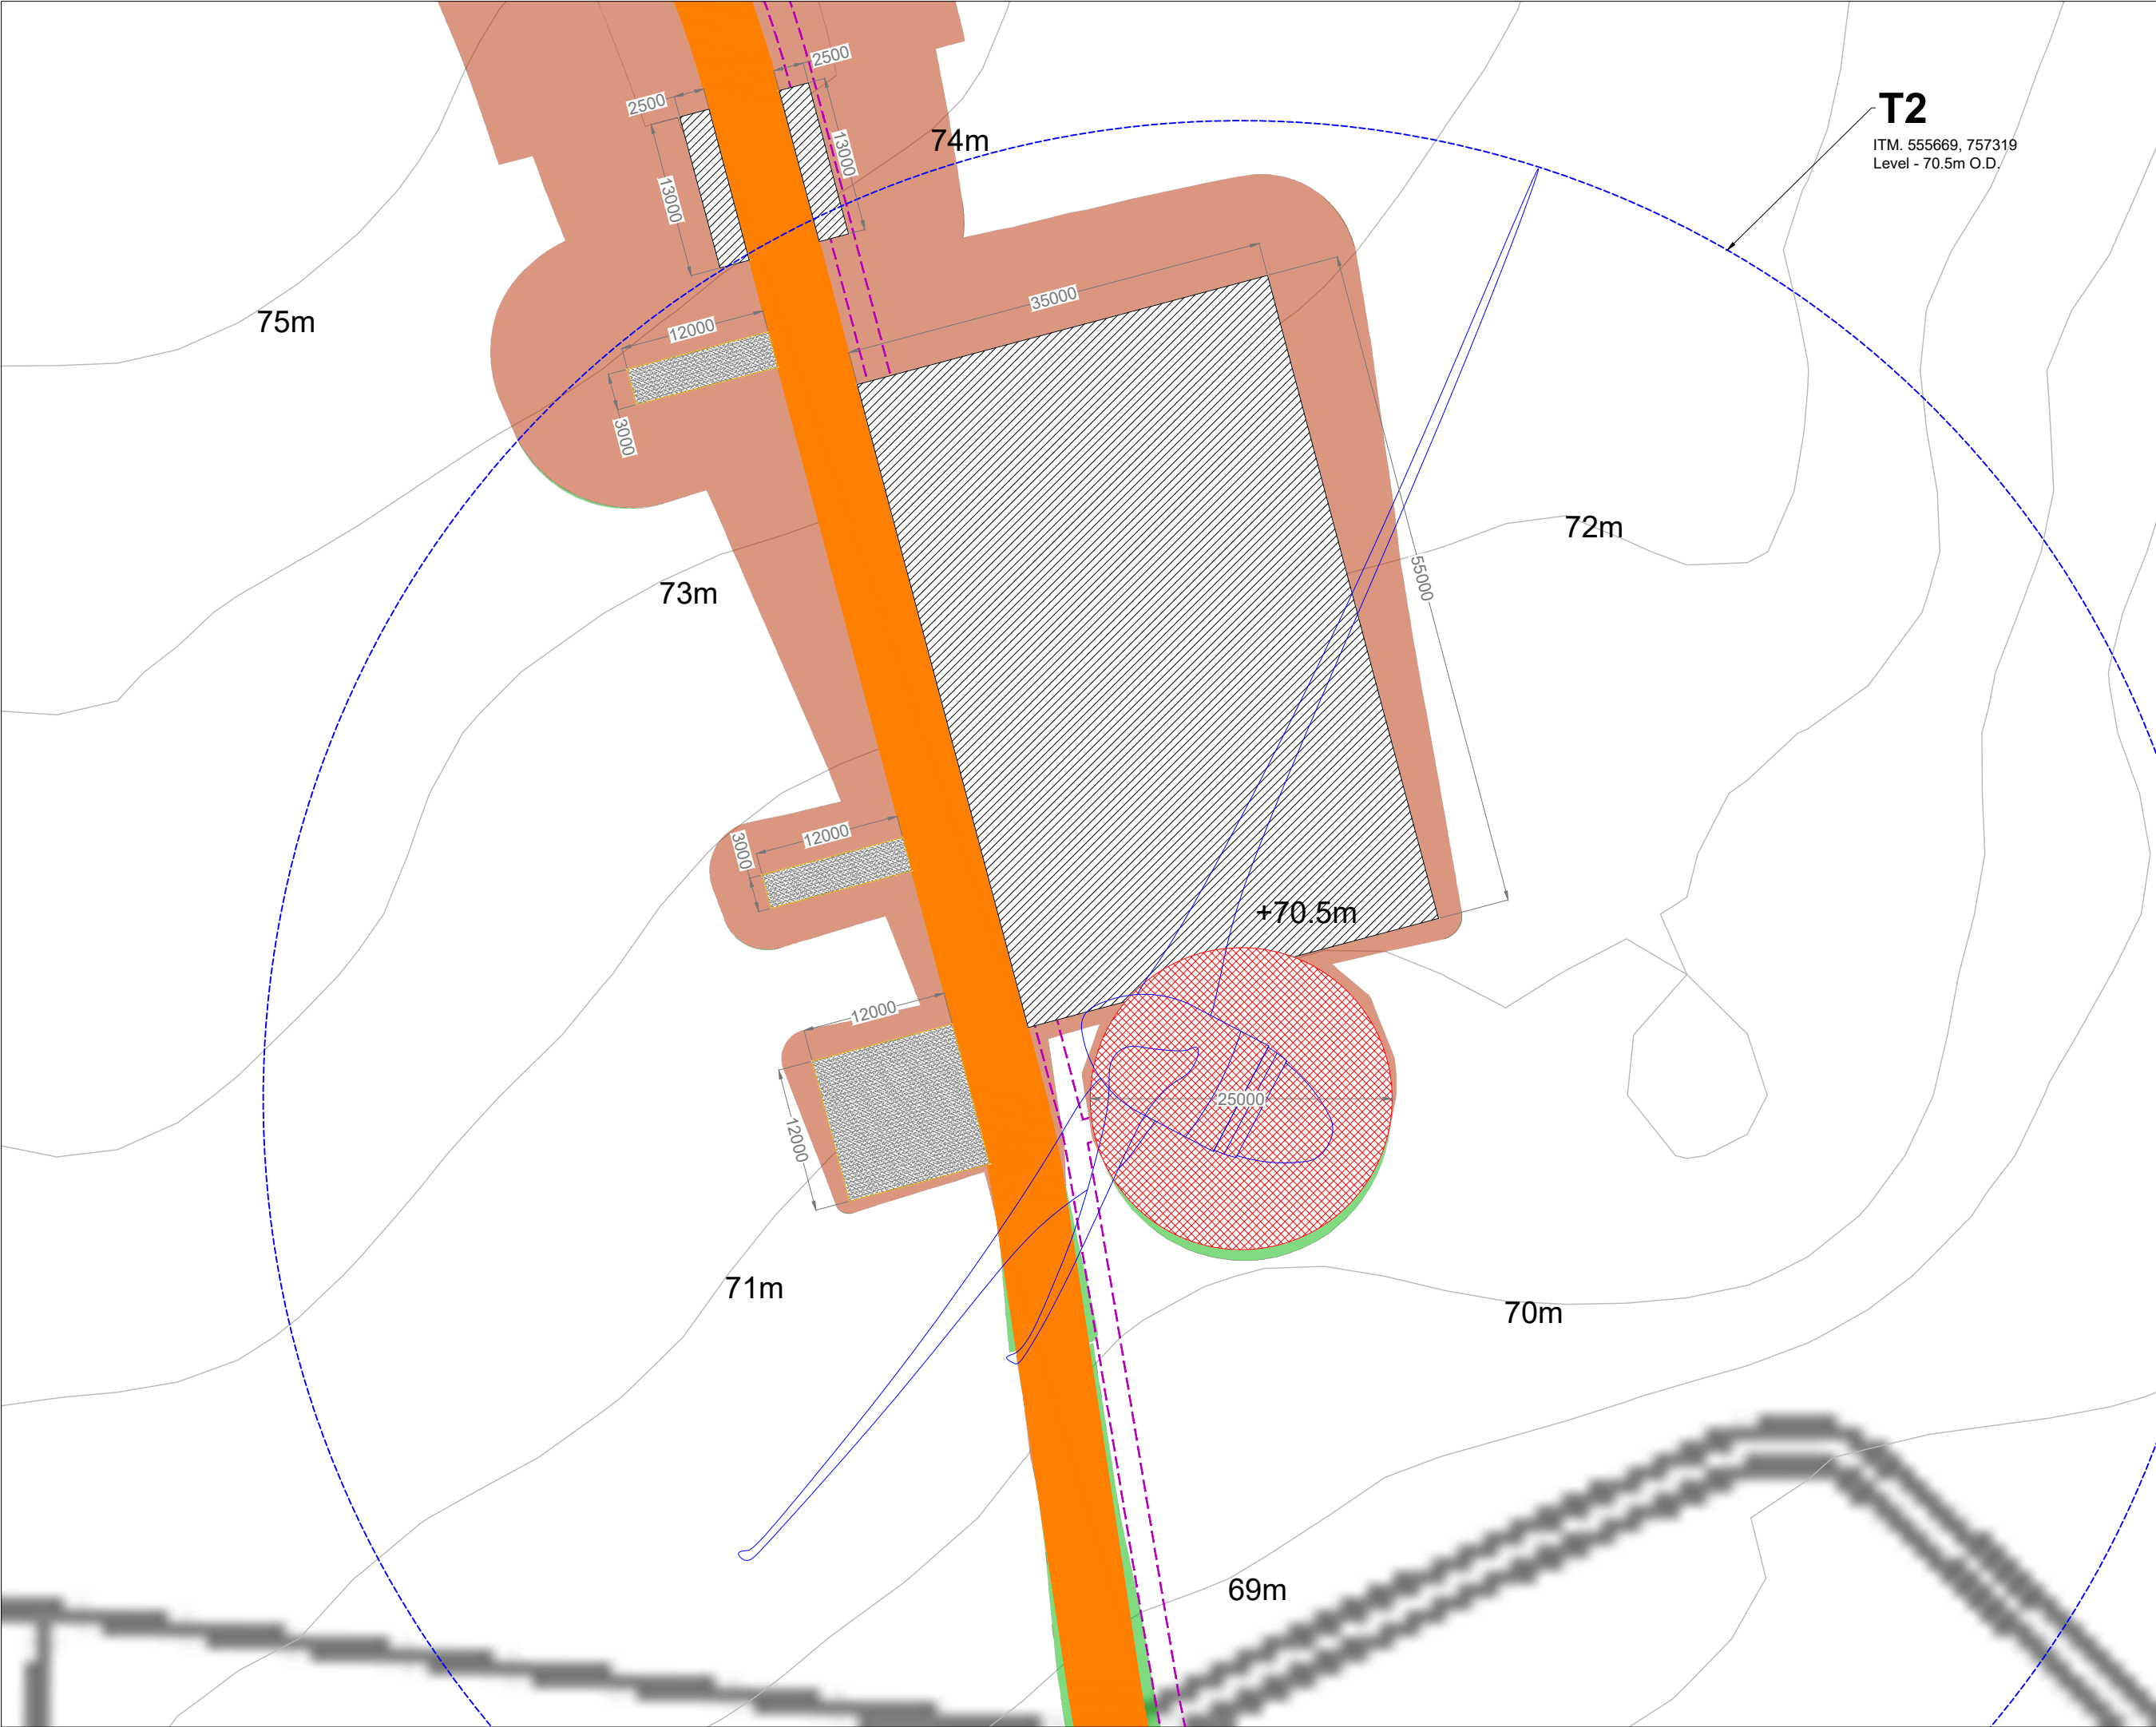

T2
ITM. 555669, 757319
Level - 70.5m O.D.

- Project Design Drawing Notes**
1. Drawings issued are for planning application purposes only.
 2. Drawings not to be used for construction/contract conditions.
 3. Copyright, all rights reserved. No part herewith may be copied or reproduced partially or wholly in any form whatsoever without the prior notice of the copyright owner McCarthy Keville O'Sullivan.
 4. Do not scale off this drawing. Figured metric dimensions only should be taken off this drawing.
 5. All contractors, whether main or sub-contractors, must visit the site and are responsible for taking and checking any and all dimensions and levels that relate to the works.
 6. The use of or reliance upon this drawing shall be deemed to be acceptance of these conditions of use unless otherwise agreed in writing, such written agreement to be sought from and issued by the copyright holder to the use or reliance upon this drawing.
 7. Layout plans show Turbine rotor diameter as per turbine drawing.
 8. Final levels may vary depending on local ground conditions.

Drawing Legend

- Proposed Road
- Electrical Cable Trench
- Soft Levelled Area
- Crane Pad Hardstanding Area
- Turbine Foundation
- Turbine Sweep Area
- Cut
- Fill



Ordnance Survey Ireland Licence No. CYAL50287517© Ordnance Survey Ireland/Government of Ireland

DRAWING TITLE:

Turbine 2 Layout

PROJECT TITLE:

Clonberne Wind Farm FI, Co. Galway


DRAWING BY:	CHECKED BY:
JOB	AC
PROJECT No.:	DRAWING No.:
180740	180740 - 17FI
SCALE:	DATE:
1:500 @ A3	02.12.2025

OS SHEET No.: 2541, 2542, 2543, 2544, 2607, 2608, 2609, 2610, 2611, 2677, 2678, 2679, 2680, 2681, 2746, 2747, 2748, 2749, 2750, 2814, 2815, 2816, 2817, 2818

MKO
Planning and
Environmental
Consultants
Tuam Road, Galway
Ireland, H91 YW84
+353 (0) 91 735611
email: info@www.mkofireland.ie
Website: www.mkofireland.ie

Drawing Legend

	Planning Application Boundary
	Proposed Road
	Electrical Cable Trench
	Soft Levelled Area
	Crane Pad Hardstanding Area
	Turbine Foundation
	Turbine Sweep Area
	Cut
	Fill



Ordinance Survey / Ireland Licence No. CYAL50267517 © Ordnance Survey

20000, 20011, 21740, 21741, 21742, 21743, 21744, 21745, 20114, 20115, 20116, 20117, 20118

MKO
Planning and
Environmental
Consultants

Tuam Road, Galway
Ireland, H91 VW84
+353 (0) 91 735611
email: info@mkoireland.ie
Website: www.mkoireland.ie

A horizontal number line with a blue dot at $\frac{1}{2}$ and a bracket from $\frac{1}{2}$ to 1.

 


T4
ITM. 555160, 757117
Level - 72.5m O.D.

- Project Design Drawing Notes**
1. Drawings issued are for planning application purposes only.
 2. Drawings not to be used for construction/contract conditions.
 3. Copyright, all rights reserved. No part herewith may be copied or reproduced partially or wholly in any form whatsoever without the prior notice of the copyright owner McCarthy Keville O'Sullivan.
 4. Do not scale off this drawing. Figured metric dimensions only should be taken off this drawing.
 5. All contractors, whether main or sub-contractors, must visit the site and are responsible for taking and checking any and all dimensions and levels that relate to the works.
 6. The use of or reliance upon this drawing shall be deemed to be acceptance of these conditions of use unless otherwise agreed in writing, such written agreement to be sought from and issued by the copyright holder to the use or reliance upon this drawing.
 7. Layout plans show Turbine rotor diameter as per turbine drawing.
 8. Final levels may vary depending on local ground conditions.

Drawing Legend

- Planning Application Boundary
- Proposed Road
- Electrical Cable Trench
- Soft Levelled Area
- Crane Pad Hardstanding Area
- Turbine Foundation
- Turbine Sweep Area
- Cut
- Fill



Ordnance Survey Ireland Licence No. CYAL50267517© Ordnance Survey Ireland/ Government of Ireland

DRAWING TITLE:

Turbine 4 Layout

PROJECT TITLE:

Clonberne Wind Farm FI, Co. Galway

DRAWING BY:	CHECKED BY:
JOB	AC
PROJECT No.:	DRAWING No.:
180740	180740 - 19FI
SCALE:	DATE:
1:500 @ A3	02.12.2025

OS SHEET No. 2541, 2542, 2543, 2544, 2607, 2608, 2609, 2610, 2611, 2677, 2678, 2679, 2680, 2681, 2746, 2747, 2748, 2749, 2750, 2814, 2815, 2816, 2817, 2818

MKO
Planning and Environmental Consultants
Tuam Road, Galway
Ireland, H91 VW84
+353 (0) 91 735611
email: info@www.mkoireland.ie
Website: www.mkoireland.ie



Project Design Drawing Notes

1. Drawings issued are for planning application purposes only.
2. Drawings not to be used for construction/contract conditions.
3. Copyright, all rights reserved. No part herewith may be copied or reproduced partially or wholly in any form whatsoever without the prior notice of the copyright owner McCarthy Keville O'Sullivan.
4. Do not scale off this drawing. Figured metric dimensions only should be taken off this drawing.
5. All contractors, whether main or sub-contractors, must visit the site and are responsible for taking and checking any and all dimensions and levels that relate to the works.
6. The use of or reliance upon this drawing shall be deemed to be acceptance of these conditions of use unless otherwise agreed in writing, such written agreement to be sought from and issued by the copyright holder to the use or reliance upon this drawing.
7. Layout plans show Turbine rotor diameter as per turbine drawing.
8. Final levels may vary depending on local ground conditions.

Drawing Legend

- Planning Application Boundary
- Proposed Road
- Cut
- Fill

DRAWING TITLE:
Temporary Construction Compound 1


PROJECT TITLE:
Clonberne Wind Farm FI, Co. Galway

DRAWING BY: JOB	CHECKED BY: AC
PROJECT No.: 180740	DRAWING No.: 180740 - 31FI
SCALE: 1:500 @ A3	DATE: 02.12.2025

OS SHEET No.: 2541, 2542, 2543, 2544, 2607, 2608, 2609, 2610, 2611, 2677, 2678, 2679, 2680, 2681, 2746, 2747, 2748, 2749, 2750, 2814, 2815, 2816, 2817, 2818



MKO
Planning and
Environmental
Consultants
Tuam Road, Galway
Ireland, H91 VW84
+353 (0) 91 735611
email: info@www.mkofireland.ie
Website: www.mkofireland.ie

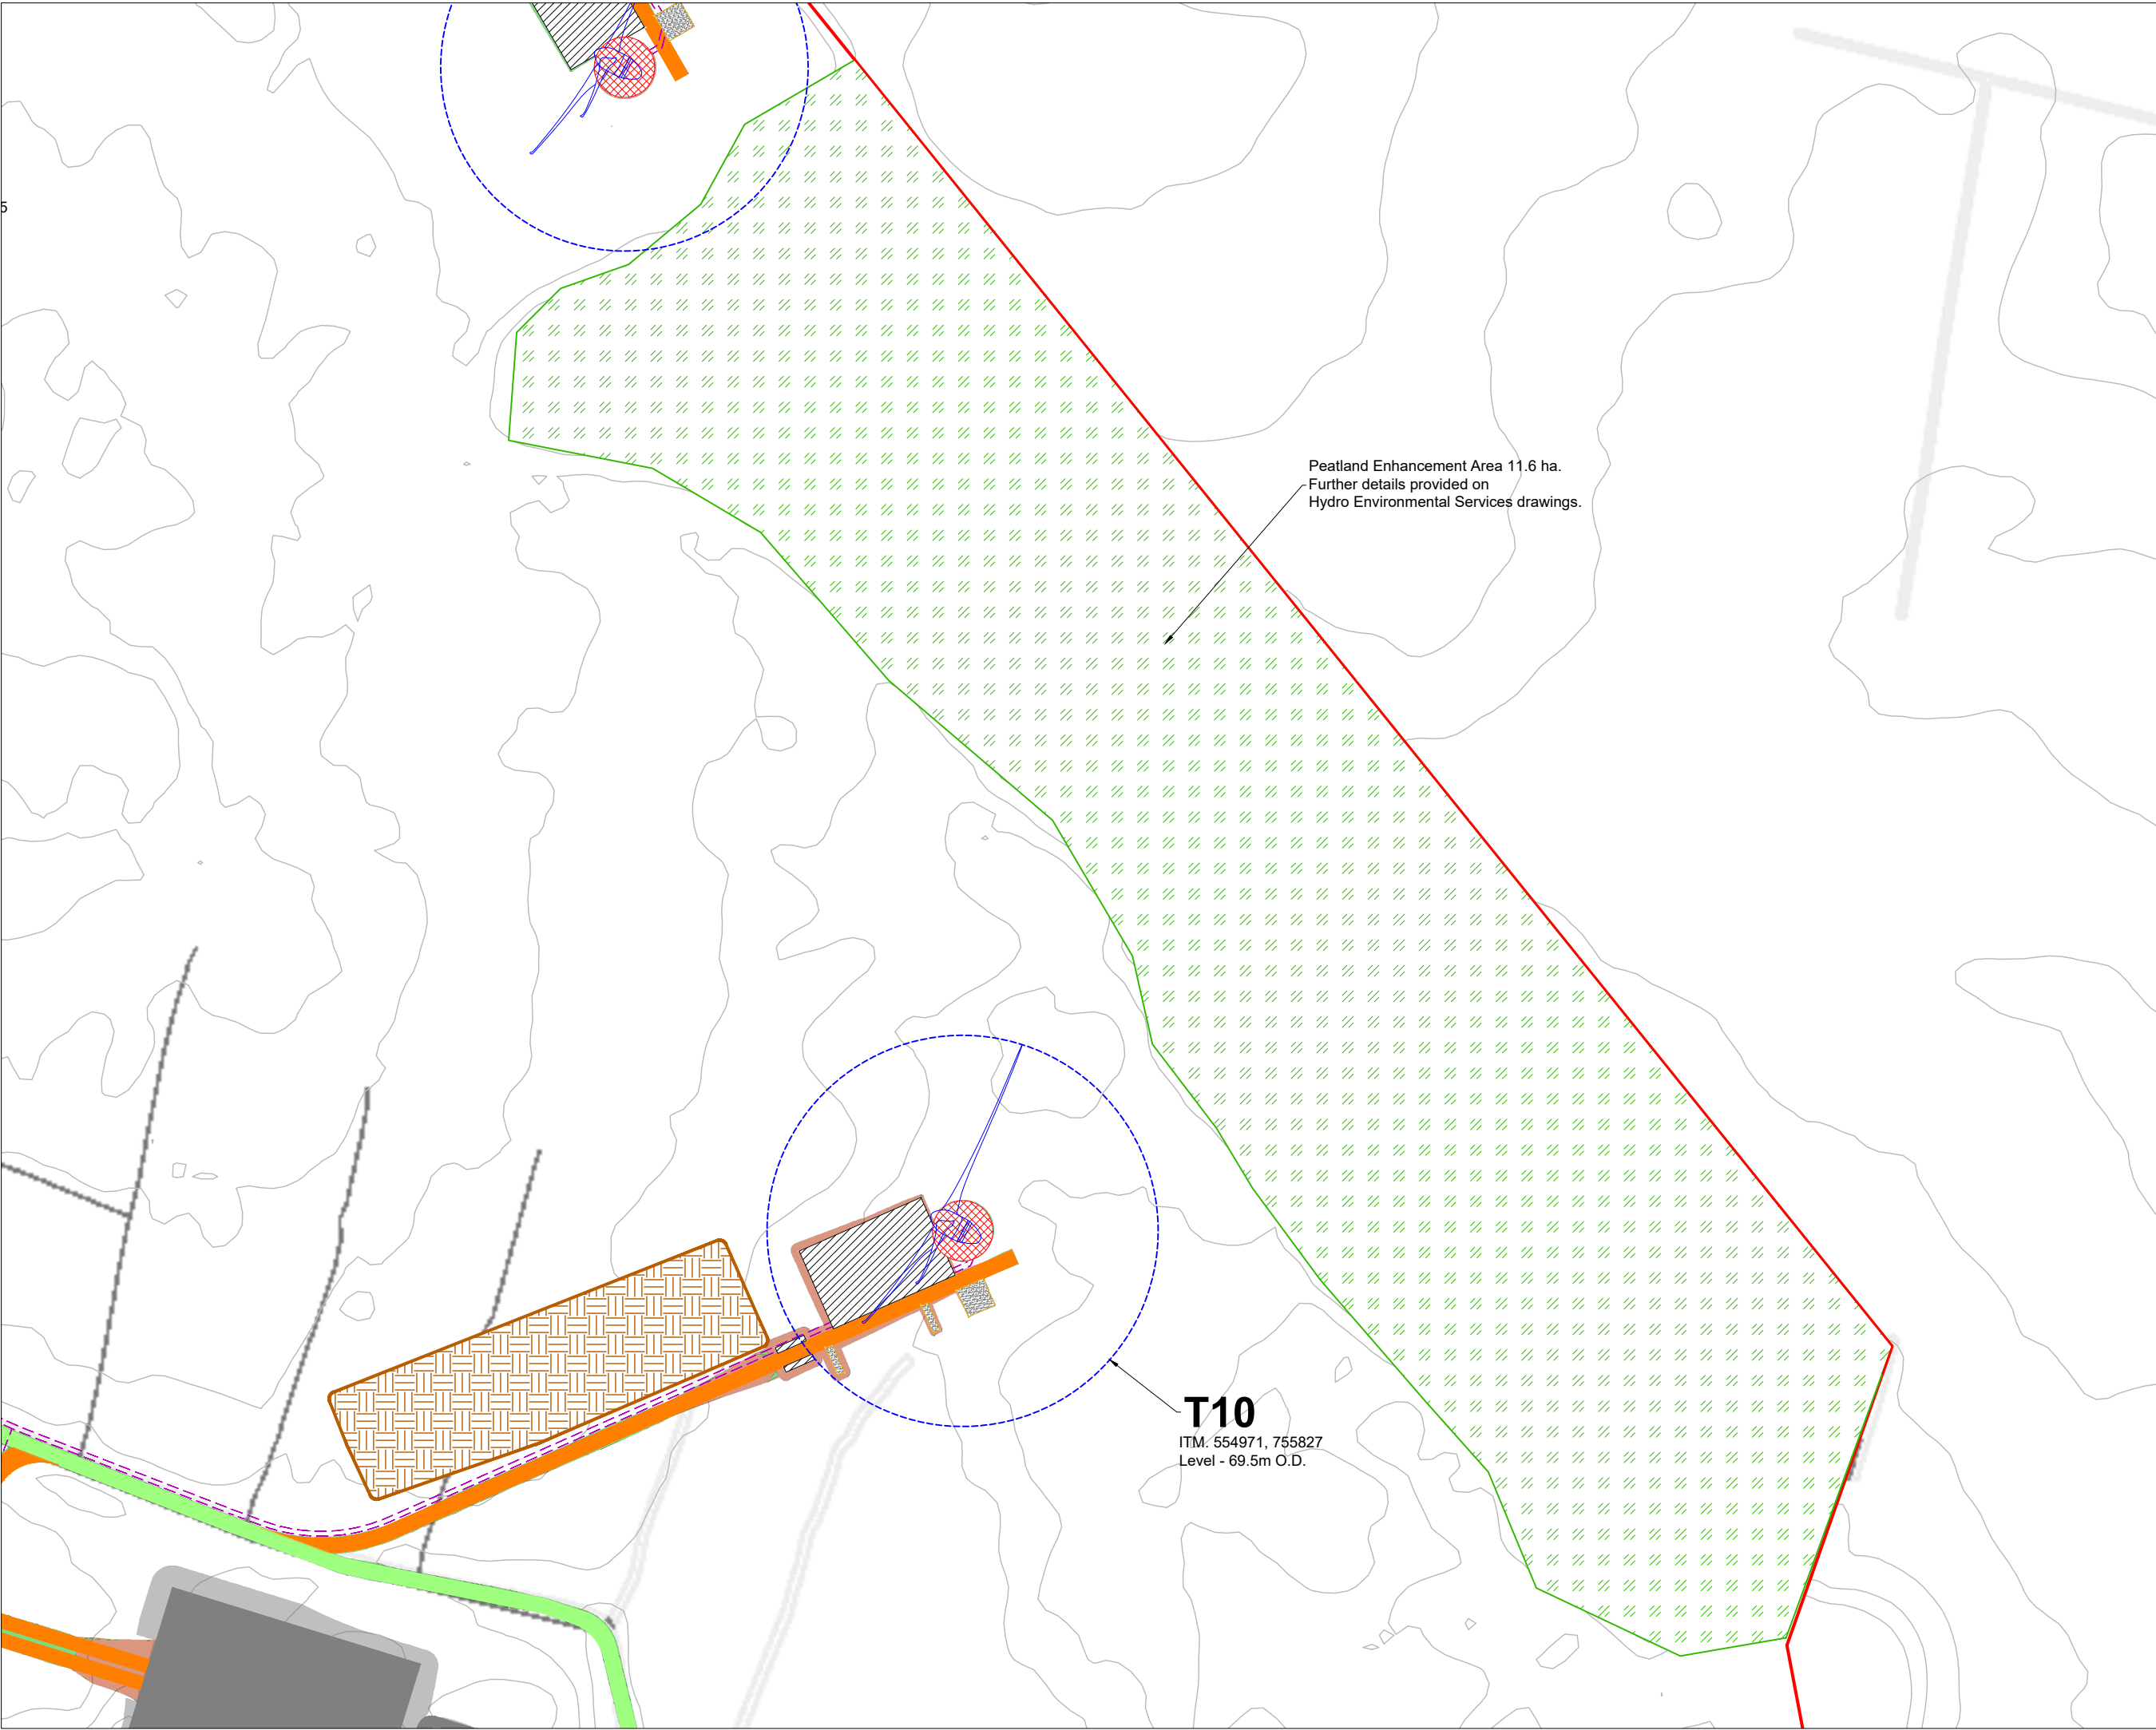

5

Peatland Enhancement Area 11.6 ha.
Further details provided on
Hydro Environmental Services drawings.

T10
ITM: 554971, 755827
Level - 69.5m O.D.

- Project Design Drawing Notes**
1. Drawings issued are for planning application purposes only.
 2. Drawings not to be used for construction/contract conditions.
 3. Copyright, all rights reserved. No part herewith may be copied or reproduced partially or wholly in any form whatsoever without the prior notice of the copyright owner McCarthy Keville O'Sullivan.
 4. Do not scale off this drawing. Figured metric dimensions only should be taken off this drawing.
 5. All contractors, whether main or sub-contractors, must visit the site and are responsible for taking and checking any and all dimensions and levels that relate to the works.
 6. The use of or reliance upon this drawing shall be deemed to be acceptance of these conditions of use unless otherwise agreed in writing, such written agreement to be sought from and issued by the copyright holder to the use or reliance upon this drawing.
 7. Layout plans show Turbine rotor diameter as per turbine drawing.
 8. Final levels may vary depending on local ground conditions.

Drawing Legend

- Planning Application Boundary
- Existing Road to be Upgraded
- Proposed Road
- Electrical Cable Trench
- Soft Levelled Area
- Crane Pad Hardstanding Area
- Turbine Foundation
- Turbine Sweep Area
- Cut
- Fill
- Peatland Enhancement Area
- Peat Repository Area
- Area Part of Separate Application



Ordnance Survey Ireland Licence No. CYAL50267517© Ordnance Survey Ireland/ Government of Ireland


DRAWING TITLE:
Peatland Enhancement Area

PROJECT TITLE:
Clonberne Wind Farm FI, Co. Galway


DRAWING BY: JOB	CHECKED BY: AC
PROJECT No.: 180740	DRAWING No.: 180740 - 33FI
SCALE: 1:2,500 @ A3	DATE: 02.12.2025

OS SHEET 250, 2541, 2542, 2543, 2544, 2607, 2608, 2609, 2610, 2611, 2677, 2678, 2679, 2680, 2681, 2746, 2747, 2748, 2749, 2750, 2814, 2815, 2816, 2817, 2818


MKO
Planning and
Environmental
Consultants
Tuam Road, Galway
Ireland, H91 VW84
+353 (0) 91 735611
email: info@www.mkoireland.ie
Website: www.mkoireland.ie

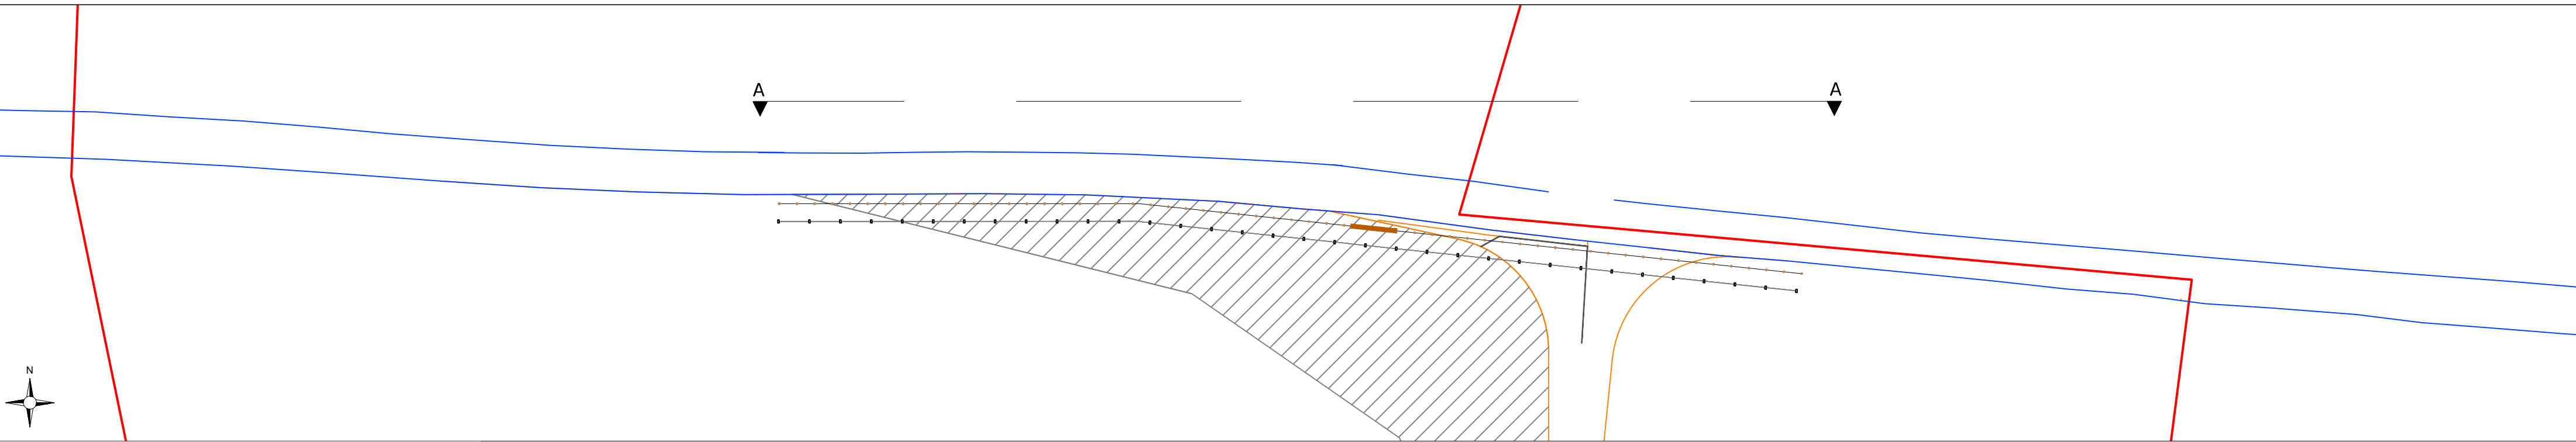


- Drawing Legend:**
- Application Boundary
 - Temporary Fencing
 - Field Gate
 - Stock Proof Fencing
 - Access Road
 - Transport Runover Area
 - Existing Road Edge

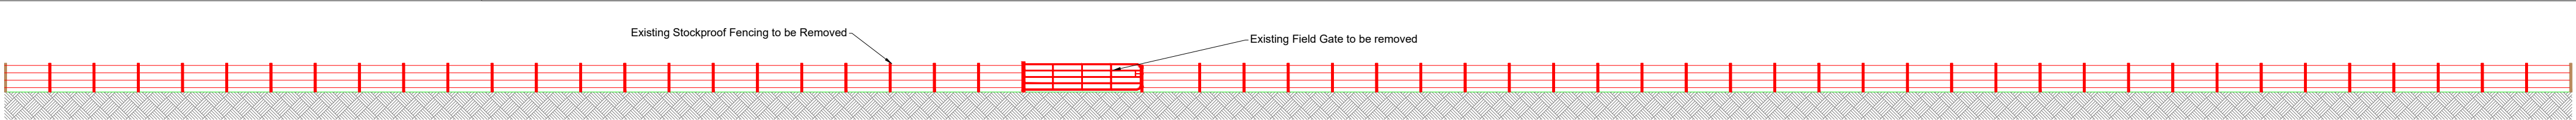


Fencing and Field Gate to be removed during construction

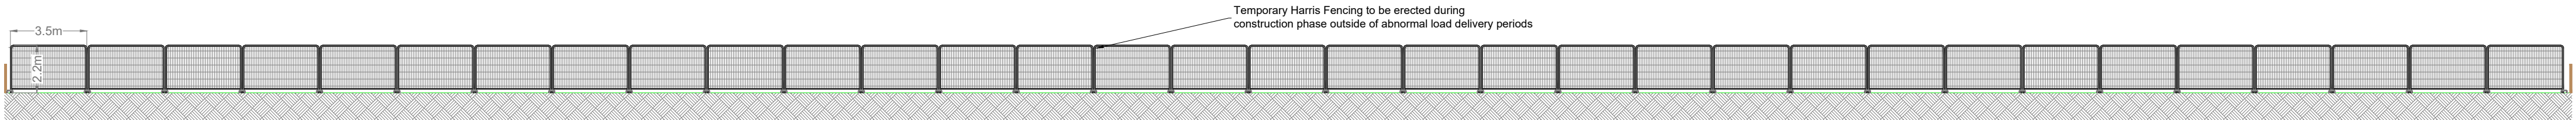

Temporary Fencing during construction

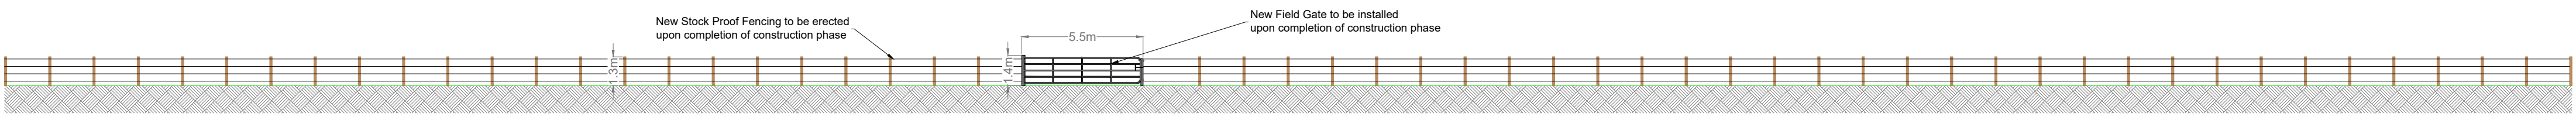

Fencing and Field Gate to be reinstated post construction

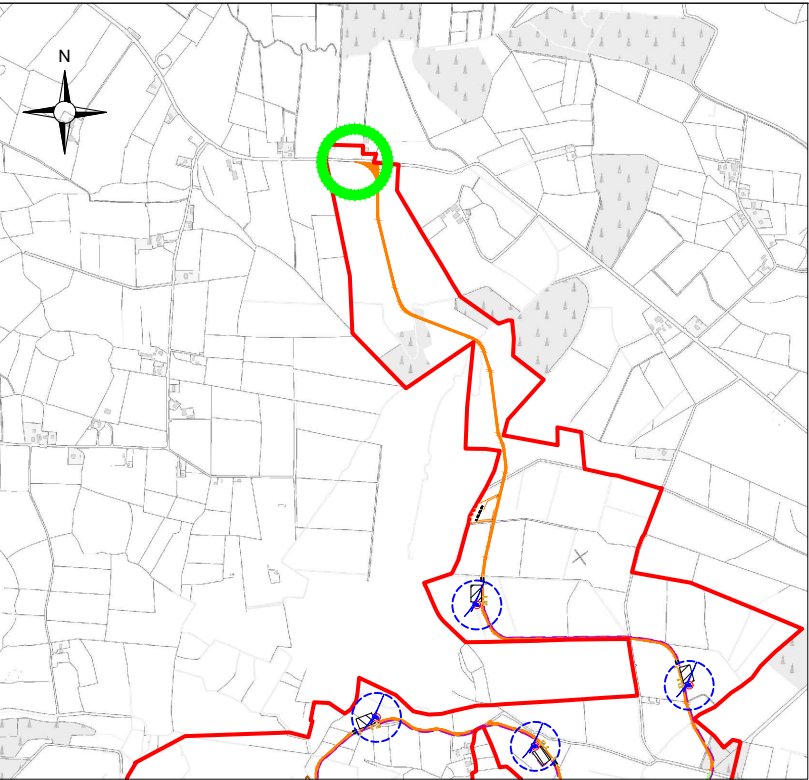

1:25,000 Location on Context Map

DRAWING TITLE:
Junction A Boundary Treatment Plan

PROJECT TITLE:
Clonberne Wind Farm FI, Co. Galway

DRAWING BY:
JOB

CHECKED BY:
AC





PROJECT No.:
180740

DRAWING No.:
180740 - 48FI


SCALE:
1:500 @ A2

DATE:
03.12.2025


MKO
Planning and Environmental Consultants
Tuum Road, Galway
Ireland, H91 VW84
+353 (0) 91 735611
email: info@www.mkoireland.ie
Website: www.mkoireland.ie

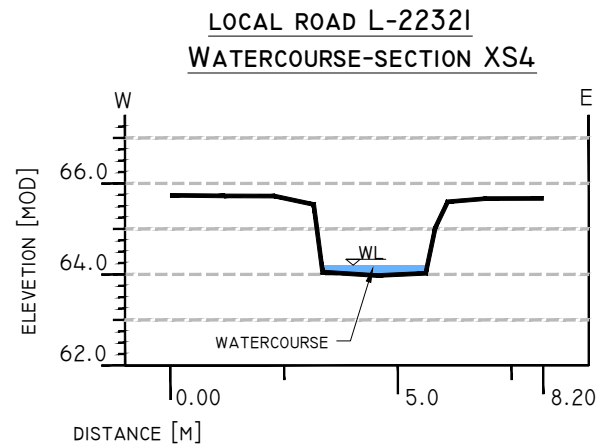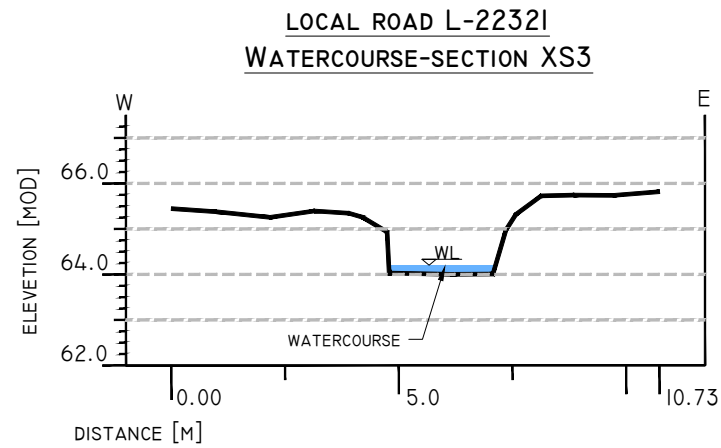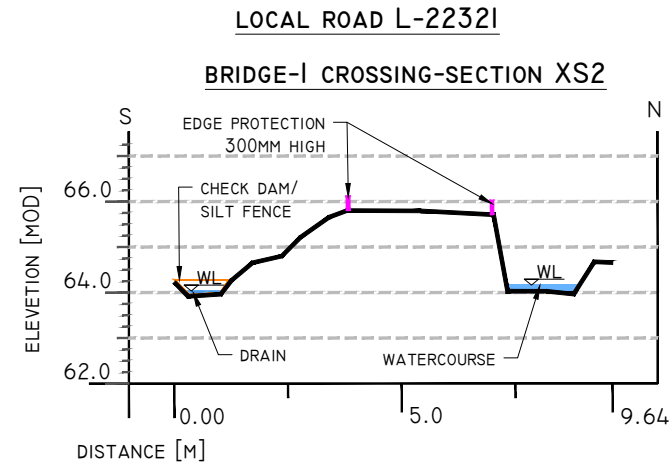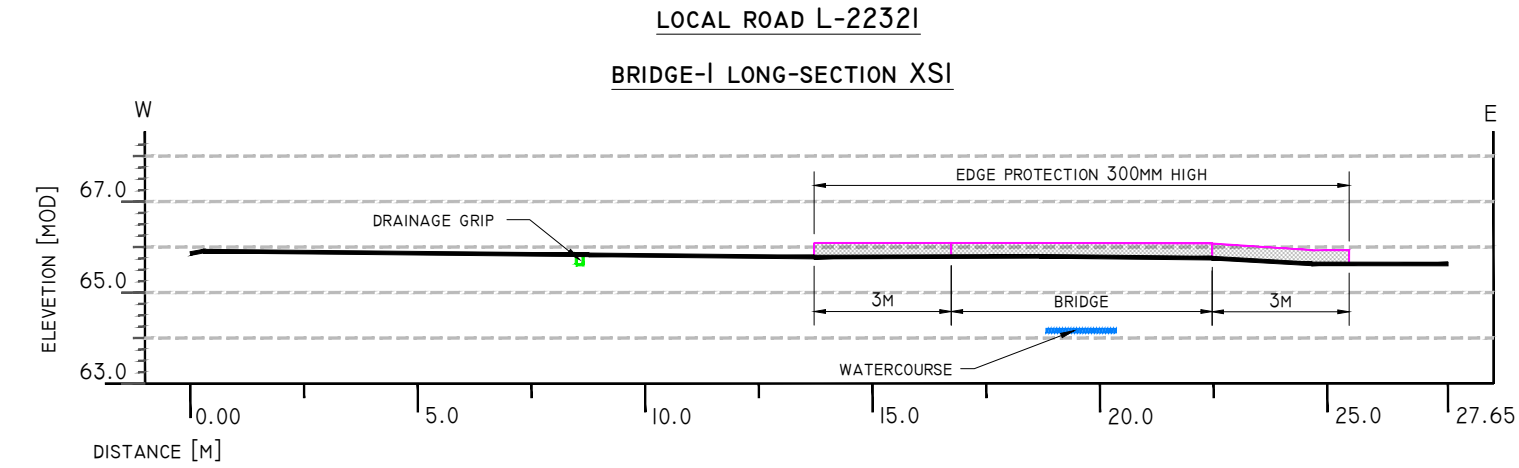

KEY PLAN

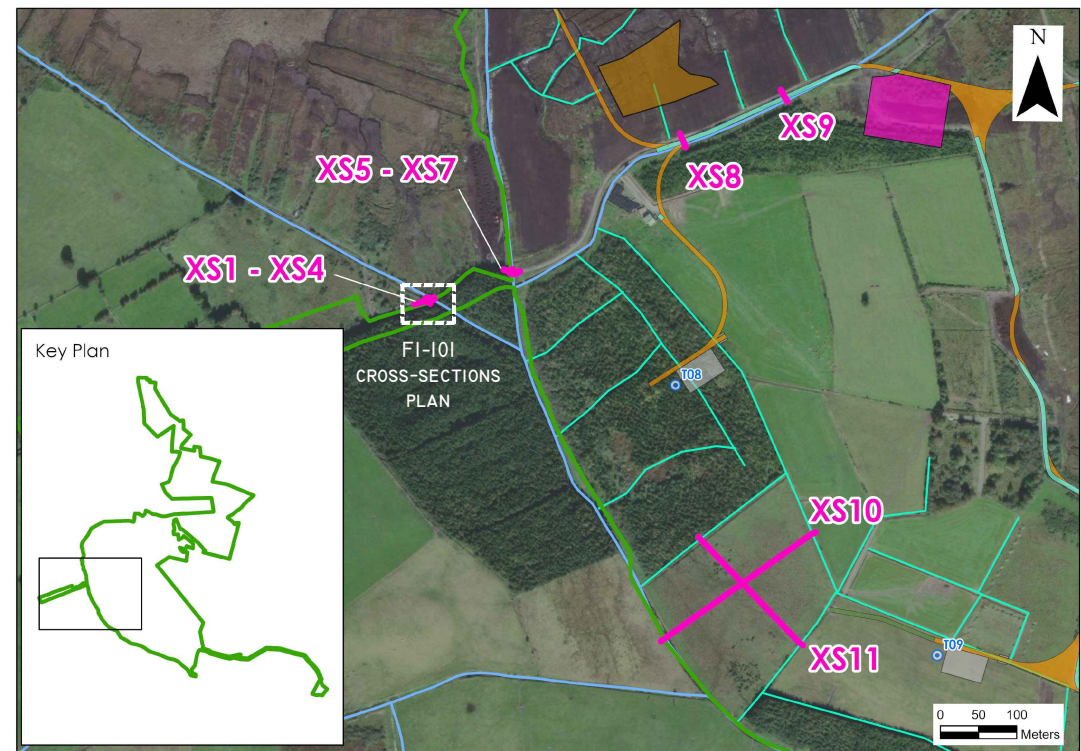

FI-I01 CROSS-SECTIONS PLAN

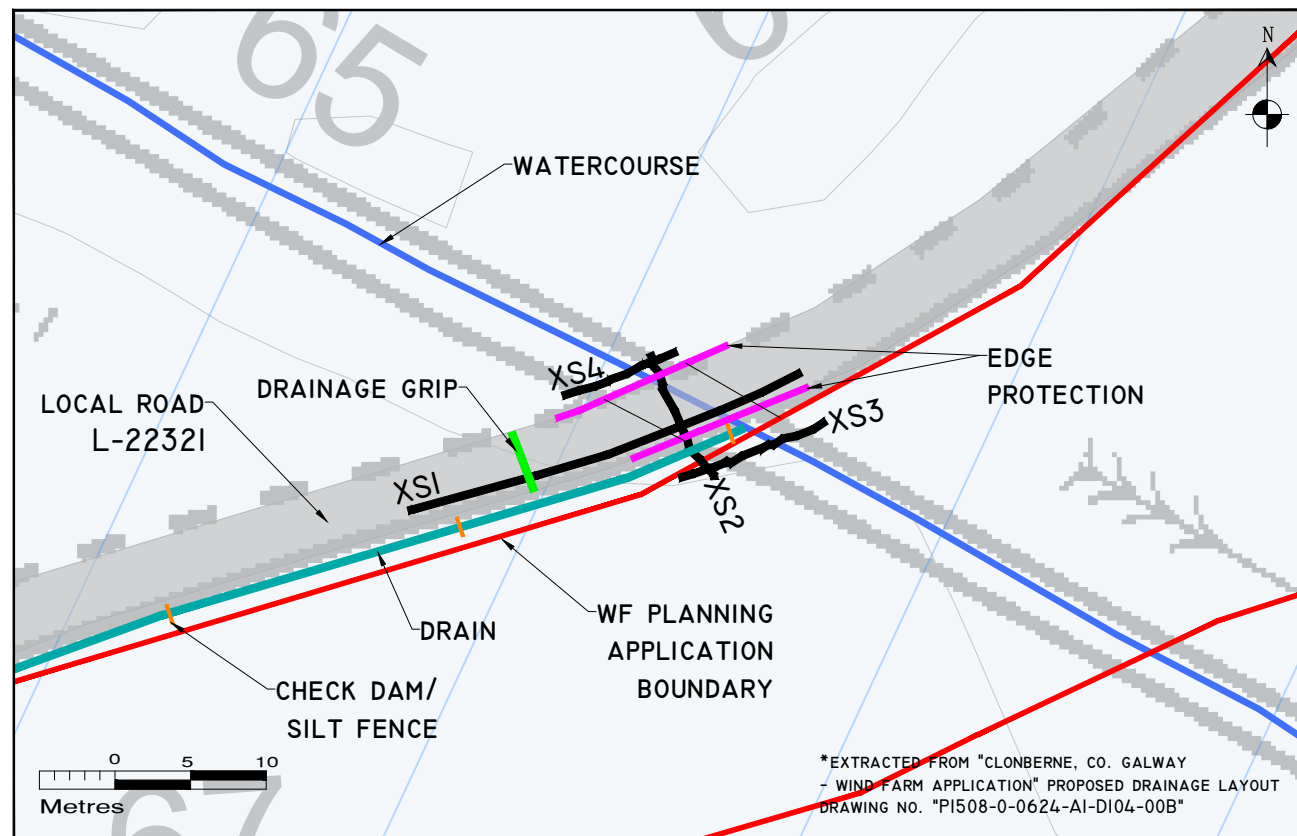

- DRAWING NOTES
1. DRAWINGS ISSUED ARE FOR PLANNING APPLICATION PURPOSES ONLY.
 2. COPYRIGHT, ALL RIGHTS RESERVED. NO PART HERE WITH MAY BE COPIED OR REPRODUCED PARTIALLY OR WHOLLY IN ANY FORM WHATSOEVER WITHOUT THE PRIOR NOTICE OF THE COPYRIGHT OWNER HYDRO-ENVIRONMENTAL SERVICES.
 3. DO NOT SCALE OFF THIS DRAWING. FIGURED METRIC DIMENSIONS ONLY SHOULD BE TAKEN OFF THIS DRAWING.
 4. ALL DIMENSIONS ARE IN METRES.

Ordnance Survey Ireland Licence No. EN 0044725
© Ordnance Survey Ireland/Government of Ireland

Date	Description	Chkd	Signed

HYDRO ENVIRONMENTAL SERVICES

22 Lower Main St
Dungarvan
Co. Waterford
Ireland

tel: +353 (0) 58-44122
tel: +353 (0) 58-44244
email: info@hydroenvironmental.ie
web: www.hydroenvironmental.ie

Client: MKO


Job: CLONBERNE WF, CO. GALWAY
- FI RESPONSE

Title: LOCAL ROAD L-2232I
AND BRIDGE-I CROSS-SECTIONS
SHEET 1 OF 4


Figure No: FI-I01

Drawing No: P1508-2-1125-A3-FI-I01-00A	
Sheet Size: A3	Project No.: P1508-2
Scale: As shown(A3)	Drawn By: GA
Date: 03/11/2025	Checked By: MG


LOCAL ROAD L-2232I
BRIDGE-2 LONG-SECTION XS5

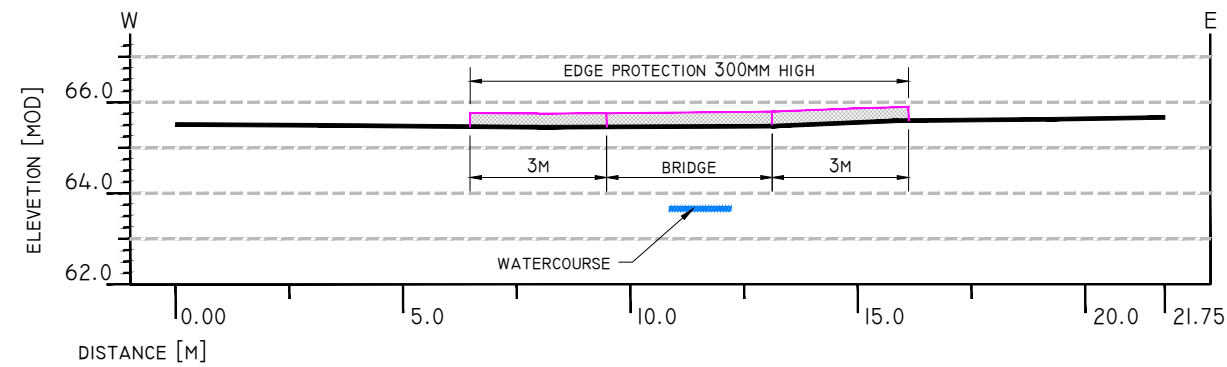


LOCAL ROAD L-2232I
BRIDGE-2 CROSS-SECTION XS6

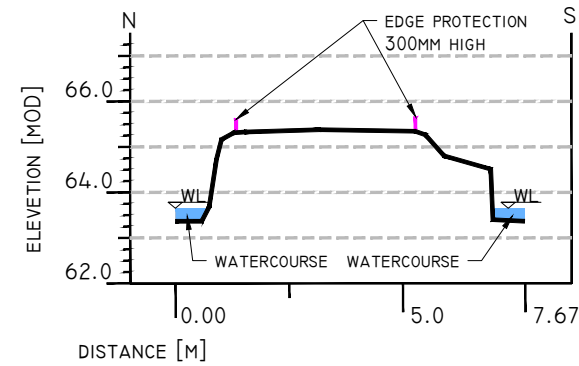


LOCAL ROAD L-2232I
WATERCOURSE CROSS-SECTION XS7

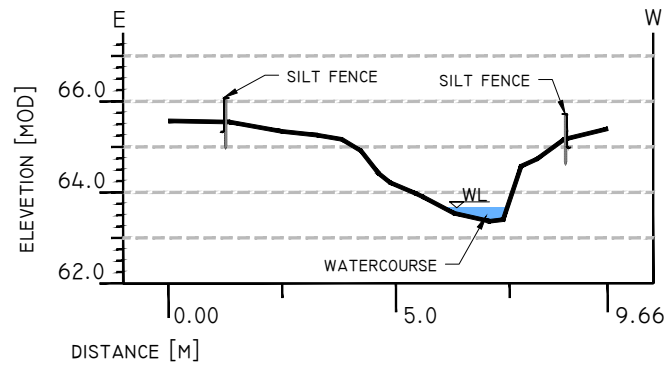

KEY PLAN

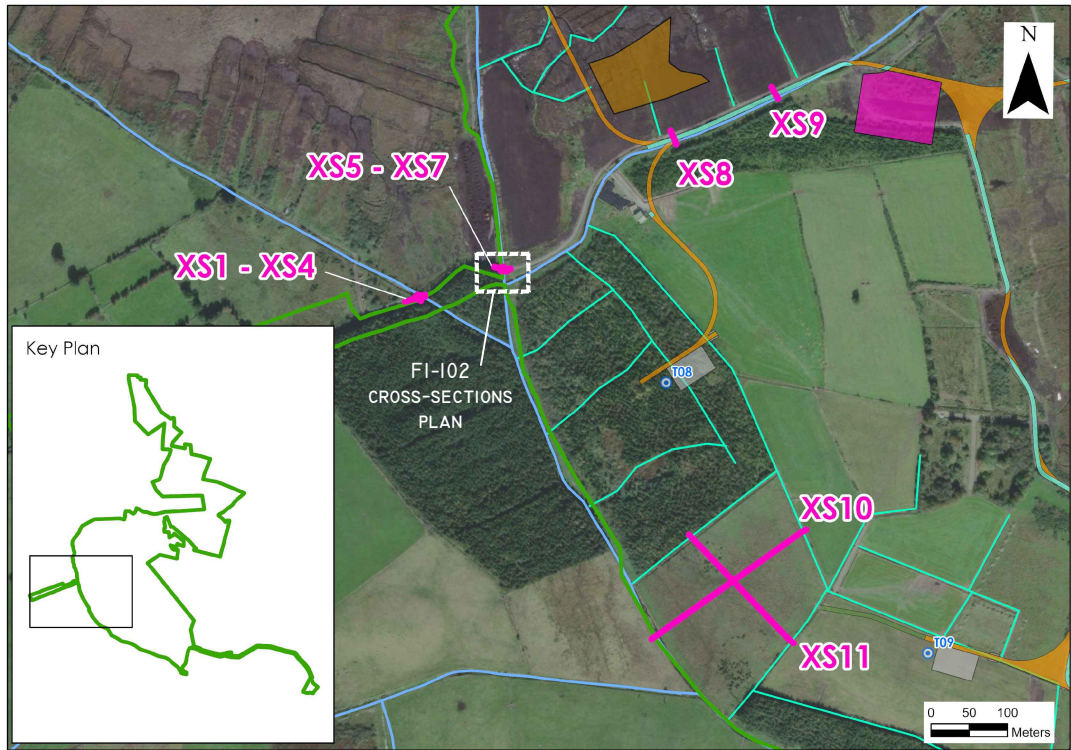

FI-102 CROSS-SECTIONS PLAN

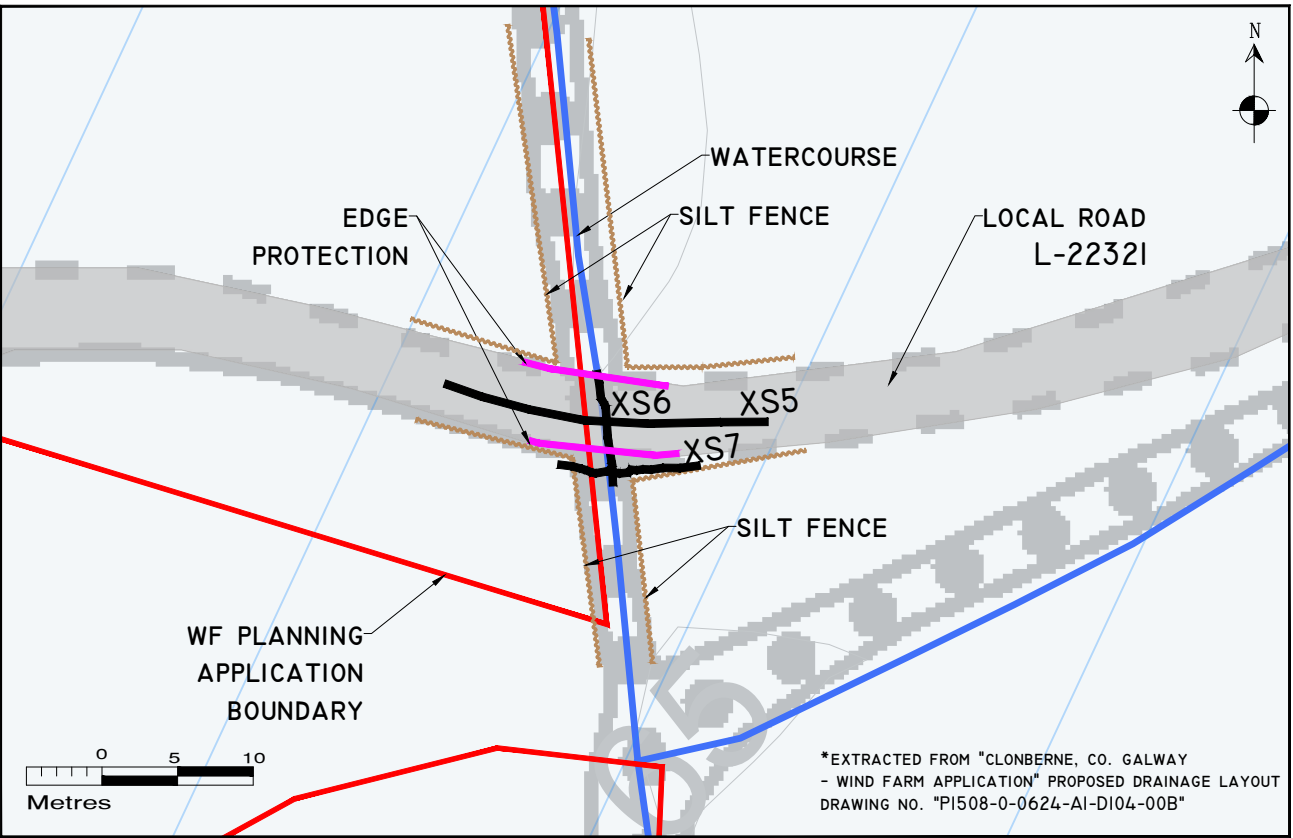

- DRAWING NOTES**
1. DRAWINGS ISSUED ARE FOR PLANNING APPLICATION PURPOSES ONLY.
 2. COPYRIGHT, ALL RIGHTS RESERVED. NO PART HERE WITH MAY BE COPIED OR REPRODUCED PARTIALLY OR WHOLLY IN ANY FORM WHATSOEVER WITHOUT THE PRIOR NOTICE OF THE COPYRIGHT OWNER HYDRO-ENVIRONMENTAL SERVICES.
 3. DO NOT SCALE OFF THIS DRAWING. FIGURED METRIC DIMENSIONS ONLY SHOULD BE TAKEN OFF THIS DRAWING.
 4. ALL DIMENSIONS ARE IN METRES.

Ordnance Survey Ireland Licence No. EN 0044725
© Ordnance Survey Ireland/Government of Ireland

Date	Description	Chkd	Signed
Revisions			

HYDRO ENVIRONMENTAL SERVICES

22 Lower Main St
Dungarvan
Co. Waterford
Ireland

tel: +353 (0) 58-44122
tel: +353 (0) 58-44244
email: info@hydroenvironmental.ie
web: www.hydroenvironmental.ie

Client: MKO

Job: CLONBERNE WF, Co. GALWAY
- FI RESPONSE


Title: LOCAL ROAD L-2232I
AND BRIDGE-2 CROSS-SECTIONS
SHEET 2 OF 4

Figure No: FI-102

Drawing No: P1508-2-1125-A3-FI-102-00A	
Sheet Size: A3	Project No.: P1508-2
Scale: As shown(A3)	Drawn By: GA
Date: 03/11/2025	Checked By: MG


EXISTING ROAD PROPOSED TO BE UPGRADED

CROSS-SECTION XS8

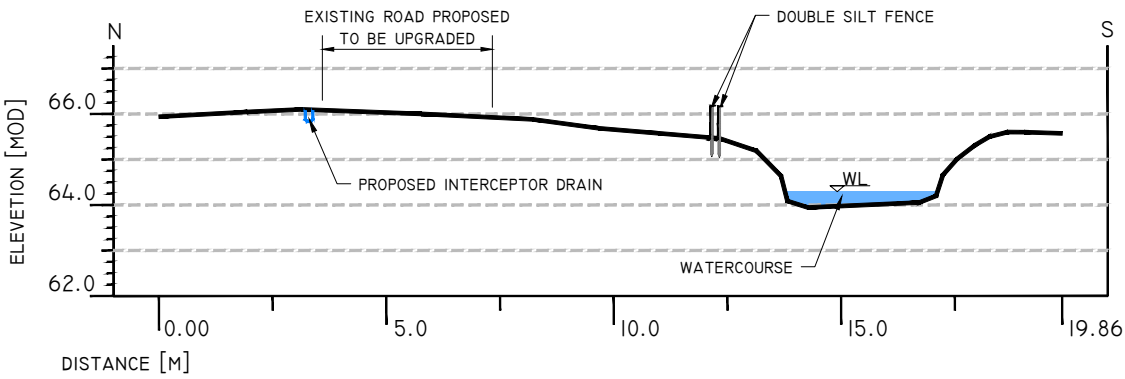


EXISTING ROAD PROPOSED TO BE UPGRADED


CROSS-SECTION XS9

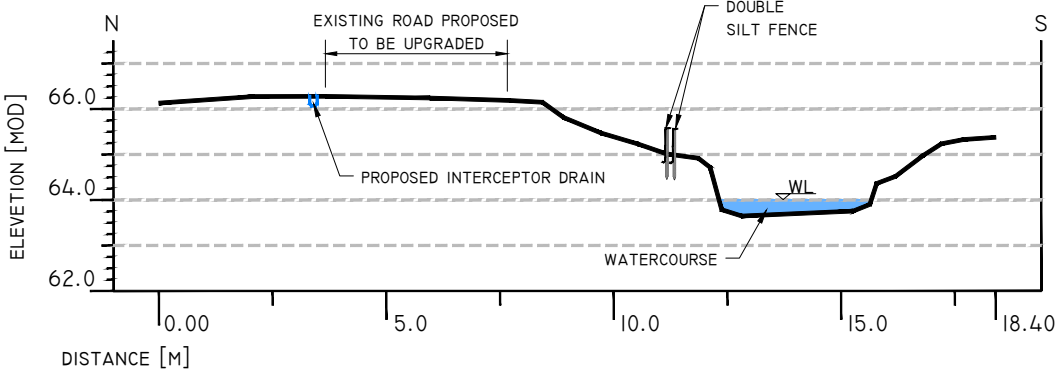

KEY PLAN

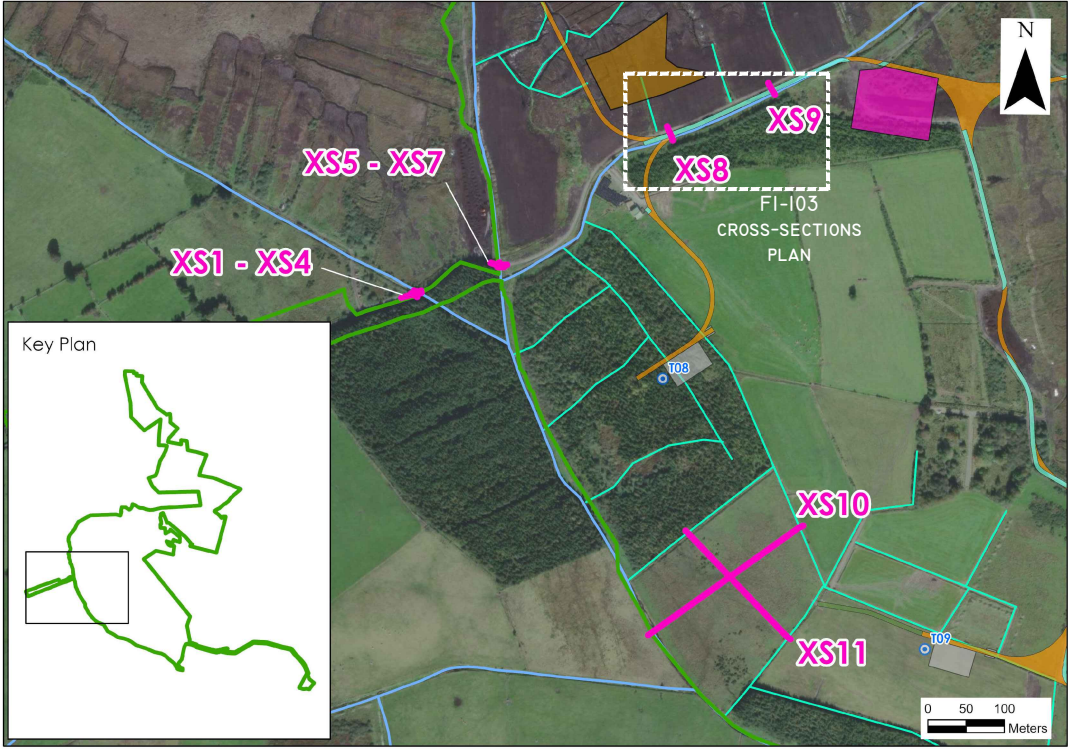

FI-103 CROSS-SECTIONS PLAN

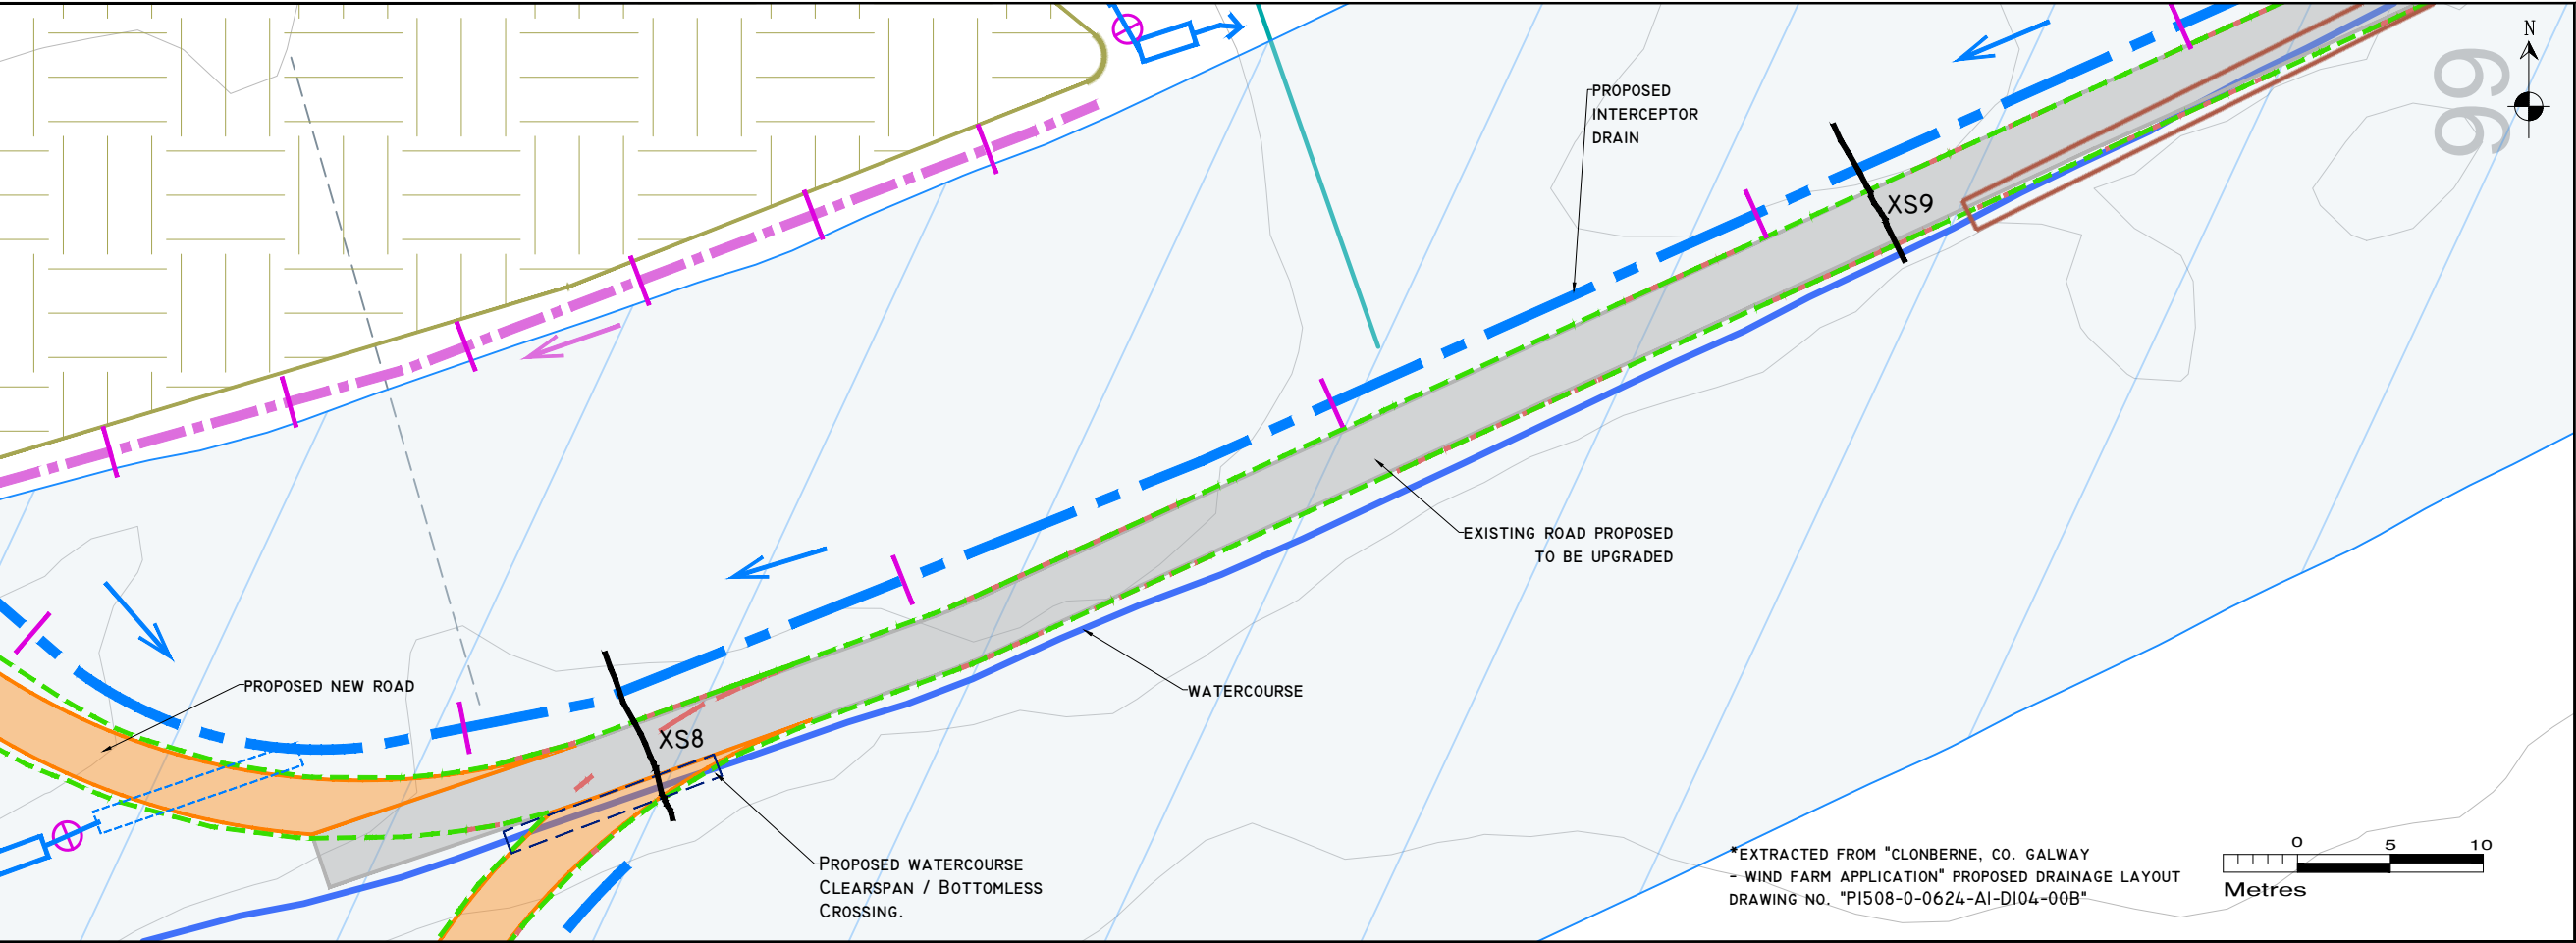

- DRAWING NOTES**
1. DRAWINGS ISSUED ARE FOR PLANNING APPLICATION PURPOSES ONLY.
 2. COPYRIGHT, ALL RIGHTS RESERVED. NO PART HERE WITH MAY BE COPIED OR REPRODUCED PARTIALLY OR WHOLLY IN ANY FORM WHATSOEVER WITHOUT THE PRIOR NOTICE OF THE COPYRIGHT OWNER HYDRO-ENVIRONMENTAL SERVICES.
 3. DO NOT SCALE OFF THIS DRAWING. FIGURED METRIC DIMENSIONS ONLY SHOULD BE TAKEN OFF THIS DRAWING.
 4. ALL DIMENSIONS ARE IN METRES.

Ordnance Survey Ireland Licence No. EN 0044725
© Ordnance Survey Ireland/Government of Ireland

Date	Description	Chkd	Signed

HYDRO ENVIRONMENTAL SERVICES

22 Lower Main St
Dungarvan
Co. Waterford
Ireland

tel: +353 (0) 58-44122
tel: +353 (0) 58-44244
email: info@hydroenvironmental.ie
web: www.hydroenvironmental.ie

Client: MKO

Job: CLONBERNE WF, CO. GALWAY
- FI RESPONSE

Title: EXISTING ROAD PROPOSED
TO BE UPGRADED CROSS-SECTIONS
SHEET 3 OF 4

Figure No: FI-103

Drawing No: P1508-2-1125-A3-FI-103-00A	Project No.: P1508-2
Sheet Size: A3	Drawn By: GA
Scale: As shown(A3)	Checked By: MG
Date: 03/11/2025	

EXISTING DRAIN

SPOIL STORAGE AREA

SILT FENCE

XS11

XS10

PROPOSED SPOIL STORAGE AREA

DRAINAGE DITCH

LEVALLY STREAM

WF PLANNING APPLICATION BOUNDARY

PROPOSED COLLECTOR DRAIN

LAND DRAIN

SILT FENCE

TW

SP

0.88

0

25

50

Metres

*EXTRACTED FROM "CLONBERNE, CO. GALWAY
- WIND FARM APPLICATION" PROPOSED DRAINAGE LAYOUT
DRAWING NO. "PI508-0-0624-AI-DI05-00C"

Ordnance Survey Ireland Licence No. EN 0044725
© Ordnance Survey Ireland/Government of Ireland

HYDRO ENVIRONMENTAL SERVICES

22 Lower Main St
Dungarvan
Co. Waterford
Ireland

tel: +353 (0) 58-44122
tel: +353 (0) 58-44244
email: info@hydroenvironmental.ie
web: www.hydroenvironmental.ie

Job: CLONBERNE WF, CO. GALWAY
- FI RESPONSE

Figure No: FI-104

Sheet Size: A3	Project No.: P1508-2
----------------	----------------------

Scale: As shown(A3)	Drawn By: GA
---------------------	--------------

Date: 03/11/2025	Checked By: MG
------------------	----------------