



**Roof Plan**  
1:100

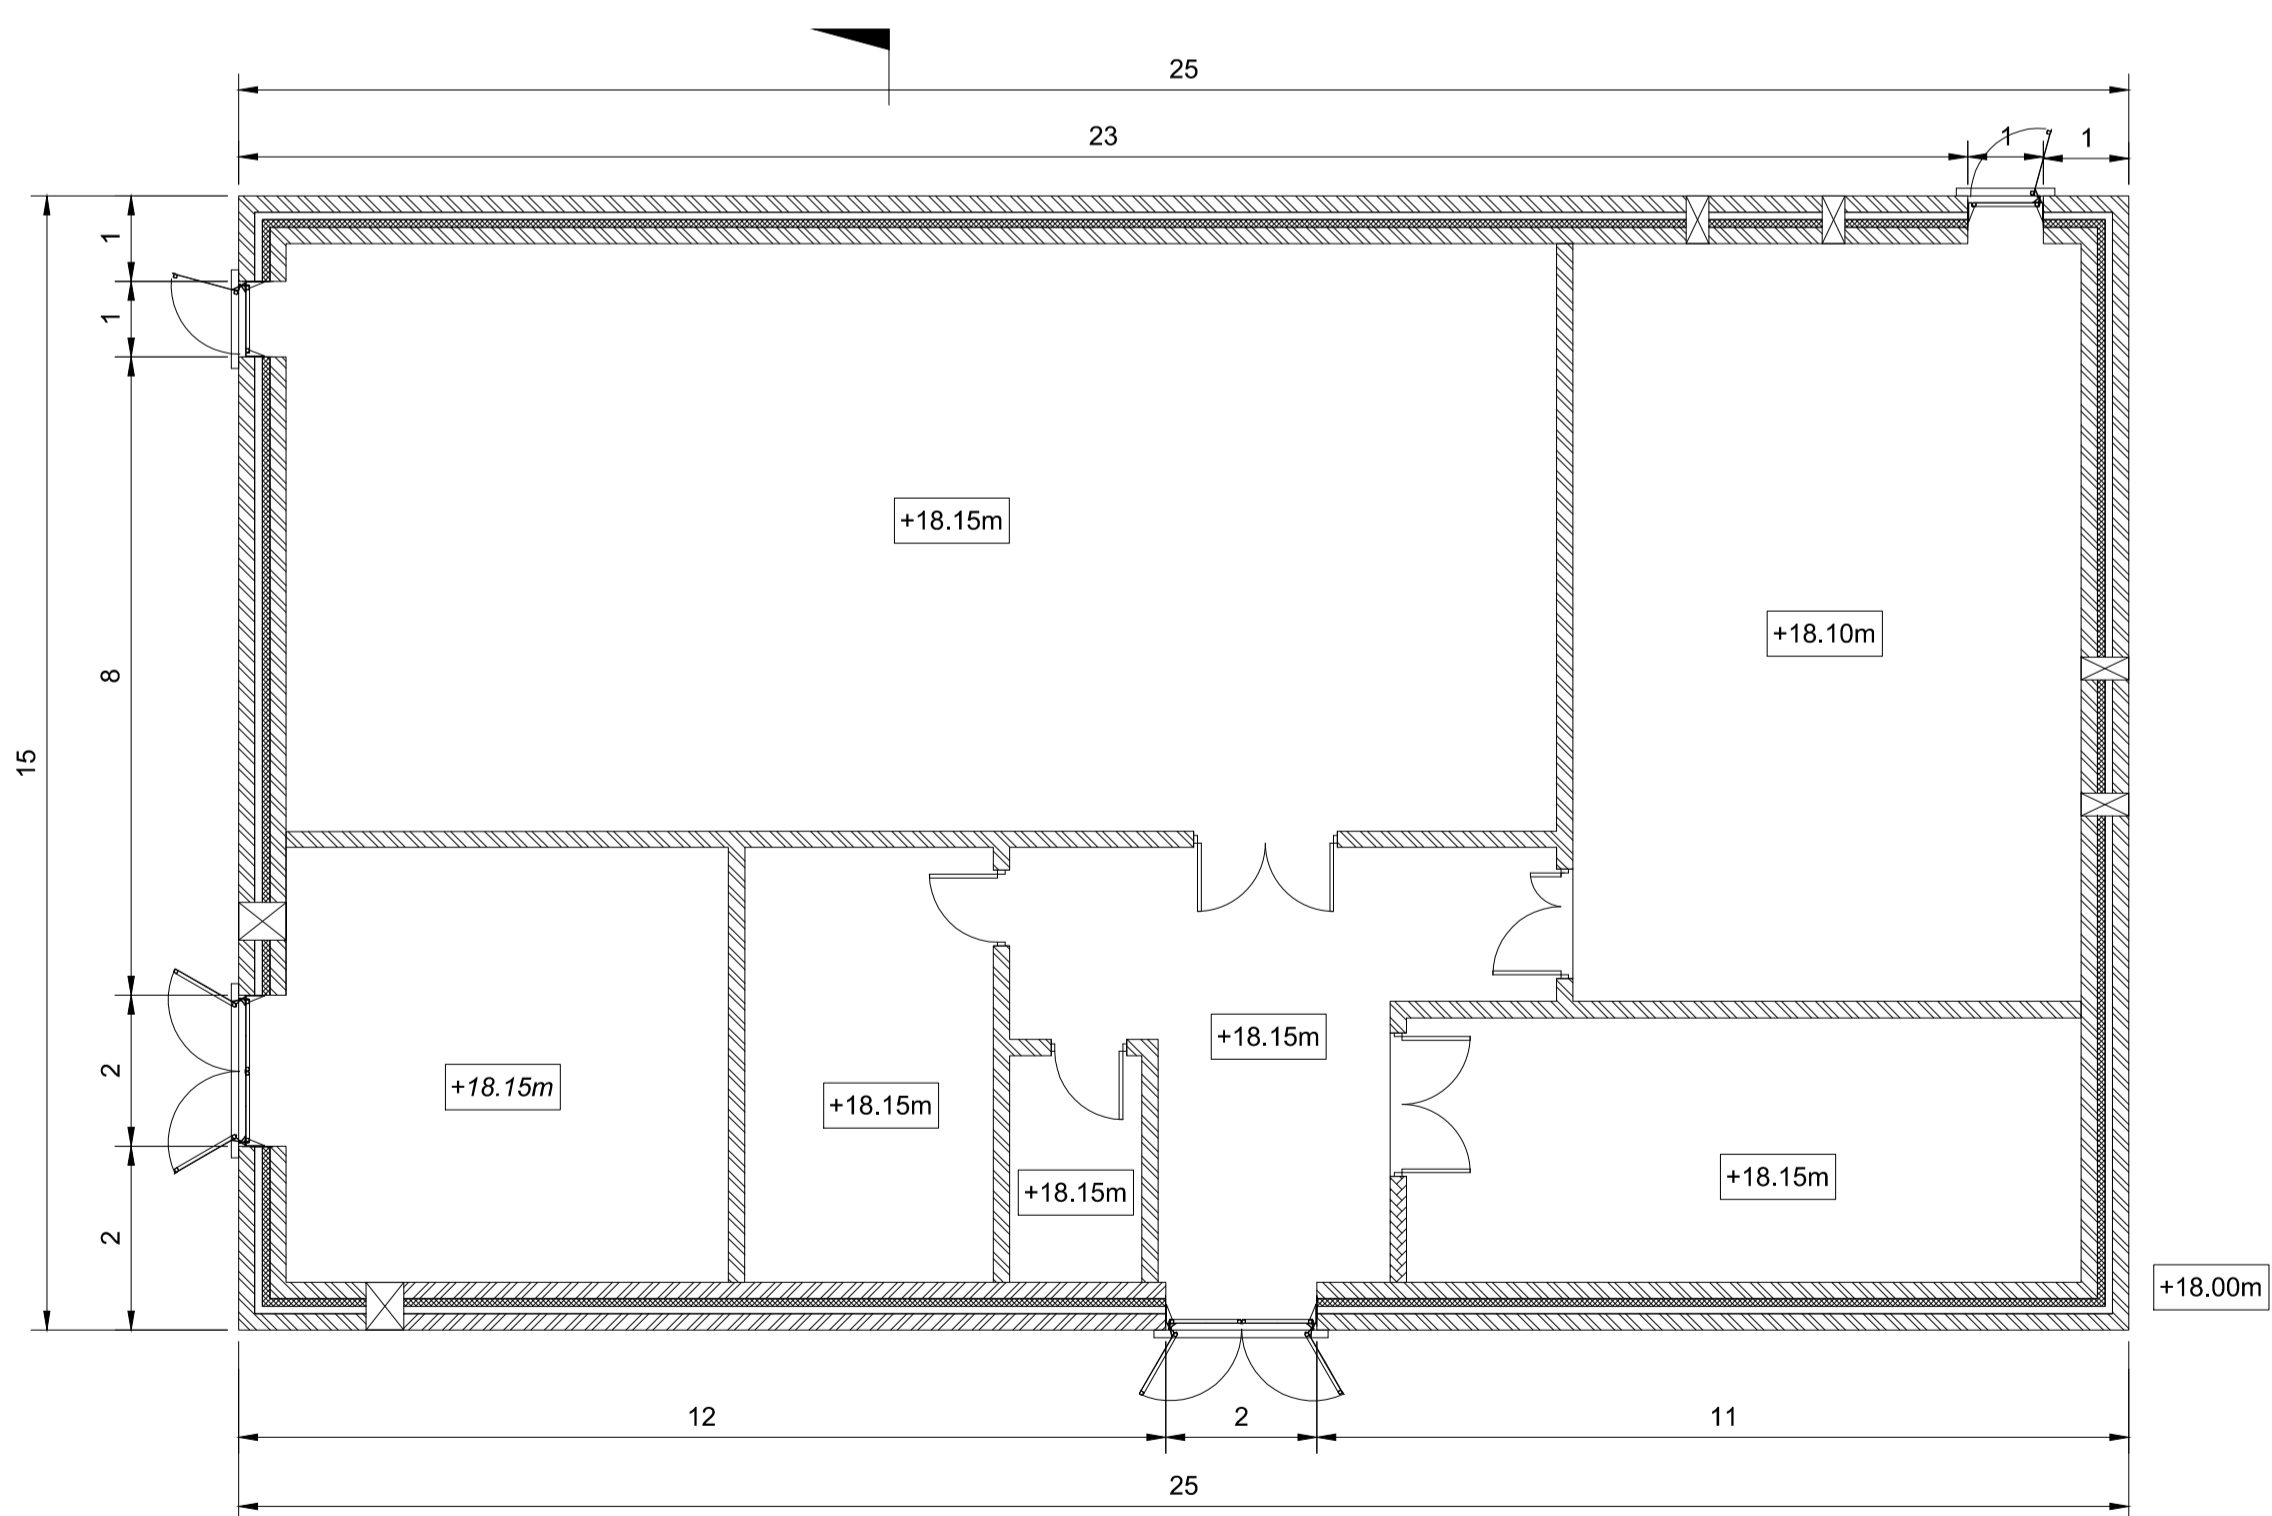


**Ground Floor Plan**  
1:100

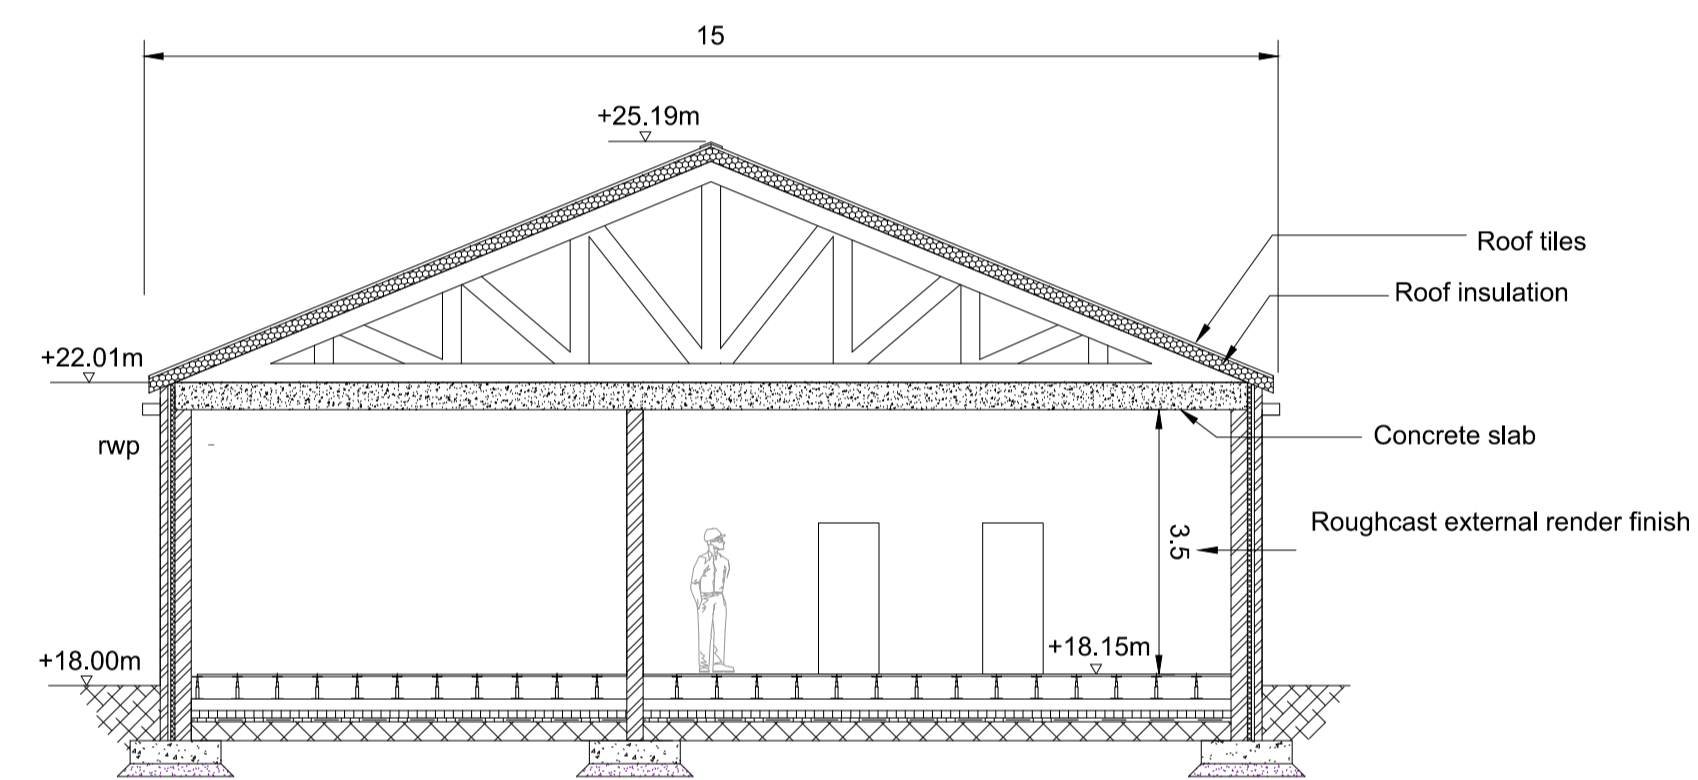

**Section A**  
1:100

- Notes**
1. For planning purposes only. Not for construction.
  2. All dimensions are in metres unless otherwise noted.
  3. Where levels are shown, all levels are in metres above Malin Head datum.

**Key to symbols**

 

**Reference drawings**

- 229100428-MMD-00-XX-DR-E-1100 Site Location Map - Key Plan
- 229100428-MMD-00-XX-DR-E-2998 Converter Station Compound Overall Site Layout
- 229100428-MMD-00-XX-DR-E-3037 Converter Station Compound 400kV Control Building - Elevations

Rev	Date	Drawn	Description	Ch'k'd	App'd
PL1	25/06/2021	SHY	Issued for Planning	DH	TK

**MOTT MACDONALD**

South Block  
Rockfield  
Dundrum  
Dublin 16  
Ireland  
T +353 (0)1 291 6700  
F  
W www.mottmac.com



**Title**  
Celtic Interconnector  
Converter Station  
400kV Control Building  
Plan and Section

Designed	I. Eustace	Eng check	D. Hassett
Drawn	B. Zulueta	Coordination	D. Monaghan
Dwg check	D. Monaghan	Approved	T. Keane

Scale at A1	Status	Rev	Security
1:100	APR	PL1	STD

Drawing Number  
**229100428-MMD-00-XX-DR-E-3036**