


FOUL/COMBINED SEWER									
NAME	CL	EL	L	DST	FALL	PIPE	DEPTH		
NO	m	m	m	m	%	DIAMETER	mm		
EX.F1A	28.100	27.450	27.530	22.800	44.7	225	1.070		
EX.F2	28.000	28.010	27.700	50.4	225	1.150			
EX.F3	28.000	28.010	27.700	50.4	225	1.150			
EX.F4	28.500	24.912	23.310	11.900	22.0	225	2.440		
EX.C1	24.700	23.183	22.710	16.000	22.0	225	1.960		
EX.C2	21.830	20.955	20.050	38.800	22.0	225	1.780		
EX.C3	21.700	21.381	18.800	38.100	31.0	300	1.800		
EX.S18	19.750	18.260	18.260	28.200	130.0	300	1.470		
EX.S19	19.500	17.990	17.990	28.000	130.0	300	1.600		
SM.F1	19.550	17.929	17.929	6.100	100.0	300	1.621		
SM.F2	19.225	17.791	17.700	4.200	100.0	300	2.025		
S4	19.550	17.601	17.544	14.300	200.0	300	1.956		

SW SEWER

ASHFORD

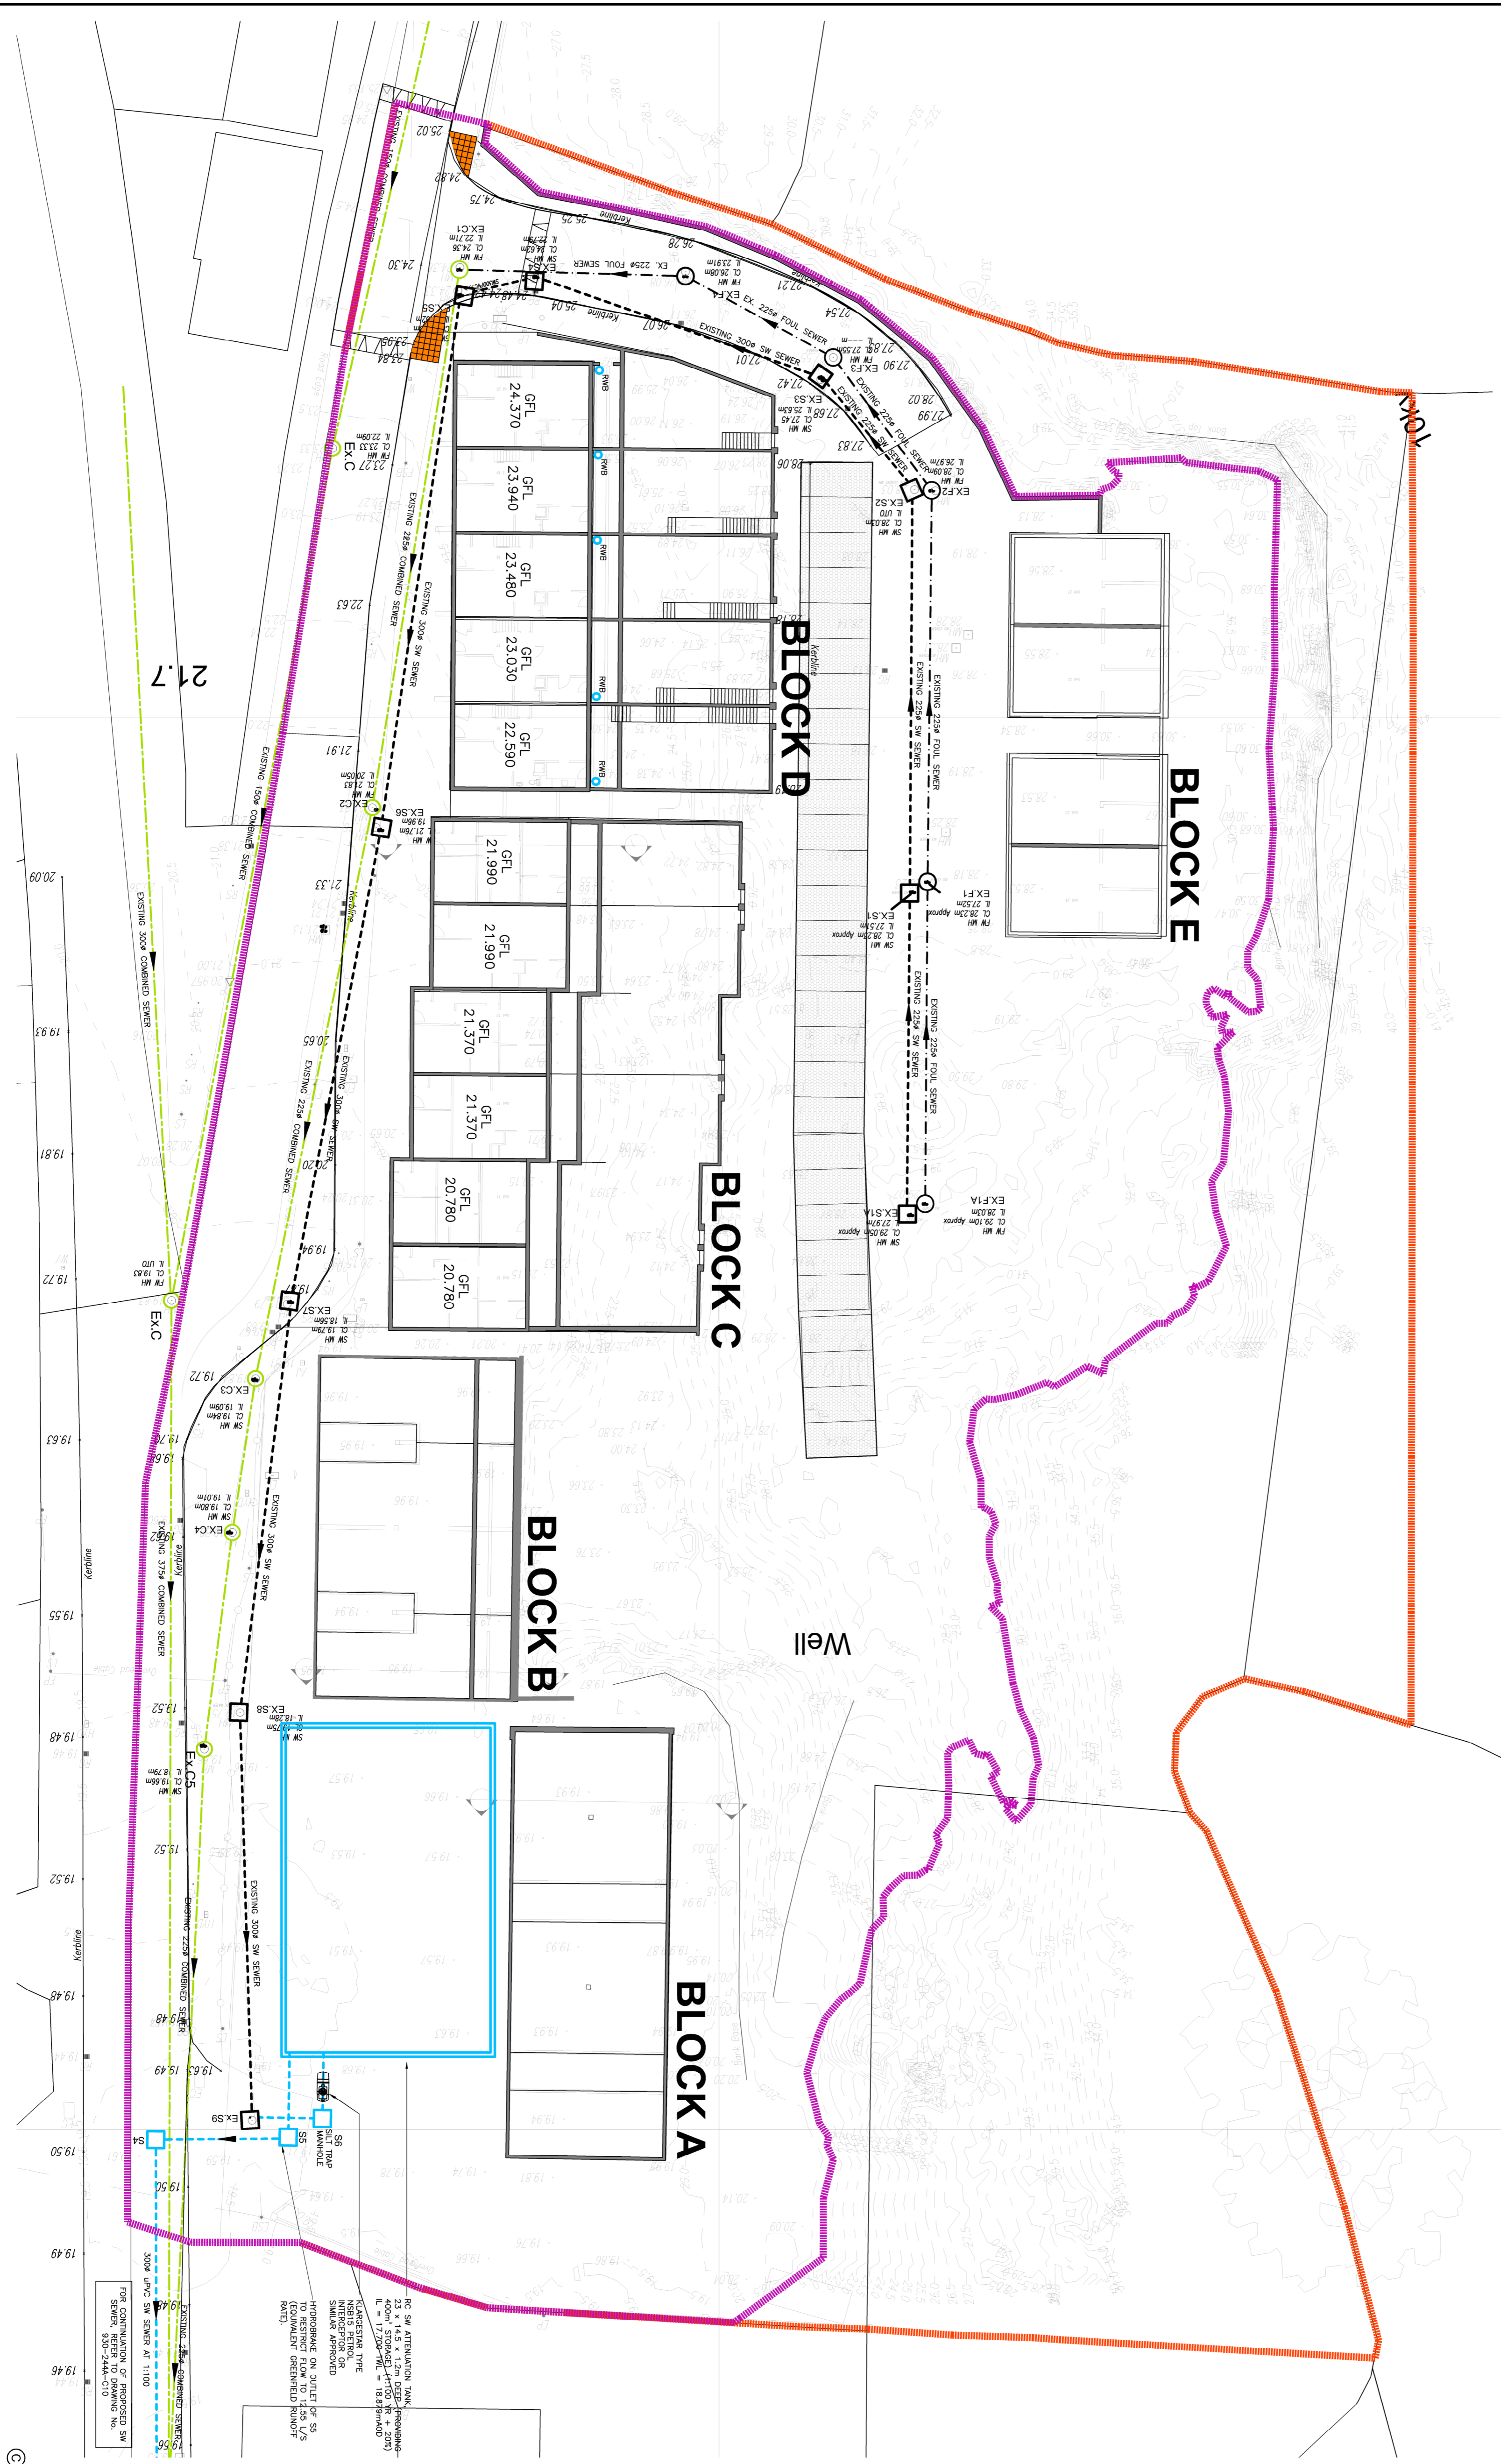

NOTES

MOLONY MILLAR CONSULTING CIVIL & STRUCTURAL ENGINEERS OF THE CONSULTANTS AND MUST NOT BE REPRODUCED WITHOUT THEIR WRITTEN CONSENT.

ALL DIMENSIONS REMAIN THE PROPERTY OF THE CONSULTANTS. FIGURED DIMENSIONS ONLY TO BE TAKEN FROM THIS DRAWING. ALL DIMENSIONS TO BE CHECKED ON SITE. CONSULTANTS TO BE INFORMED OF ANY DISCREPANCIES BEFORE WORK PROCEEDS.

DRAINAGE LEGEND:

- PROPOSED SURFACE WATER PIPE
- PROPOSED SURFACE WATER MANHOLE
- PROPOSED ROAD GULLY
- PROPOSED RW BURTS TO THE REAR OF ALL RESIDENTIAL RW01'S
- PROPOSED PERMEABLE PAVINGS
- EXISTING SURFACE WATER PIPE
- EXISTING SURFACE WATER MANHOLE
- EXISTING SURFACE WATER PIPE
- PROPOSED FOUL WATER PIPE
- PROPOSED FOUL WATER MANHOLE
- EXISTING FOUL PIPE
- EXISTING FOUL MANHOLE
- EXISTING COMBINED WATER PIPE
- EXISTING COMBINED MANHOLE

Client	VARRY DEVELOPMENTS LTD.
Project Title	SUBSTITUTE CONSENT APPLICATION FOR THE EXISTING WORKS AT MOUNT USHER VIEW, ASHFORD, CO. WICKLOW
Drawing Title	SURFACE WATER & FOUL DRAINAGE LAYOUT PLAN
Architect	CDP ARCHITECTS
Scale	1:250@A1
Drawn by	S.DRAWINGS
Checked by	S.DRAWINGS
Date	NOV 2021
Job Number	930-244A
Drawing Number	02
Revision	A

MOLONY MILLAR
Consulting Civil and Structural Engineers
Ryebank House
Ballyvaughan Road
Rathfarnham
Dublin 14
Tel: (053-1) 4930211
Fax: (053-1) 4930215
email: info@molonymillar.ie
www.molonymillar.ie