

Location of ancillary equipment

EXISTING 1No. SUB-DUCT ROUTED TO EACH OPERATOR EQUIPMENT CABINET FROM FIBRE CHAMBER

Station 28.3

EXISTING 2No. 125mm RED U/G POWER DUCTS FROM EXISTING ESS OVERHEAD POLE TO RFE CABINET

EXISTING FIBRE INTERCONNECT DUCT TO EIR DUCT CHAMBER

EXISTING 4No. Ø150mm U/G DUCTS FOR FEEDERS C/W SLOW RADIUS BENDS AND DRAW CORDS

EXISTING 2No. 50mm RED U/G POWER DUCTS FROM VODAFONE CHAMBER TO ACCESS CHAMBER AT POLE LAD OVER EACH OTHER FOR RF ISOLATOR SWITCH

EXISTING DRAW ROPE CHAMBER WITH "D400" CHAMBER COVER

PLAN VIEW ELEVATION SCALE 1:200

STOP

Location of mast structure




STOP

AN BORD PLEANÁLA
TIME _____ BY _____
29 AUG 2018
LTR DATER _____ FROM _____
PL _____

Mark up of Signal Infrastructure Drawing issued to DLRC

SITE PLAN - SCALE 1:200 @ A3

CPR Architects	93 Upper Georges St. Dun Laoghaire, Co. Dublin	Tel: 01-2711840	Email: mail@cprarchitects.ie
Job: Section 5 Declaration - Monkstown Mast	Scale: 1:200@A3	Title: SITE PLAN	
Client: Angela O'Flainn	Date: 01.08.18	Dwg No: SEC5-002	

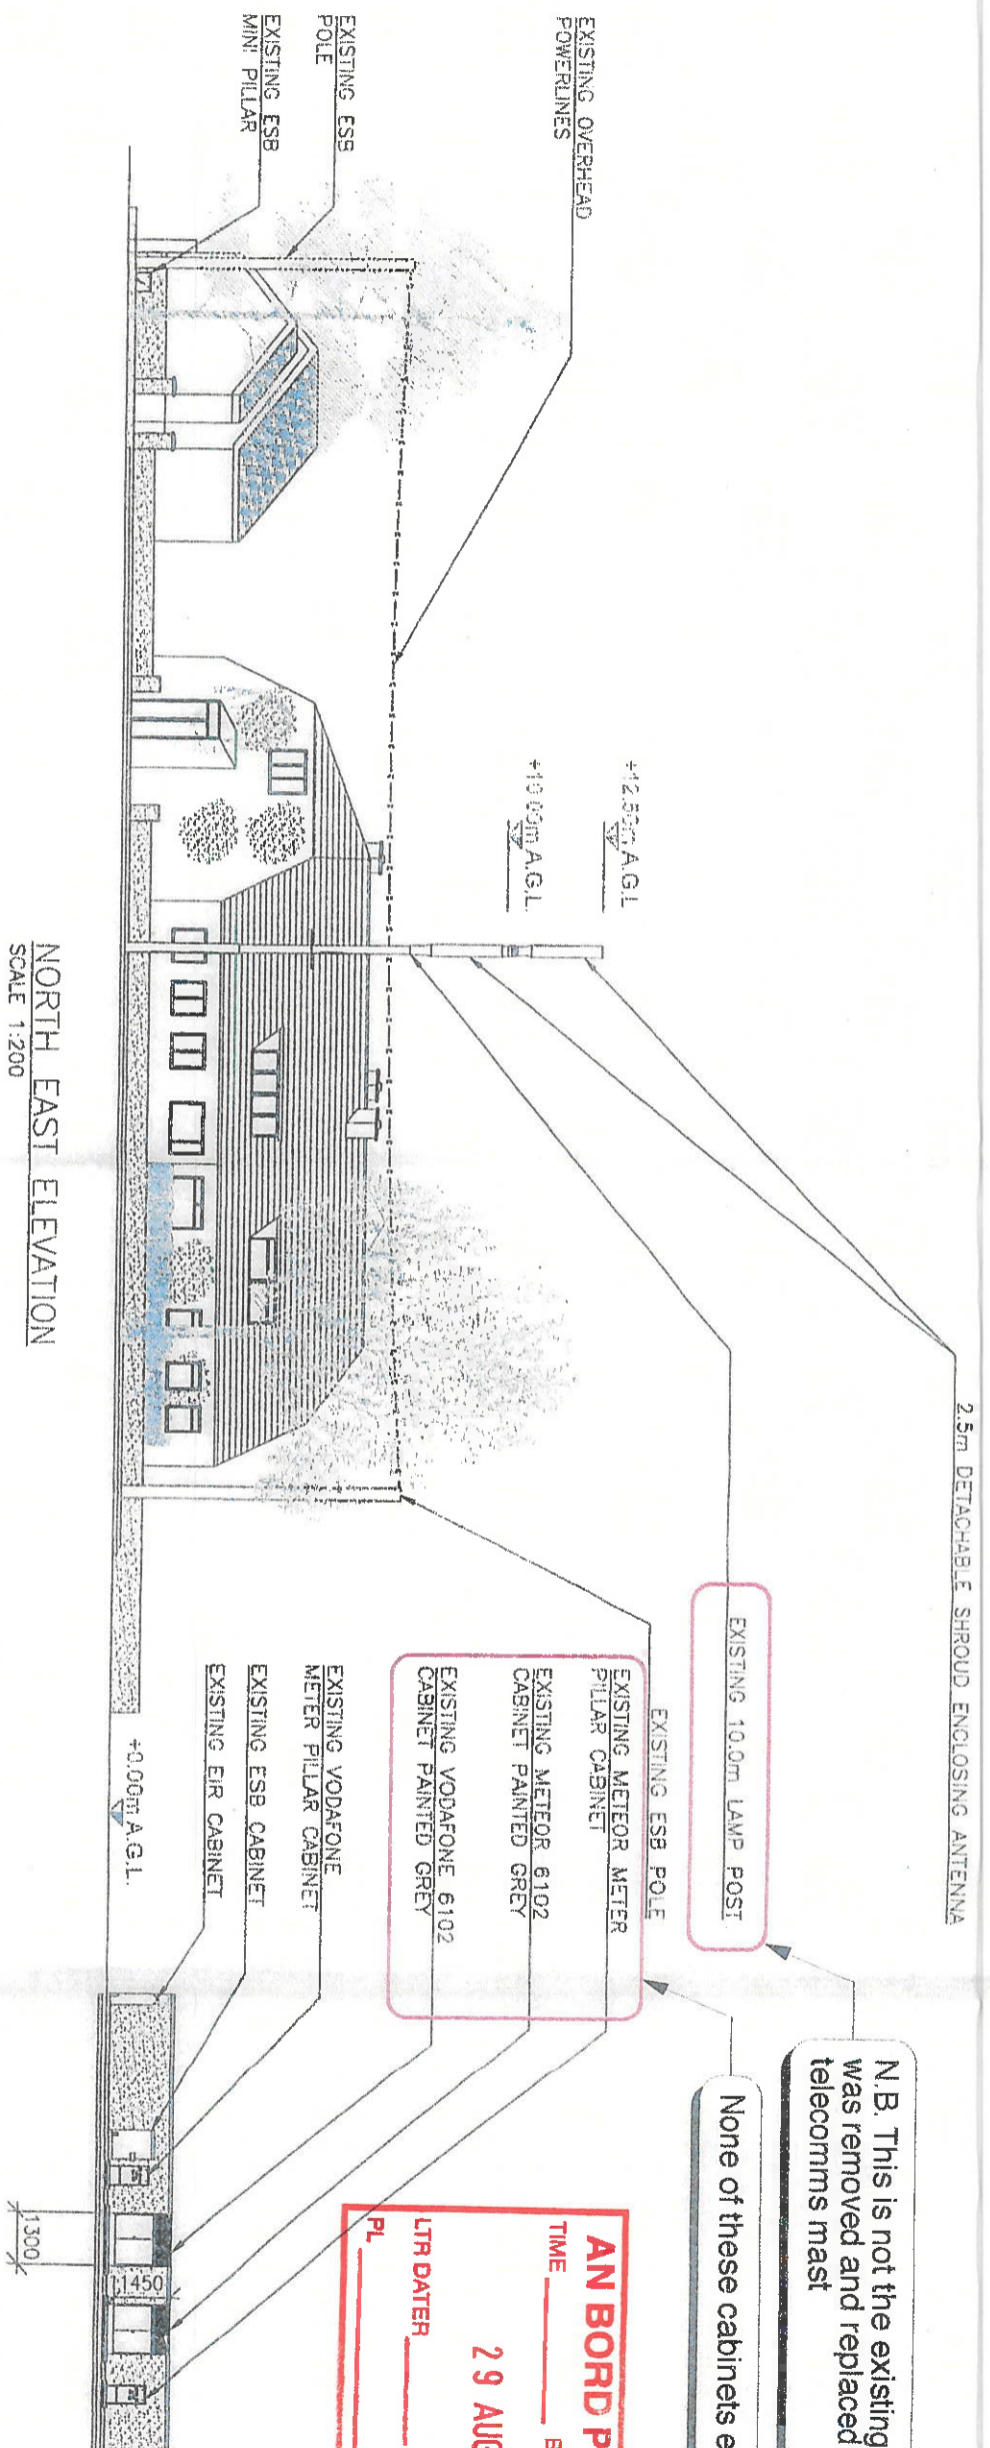

N.B. This is not the existing lamp post. This was removed and replaced with the telecomms mast


None of these cabinets existed previously

AN BORD PLEANALA
 TIME _____ BY _____
 29 AUG 2018
 LTR DATER _____ FROM _____
 PL _____

Mark up of Signal Infrastructure Drawing issued to DLRCC

ELEVATION - SCALE 1:200 @ A3

CPR Architects		93 Upper Georges St, Dun Laoghaire, Co. Dublin		Tel: 01-2711840 Email: mal@cparchitects.ie	
Job:	Section 5 Declaration - Monkstown Mast	Scale:	1:200@A3	Title:	ELEVATION
Client:	Angela O'Flolinn	Date:	01.08.18	Dwg No:	SEC5-003

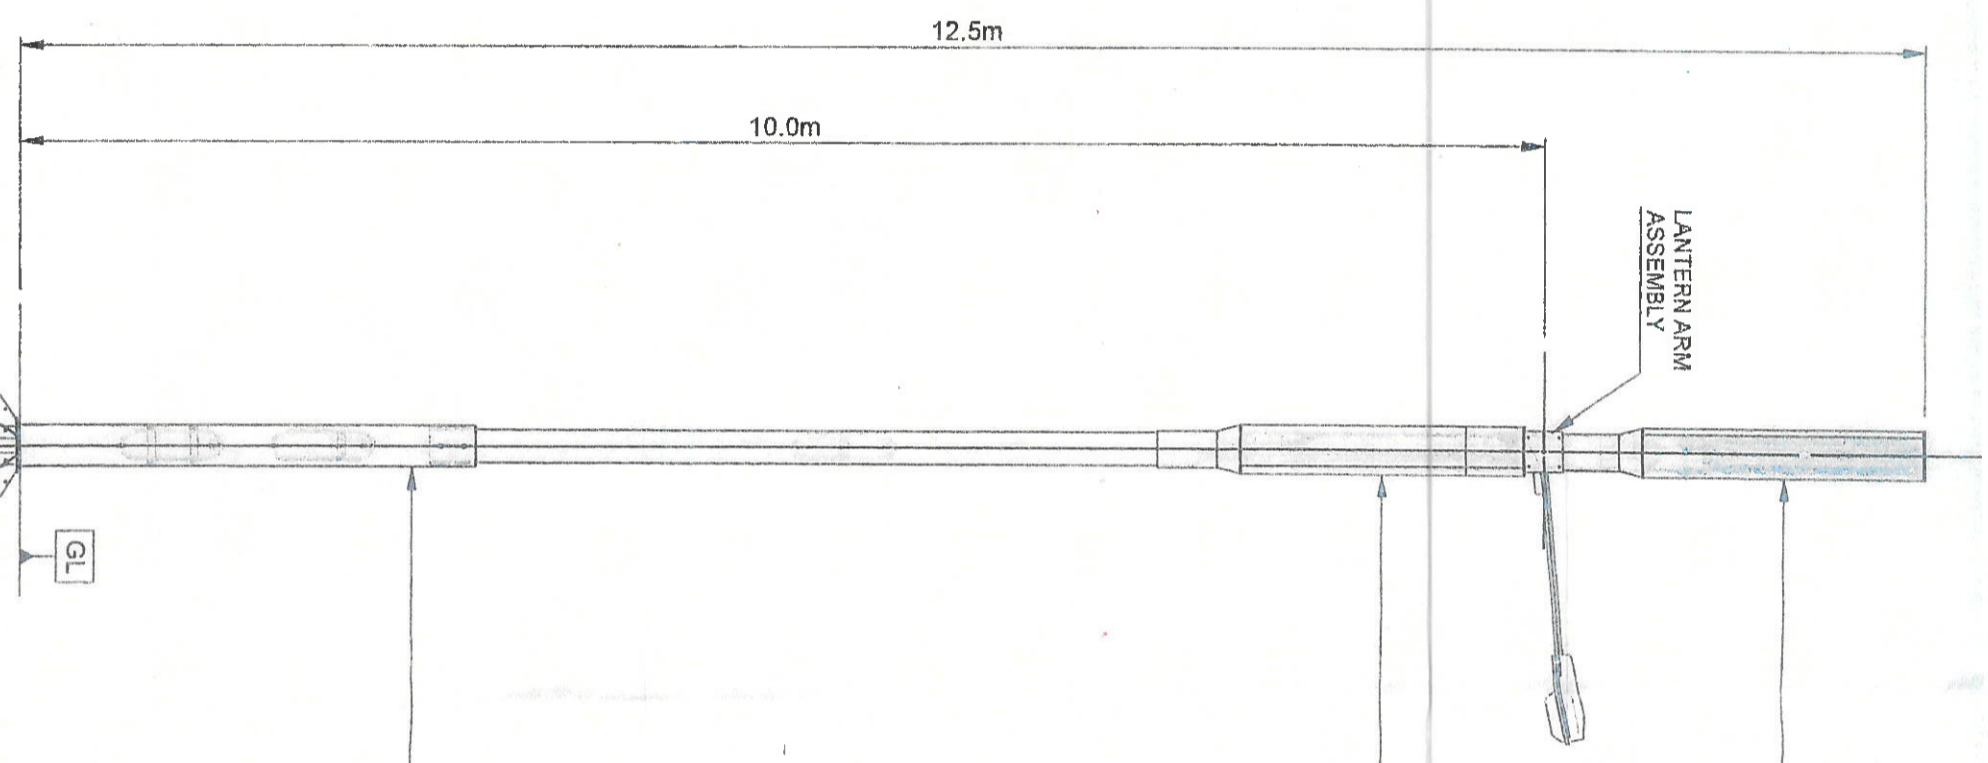

EXISTING 10.0M LAMP POST

N.B. This is not the existing lamp post. This was removed and replaced with the telecomms mast

AN BORD PLEANÁLA
 TIME _____ BY _____
 29 AUG 2018
 LTR DATER _____ FROM _____
 PL _____

Mark up of Signal Infrastructure
 Drawing issued to DLRCC

ELEVATION - SCALE 1:50 @ A3

CPR Architects		93 Upper Georges St, Dun Laoghaire, Co. Dublin Tel: 01-2711840 Email: mail@cparcitects.ie	
Job:	Section 5 Declaration - Monkstown Mast	Scale:	1:50@A3
Client:	Angela O'Flaherty	Date:	01.08.18
		Title:	MAST DETAIL
		Dwg No:	SECS-004

